



DRAWN BY: J. DAVIS
 CHECKED BY: R. DAVIS
 DATE: 6/1/92

6 1 5 1 4 1 3 1 2 1

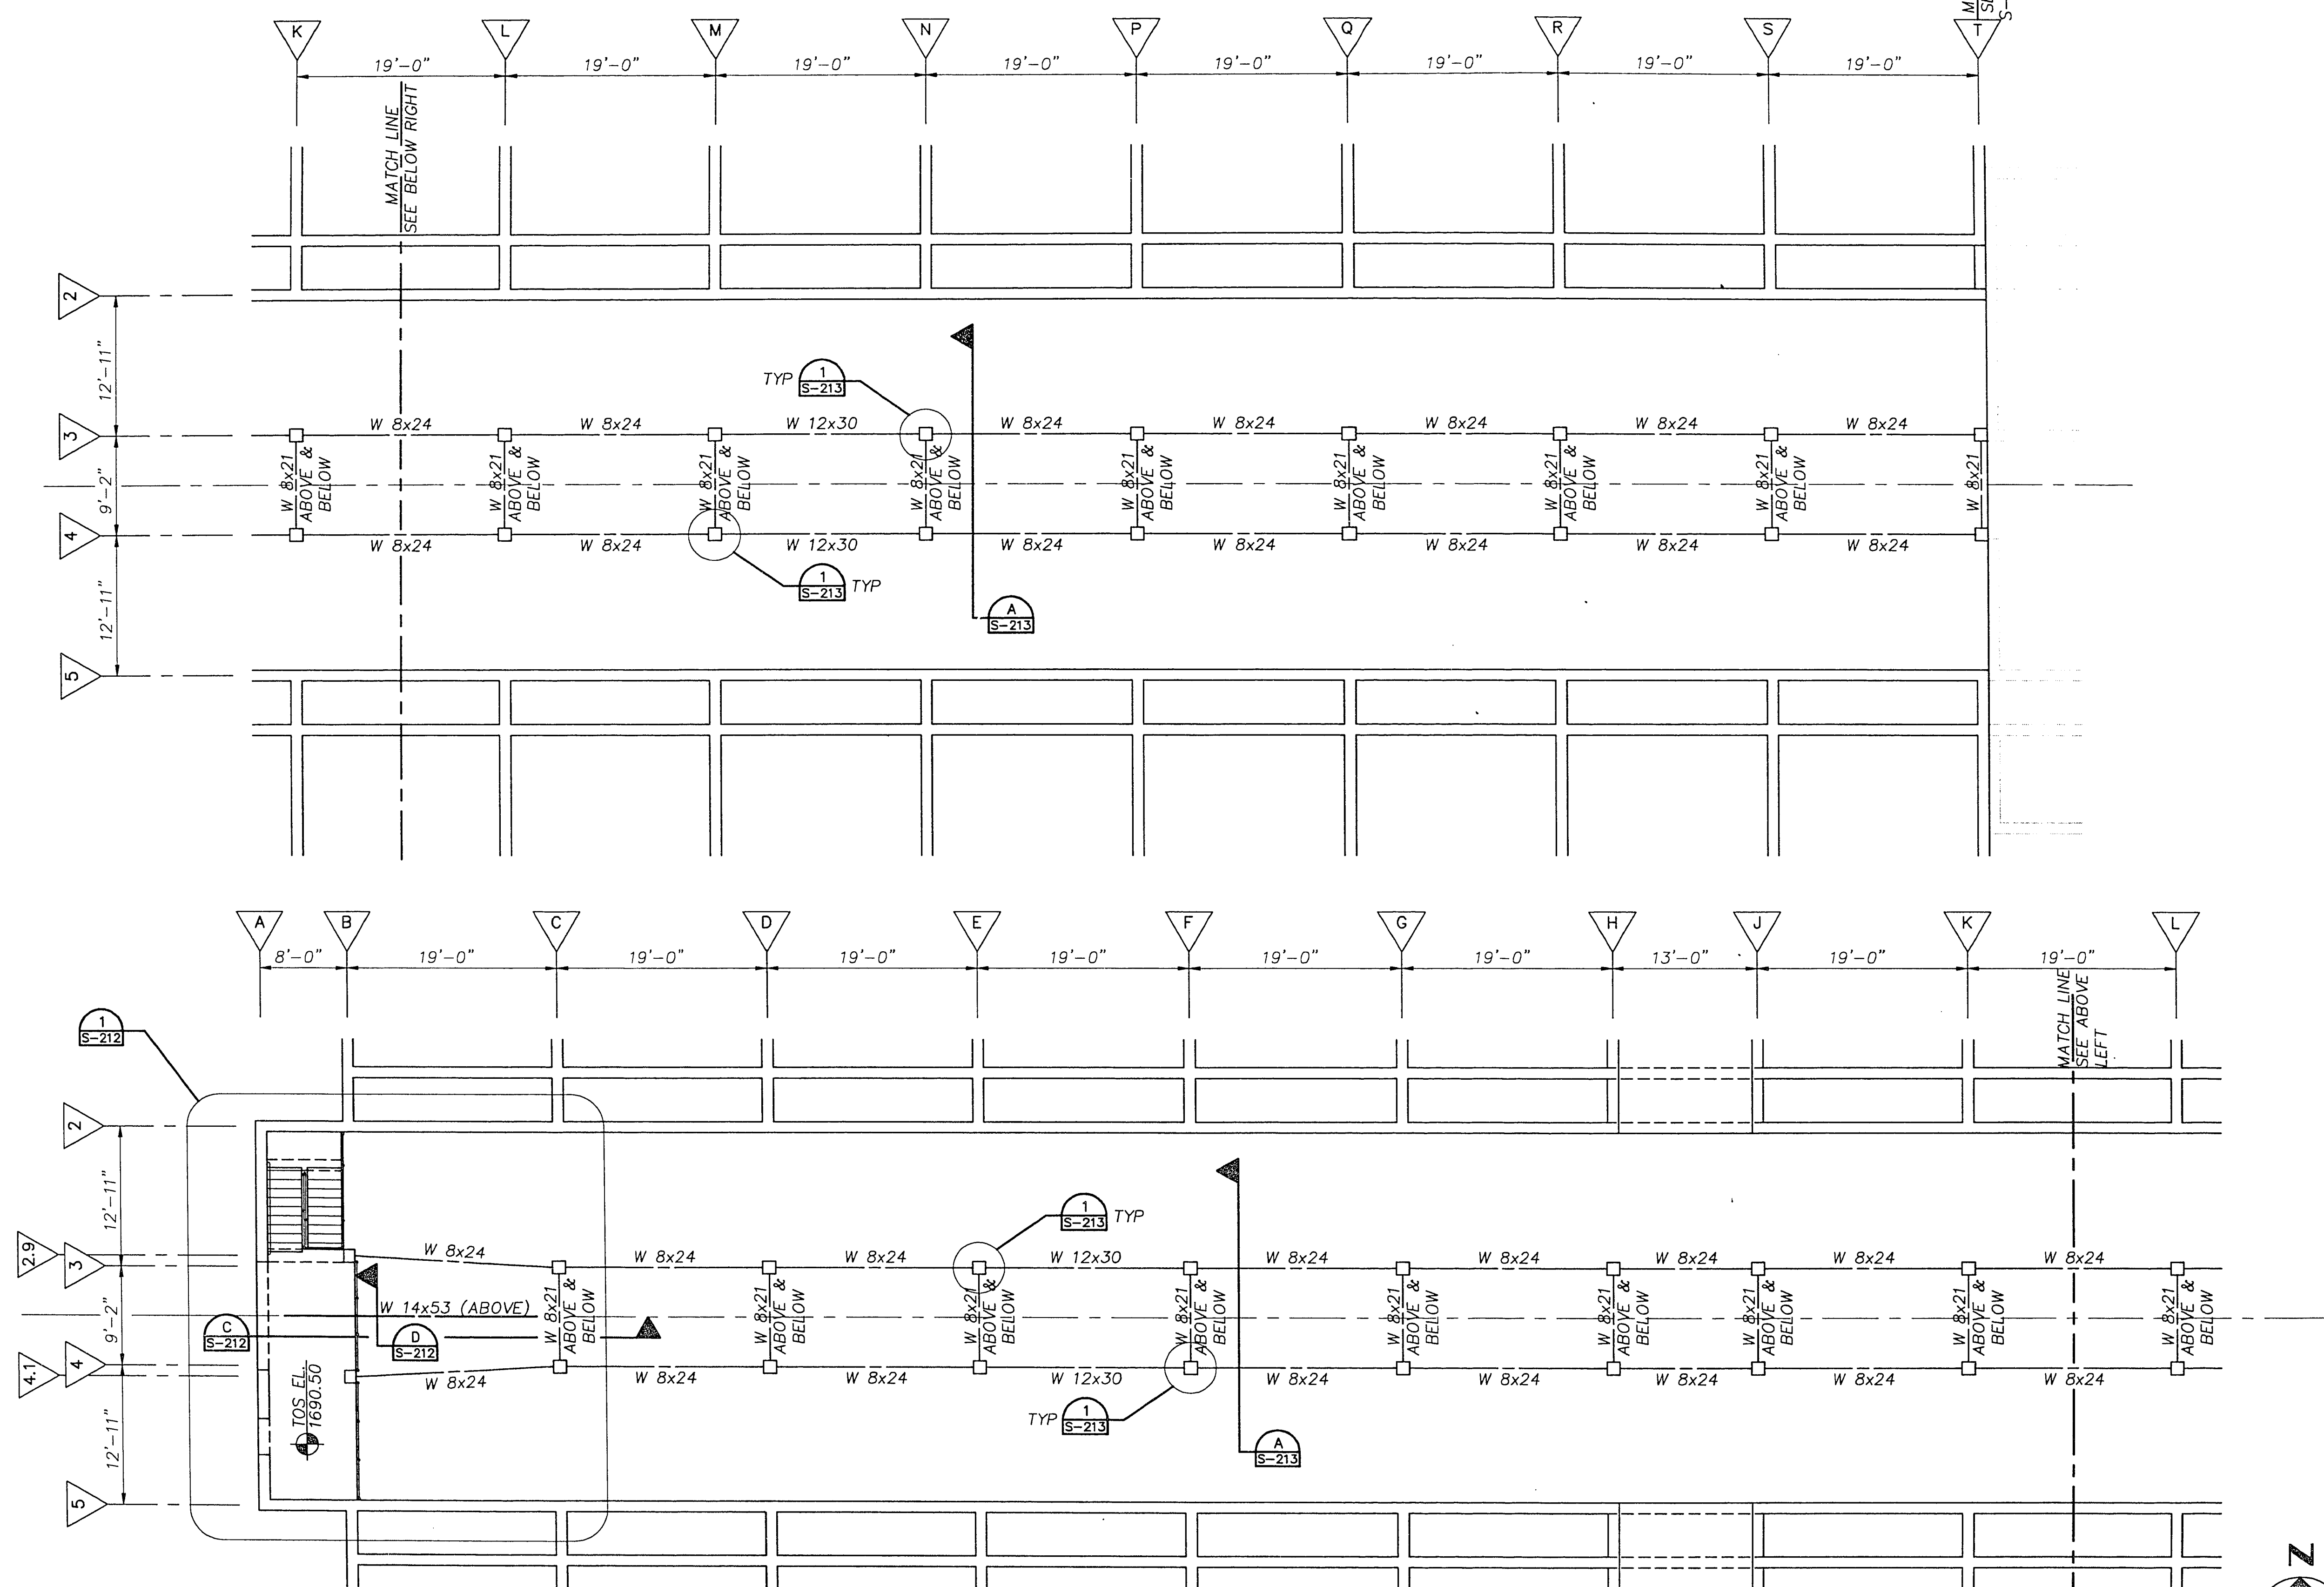


PLAN @ EL 1689.17

1/8" = 1'-0"

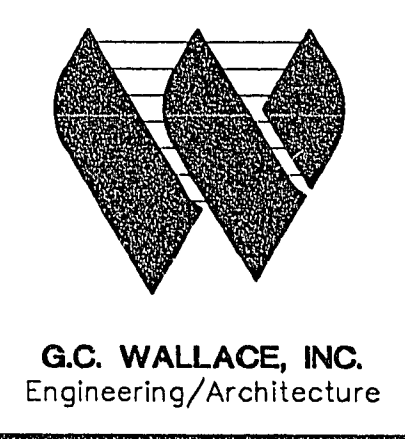

Issue No.	Description	Date	Drawn	Checked	Responsible	Project Mgr.
3	CORRECTED ACCORDING TO CONSTRUCTION RECORDS	7/1/93	LKE	EFH	ML	MJH
0	ISSUED FOR CONSTRUCTION	6/1/92	RAD	RCH	CRD	JBG
A	ISSUED FOR BIDS	1/8/92	RAD	RCH	CRD	JBG

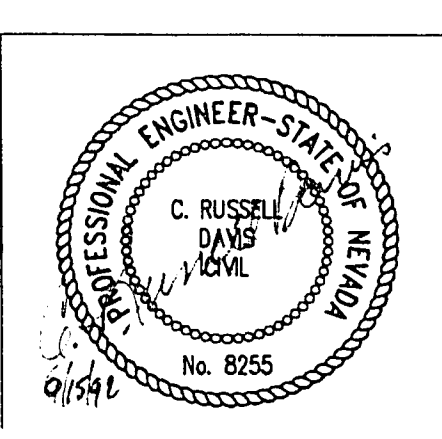

Project Manager	JEFFREY B. GLOVER
Architect	R. DAVIS
Civil	
Electrical	
Mechanical	
Structural	R. DAVIS
Drawn By	R. DOUGLAS

Water Pollution Control Facility
Nitrification / Filtration Facilities
Contract 16
EFFLUENT FILTRATION COMPLEX

CONTACT CLARIFIER / FILTER BASIN	
PIPE SUPPORT FRAMING PLAN	
Date	JUNE 1992
Scale	1/8" = 1'-0"
Project No.	00120-083-141
Drawing No.	S-211
Issue	99 of 274
3	

9-1-1-9
311.33