



**SHEET NOTES** M2.02

- ① SEE SHEET M2.01 FOR CONTINUATION.
- ② SEE SHEET M2.03 FOR CONTINUATION.
- ③ SEE SHEET M3.00 FOR CONTINUATION.
- ④ DUCT THRU WALL WITH RETURN AIR LOUVER.
- ⑤ FLEXIBLE DUCT WITH FLEXIBLE DUCT HANGING SYSTEM. HANG FROM STRUCTURE PER MANUFACTURERS INSTALLATION REQUIREMENTS.
- ⑥ 5" CHS UP THRU ROOF.
- ⑦ 5" CHR UP THRU ROOF.
- ⑧ 2-1/2" HWS/R UP THRU ROOF.
- ⑨ 4" CHS/R UP THRU ROOF.
- ⑩ 18x18 EA DUCT UP THRU ROOF.
- ⑪ 90x40 RA UP THRU ROOF. SEE B/M4.01.
- ⑫ LINE SIZE SHUT-OFF VALVES.

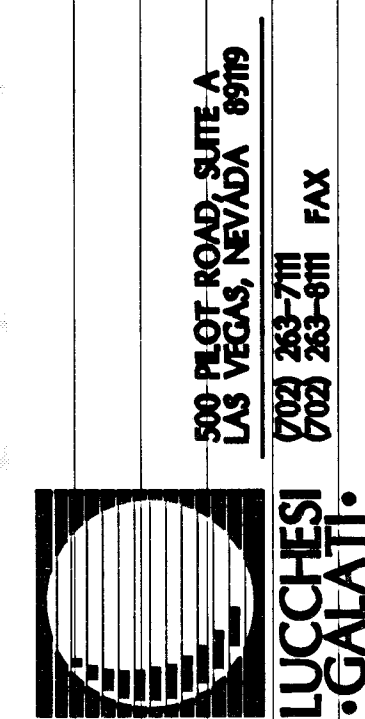

Disclaimer: These record drawings prepared by Lucchese Galati Architects, Inc. are based on information provided by others. Lucchese Galati Architects, Inc. has not verified the accuracy and/or completeness of its information supplied by others, and shall not be responsible for any errors or omissions, which may be incorporated herein as a result.

CITY OF LAS VEGAS  
CENTENNIAL HILLS COMMUNITY CENTER  
FLOOR PLAN - AREA B  
MECHANICAL

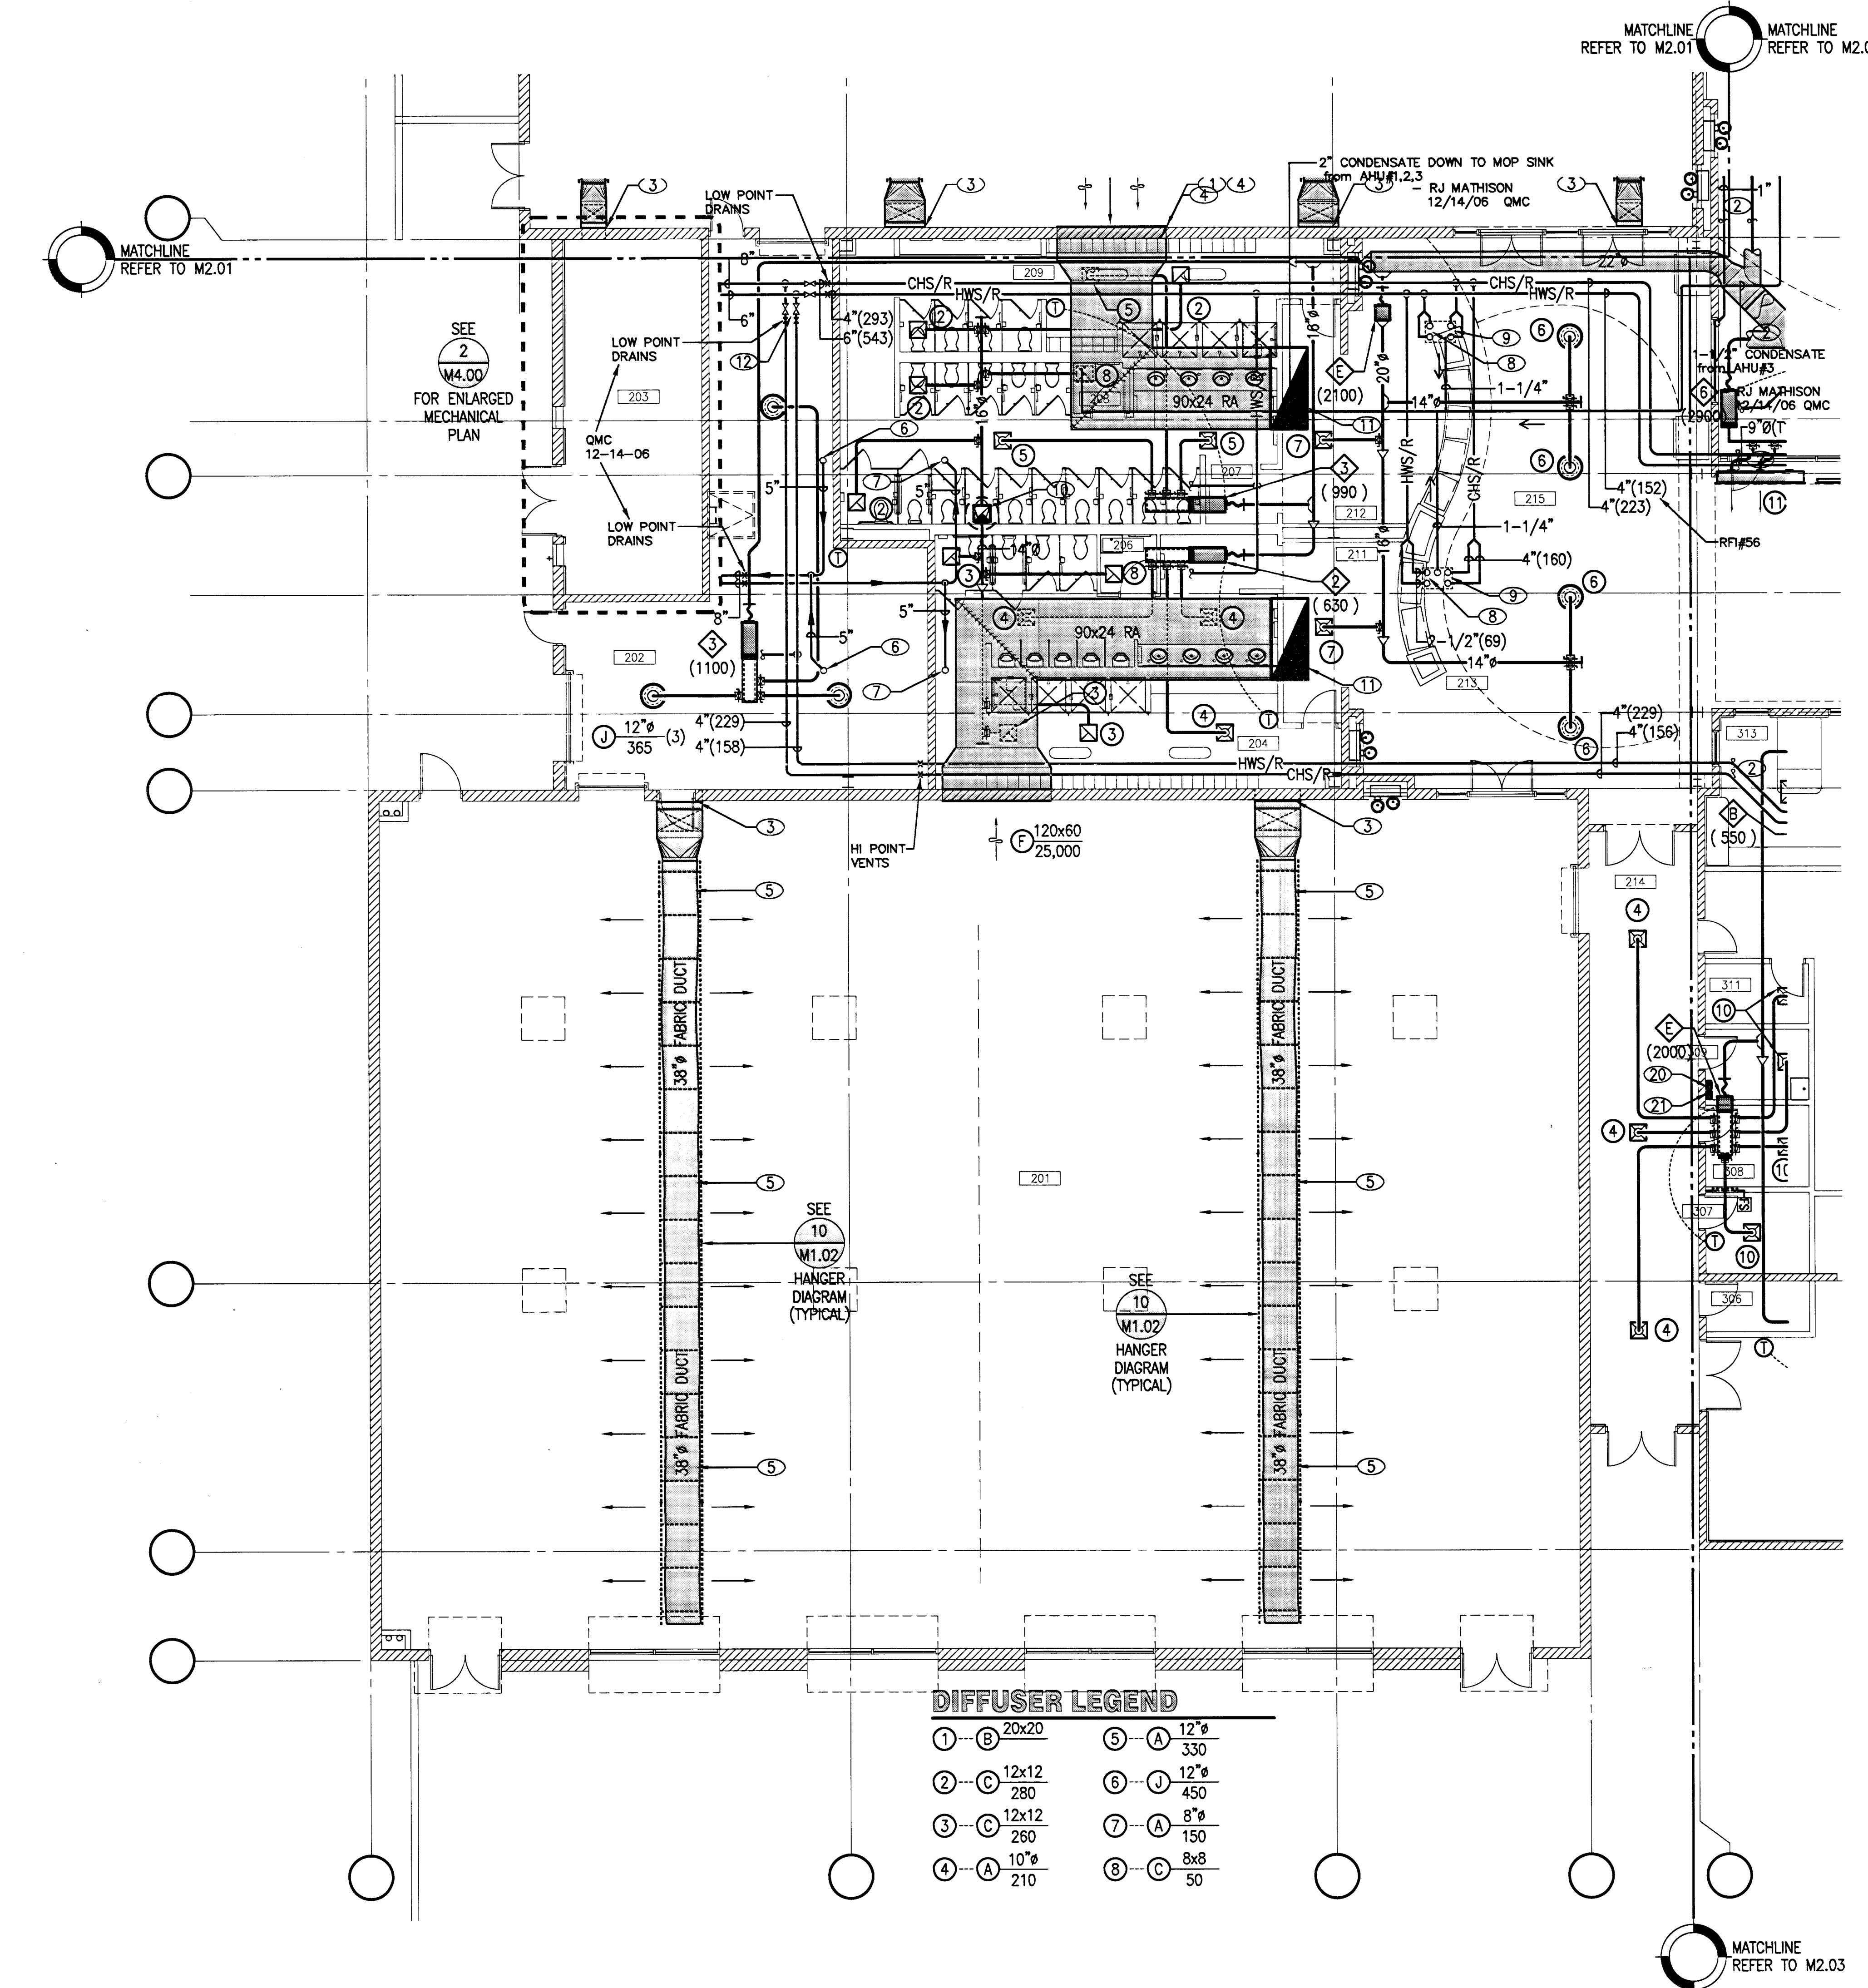


**DIFFUSER LEGEND**

① - B 20x20	⑤ - A 12" 330
② - C 12x12 280	⑥ - U 12" 450
③ - C 12x12 260	⑦ - A 8" 150
④ - A 10" 210	⑧ - C 8x8 50


**ROOM NAME SCHEDULE**

201	GYMNASIUM 2
202	GYMNASIUM STORAGE
203	MECHANICAL
204	LOCKER AREA
205	TOILET ROOM
206	JANITOR
207	TOILET ROOM
208	JANITOR
209	LOCKER AREA
211	CIRCULATION
212	CIRCULATION
213	CIRCULATION
214	CIRCULATION
215	LOBBY

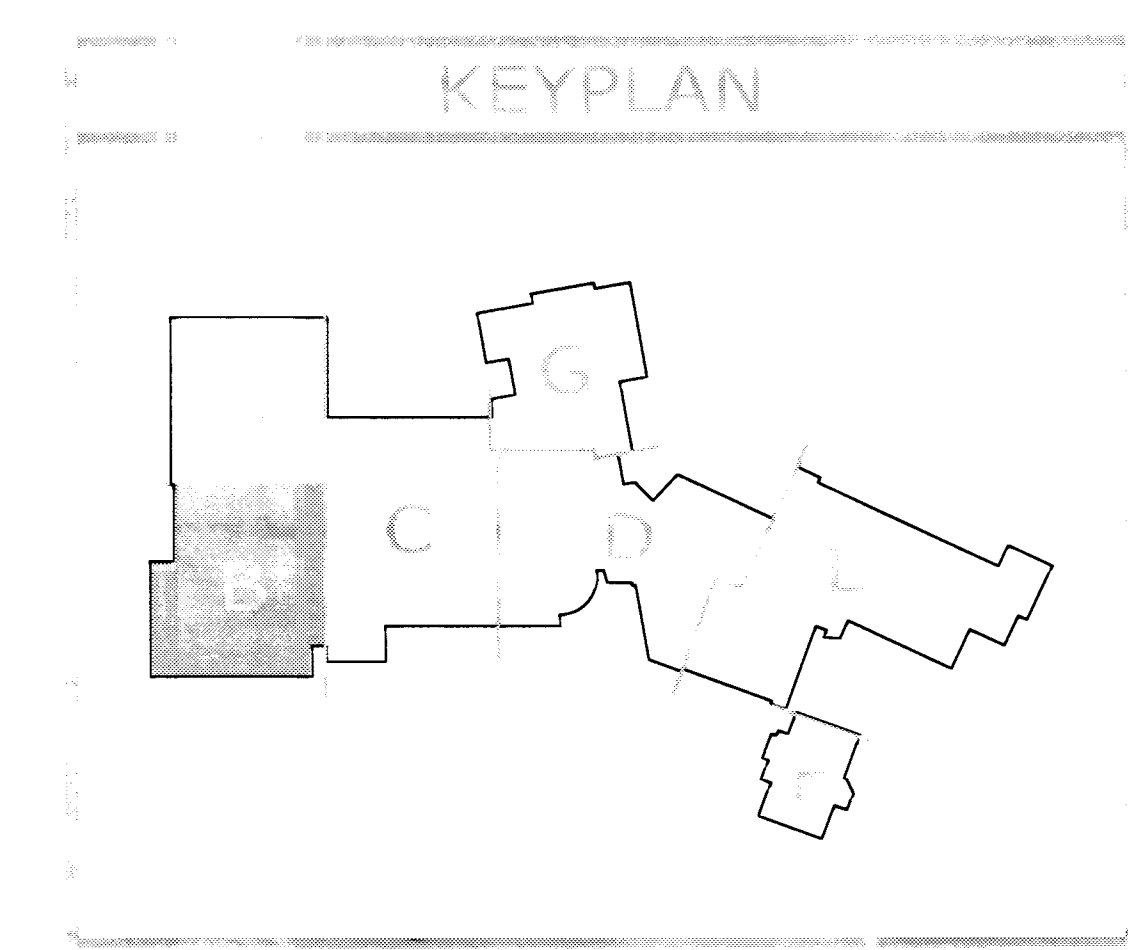

2.18 - ADD METAL LOCKING COVERS AT ALL THERMOSTATS.

**1 FLOOR PLAN - AREA B**  
M2.02 SCALE: 1/8" = 1'-0"

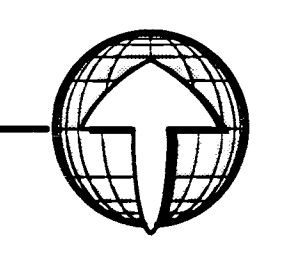

122073

05-15-05  
051534101  
6-11-49