


- ① SEE SHEET M2.05 FOR CONTINUATION.
- ② SEE SHEET M3.00 FOR CONTINUATION.
- ③ 14x14 EA UP THRU ROOF.
- ④ 8x4 COMBUSTION AIR DUCT FROM 12" ABOVE FINISHED FLOOR UP THRU ROOF TO GOOSENECK WITH BIRDSCREEN.
- ⑤ 8x4 COMBUSTION AIR DUCT FROM 12" BELOW FINISHED CEILING UP THRU ROOF TO GOOSENECK WITH BIRDSCREEN.
- ⑥ SUPPLY AIR DUCT UP THRU ROOF SAME SIZE AS UNIT OPENING.
- ⑦ RETURN AIR DUCT UP THRU ROOF SAME SIZE AS UNIT OPENING. TURN DUCT BACK TO THE VERTICAL POSITIONS WITH TWO 90° ELBOWS AND TURNING VANES. LINE DUCT WITH 1" 1-1/2# DENSITY ACOUSTIC DUCT LINER.

300 PILOT ROAD, SUITE A
LAS VEGAS, NEVADA 89166
702 733-7711
702 283-6111 FAX

LUCCHESI GABATI

Disclaimer: These record drawings prepared by Lucchese Gabati Architects, Inc. are based on information provided by others. Lucchese Gabati Architects, Inc. has not verified the accuracy and/or completeness of its information supplied by others and shall not be responsible for any errors or omissions, which may be incorporated herein as a result.

CITY OF LAS VEGAS
CENTENNIAL HILLS COMMUNITY CENTER
FLOOR PLAN - AREA F
MECHANICAL

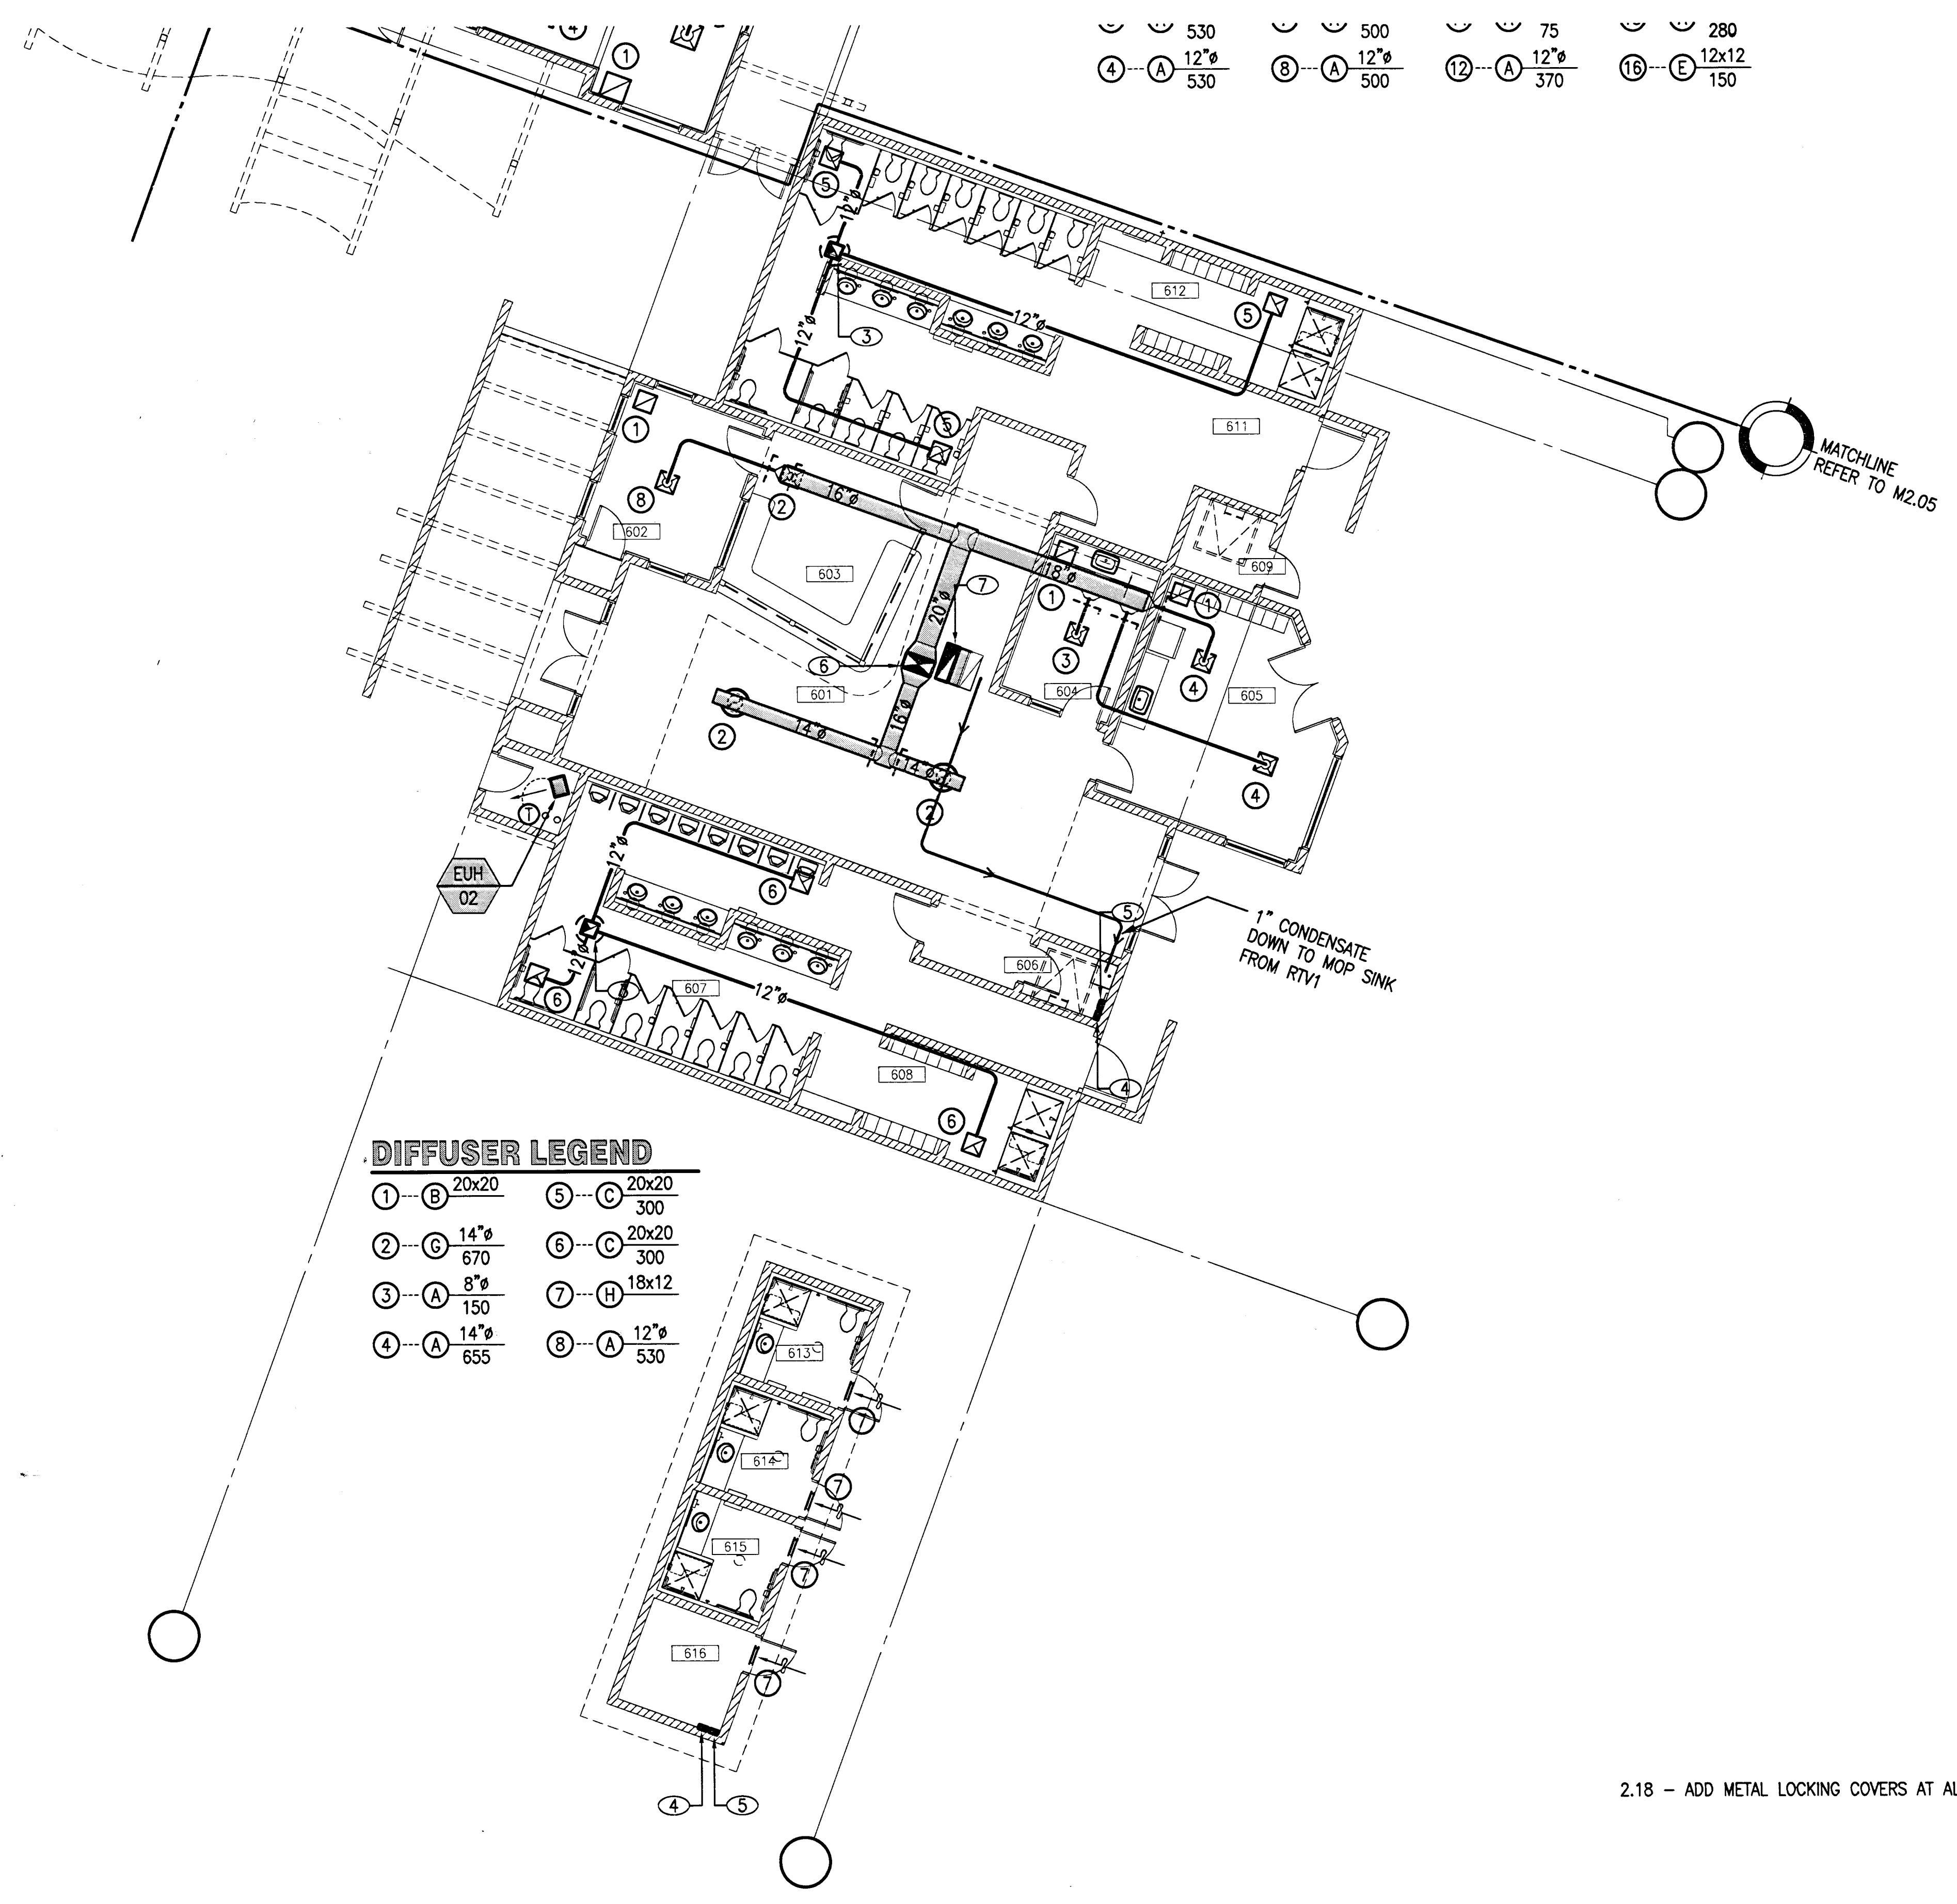

530	500	75	280
12"ø	12"ø	12"ø	12x12
530	500	370	150


DIFFUSER LEGEND

①---B	20x20	⑤---C	20x20
	300		300
②---G	14"ø	⑥---C	20x20
	670		300
③---A	8"ø	⑦---H	18x12
	150		
④---A	14"ø	⑧---A	12"ø
	655		530


ROOM NAME SCHEDULE

601	ENTRY & FEE COLLECTION
602	OFFICE
603	RECEPTION
604	FIRST AID
605	LIFEGUARD
606	JANITOR
607	TOILET ROOM
608	LOCKER AREA
609	JANITOR
611	TOILET ROOM
612	LOCKER AREA
613	TOILET ROOM
614	TOILET ROOM
615	TOILET ROOM
616	TOILET ROOM

2.18 - ADD METAL LOCKING COVERS AT ALL THERMOSTATS.

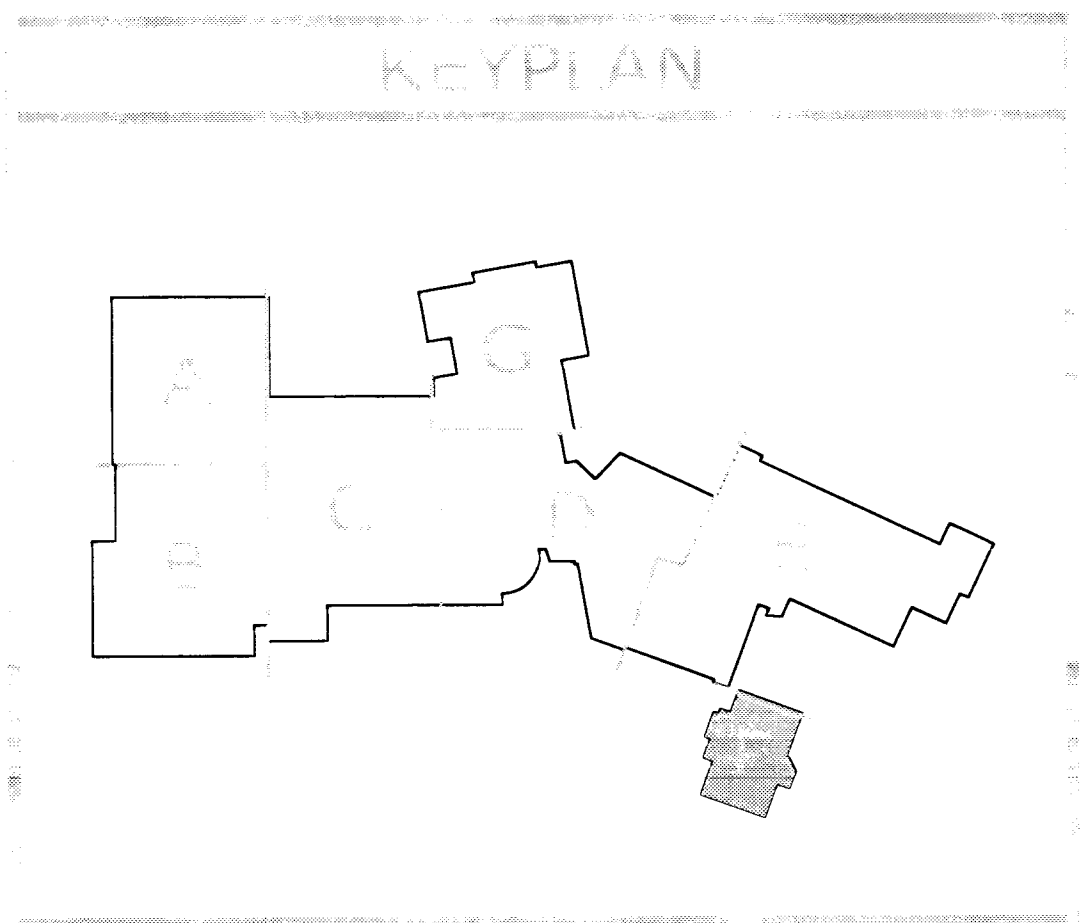

FLOOR PLAN - AREA F
SCALE: 1/8" = 1'-0"

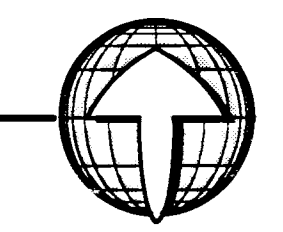

STAMP

05-18-05
0515341.01
6/11/09

127092