



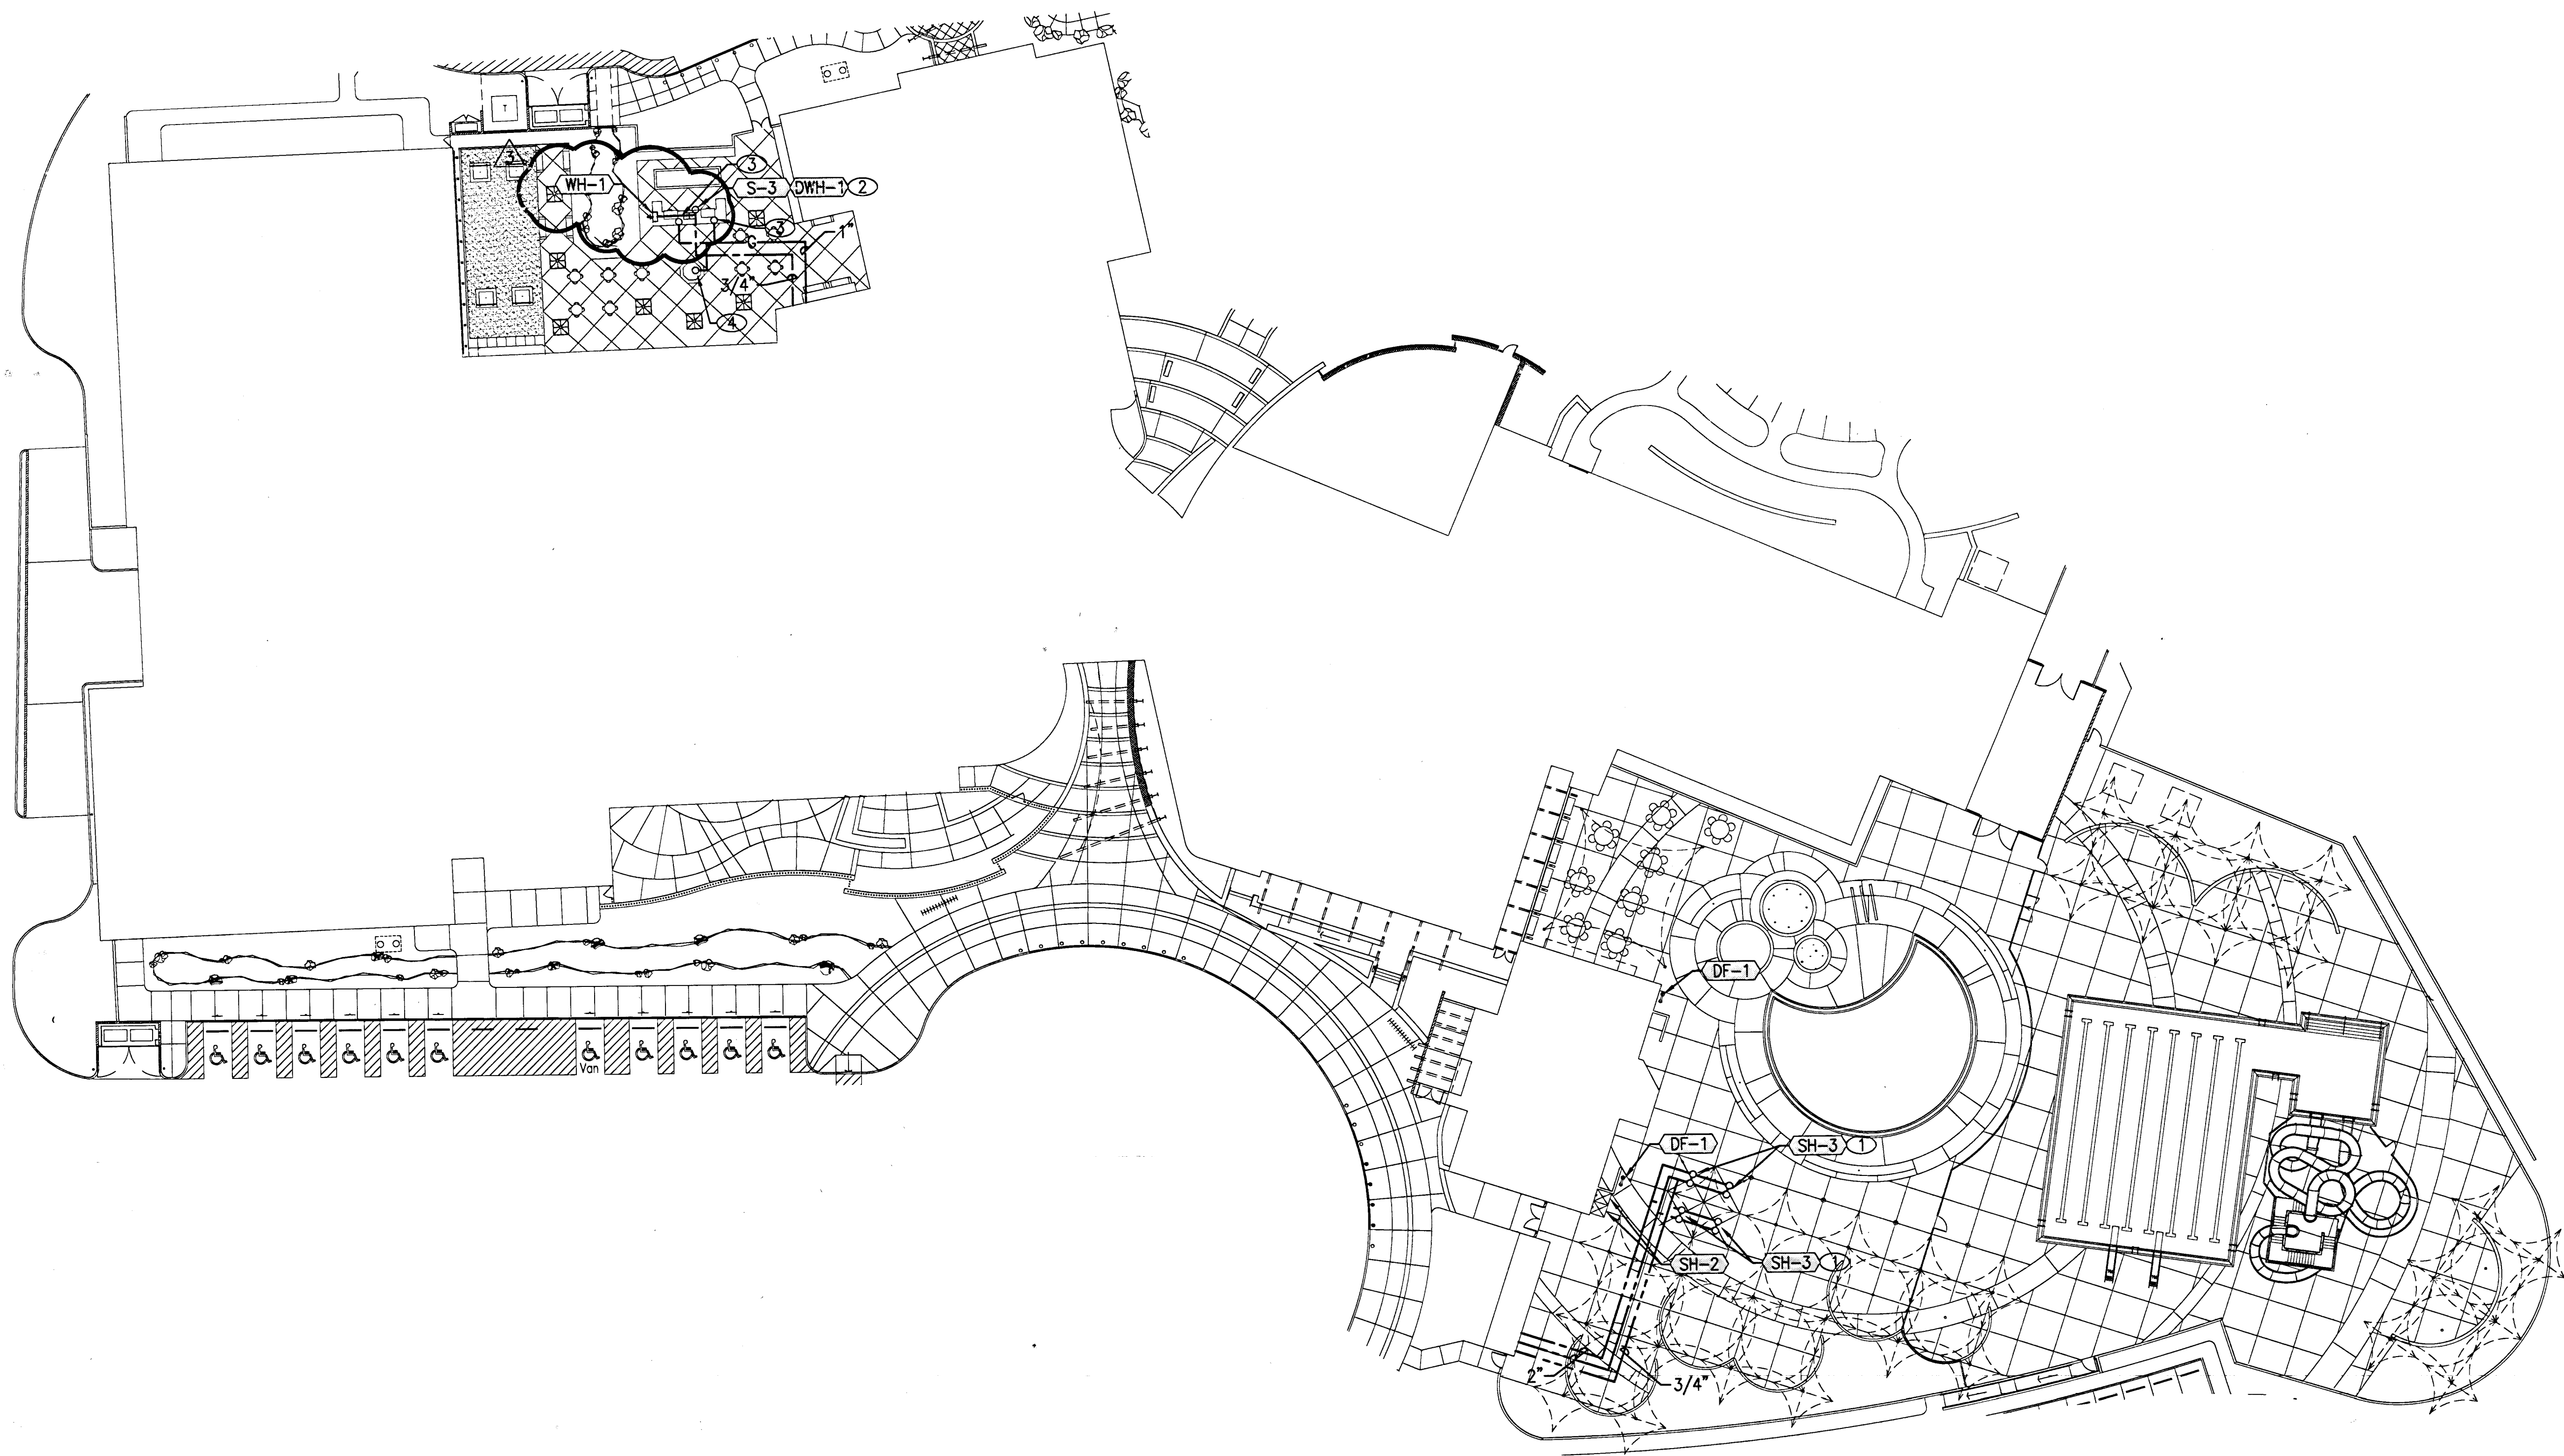


3 PLUMBING SITE PLAN
P1.02 SCALE: 1" = 30'-0"

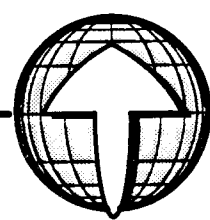

SHEET NOTES

- ① 1-1/4" CW/HW UP TO SERVE SHOWER.
- ② 3/4" CW UP TO SERVE SINK.
- ③ 1/2" G UP TO SERVE BARBECUE. PROVIDE GAS PIPING WITH LINE SIZE GAS COCK, UNIONS AND PRESSURE REGULATOR. SET PRV FROM 5 PSI TO 7" W.C. VENT PRV TO ATMOSPHERE.
- ④ 1/2" G UP TO SERVE FIREPIT. PROVIDE GAS PIPING WITH LINE SIZE GAS COCK, UNIONS AND PRESSURE REGULATOR. SET PRV FROM 5 PSI TO 7" W.C. VENT PRV TO ATMOSPHERE.

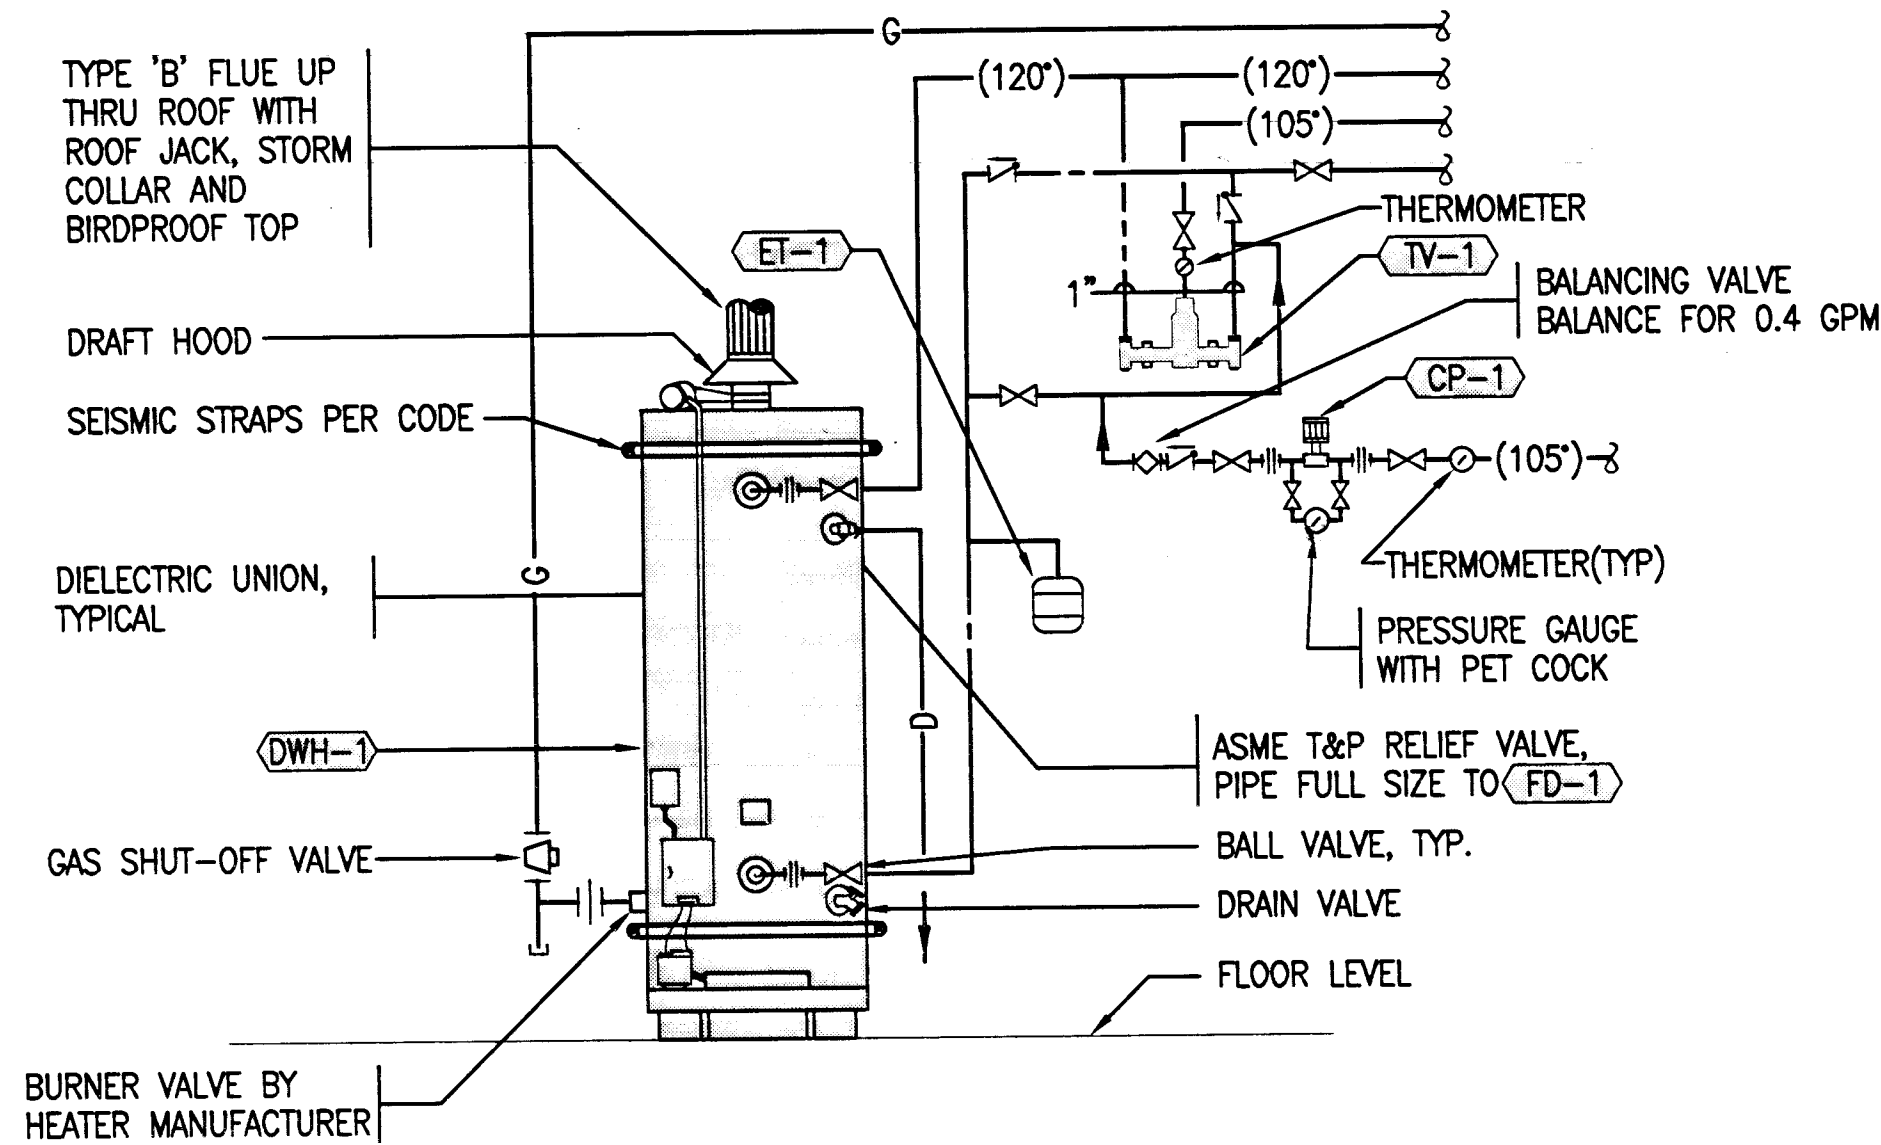


NOTE: REFERENCE PLAN FOR PIPE SIZES

1 GAS FIRE DOMESTIC WATER HEATER DIAGRAM
P1.02 SCALE: NTS

GREASE INTERCEPTOR KEY NOTES

- ① 4" COTG SET IN 18x18x4" DEEP CONCRETE PAD.
- ② FINISHED GRADE. PLANTING AREA, IN LANDSCAPING.
- ③ 3" VENT. ROUTE TO NEAREST WALL THEN UP. (SEE PLANS)
- ④ RISERS AS REQUIRED.
- ⑤ 24" CAST IRON FRAME AND COVER WITH GASTIGHT GASKET.
- ⑥ CAST IRON PIPE & FITTINGS.
- ⑦ PRE-CAST CONCRETE INTERCEPTOR.
- ⑧ SEE PLANS FOR CONTINUATION.

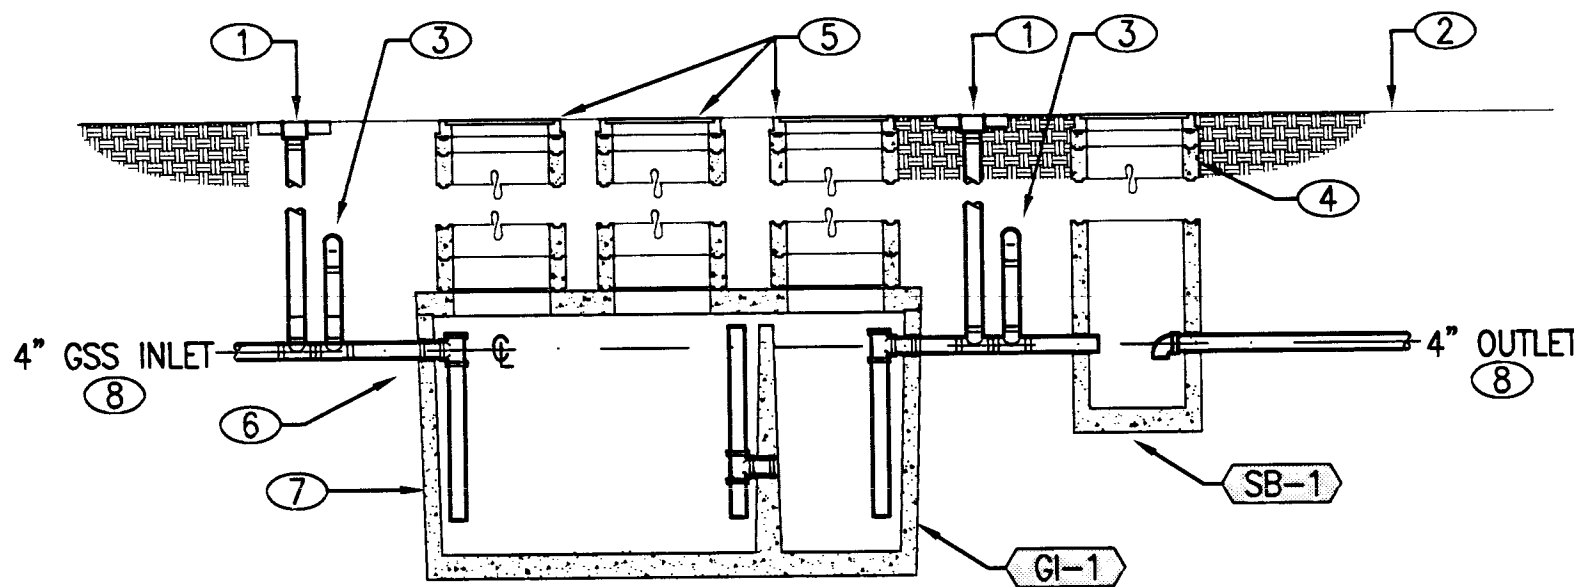

LIQUID CAPACITY: 1000 GALLONS
DESIGN LOAD: H-20 (FULL TRAFFIC)

2 GREASE INTERCEPTOR & SAMPLE BOX
P1.02 SCALE: NTS