



**SHEET NOTES**

- ① DROP 4" SD/OSD FROM ROOF DRAINAGE AND ROUTE BELOW ROOF STRUCTURE.
- ② DROP 1/2" CW IN WALL. RISE 2" V UP AND DROP 2" SS TO ROUTE BELOW FLOOR.
- ③ DROP 3/4" CW ALONG WALL.
- ④ DROP 6" SD/OSD TO TERMINATE OUT OF WALL @ 6" ABOVE FINISH GRADE.

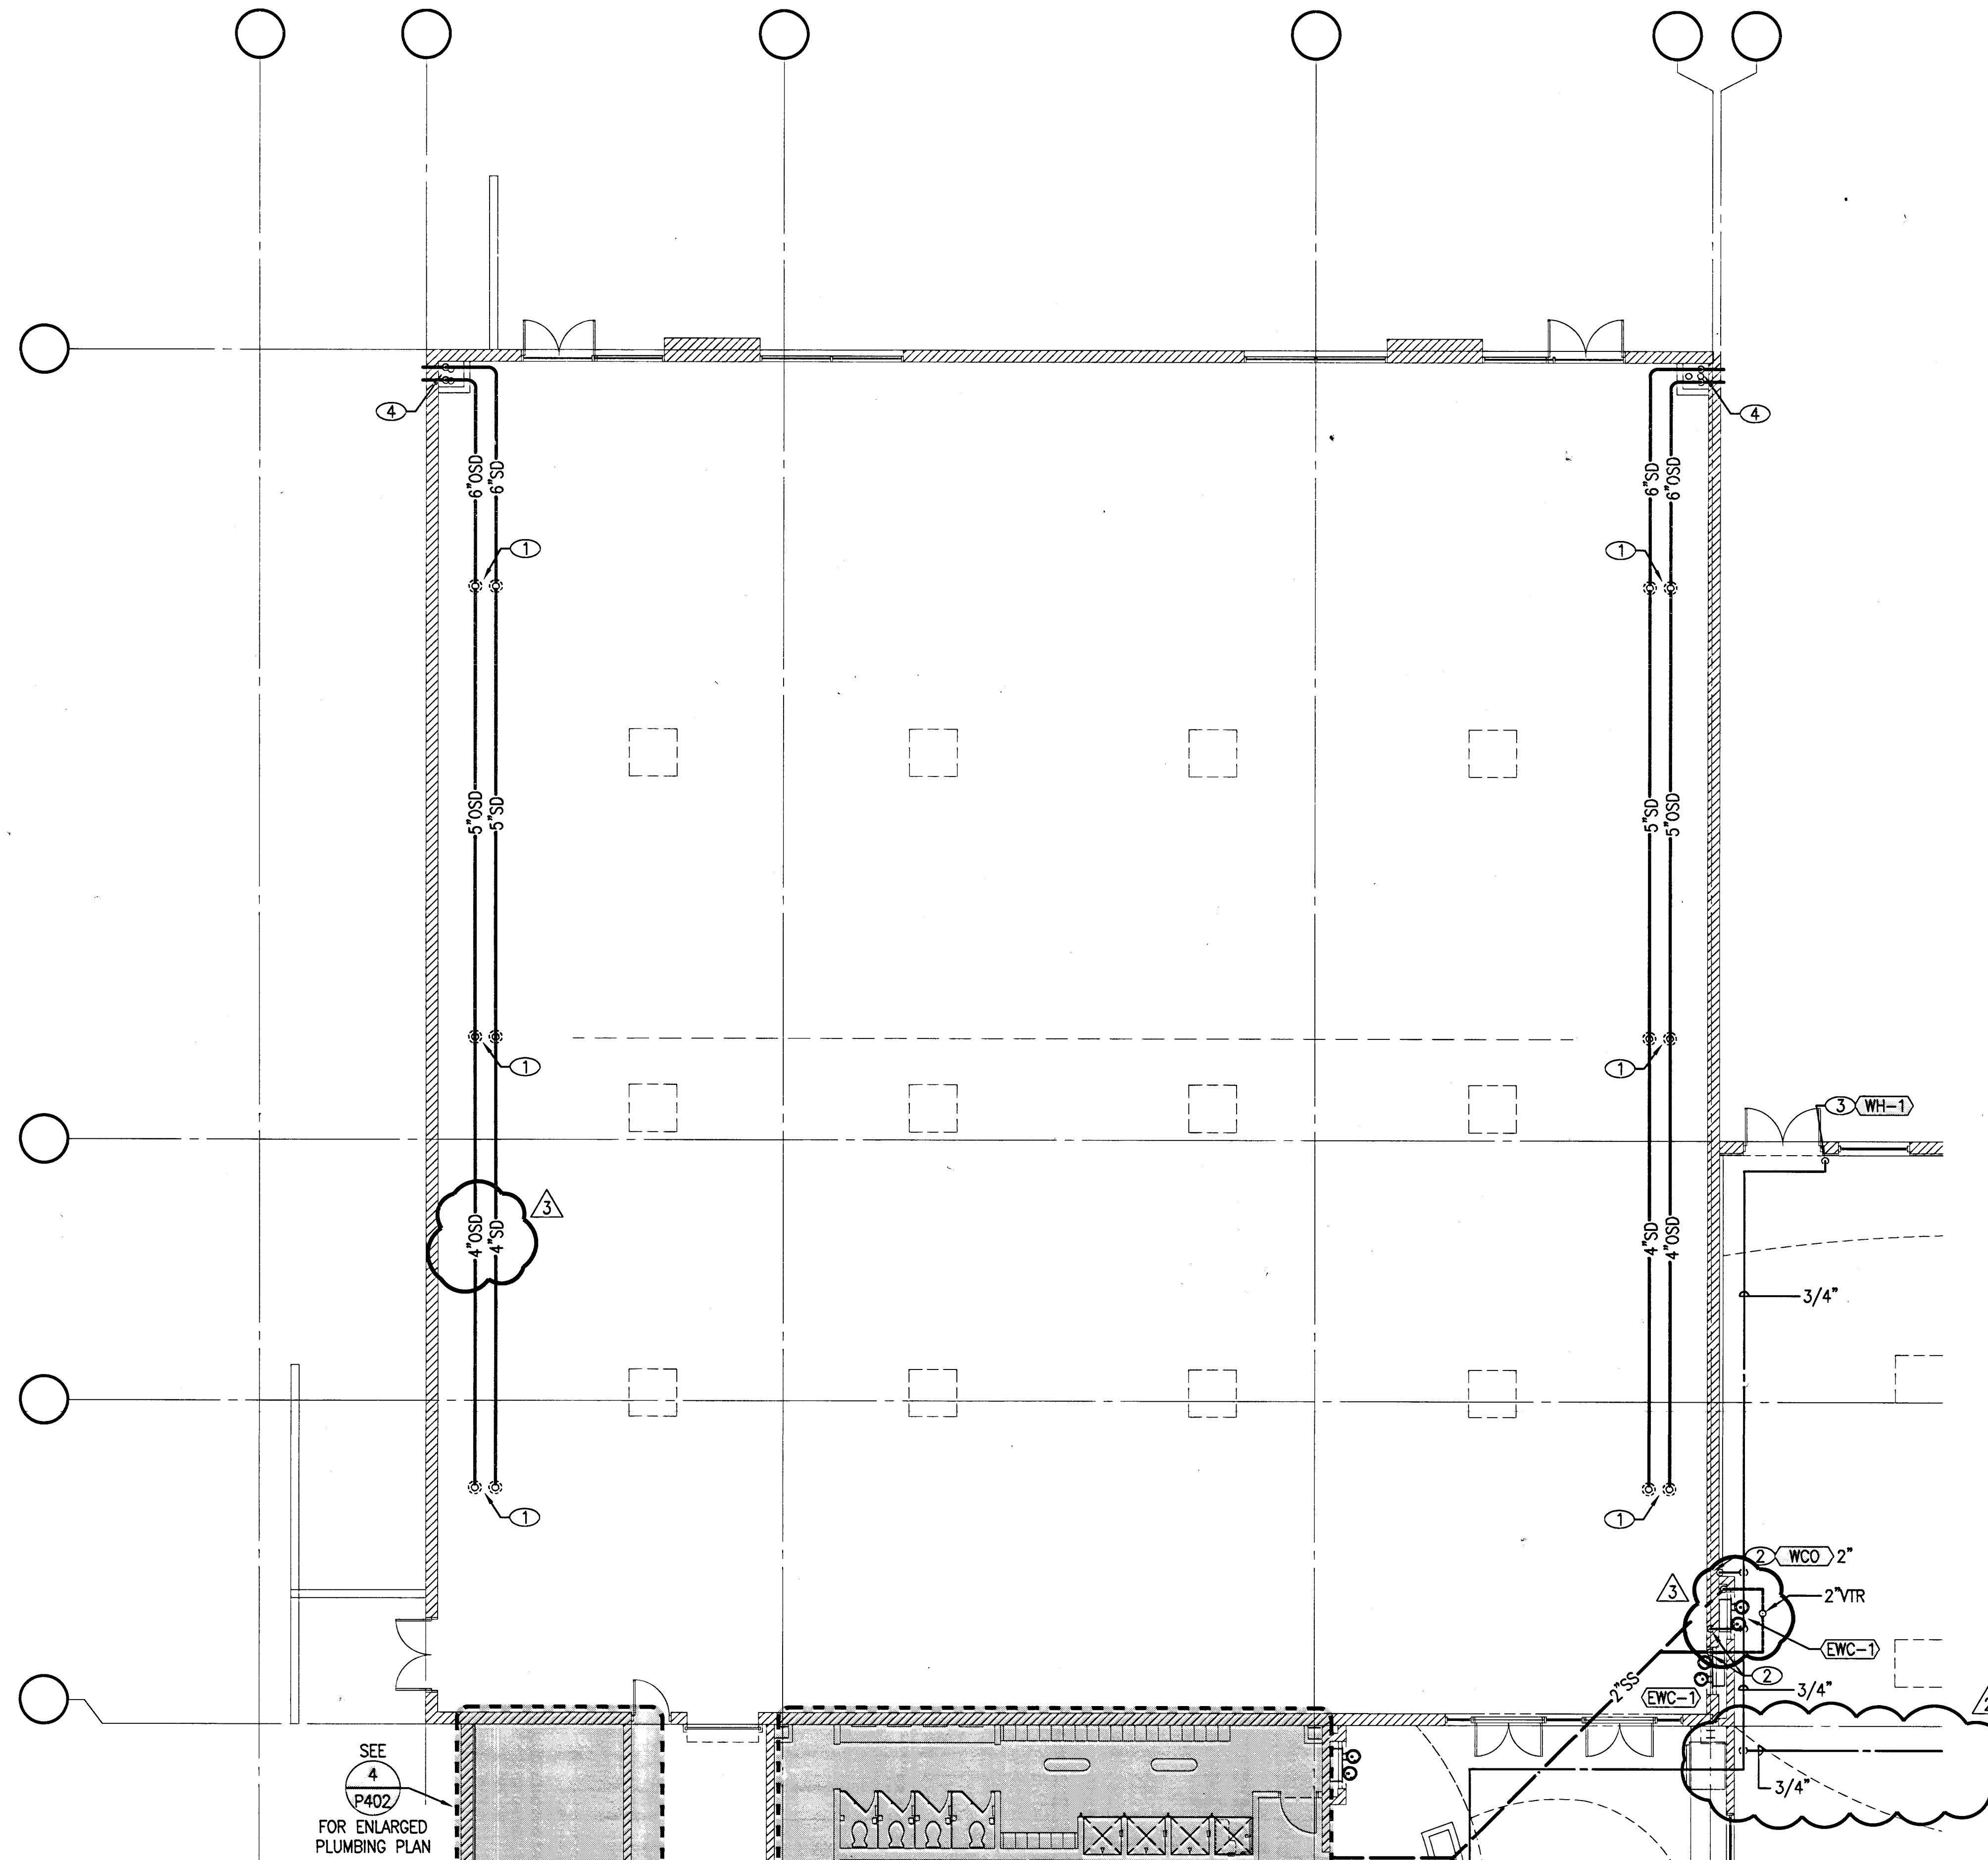

PLUMBING PIPING SHALL NOT BE RUN IN CMU BLOCK. ROUTE PIPING EITHER IN FURRED OUT OR STUD WALLS.

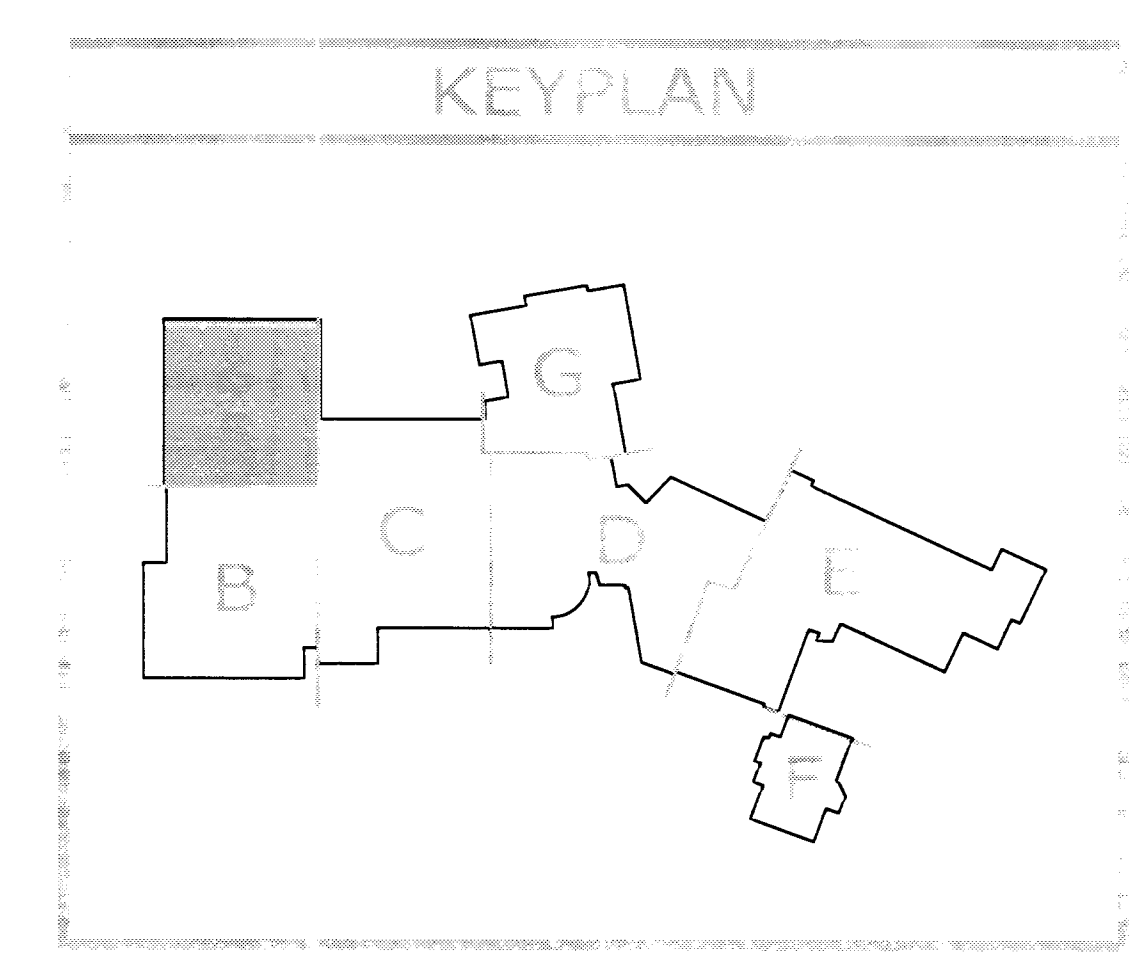

**1 FLOOR PLAN - AREA A**  
 P2.01 SCALE: 1/8" = 1'-0"

RECORD DRAWING 10/25/07

DR. PLOT ROAD, SUITE A  
 LAS VEGAS, NEVADA 89169  
 (702) 363-7711 FAX

**LUCCESE GALATI**

Disclaimer: These record drawings prepared by Luccece Galati Architects, Inc., are based on information provided by others. Luccece Galati Architects, Inc. has not verified the accuracy and/or completeness of the information supplied by others, and shall not be responsible for any errors or omissions, which may be incorporated herein as a result.

CITY OF LAS VEGAS  
 CENTENNIAL HILLS COMMUNITY CENTER  
 FLOOR PLAN - AREA A

DATE	03-08-06
BY	1-0
NO.	051534101
	671-43

127371

024 P2.01.TIF