



SHEET NOTES

- ① DROP 4" SD/OSD FROM ROOF DRAINAGE AND ROUTE BELOW ROOF STRUCTURE.
- ② REFER TO CIVIL UTILITY DRAWINGS FOR CONTINUATION.
- ③ DROP 5" SD/OSD TO TERMINATE OUT OF WALL @6" ABOVE FINISH GRADE.
- ④ DROP 6" SD/OSD FROM ROOF DRAINAGE AND ROUTE DOWN ALONG WALL TO TERMINATE OUT OF STRUCTURE @6" ABOVE FINISH GRADE.
- ⑤ LOCATE GREASE TRAP AWAY FROM STRUCTURE @ A MIN OF 10'-0".

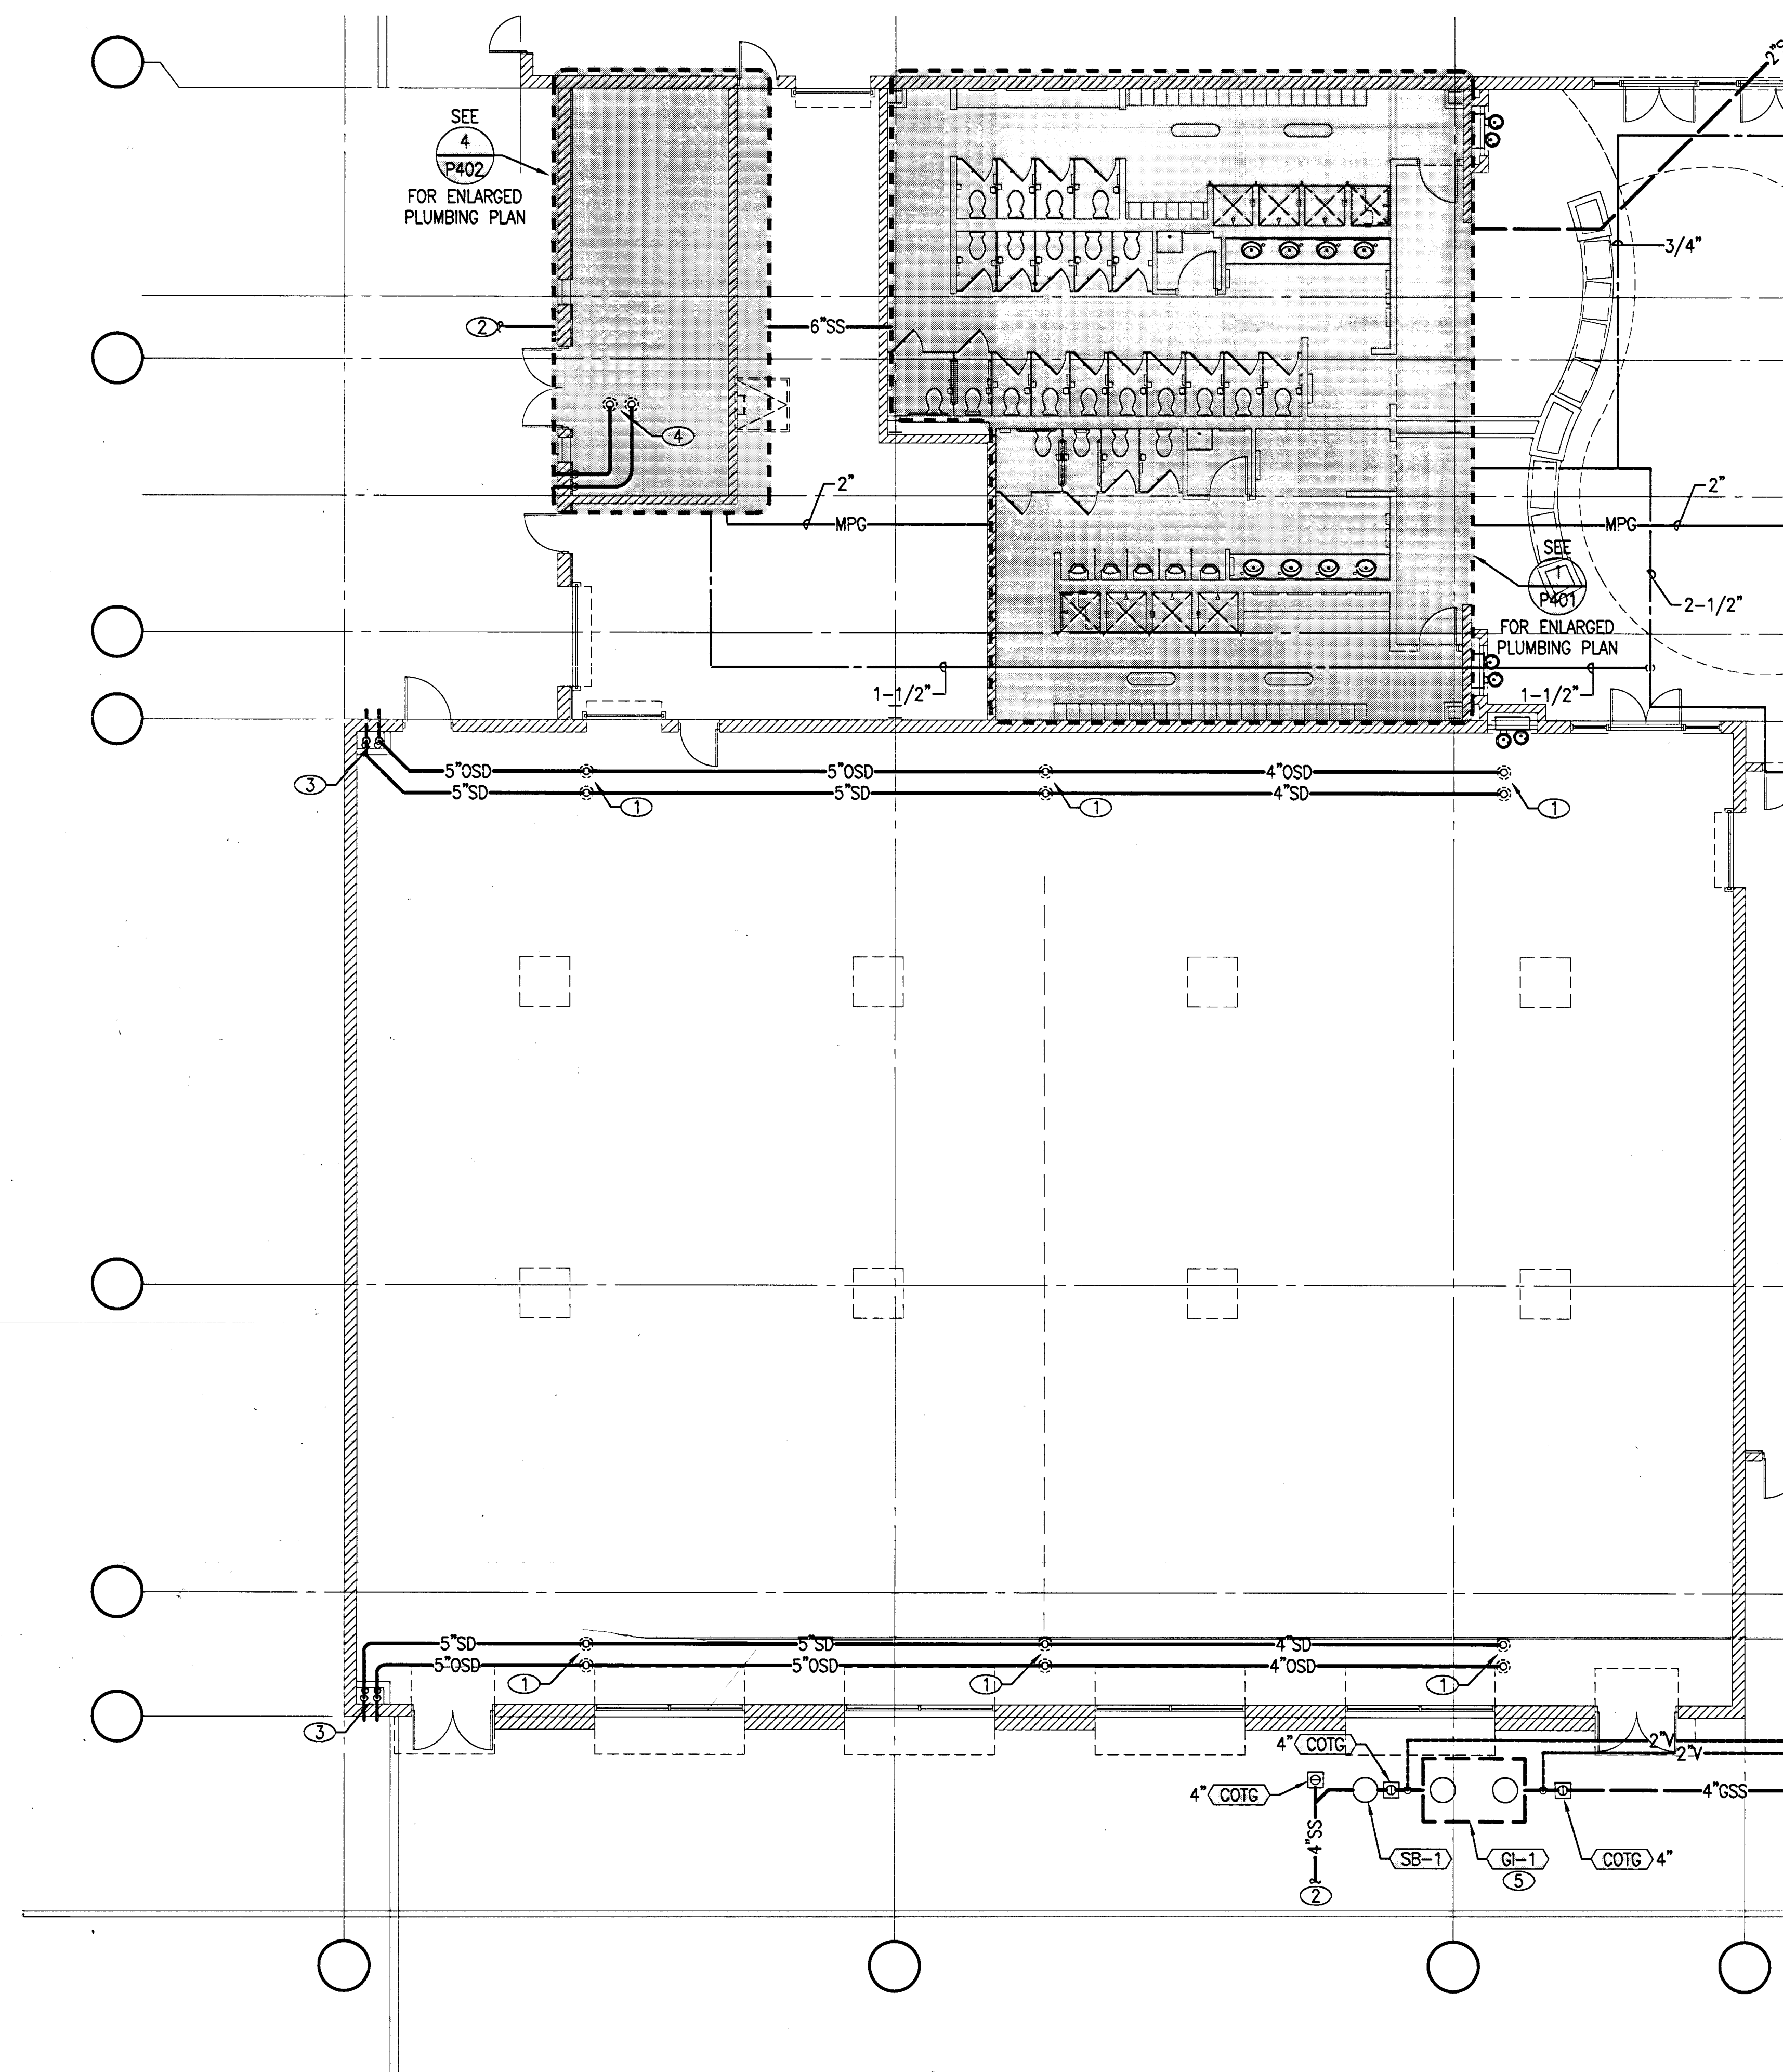

PLUMBING PIPING SHALL NOT BE RUN IN
CMU BLOCK. ROUTE PIPING EITHER IN
FURRED OUT OR STUD WALLS.

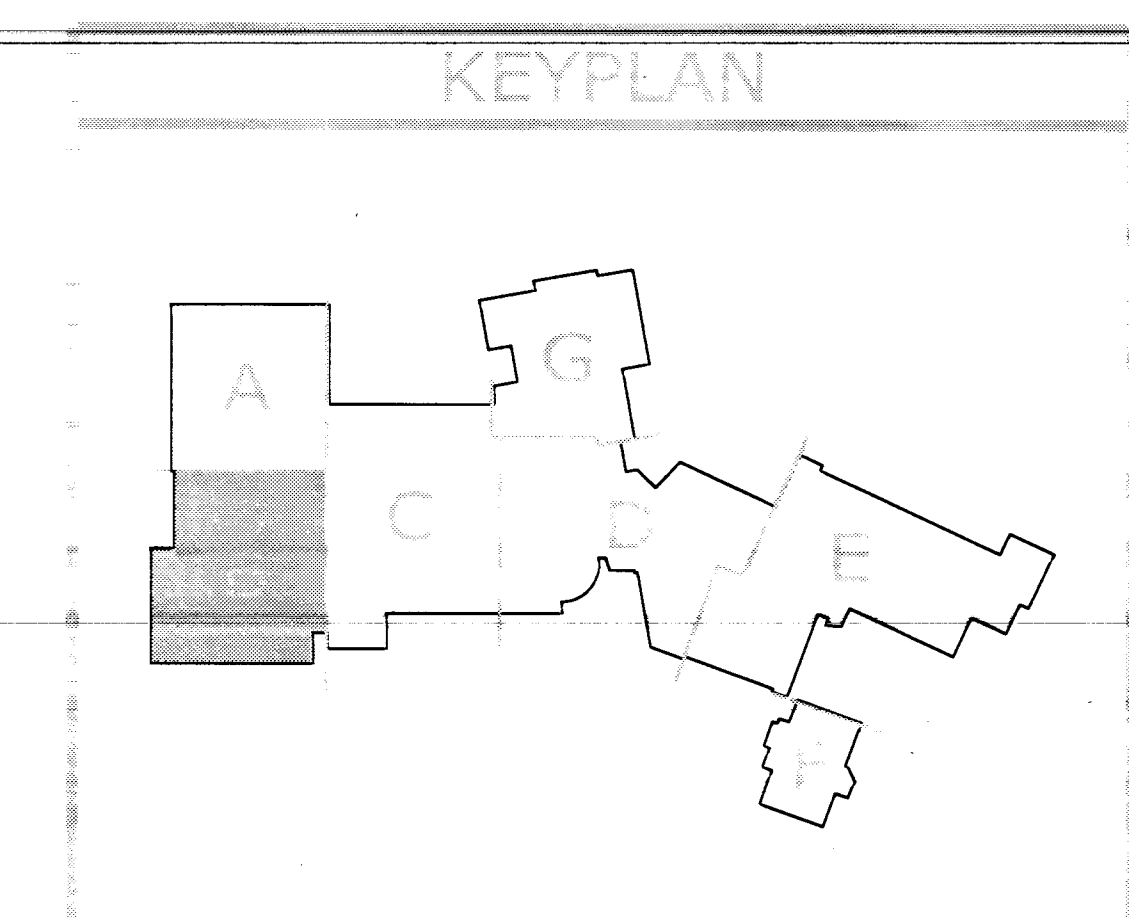

FLOOR PLAN - AREA B
SCALE: 1/8" = 1'-0"

