



**SHEET NOTES**

- ① DROP 4" SD/OSD TO TERMINATE OUT OF WALL @ 6" ABOVE FINISH GRADE.
- ② DROP 1/2" CW IN WALL. TEE 1/2" CW IN WALL TO HEATER. ROUTE 1/2" HW FROM HEATER TO SINK. RISE 2" V UP AND DROP 2" GSS TO ROUTE BELOW FLOOR.
- ③ 3" SD/OSD DOWN FROM ROOF DRAINAGE AND ROUTED BELOW ROOF STRUCTURE.
- ④ DROP 3/4" CW ALONG WALL.
- ⑤ DROP 1/2" CW IN WALL. RISE 2" V UP AND DROP 2" SS TO ROUTE BELOW FLOOR.
- ⑥ DROP 6" SD/OSD TO TERMINATE OUT OF WALL @ 6" ABOVE FINISH GRADE.
- ⑦ RISE 2" V UP FROM BELOW GRADE ALONG WALL TO CEILING.
- ⑧ DROP 1/2" CW/HW IN WALL. RISE 2" V UP AND DROP 2" SS TO ROUTE BELOW FLOOR.
- ⑨ 5" SD/OSD DOWN FROM ROOF DRAINAGE AND ROUTED BELOW ROOF STRUCTURE.
- ⑩ 4" SD/OSD DOWN FROM ROOF DRAINAGE AND ROUTED BELOW ROOF STRUCTURE.
- ⑪ DROP 1/2" CW IN WALL WITH ANGLE STOP IN WALL BOX.
- ⑫ REFER TO CIVIL UTILITY DRAWINGS FOR CONTINUATION.
- ⑬ 3/4" CW TO SERVE WH-3 ON ROOF.

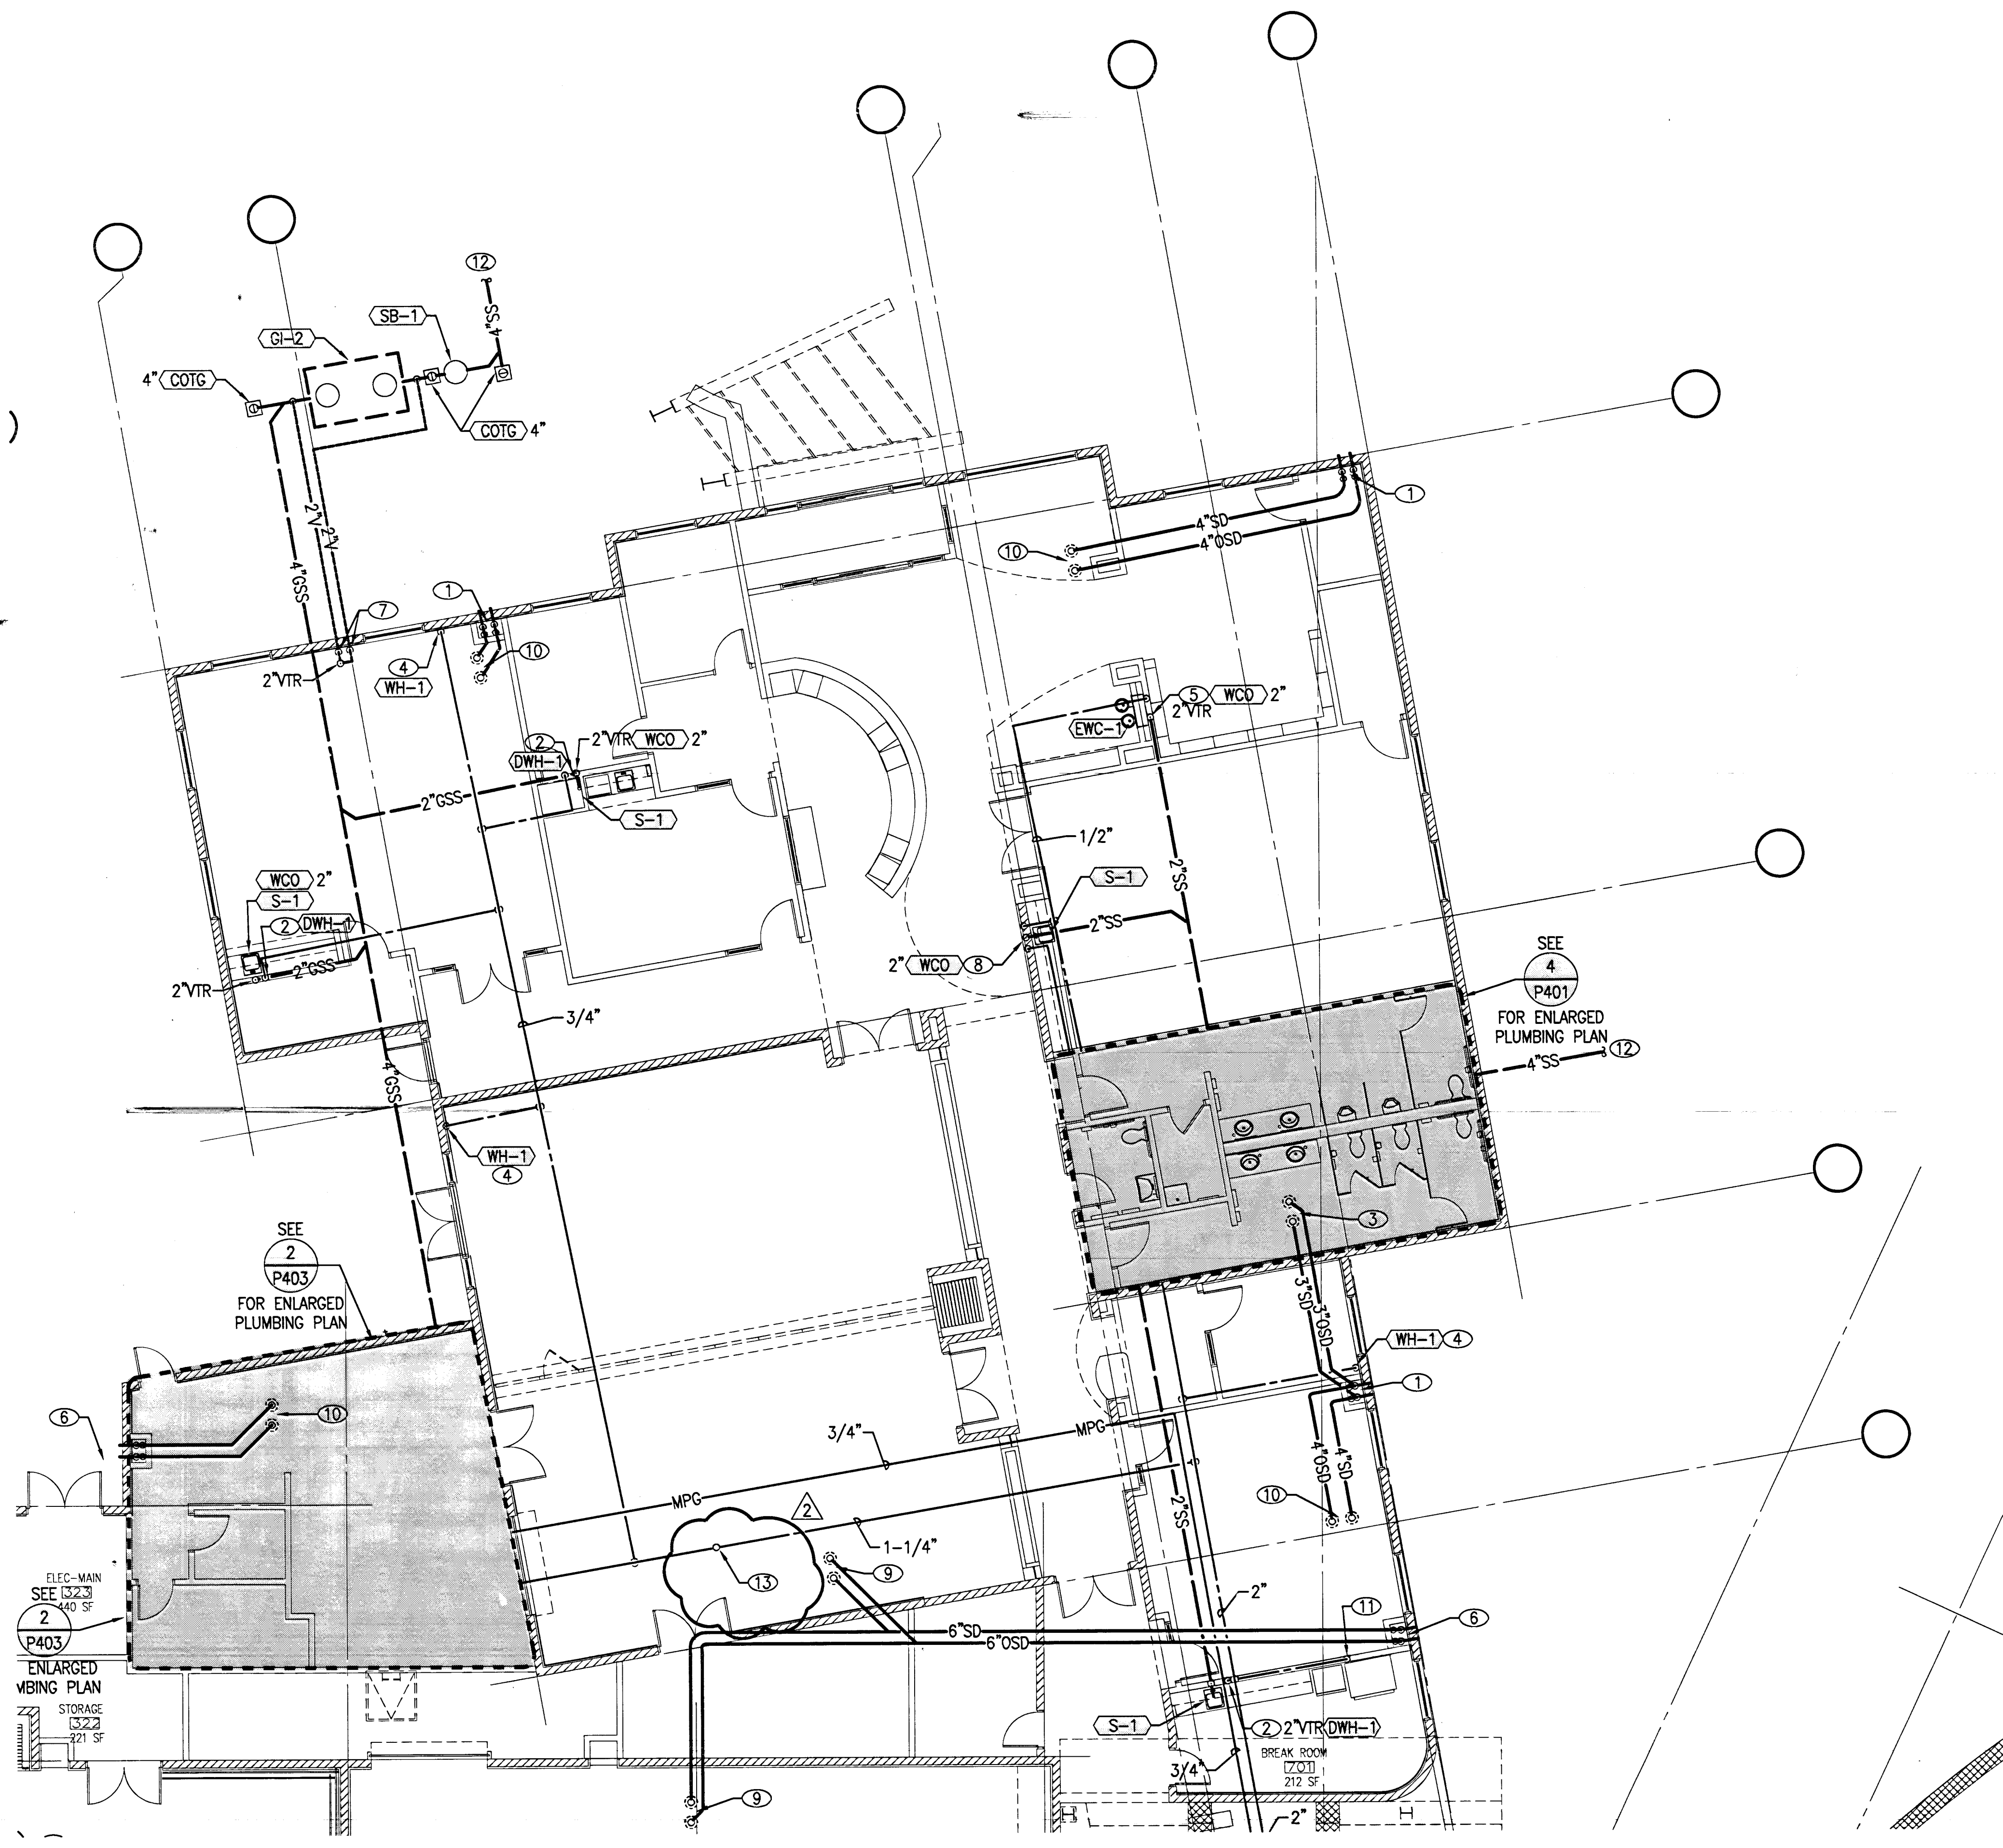


PLUMBING PIPING SHALL NOT BE RUN IN CMU BLOCK. ROUTE PIPING EITHER IN FURRED OUT OR STUD WALLS.

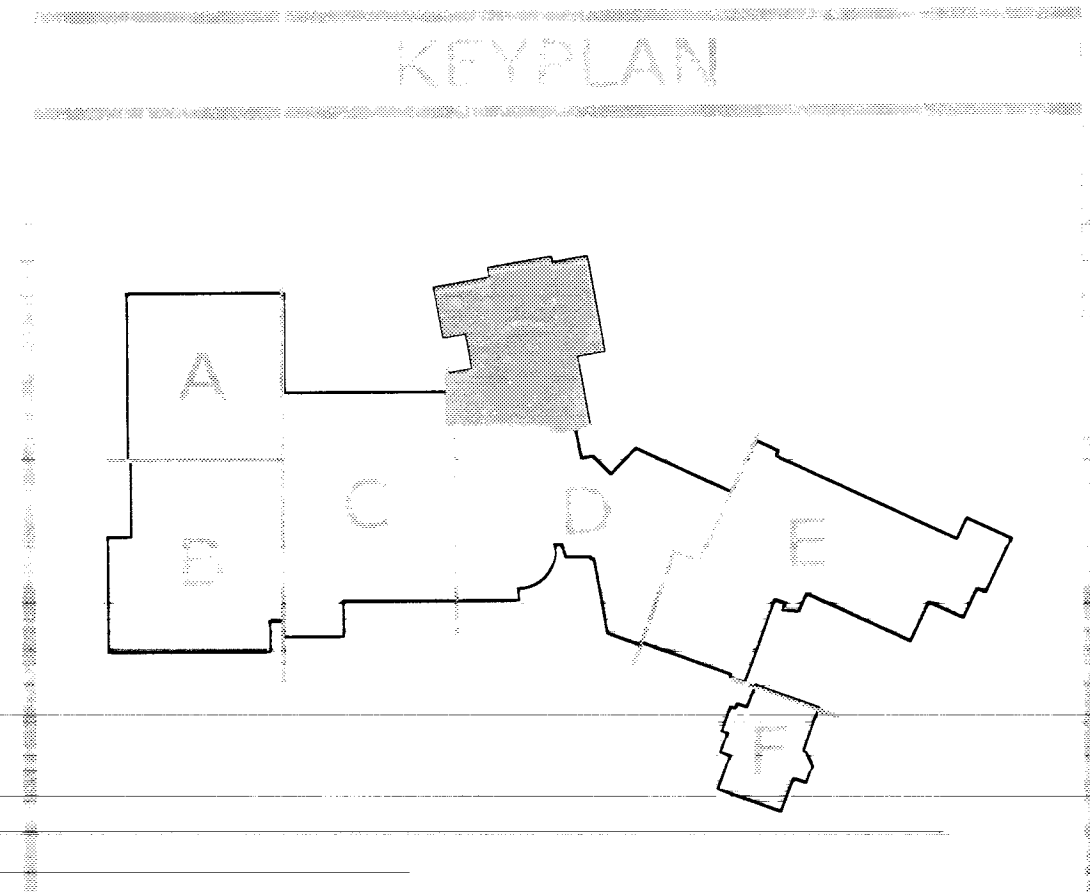

**FLOOR PLAN - AREA G**  
 P2.07 SCALE: 1/8" = 1'-0"

Disclaimer: These record drawings prepared by Lucchesi Galati Architects, Inc., are based on information provided by others. Lucchesi Galati Architects, Inc. has not verified the accuracy and/or completeness of the information provided. The user assumes all responsibility for any errors or omissions, which may be incorporated herein as a result.

CITY OF LAS VEGAS  
 CENTENNIAL HILLS COMMUNITY CENTER  
 FLOOR PLAN - AREA G

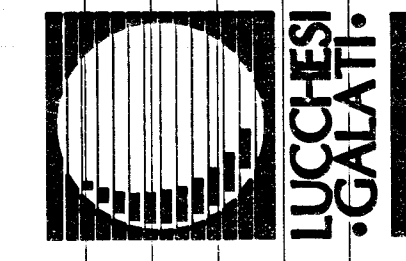

500 FLOTT ROAD, SUITE A  
 LAS VEGAS, NEVADA 89109  
 702.733.7711 FAX  
 702.733.4844

RECORD DRAWING 120207

DATE: 09-01-09  
 VP: 1'-0"  
 DESIGNED BY: JES/34121  
 DRAWN BY: 671-49

P2.07

P2.07

122077