


ELECTRICAL LIGHTING PLAN AREA E

SCALE: 1/8"=1'-0"

- NOTES:**
- ① SEE SHEET E1.04 FOR CONTINUATION OF CIRCUIT H4-11.
 - ② SEE SHEET E1.04 FOR CONTINUATION OF CIRCUIT H4-7.
 - ③ PROVIDE ROTARY 60 MIN. TIMER SWITCH.
 - ④ ROUTE CIRCUIT THROUGH CONTACTOR. SEE CONTACTOR SCHEDULES.
 - ⑤ SEE DETAIL 10/E4.02 FOR ADDITIONAL INFORMATION.

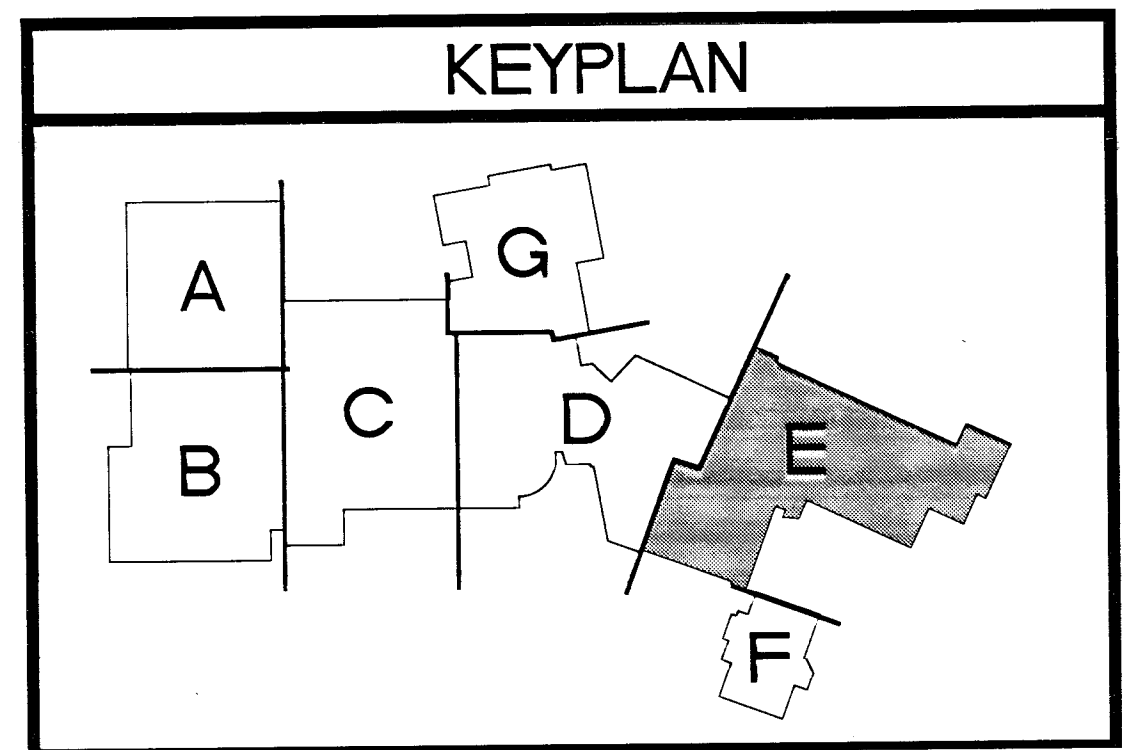

THESE RECORD DOCUMENTS HAVE BEEN PREPARED BASED ON INFORMATION PROVIDED BY OTHERS. THE DESIGN PROFESSIONAL HAS NOT VERIFIED THE ACCURACY AND/OR COMPLETENESS OF THIS INFORMATION AND SHALL NOT BE RESPONSIBLE FOR ANY ERRORS OR OMISSIONS WHICH MAY BE INCORPORATED HEREIN AS A RESULT.

REVISIONS

NO.	DATE	DESCRIPTION

CONSULTANT

LUCCHESE • GALATI

500 PILOT ROAD, SUITE A
LAS VEGAS, NEVADA 89119
(702) 263-7111
(702) 263-8111 FAX

Disclaimer: These record drawings prepared by Luchesi Galati Architects, Inc. are based on information provided by others. Luchesi Galati Architects, Inc. has not verified the accuracy and/or completeness of its information supplied by others, and shall not be responsible for any errors or omissions, which may be incorporated herein as a result.

CITY OF LAS VEGAS
CENTENNIAL HILLS COMMUNITY CENTER
RECORD DRAWINGS
ELECTRICAL LIGHTING PLAN AREA E

OWNER: CITY OF LAS VEGAS
DEPARTMENT OF PUBLIC WORKS
ARCHITECTURAL SERVICES

400 EAST STRAWBERRY AVENUE
LAS VEGAS, NEVADA 89101
PHONE: (702) 228-8528
FAX: (702) 384-8842
TDD: (702) 386-8108

DATE: 05/08/05

SCALE: 1/8"=1'-0"

REV NO: 05153410

CITY NO: 611-43

SHEET NO: E1.05