

NOTES:

- ① J-BOX FOR THREE ROOM COMBINER BOXES.
- ② J-BOX FOR TWO ROOM COMBINER BOXES.
- ③ SEE DETAIL 1/E4.04 FOR TV CONDUIT INFORMATION.
- ④ ROUTE TO AV EQUIPMENT. SEE DETAIL 4/E4.01 FOR ADDITIONAL INFORMATION.
- ⑤ ROUTE TO NEAREST TELE-AUX ROOM THAT IS ACCESSIBLE WITHOUT CROSSING THE CIRCULATION CORRIDOR. SEE DETAIL 3/E4.01 FOR CABLING INFORMATION.
- ⑥ ROUTE CABLE A, 3/4\" C TO CLOCK/INTERCOM CABINET IN ROOM 403.
- ⑦ SOUND SYSTEM EQUIPMENT LOCATED IN UPPER CABINETS. COORDINATE LOCATION OF CONDUIT ENTRANCES WITH ARCHITECTURAL ELEVATIONS.
- ⑧ SEE SITE PLAN FOR ADDITIONAL INFORMATION.
- ⑨ NOT USED.
- ⑩ PROVIDE 3/4\" FIRE-TREATED PLYWOOD BACKBOARD ON ALL WALLS, 8\" HIGH.
- ⑪ SEE DRAWING E3.04 FOR CONTINUATION.
- ⑫ DATA AND POWER ONLY.
- ⑬

GENERAL NOTES:

- 1. ALL CONDUIT IS 3/4\" MIN. UNO.
- 2. CONTRACTOR MAY COMBINE ALL TYPE A HOMERUNS.
- 3. MOUNT ALL EXPOSED CONDUIT ALONG CEILING SNUG TO BOTTOM OF STRUCTURE.
- 4. SURFACE MOUNTED CONDUITS ARE NOT ACCEPTABLE. ALL CONDUITS ARE TO BE CONCEALED WITHIN WALLS OR BELOW GRADE.
- 5. ALL WIRING AND CONDUIT SHALL BE CONCEALED WITHIN THE WALLS, INCLUDING BLOCK WALLS. COORDINATE CONDUIT INSTALLATION WITH OTHER TRADES PRIOR TO ROUGH-IN.
- 6. REFER TO SPECIFICATIONS AND ARCHITECTURAL FINISH SCHEDULE FOR DEVICE COVERPLATE REQUIREMENTS.

REVISIONS
 RECORD DRAWING 10/07/20
 CONSULTANT
 300 PLOT ROAD, SUITE A
 LAS VEGAS, NEVADA 89109
 (702) 263-7111
 (702) 263-8111 FAX
LUCCHESI
GALATI

Disclaimer: These record drawings prepared by Lucchesi Galati Architects, Inc., are based on information provided by others. Lucchesi Galati Architects, Inc. is not responsible for any errors or omissions, which may be incorporated herein as a result.


CITY OF LAS VEGAS
CENTENNIAL HILLS COMMUNITY CENTER
RECORD DRAWINGS
ELECTRICAL COMMUNICATION PLAN AREA C

OWNER: CITY OF LAS VEGAS
 DEPARTMENT OF PUBLIC WORKS
 ARCHITECTURAL SERVICES

400 EAST STEWART AVENUE
 LAS VEGAS, NEVADA 89101
 PHONE: (702) 229-8333
 FAX: (702) 384-8848
 TDD: (702) 386-9308


DATE	05/28/09
SCALE	
BD NO	05153410
DWG NO	611-49

E3.03

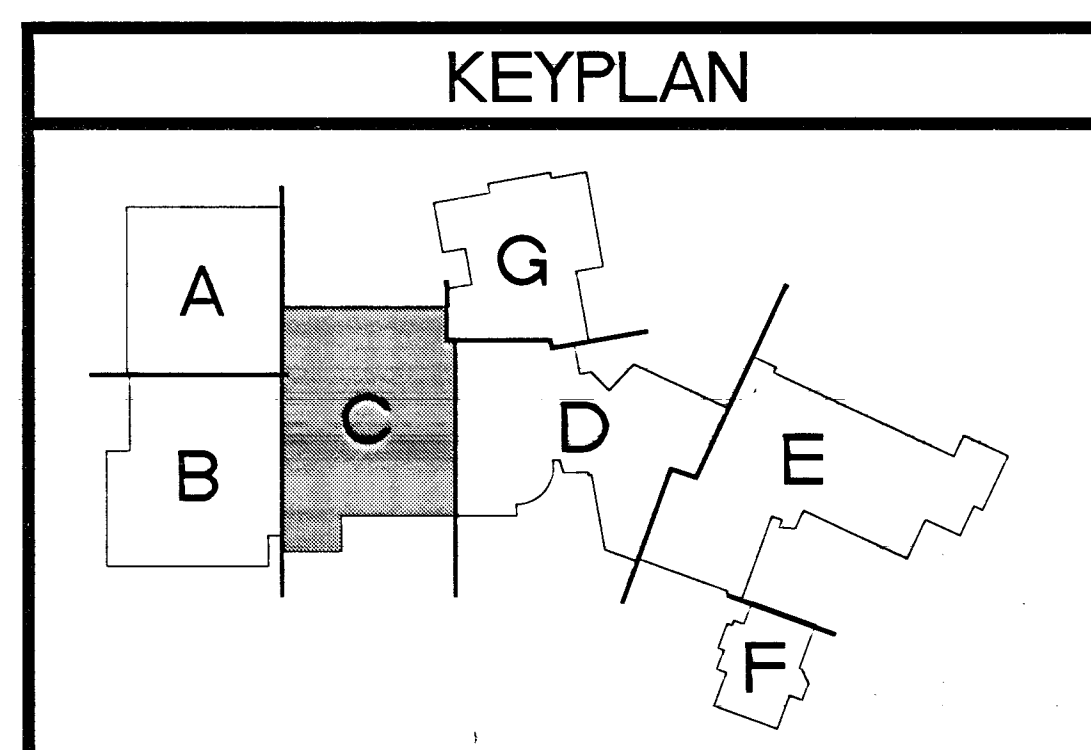

THESE RECORD DOCUMENTS HAVE BEEN PREPARED BASED ON INFORMATION PROVIDED BY OTHERS. THE DESIGN PROFESSIONAL HAS NOT VERIFIED THE ACCURACY AND/OR COMPLETENESS OF THIS INFORMATION AND SHALL NOT BE RESPONSIBLE FOR ANY ERRORS OR OMISSIONS WHICH MAY BE INCORPORATED HEREIN AS A RESULT.

ELECTRICAL COMMUNICATION PLAN AREA C
 SCALE: 1/8"=1'-0"

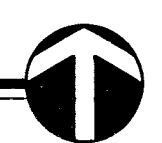

JUL 03 03 09
 127123