
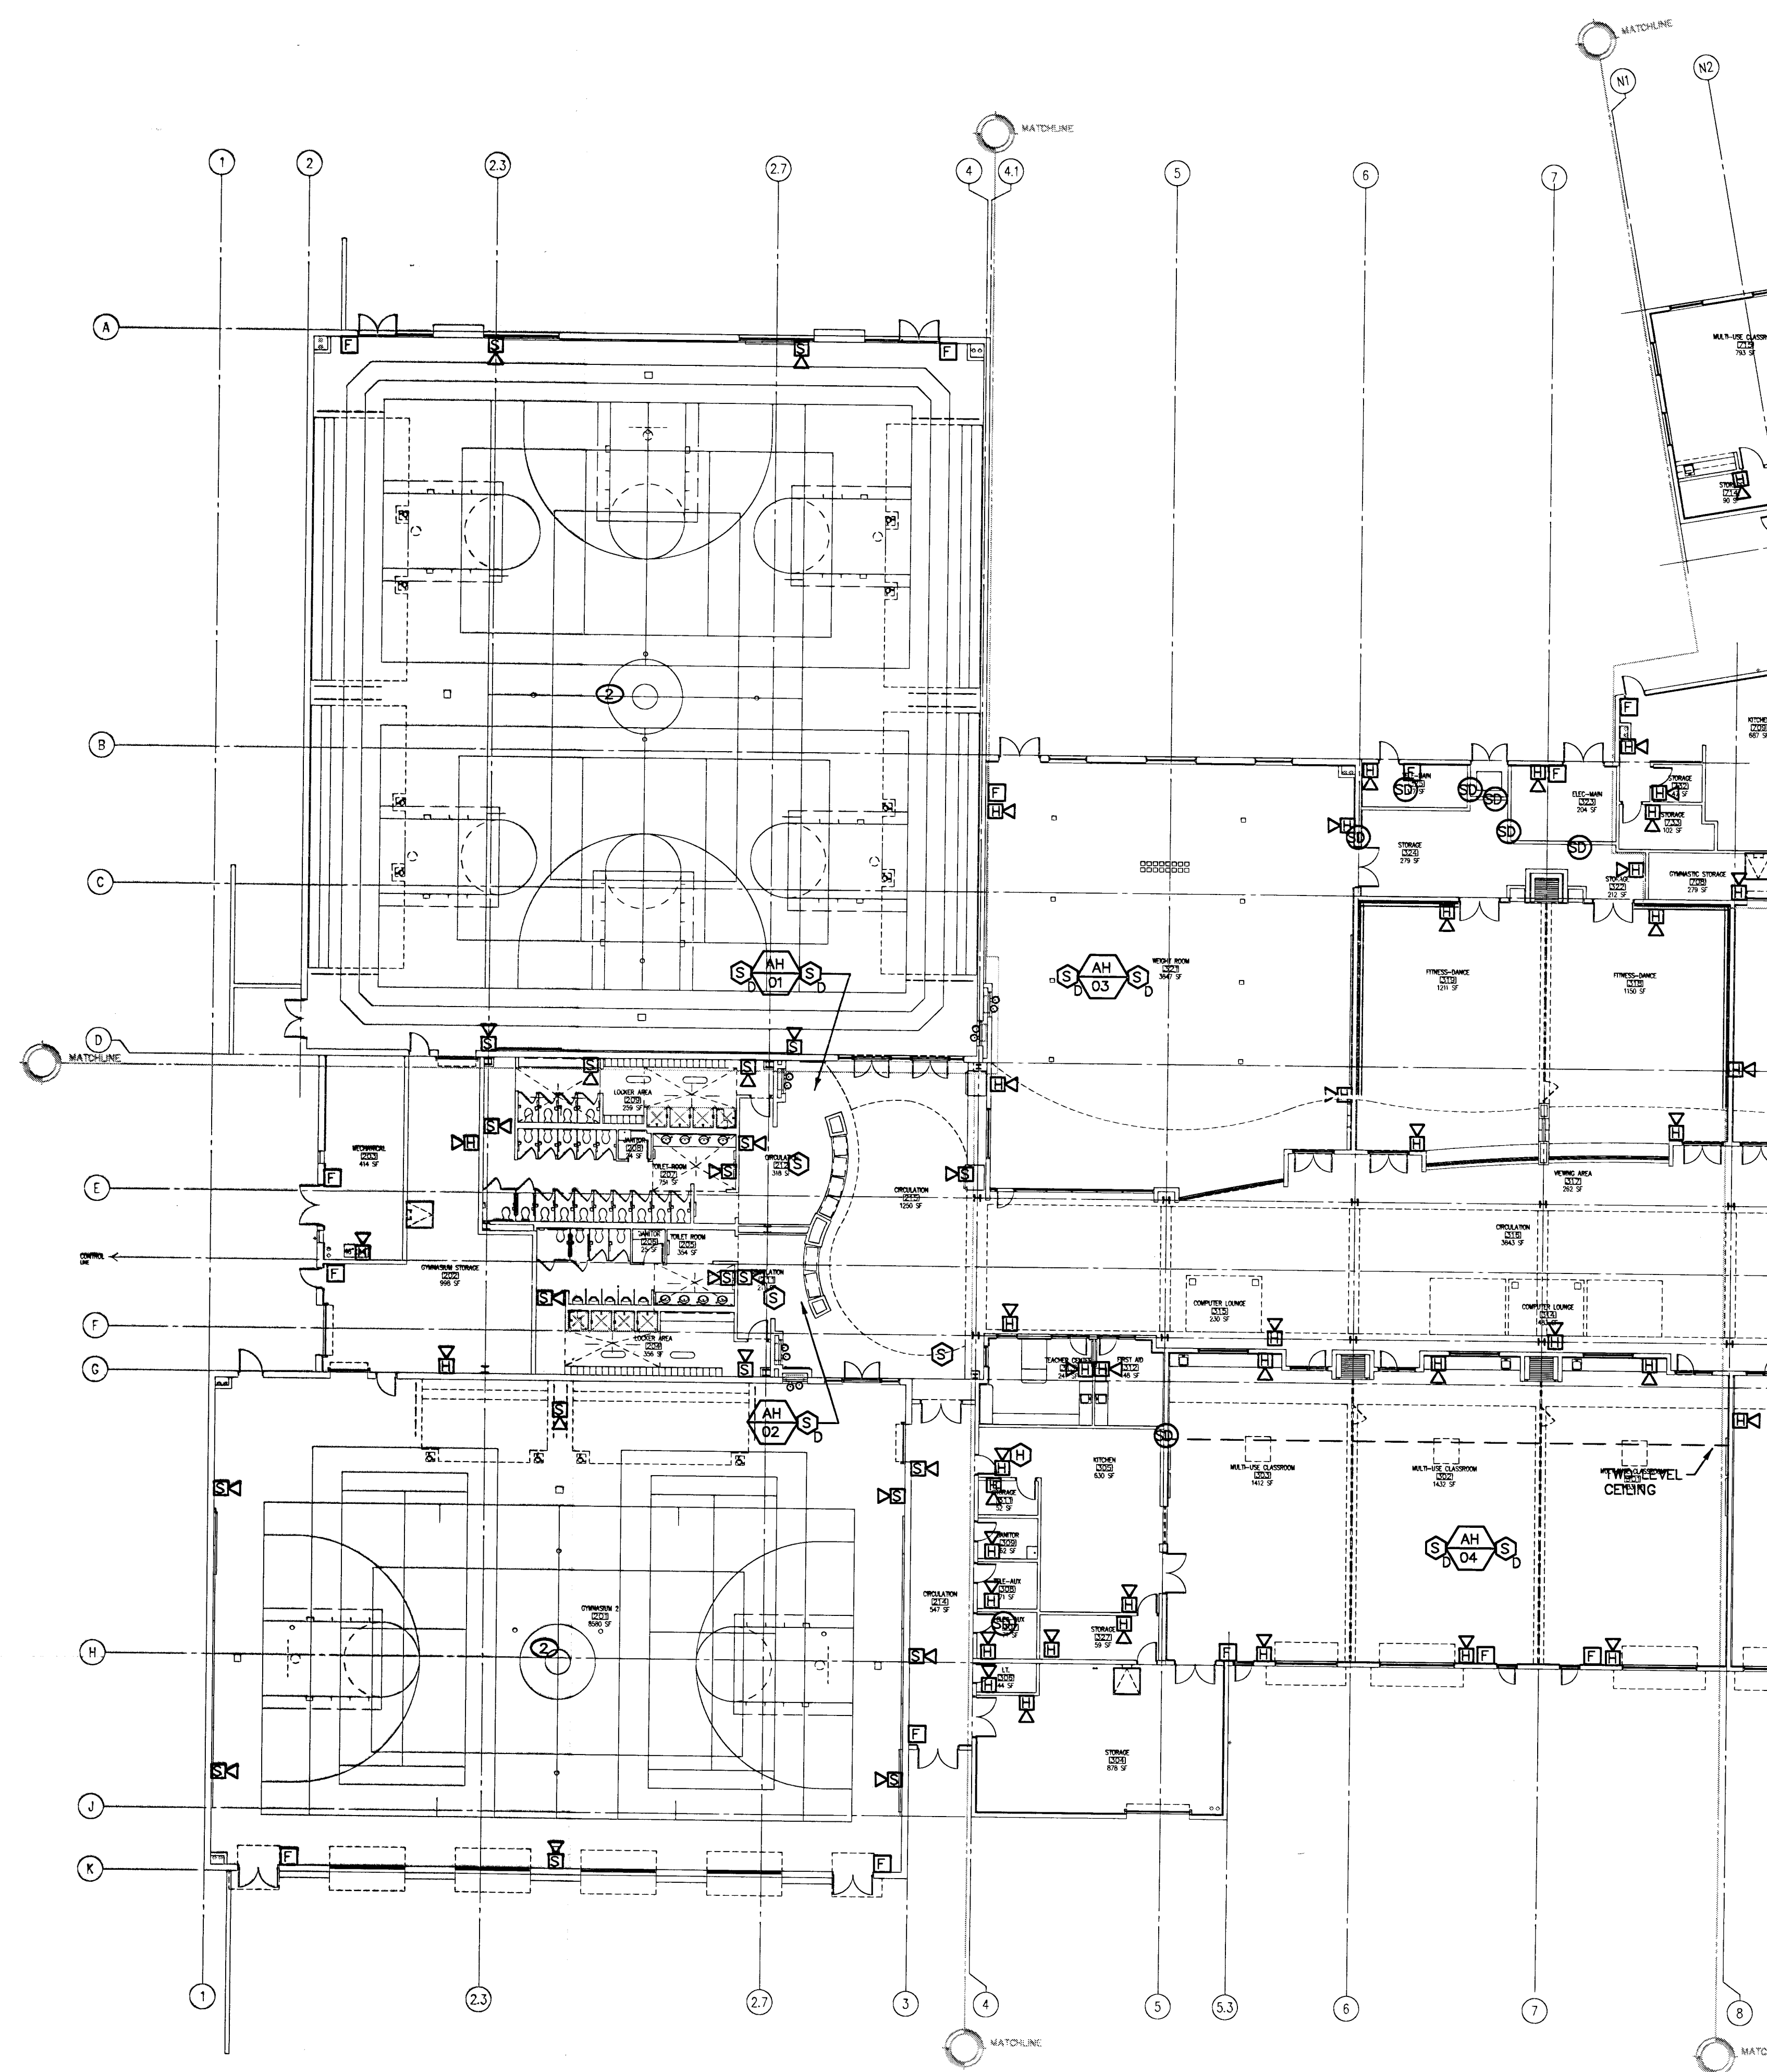


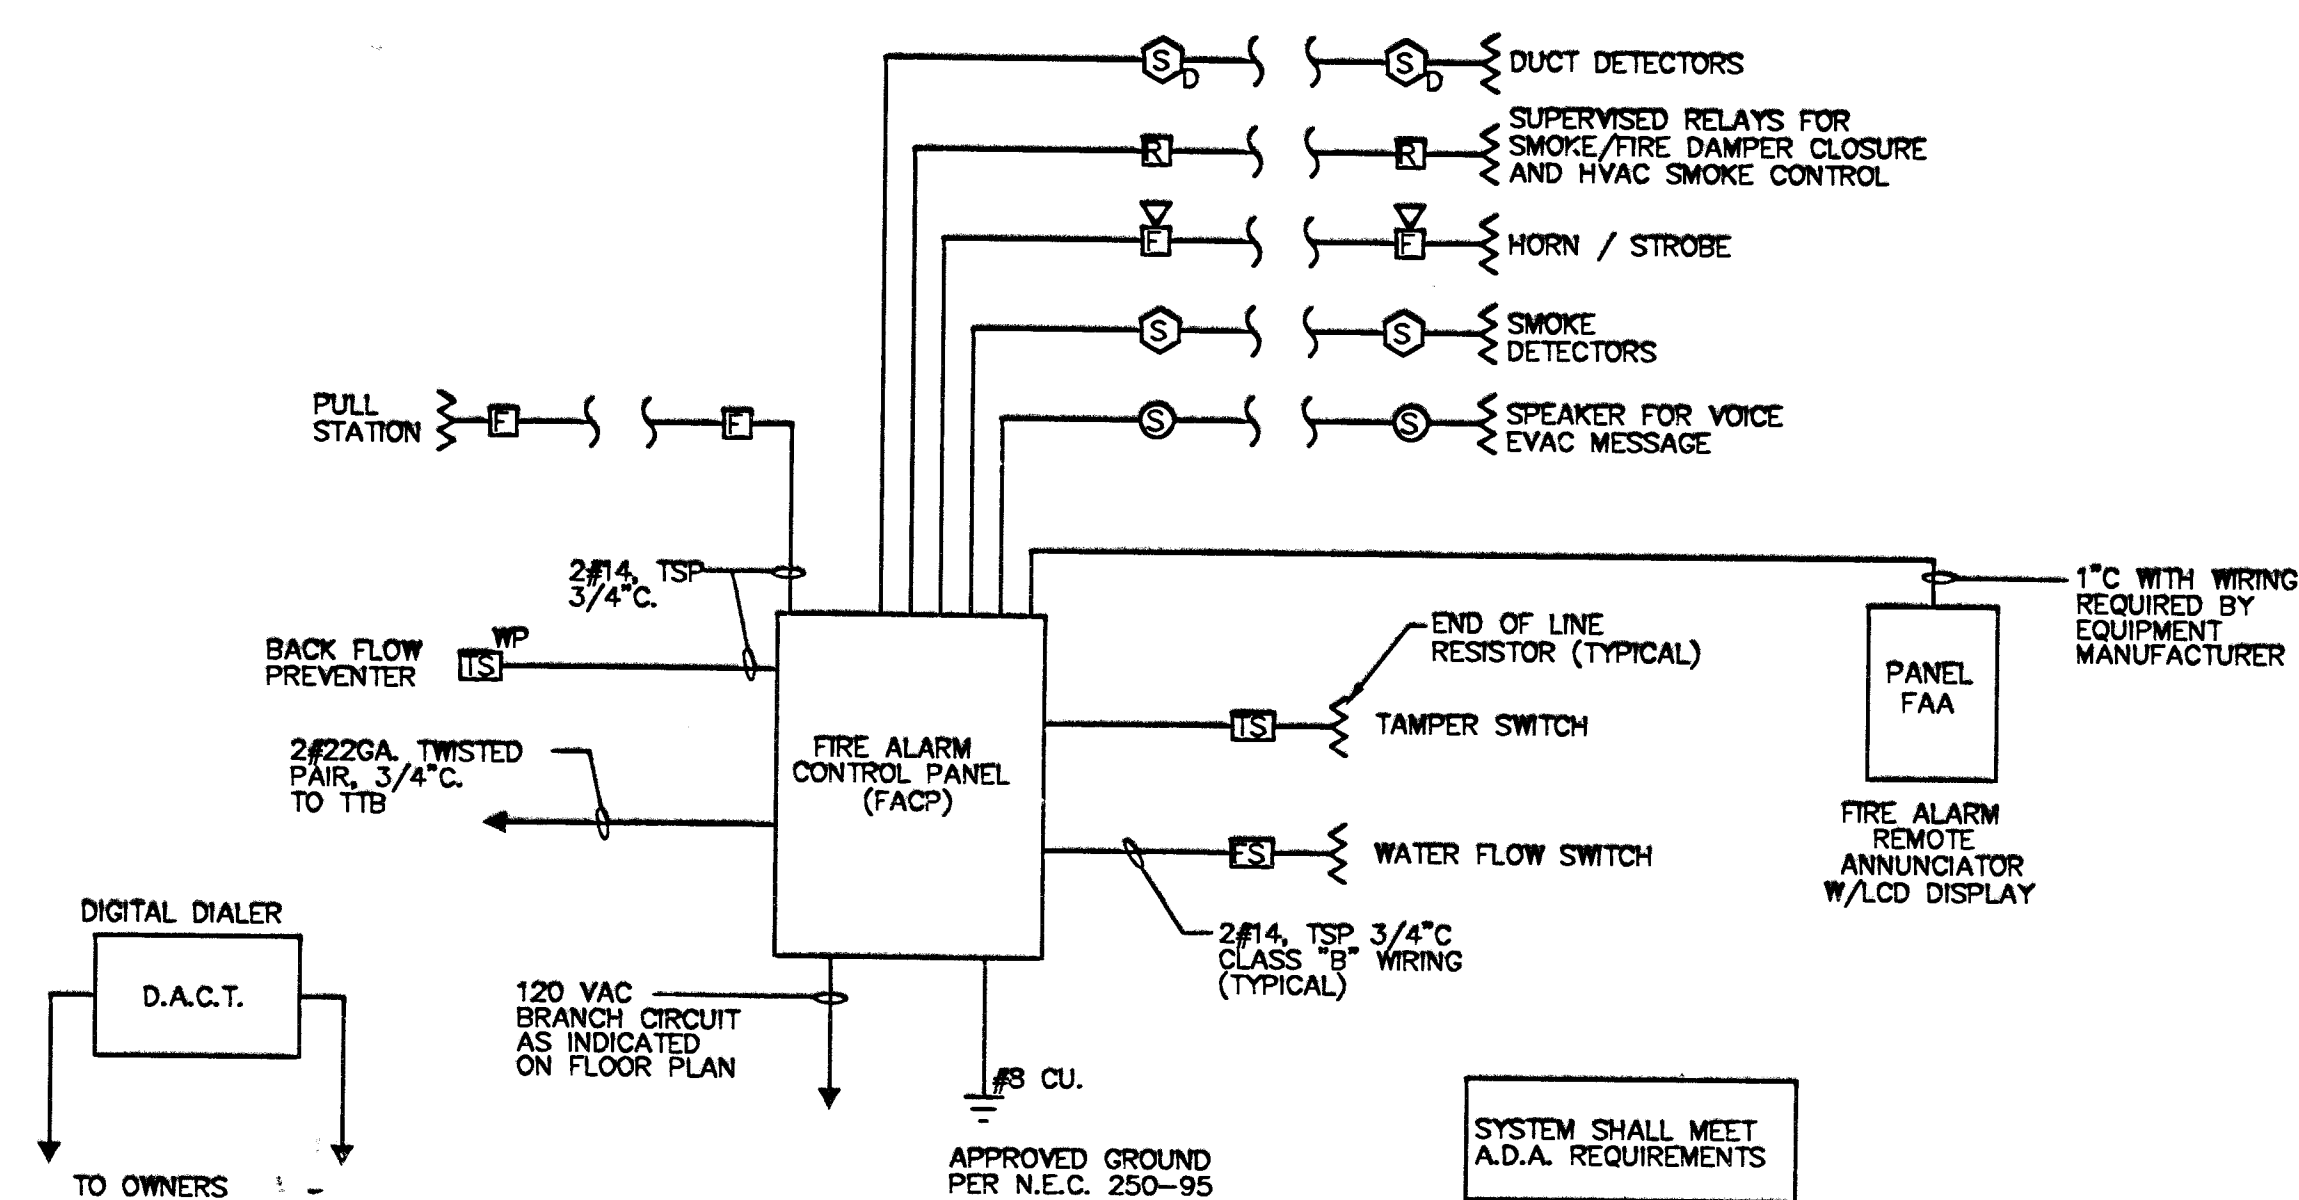

FIRE ALARM PLAN AREAS A, B, C

SCALE: 1/16"=1'-0"


NOTES:

- NOT USED.
- ALL DEVICES IN GYM TO HAVE WIRE GUARD PROTECTION. WIRE GUARD SHALL BE FASTENED TO THE WALL SECURELY WITH NUT AND BOLT. DO NOT USE SPRING LOADED FASTENERS.

GENERAL NOTES:

- ALL CONDUITS SHALL BE ROUTED SNUG TO BOTTOM OF DECK. UTILIZE ELECTRICAL ROOMS FOR CROSSING THE CIRCULATION CORRIDOR. SEE DETAIL 7/E4.01 FOR UNDERGROUND CONDUIT INFORMATION.

THESE RECORD DOCUMENTS HAVE BEEN PREPARED BASED ON INFORMATION PROVIDED BY OTHERS. THE DESIGN PROFESSIONAL HAS NOT VERIFIED THE ACCURACY AND/OR COMPLETENESS OF THIS INFORMATION AND SHALL NOT BE RESPONSIBLE FOR ANY ERRORS OR OMISSIONS WHICH MAY BE INCORPORATED HEREIN AS A RESULT.

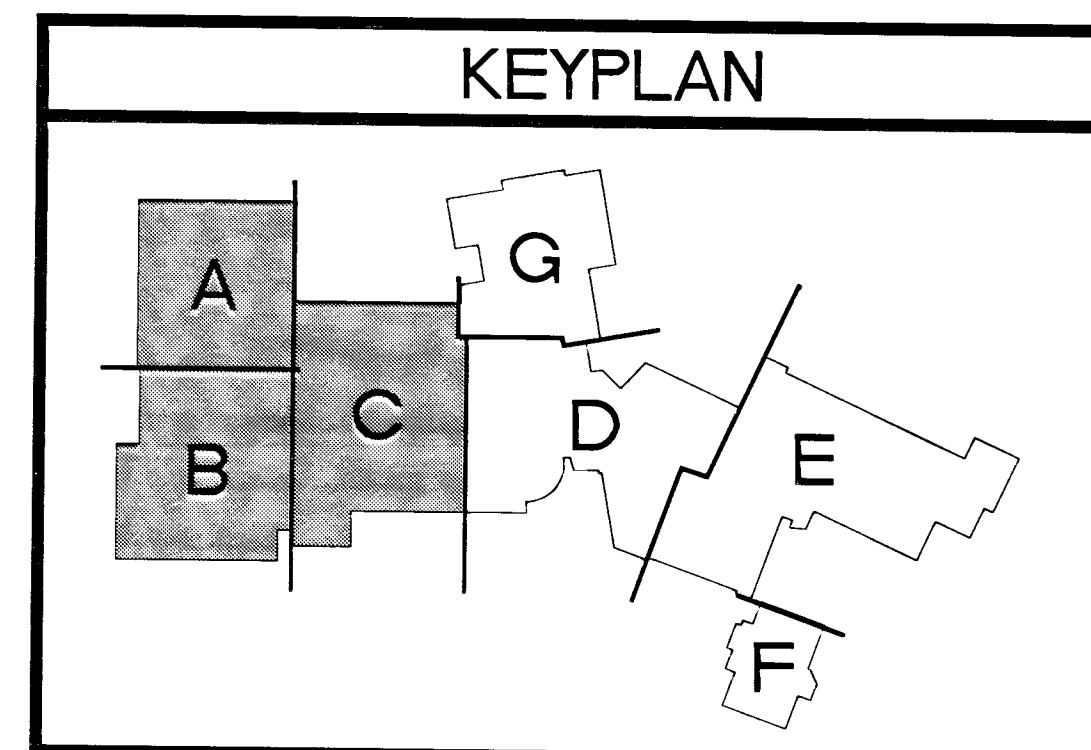

Disclaimer: These record drawings prepared by Lucchesi Galati Architects, Inc., are based on information provided by others. Lucchesi Galati Architects, Inc., does not warrant the accuracy and/or completeness of the information supplied by others, and shall not be responsible for any errors or omissions, which may be incorporated herein as a result.

**CITY OF LAS VEGAS
CENTENNIAL HILLS COMMUNITY CENTER
RECORD DRAWINGS
FIRE ALARM PLAN AREAS A, B, C**

OWNER: CITY OF LAS VEGAS
DEPARTMENT OF PUBLIC WORKS
ARCHITECTURAL SERVICES

400 EAST STEWART AVENUE
LAS VEGAS, NEVADA 89101
PHONE: (702) 229-8434
FAX: (702) 384-8866
TDD: (702) 386-1908

DATE: 03/05
SCALE:
REV NO: 051534101
CLVING NO: 671-49

FA1.01