


**LEGEND**

- UL = UNDERWATER LIGHT
- JB = JUNCTION BOX


**NOTES**

1. PROVIDE EMERGENCY SHUT-OFF SWITCH IN LIFEGUARD RM. 506 FOR CIRCULATION PUMPS.
2. PROVIDE UNDERWATER LIGHT SWITCHES FOR TEACHING POOL AND INDOOR POOL IN LIFEGUARD RM. 506.

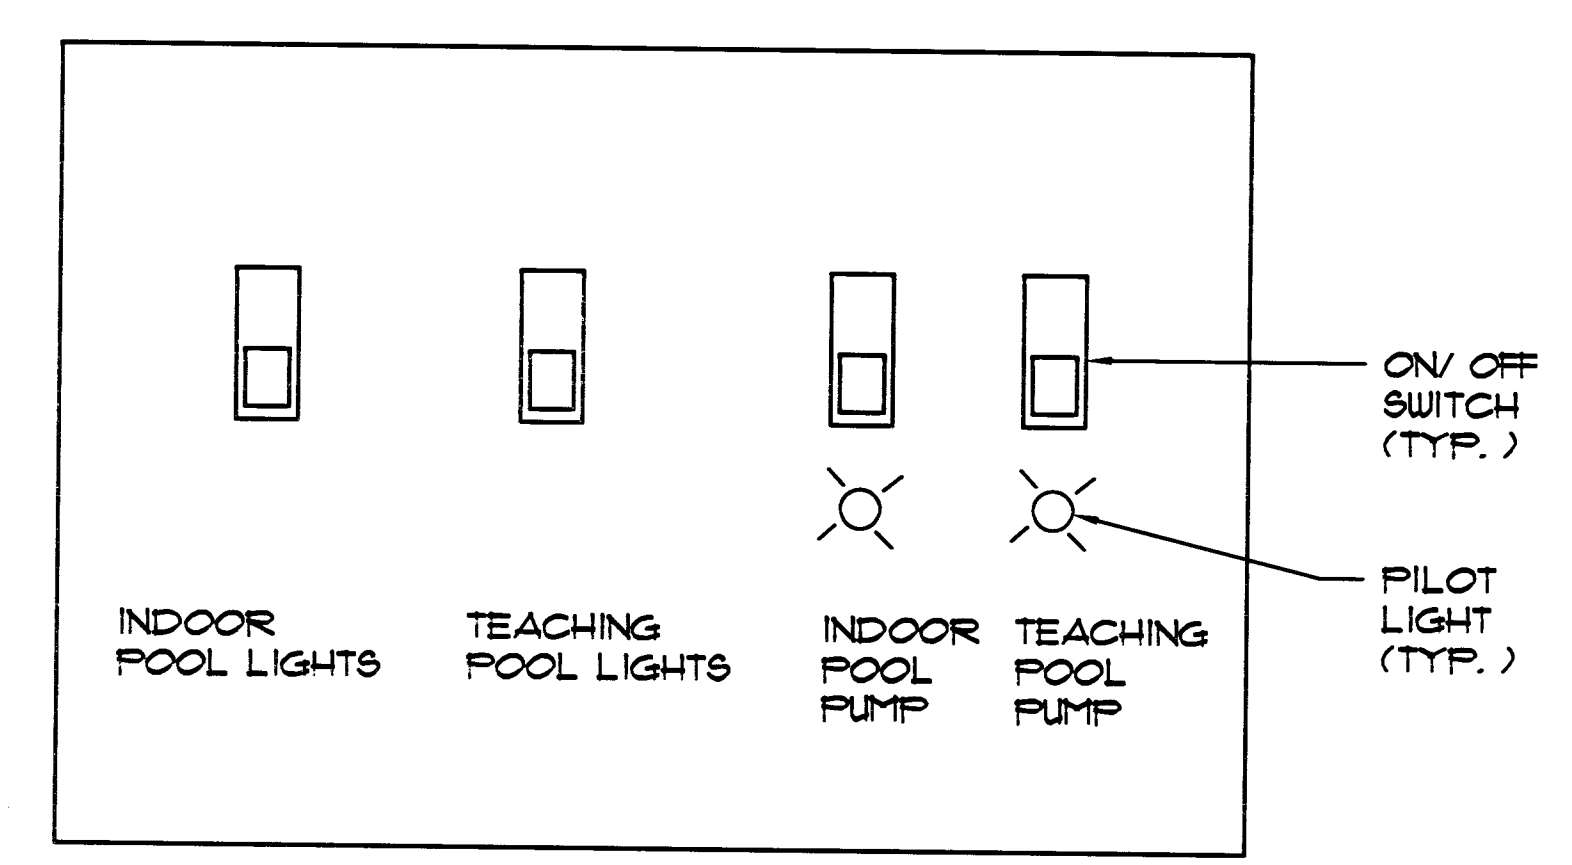

LOCATE IN LIFEGUARD OFFICE RM. 506

**2 SWITCH BANK DETAIL**  
 NO SCALE

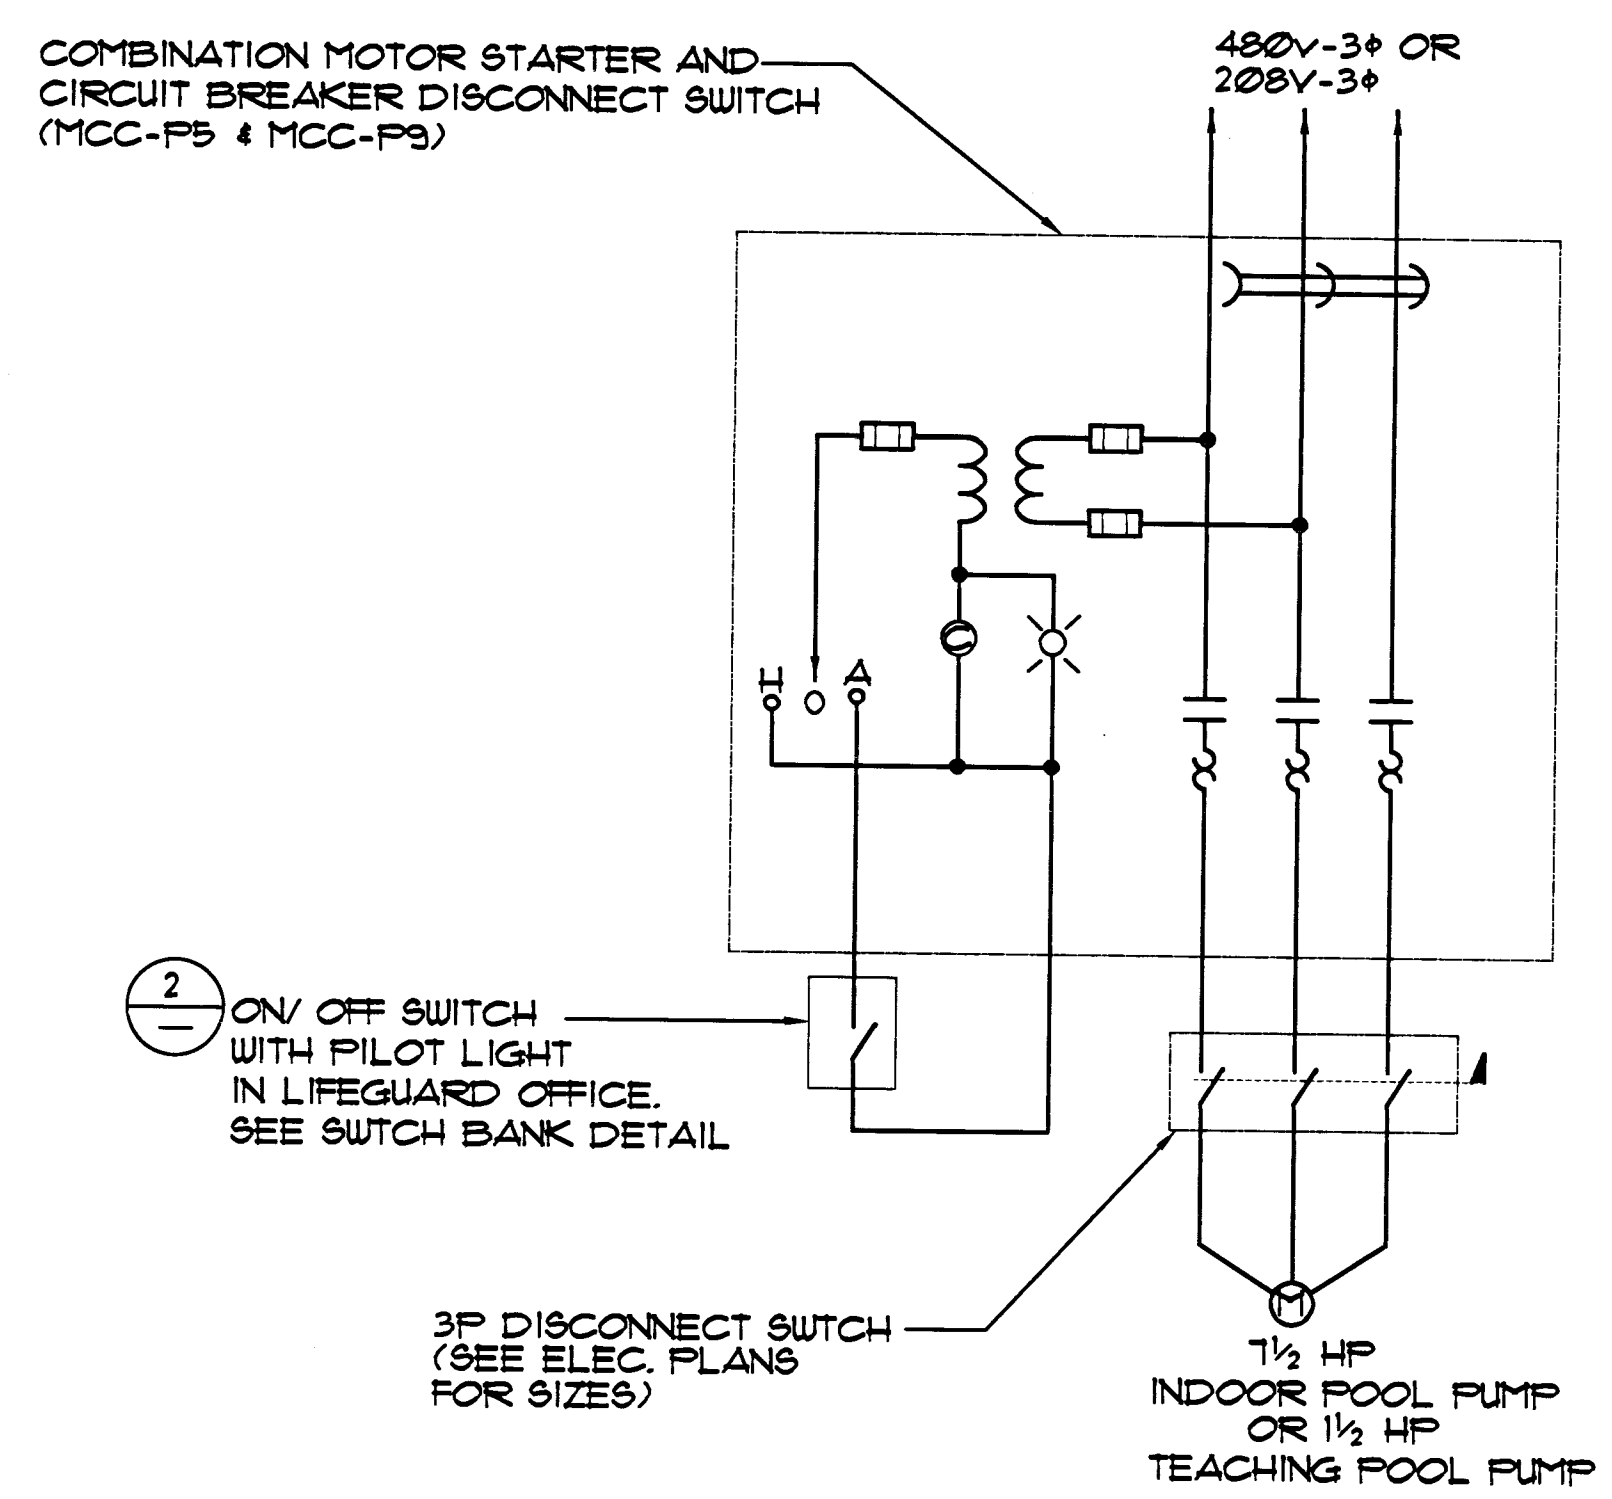

**3 CIRCULATION PUMP CONTROL DIAGRAM**  
 NO SCALE

TEACHING / INDOOR POOL UNDERATER LIGHT PLAN 1/8"=1'-0"



075 PR311E  
 127142