


CONSTRUCTION ITEMS:

1. ADJUST WATER VALVE BOX TO FINISHED GRADE PER UDACS PLATE NO. 39. VALVE SHALL BE ACCESSIBLE AT ALL TIMES
2. CONTRACTOR SHALL INSTALL BLIND FLANGE, CONCRETE COLLAR, MANHOLE FRAME AND COVER AND ADJUST WATER BLOW-OFF ASSEMBLY TO FG PER UDACS PLATE NO. 37
3. ADJUST WATER MANHOLE TO FG PER LVVWD DESIGN STD. PLO8-4 (LVVWD ACAD STD)
4. ADJUST WATER METER BOX TO FG PER UDACS PLATE NO. 2
5. ADJUST SSMH AND SDMH TO FG AND CONSTRUCT CONCRETE COLLAR PER USD. DWG. #408
6. ADJUST ELECTRICAL OR TELEPHONE MANHOLE TO FG AND CONSTRUCT CONCRETE COLLAR
7. ADJUST GAS VALVE TO FG AND CONSTRUCT CONCRETE COLLAR
8. ADJUST TELEPHONE MANHOLE TO FG AND CONSTRUCT CONCRETE COLLAR (BY OTHERS)


2068

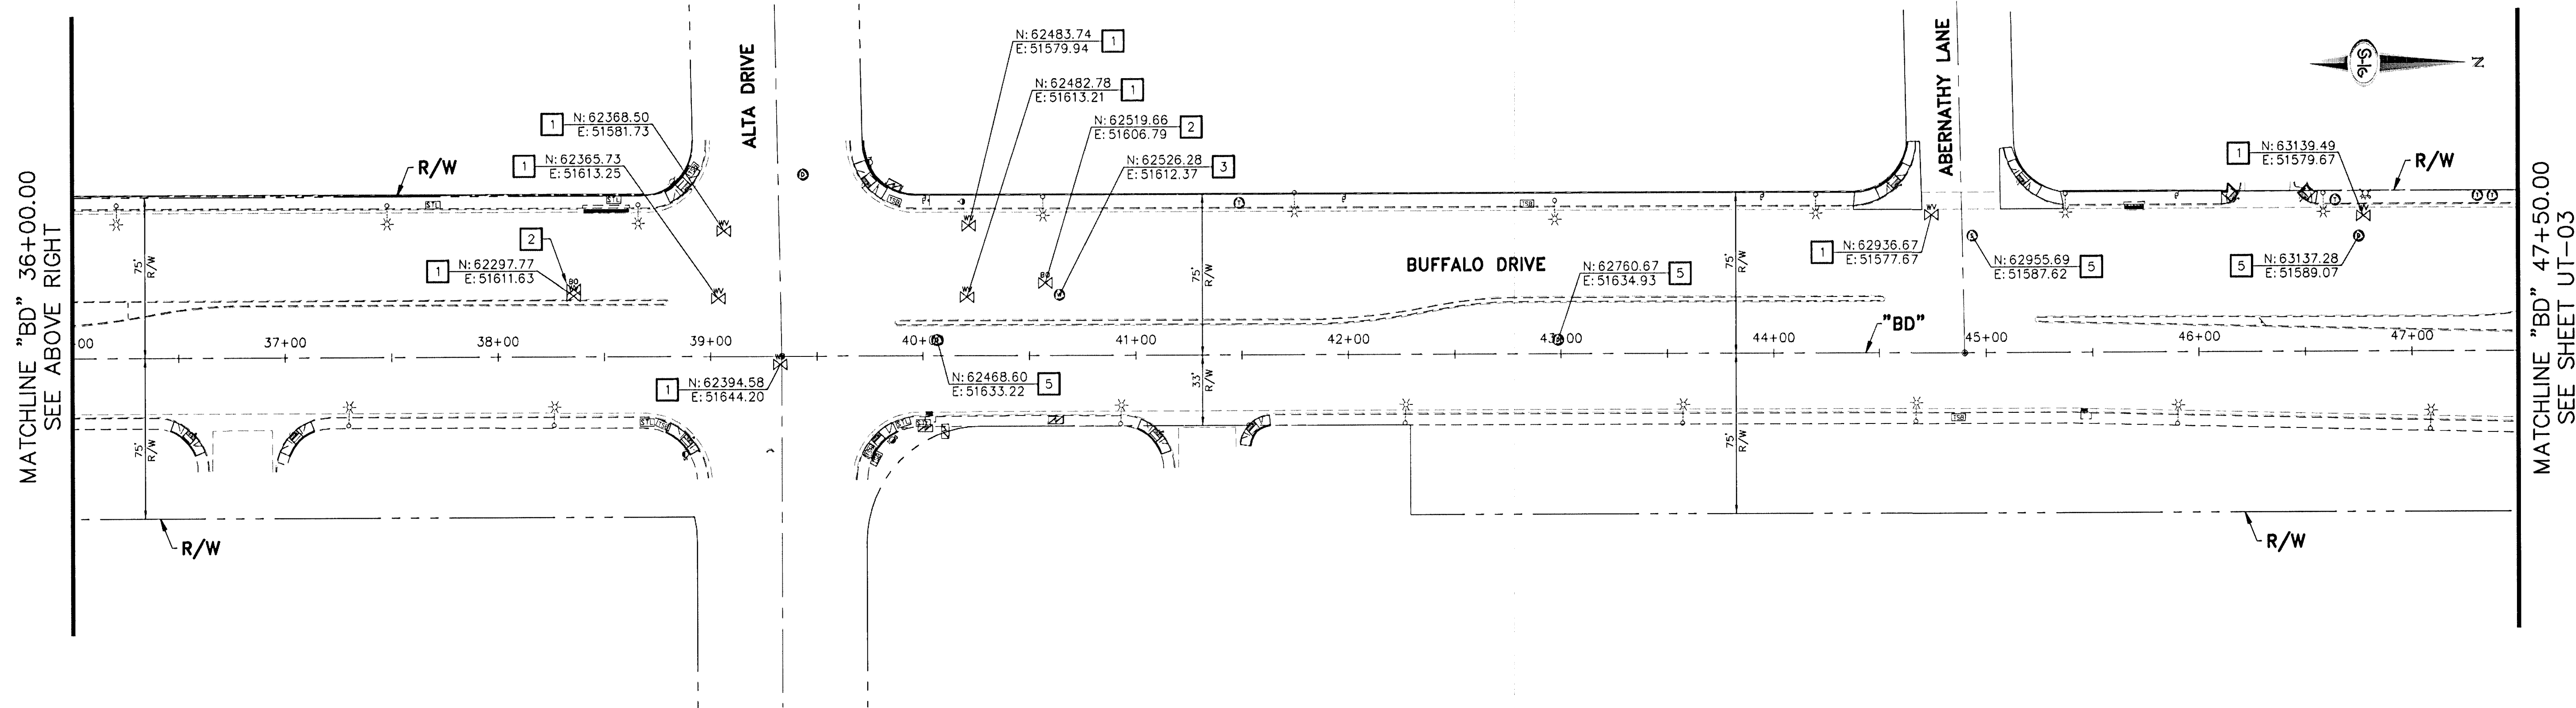

APPROVED FOR CONSTRUCTION
Matthew D. Meyer 08/24/12
LVVWD ENGINEERING SERVICES MANAGER DATE
PROJECT NO. 116912

GENERAL NOTE:

1. LENGTH OF ASPHALT PATCH SHOWN ON THE DRAWINGS IS TO THE CENTER OF THE ASPHALT PATCH UNLESS OTHERWISE NOTED.
2. ALL CONSTRUCTION ACTIVITIES WILL BE PERFORMED WITHIN CITY OF LAS VEGAS RIGHT-OF-WAY.

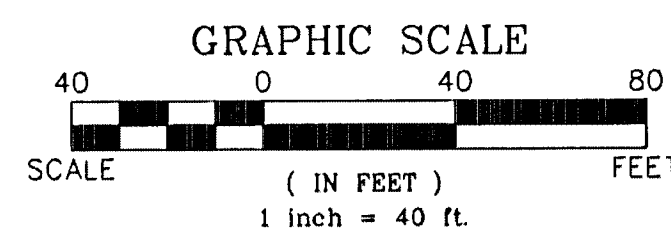

TITLE: BUFFALO DRIVE CHARLESTON BLVD TO LAKE MEAD BLVD UTILITY PLAN "BD" 28+00.00 TO "BD" 47+50.00	SHEET: UT-02 15 of 27 BID NO. 10745984	DEPARTMENT OF OPERATIONS AND MAINTENANCE DEPUTY DIRECTOR OF OPERATIONS AND MAINTENANCE: JERRY WALKER, P.E. DESIGNED BY: MDW DRAWN BY: JAS CHECKED BY: MDW DATE: 8/1/12	NO.	REVISIONS	DATE

BUFFALO DRIVE-CHARLESTON BLVD TO LAKE MEAD BLVD