



MATCHLINE "BD" 95+50.00  
SEE SHEET UT-04

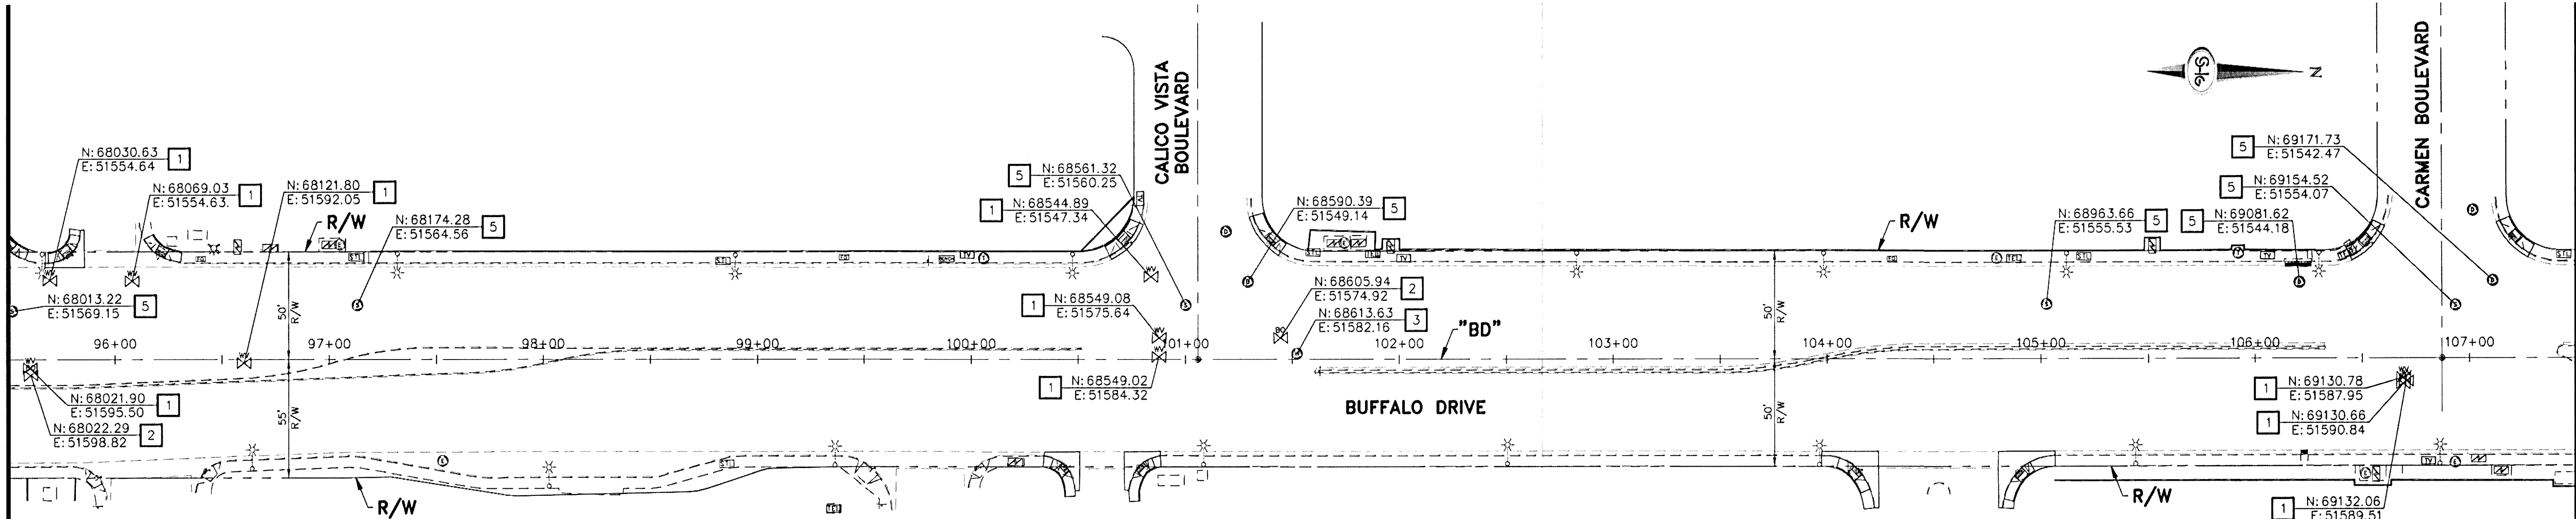

MATCHLINE "BD" 107+50.00  
SEE BELOW LEFT

MATCHLINE "BD" 107+50.00  
SEE ABOVE RIGHT

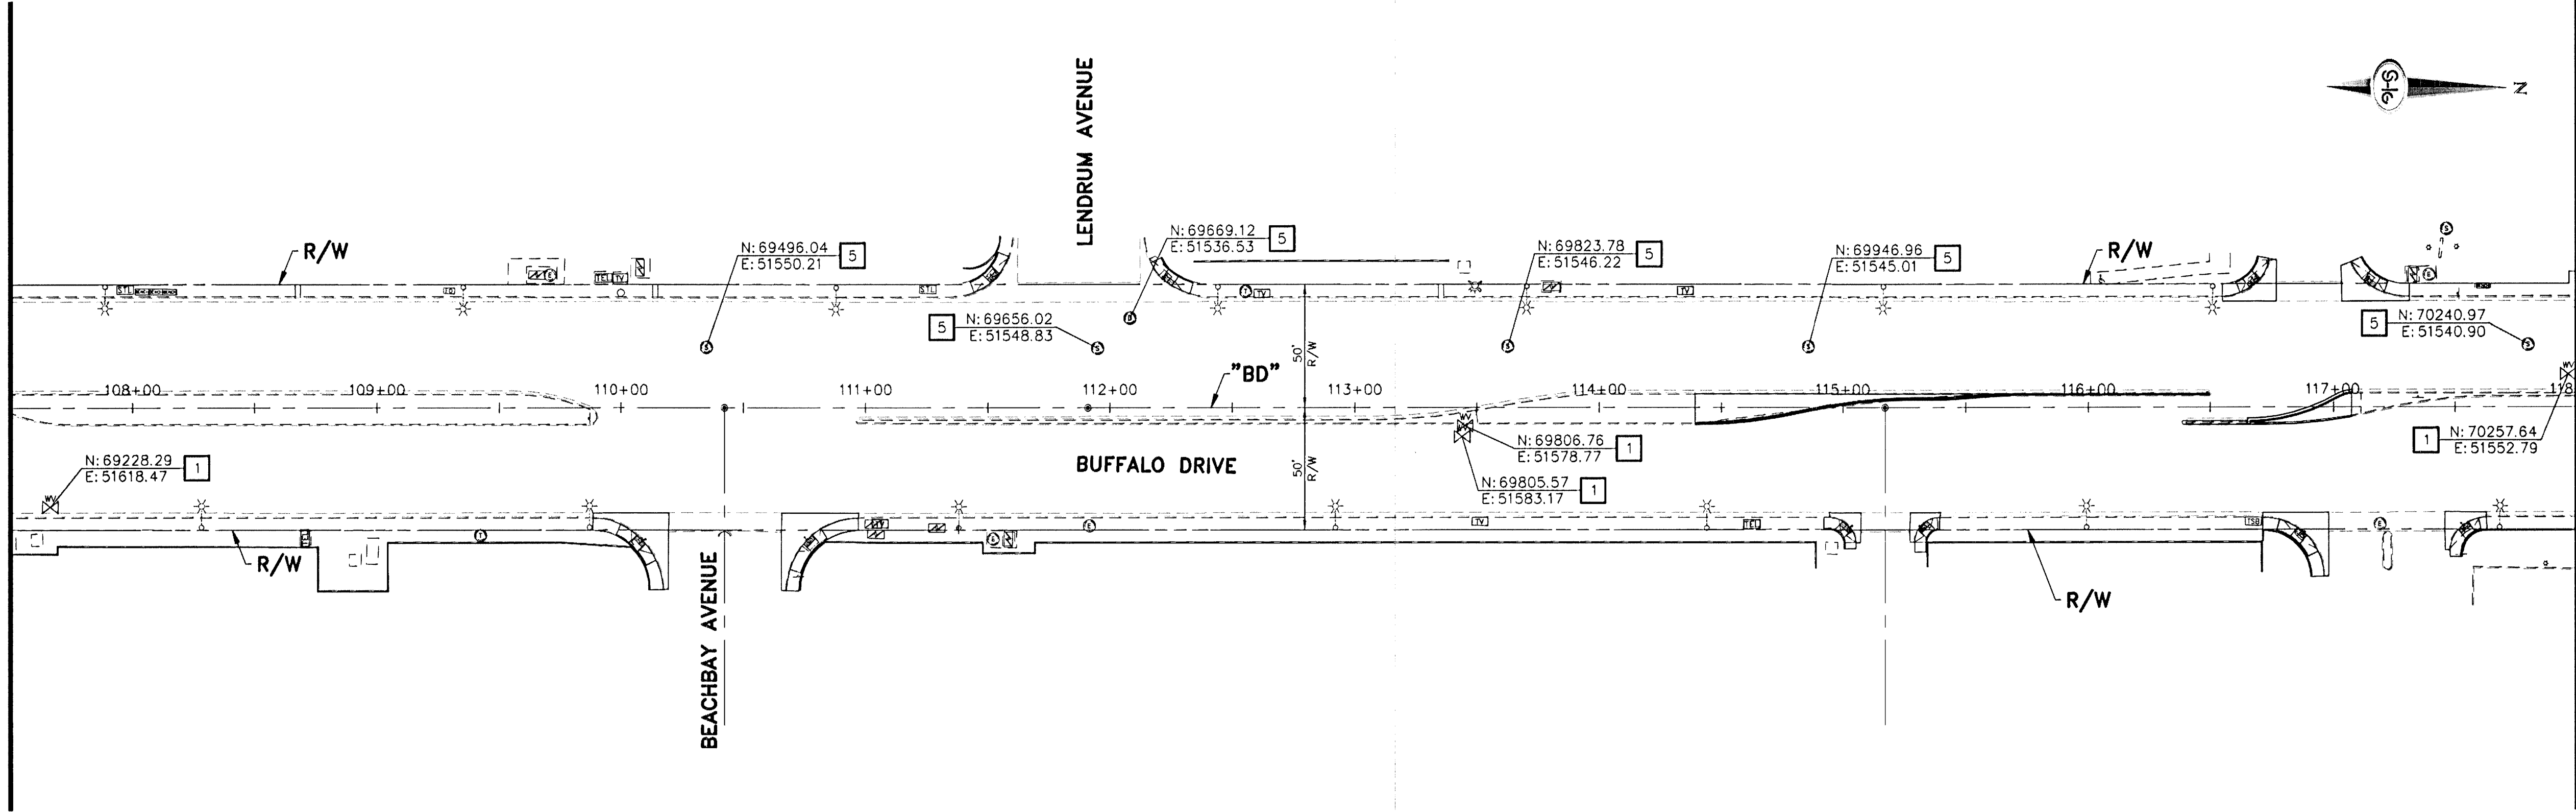


MATCHLINE "BD" 118+00.00  
SEE SHEET UT-06

CONSTRUCTION ITEMS:

- 1 ADJUST WATER VALVE BOX TO FINISHED GRADE PER UDACS PLATE NO. 39. VALVE SHALL BE ACCESSIBLE AT ALL TIMES
- 2 CONTRACTOR SHALL INSTALL BLIND FLANGE, CONCRETE COLLAR, MANHOLE FRAME AND COVER AND ADJUST WATER BLOW-OFF ASSEMBLY TO FG PER UDACS PLATE NO. 37
- 3 ADJUST WATER MANHOLE TO FG PER LVVWD DESIGN STD. PL08-4 (LVVWD ACAD STD)
- 4 ADJUST WATER METER BOX TO FG PER UDACS PLATE NO. 2.
- 5 ADJUST SSMH AND SDMH TO FG AND CONSTRUCT CONCRETE COLLAR PER USD. DWG. #408
- 6 ADJUST ELECTRICAL OR TELEPHONE MANHOLE TO FG AND CONSTRUCT CONCRETE COLLAR
- 7 ADJUST GAS VALVE TO FG AND CONSTRUCT CONCRETE COLLAR
- 8 ADJUST TELEPHONE MANHOLE TO FG AND CONSTRUCT CONCRETE COLLAR (BY OTHERS)

APPROVED FOR CONSTRUCTION  
*Matthew D. Meyer* 08/20/12  
LVVWD ENGINEERING SERVICES MANAGER DATE  
PROJECT NO. 116912

GENERAL NOTE:  
1. LENGTH OF ASPHALT PATCH SHOWN ON THE DRAWINGS IS TO THE CENTER OF THE ASPHALT PATCH UNLESS OTHERWISE NOTED.  
2. ALL CONSTRUCTION ACTIVITIES WILL BE PERFORMED WITHIN CITY OF LAS VEGAS RIGHT-OF-WAY.

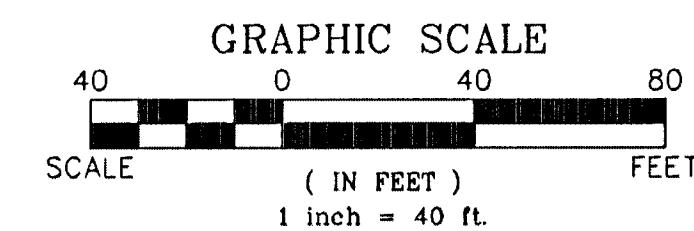

|                                                           |  |                                                                      |  |
|-----------------------------------------------------------|--|----------------------------------------------------------------------|--|
| DEPARTMENT OF OPERATIONS AND MAINTENANCE                  |  | DEPUTY DIRECTOR OF OPERATIONS AND MAINTENANCE:<br>JERRY WALKER, P.E. |  |
| DESIGNED BY: MDW                                          |  | DATE: 8/1/12                                                         |  |
| DRAWN BY: JAS                                             |  |                                                                      |  |
| CHECKED BY: MDW                                           |  |                                                                      |  |
| TITLE: BUFFALO DRIVE<br>CHARLESTON BLVD TO LAKE MEAD BLVD |  | SHEET: UT-05<br>18 of 27                                             |  |
| UTILITY PLAN<br>"BD" 95+50.00 TO "BD" 118+00.00           |  | BID NO. 107V5984                                                     |  |