

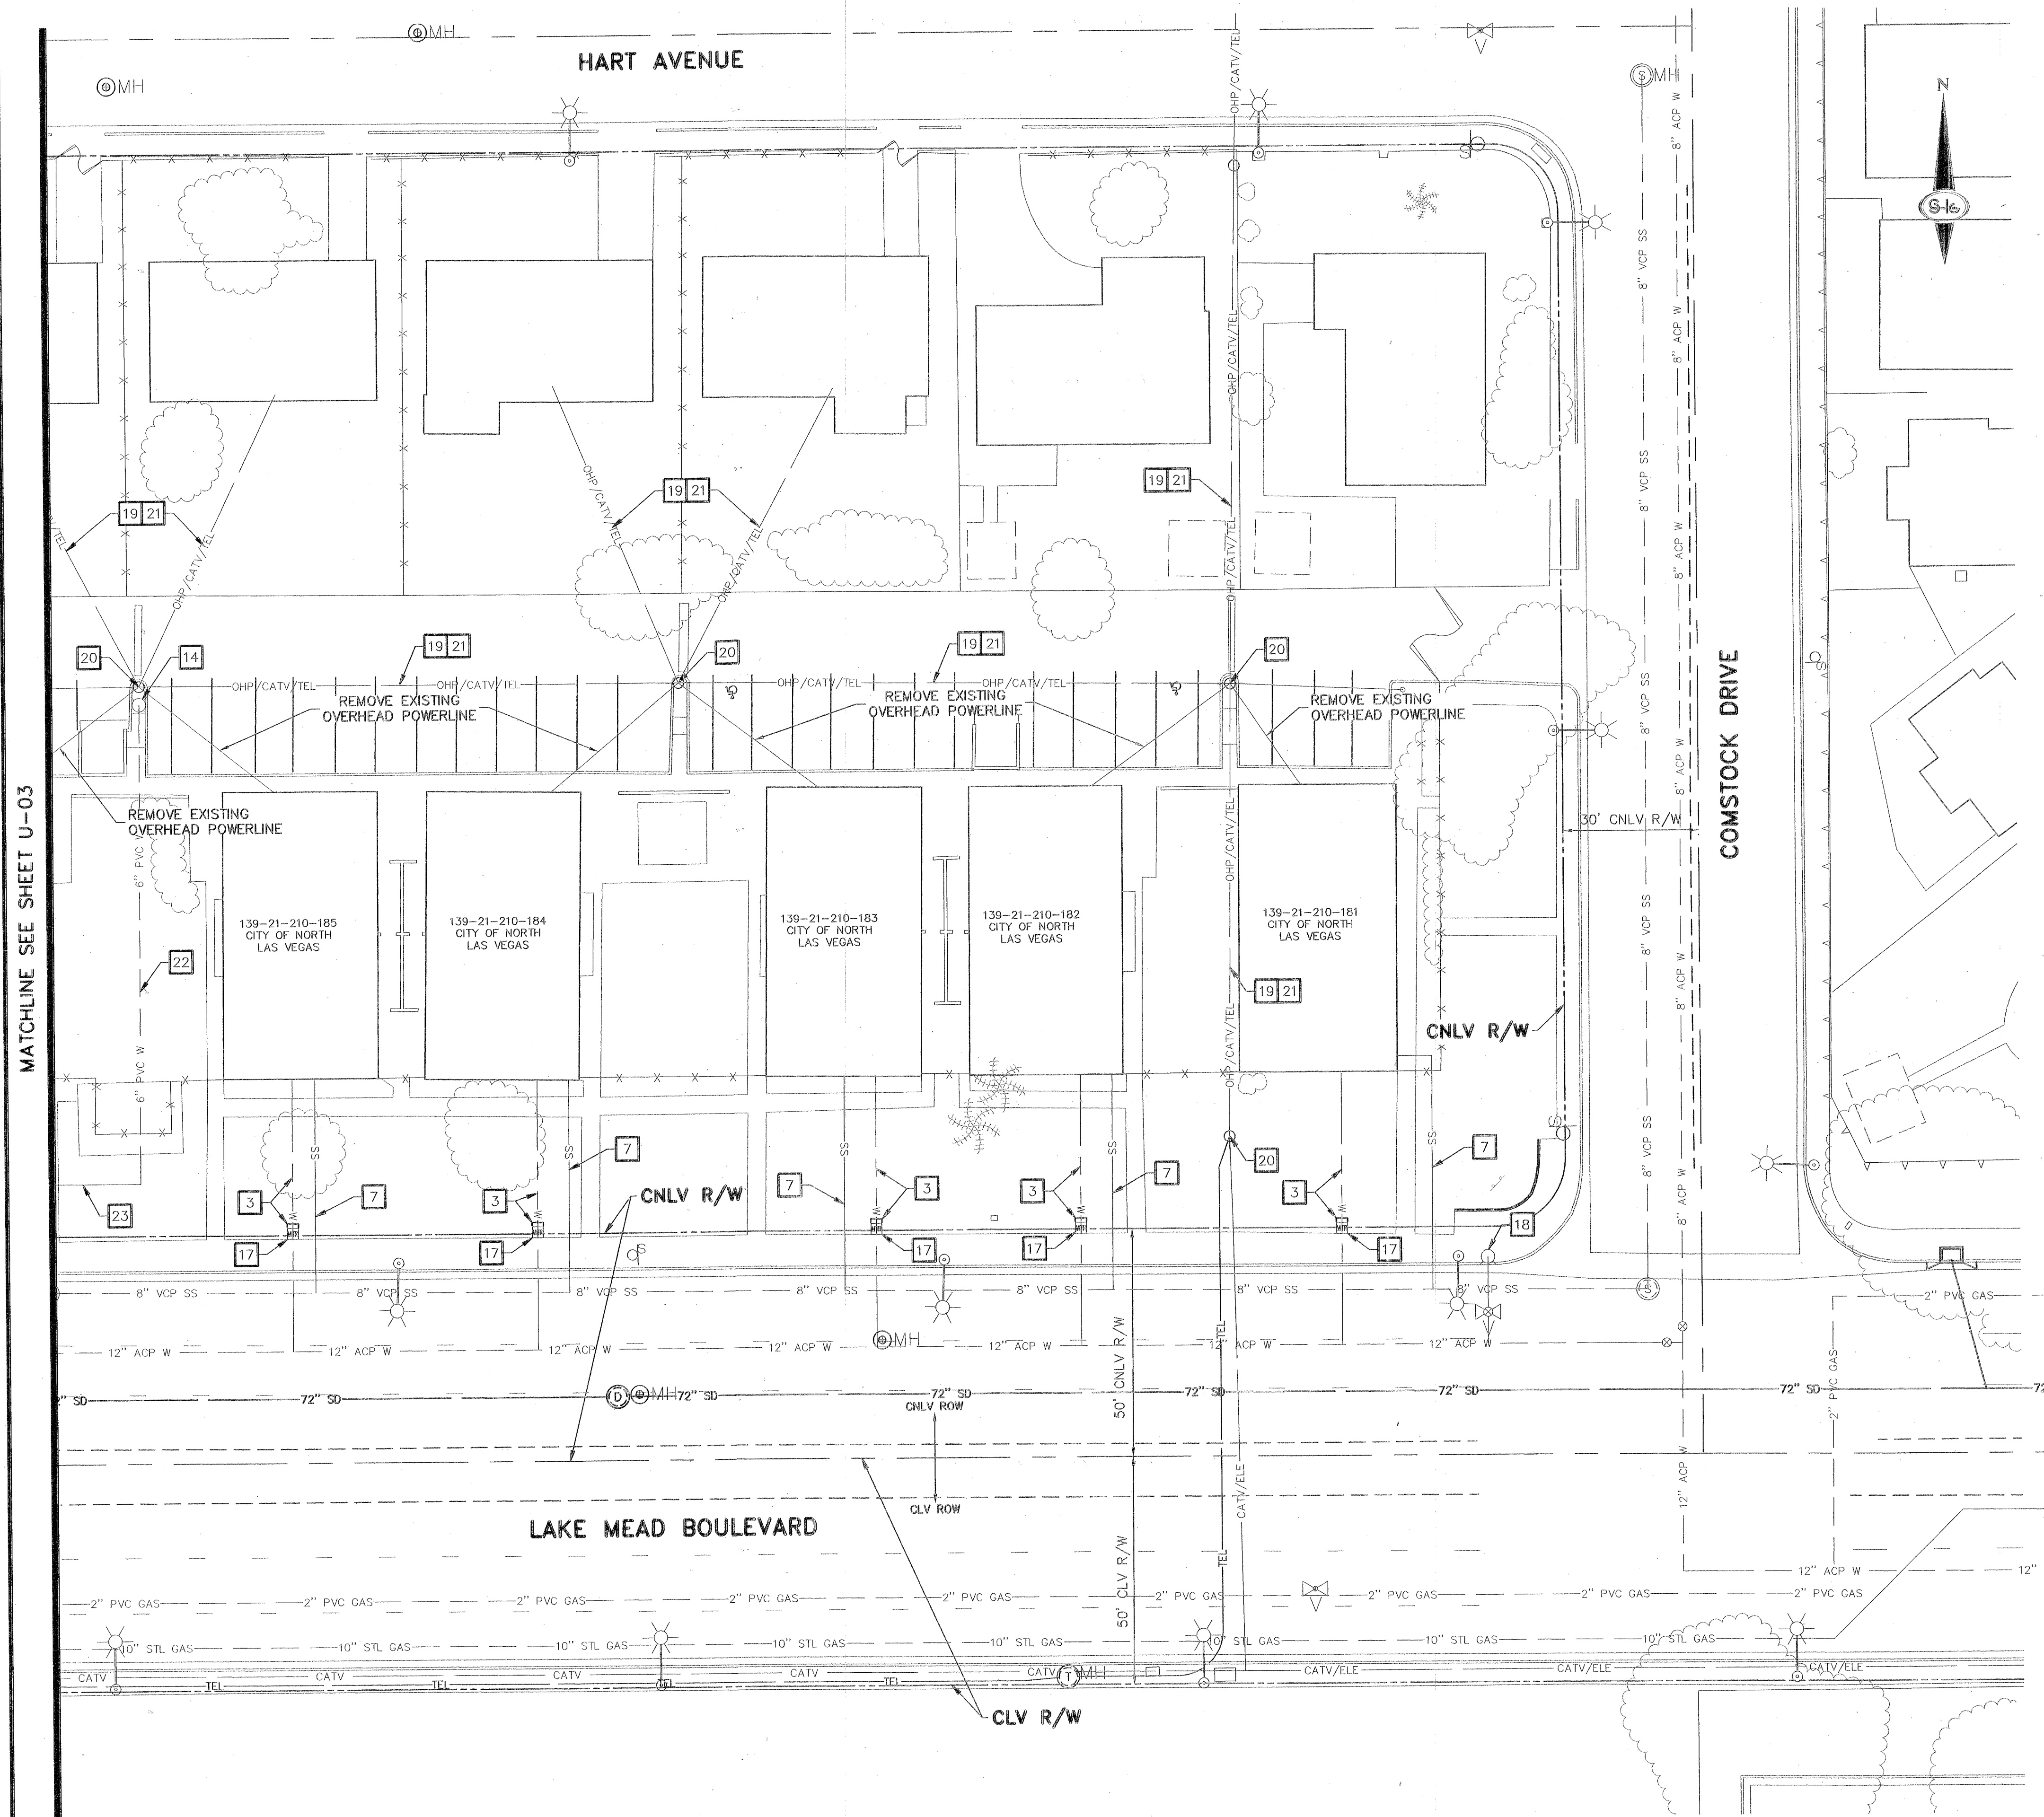
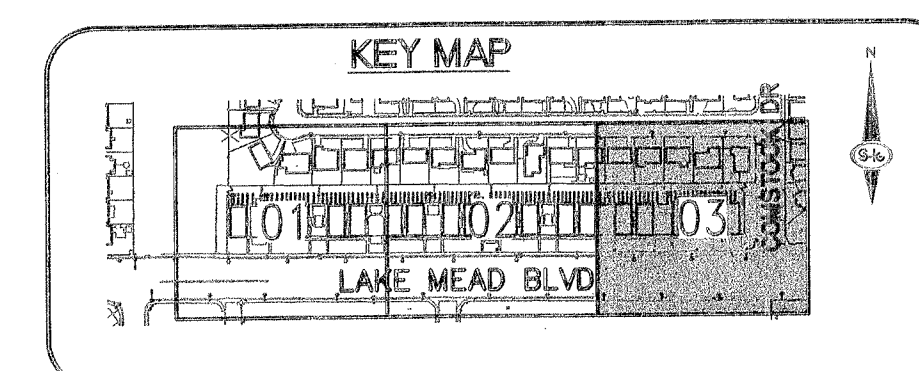


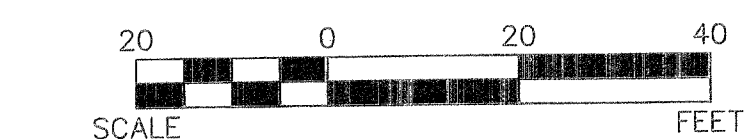

- ## UTILITY NOTES
- | | |
|----|---|
| 1 | NOT USED |
| 2 | NOT USED |
| 3 | CUT, CAP, AND REMOVE EXISTING WATER LATERAL, SEE DETAIL B, SHEET D-01 |
| 4 | NOT USED |
| 5 | REMOVE AND SALVAGE WATER VALVE |
| 6 | NOT USED |
| 7 | REMOVE EXISTING SANITARY SEWER LATERAL, INSTALL AND SEAL CAP WYE AT MAINLINE. |
| 8 | NOT USED |
| 9 | NOT USED |
| 10 | NOT USED |
| 11 | NOT USED |
| 12 | NOT USED |
| 13 | REMOVE EXISTING 8-INCH DOUBLE CHECK DETECTOR |
| 14 | REMOVE FIRE HYDRANT ASSEMBLY |
| 15 | NOT USED |
| 16 | NOT USED |
| 17 | PROTECT WATER METER IN PLACE |
| 18 | PROTECT FIRE HYDRANT IN PLACE |
| 19 | PROTECT OVERHEAD POWER LINE IN PLACE |
| 20 | PROTECT POWER POLE IN PLACE |
| 21 | PROTECT OVERHEAD CATV LINE IN PLACE |
| 22 | REMOVE 6" PVC WATER LINE |
| 23 | REMOVE 8" PVC WATER LINE |
| 24 | ABANDON WATER VALVE PER UDACS SECTION 2.11.07 |

- ### GENERAL NOTES
1. CLEAR, GRUB, AND REMOVE ALL VEGETATION AND LANDSCAPING WITHIN THE DEMOLITION AREA.
 2. FREE HYDRANTS SHALL REMAIN IN OPERATION UNTIL THE SITE HAS BEEN COMPLETELY DEMOLISHED AND CLEARED.
 3. CONTRACTOR SHALL REMOVE ALL EXISTING COX COMMUNICATION AND CABLELINK RINGS AND SERVICE LINE, CUT SERVICE LINE.
 4. CONTRACTOR SHALL COORDINATE WITH NVE FOR THE DEACTIVATION AND REMOVAL OF NVE FACILITIES.
 5. DEMOLITION SHALL BE ACCORDANCE WITH SPECIFICATIONS.
 6. THE EXISTING UTILITIES SHOWN ON THE DRAWINGS IS APPROXIMATE AND FROM THE BEST AVAILABLE INFORMATION, CONTRACTOR SHALL VERIFY LOCATION OF ALL EXISTING UTILITIES PRIOR TO REMOVAL OR ABANDONMENT.
 7. SEE R-SHEETS FOR DEMOLITION PLANS.

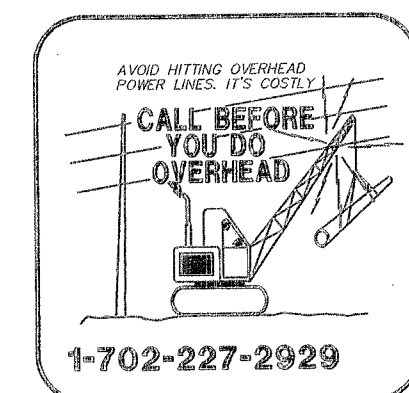

(DRAWING TITLE) (PROJECT TITLE)		UTILITY PLAN BUENA VISTA SPRINGS II DEMOLITION CITY OF NORTH LAS VEGAS				SCALE: 1"=20' DESIGN: MDM DRAWN: JAS CHECKED: MDM APPROVED:		REVISIONS NO. DESCRIPTION DATE BY	
						DATE: 05-15-13			