



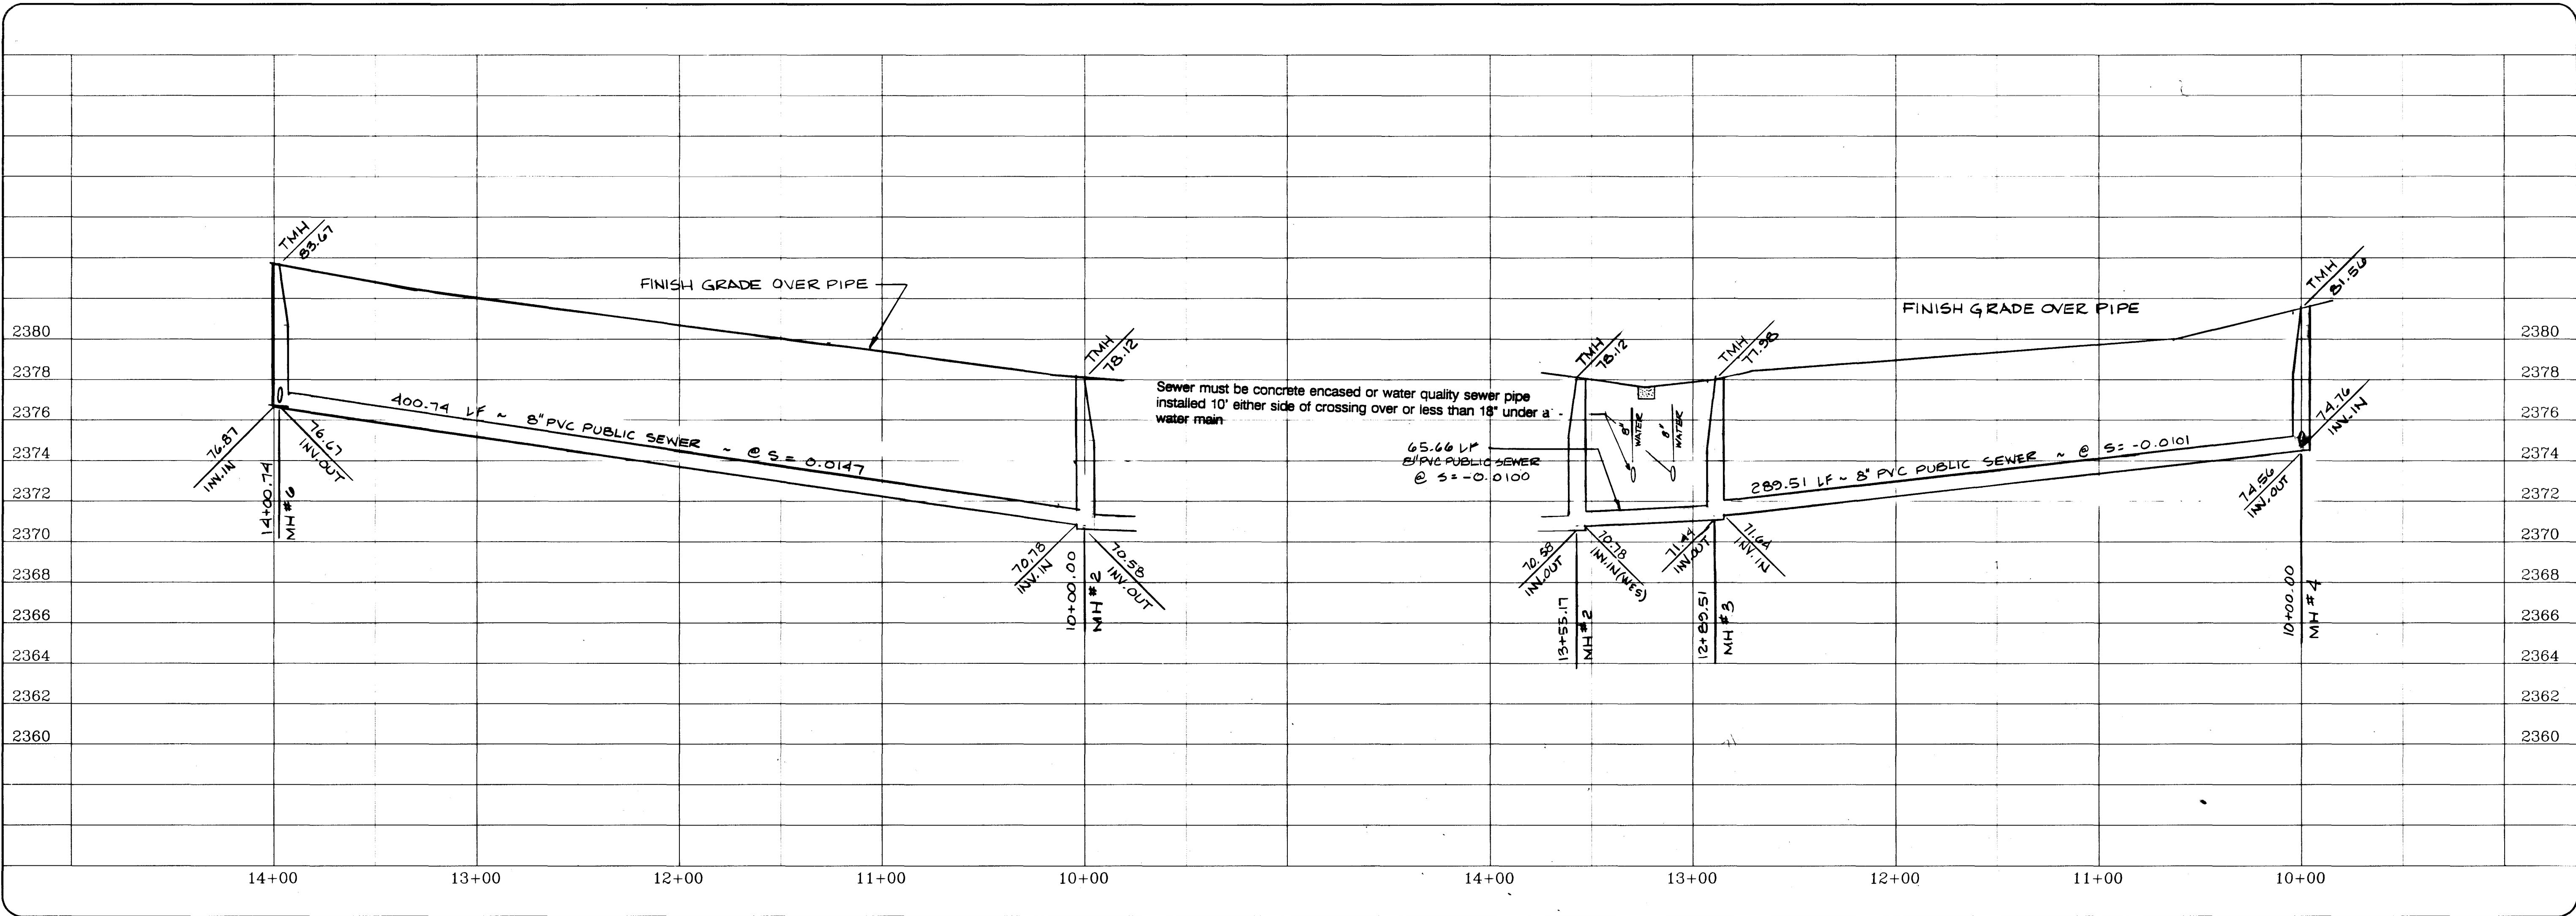



REV	DATE	BY	REVISION
4			
3			
2			
1			

KOKOPPELLI L.L.C. 3645 W. OQUENDO ROAD SITE 200 LAS VEGAS, NV 89110 (702) 798-9039	CITY OF LAS VEGAS	CONSULTING ENGINEERS • PLANNERS • LAND SURVEYORS 2727 SOUTH RAINBOW BOULEVARD LAS VEGAS, NEVADA 89102-5148 PHONE (702) 873-7550 FAX (702) 362-2597
---	-------------------	--

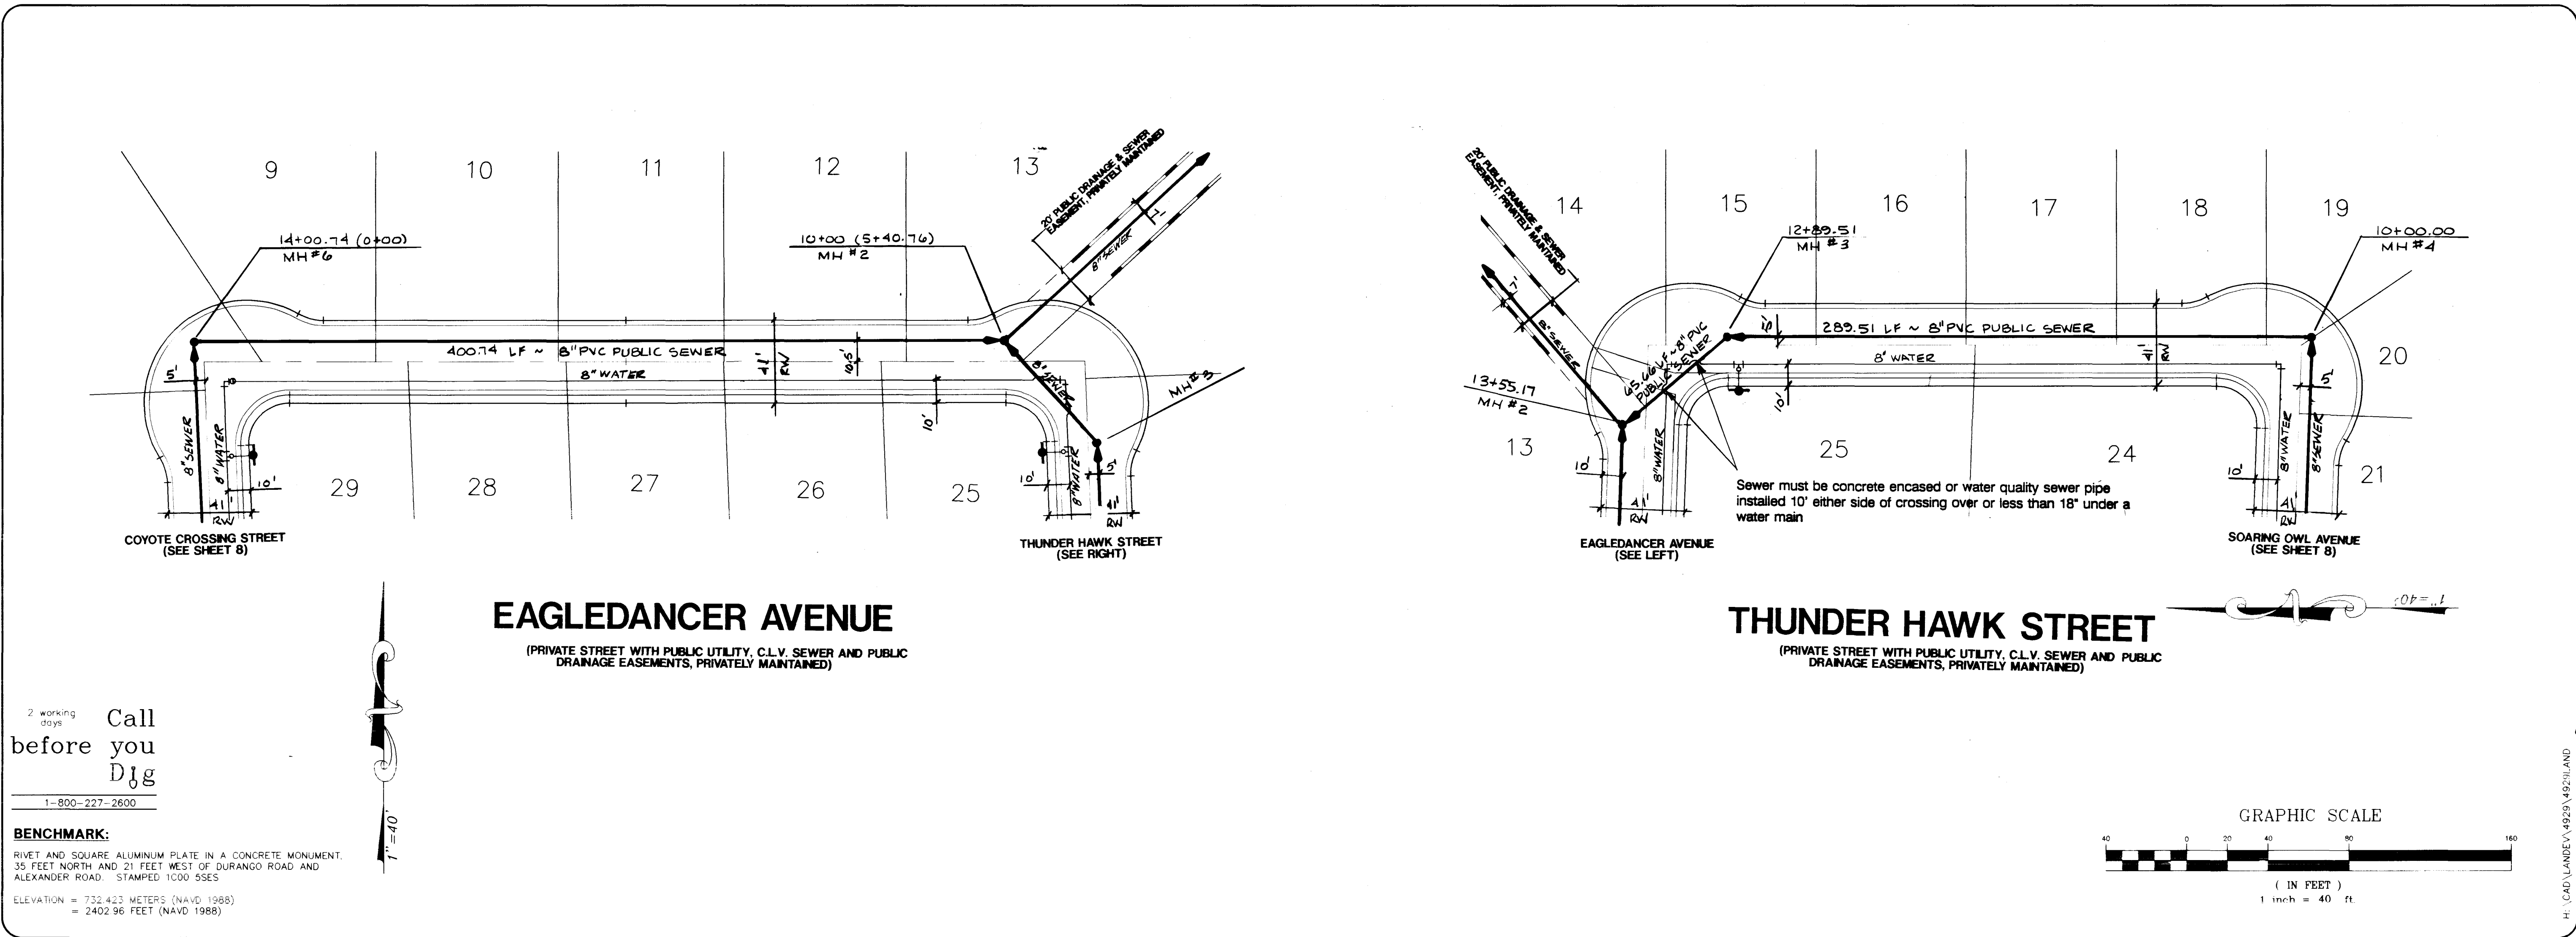


SEWER PLAN AND PROFILE	
EAGLEDANCER AVENUE - THUNDER HAWK STREET	
PROJECT ALEXANDER 10	

WD NO.	4929
BY	CZP
DATE	4-3-96
SCALE	HORIZ 1"=40'
VERT	1"=4'
SHEET	7
OF	10
SHEETS	

 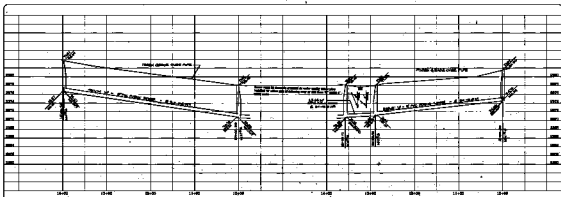

EAGLEDANCER AVENUE

 

THUNDER HAWK STREET

Call
before you
dig

800-4-A-SEWER
www.800-4-a-sewer.com



DATE: 10/10/10
DRAWN BY: J. L. HARRIS & SONS, INC.
CHECKED BY: J. L. HARRIS & SONS, INC.
ALL DATA, MEASUREMENTS AND NOTES ARE TO BE USED IN CONJUNCTION WITH THE STANDARD SPECIFICATIONS FOR HIGHWAY CONSTRUCTION, EDITION 1983, AS AMENDED.

SEWER PLAN AND PROFILE
EAGLEDANCER AVENUE - THUNDER HAWK STREET
ALEXANDER 30



SCALE
1" = 100'
1" = 100'
1" = 100'