


GRUZEN & SILVERMAN
AND
KEITH FARRIS & ASSOCIATES
architecture
planning
interiors
844 E. Sahara Las Vegas, NV. (702) 737-7444

JAMES H. GLOVER
AND ASSOCIATES
consulting engineers
Las Vegas, Nevada

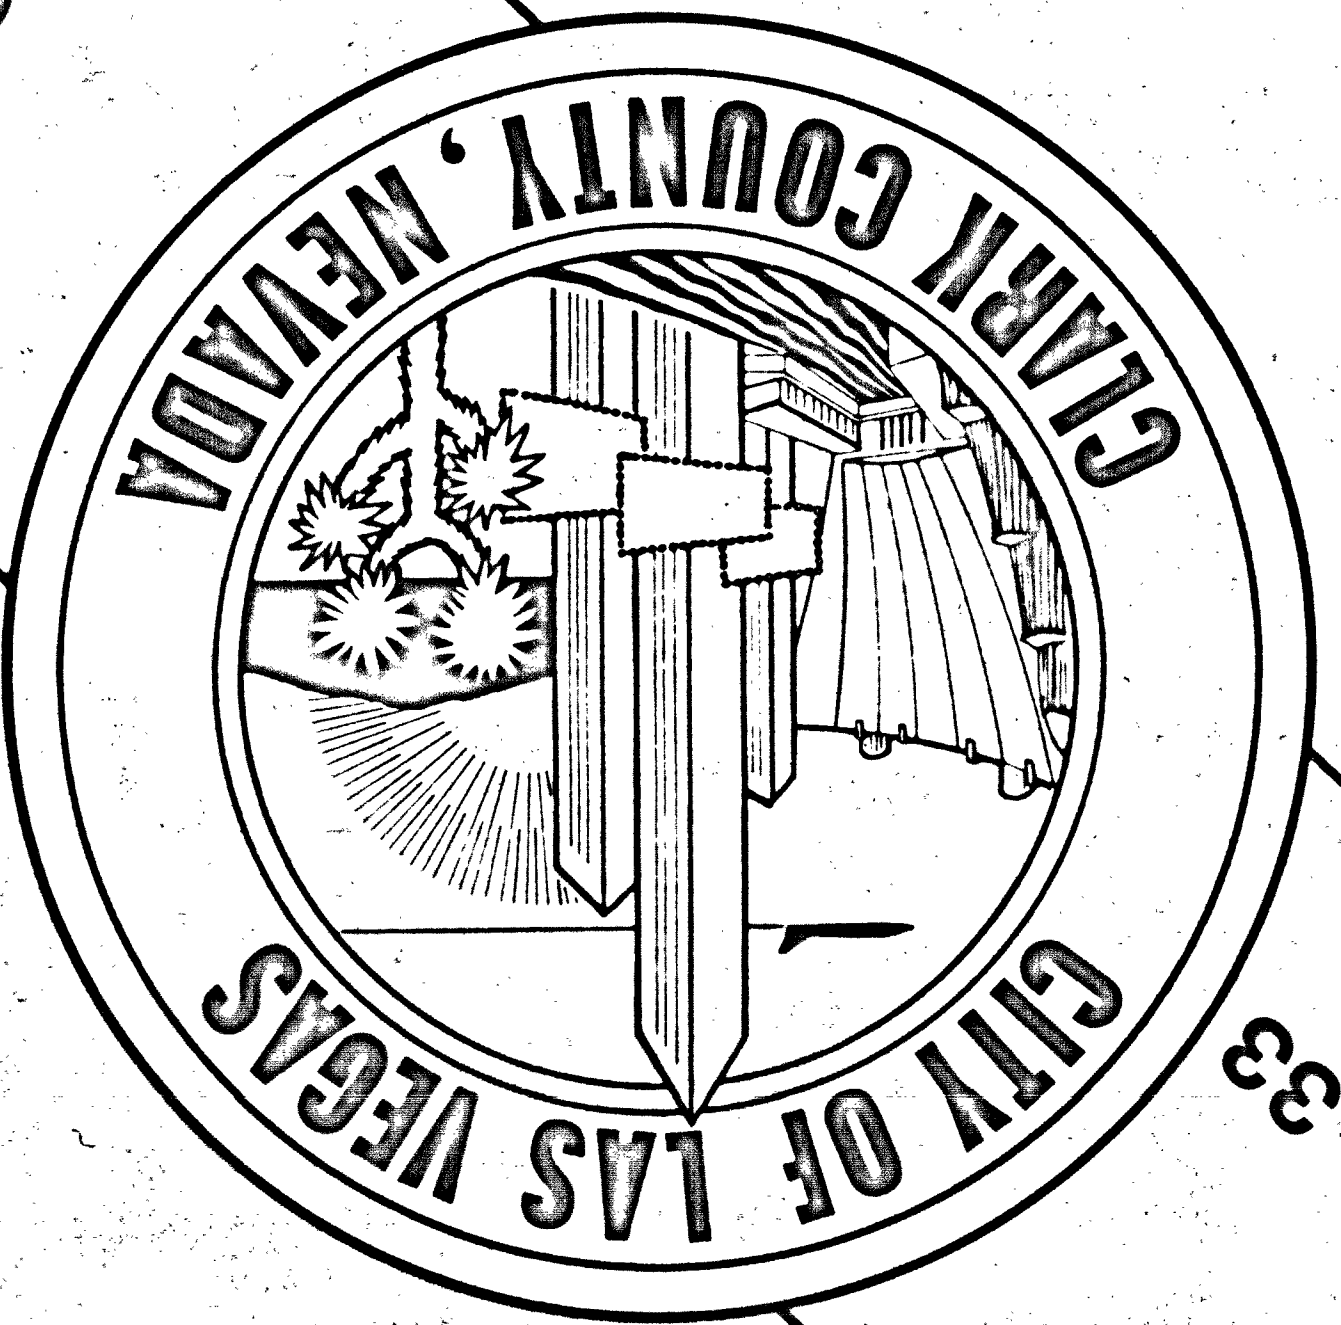



bid no. 81.3550.33

City of Las Vegas
Clark County, NV.

Mayor:
Bill Briare

Ron Lurie
Paul J. Christensen
Roy Wooster
Al Levy

CITY JAIL ANNEX RENOVATION

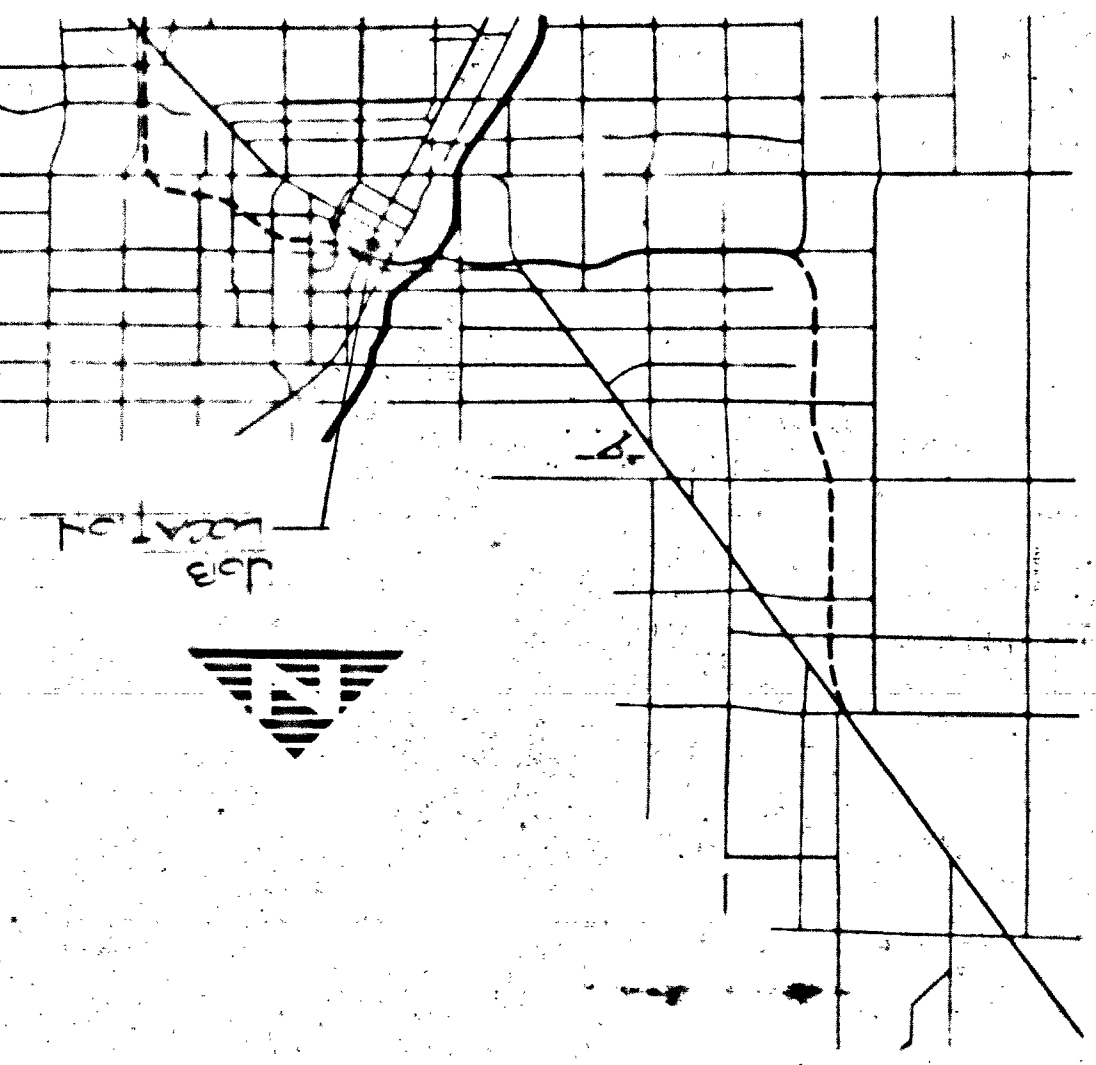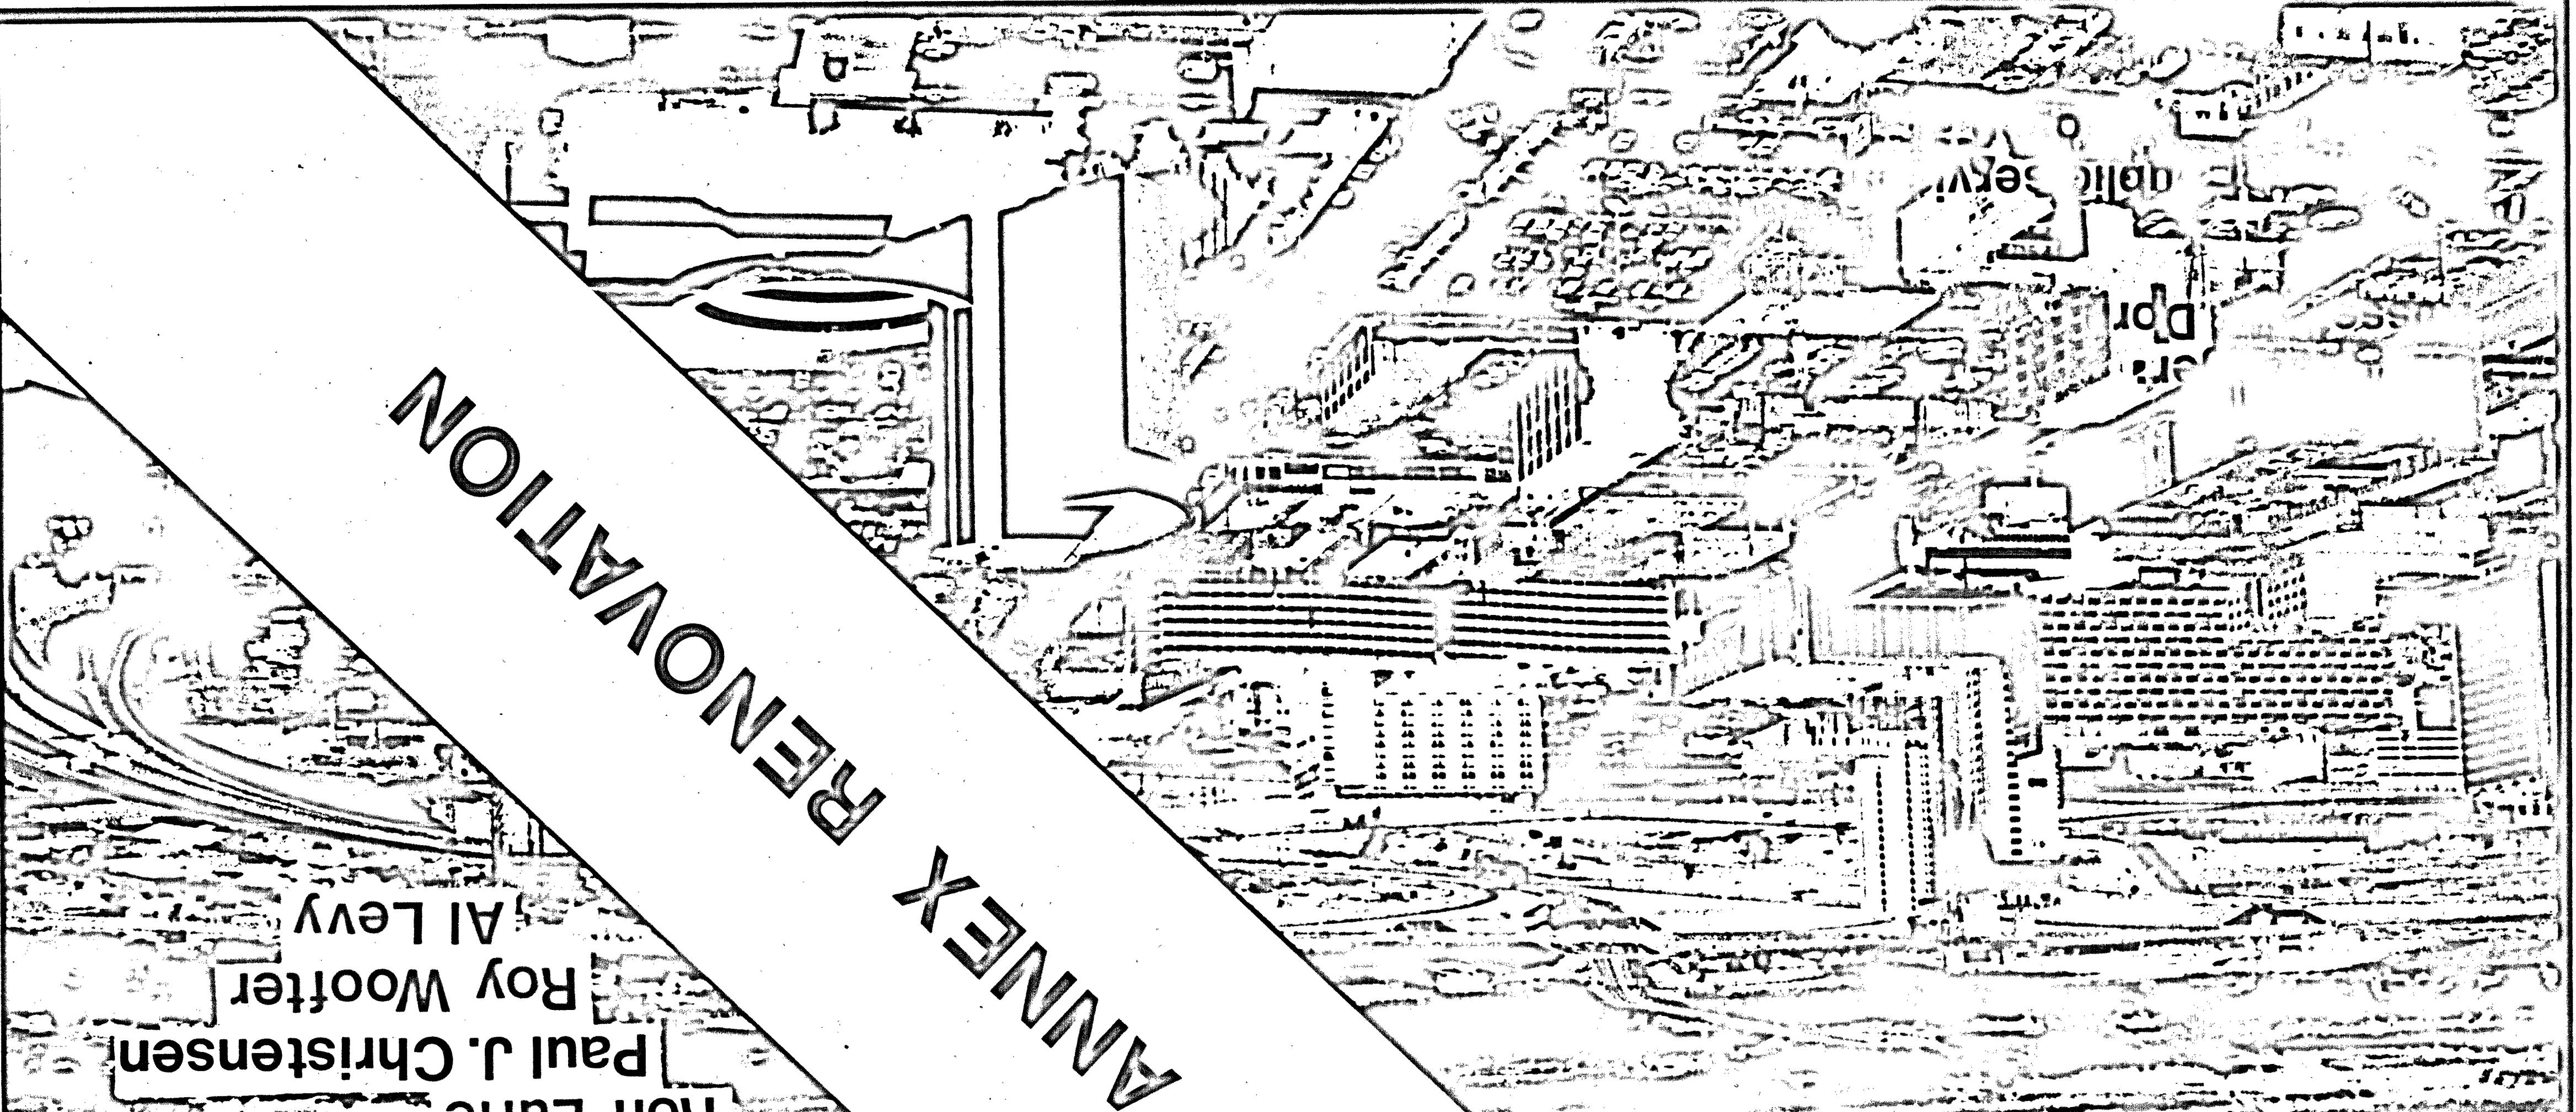

location map

index of sheets	
no.	description
A-1	TITLE SHEET & SHEET INDEX
A-2	WORK SEQUENCE PLAN & SCHEDULE
A-3	FLOOR PLAN
A-4	DOOR SCHEDULE & DOOR DETAILS
A-5	ROOM FINISH SCHEDULE & MISCELLANEOUS DETAILS
A-6	MISCELLANEOUS DETAILS
M-1	MECHANICAL
M-1	AIR CONDITIONING FLOOR PLAN
M-2	AIR CONDITIONING DETAILS
P-1	PLUMBING
P-1	PLUMBING FLOOR PLAN
P-2	PLUMBING DETAILS
E-1	ELECTRICAL
E-1	LIGHTING PLAN
E-2	POWER PLAN
E-3	DETAILS
E-4	ELEMENTARY WIRING DIAGRAMS
E-5	ELEMENTARY WIRING DIAGRAMS
E-6	ELEMENTARY DIAGRAMS
E-7	DETAILS
E-8	DOOR CONTROLS
E-9	RELAY WIRING DETAILS
E-10	RELAY WIRING DETAILS

agency		approved date	
Director of Comm. Plan. & Dev.		6-1-81	
LVPD Director of Detentions		6-1-81	
Director of Fire Services		6-1-81	
Director of Arch. Serv. & Proj. Control		6-1-81	
Chief of Building & Safety		6-1-81	
Chief of Electrical Services		6-1-81	
Chief of Quality Control		6-1-81	
Chief of Engineering Design		6-1-81	
City Engineer		6-1-81	
Field Operator's Engineer		6-1-81	
Director of Public Services		6-1-81	
Deputy City Manager		6-1-81	
agency		approved date	
Southwest Gas Corporation	N/A		
Nevada Power Company	N/A		
Las Vegas Valley Water District	N/A		
Central Telephone Company	N/A		
date		drawing number	
MAY 26, 1981		A-1	
sheet 1 of 20			