
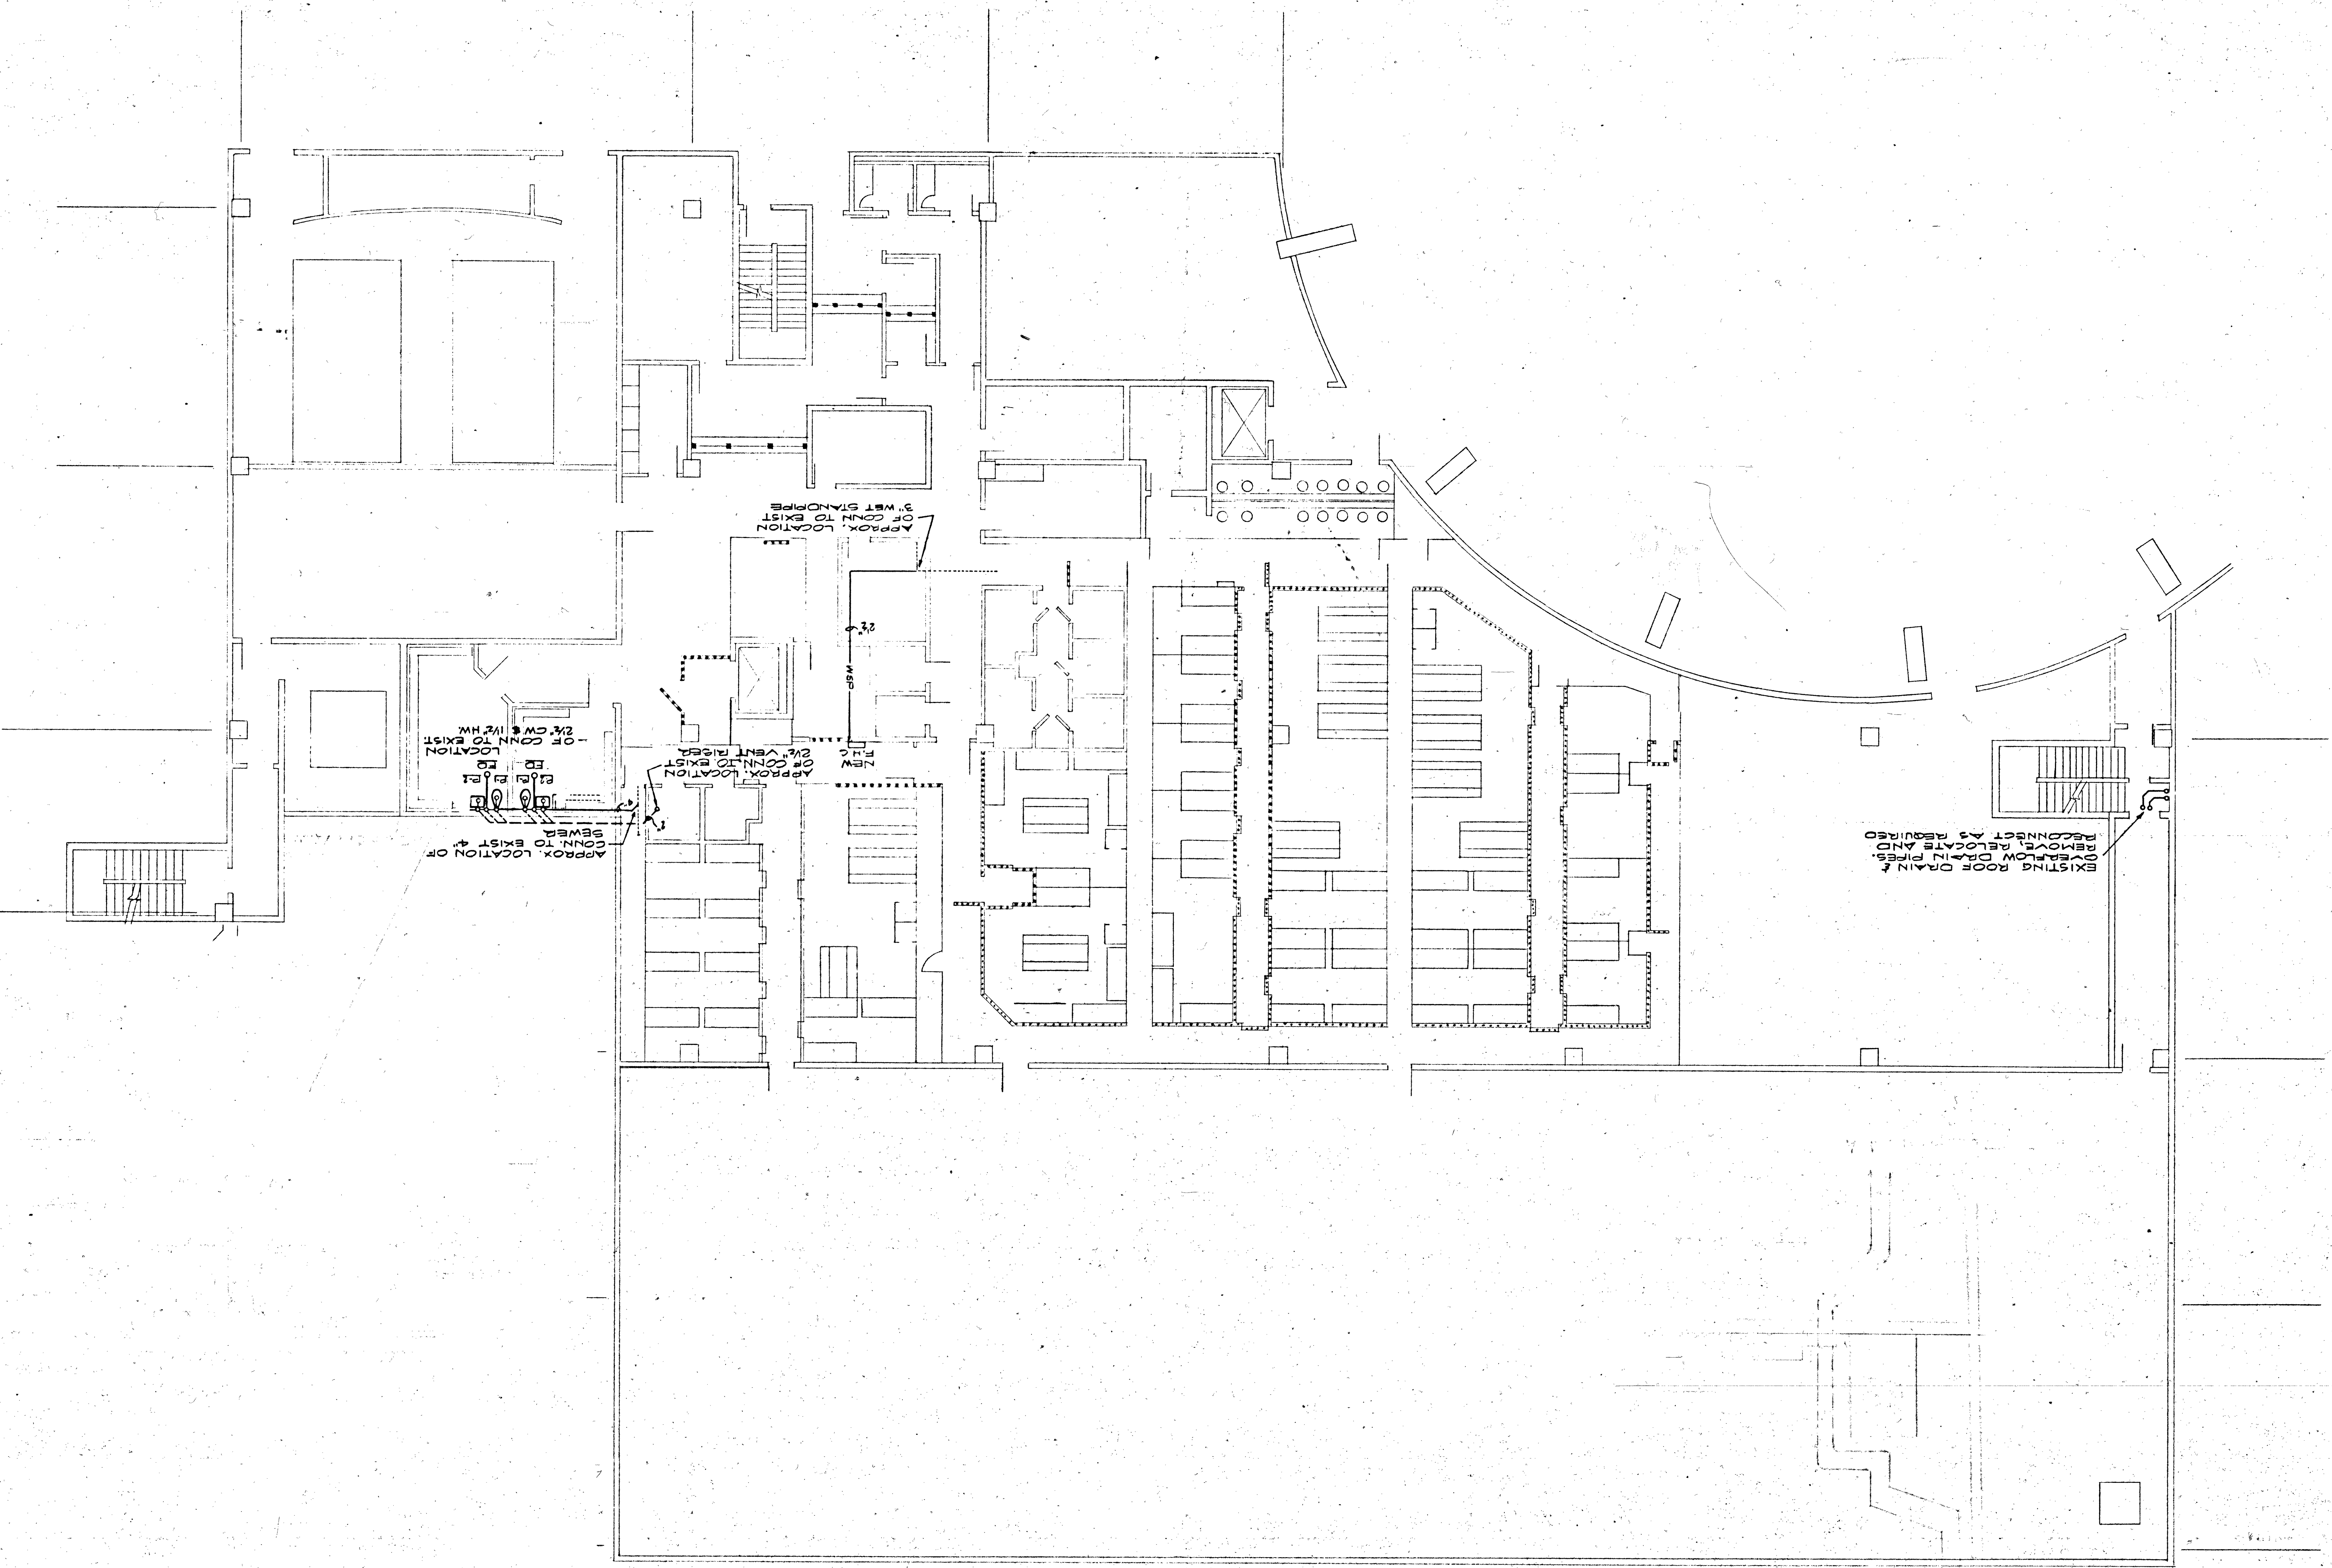


PLUMBING PLAN

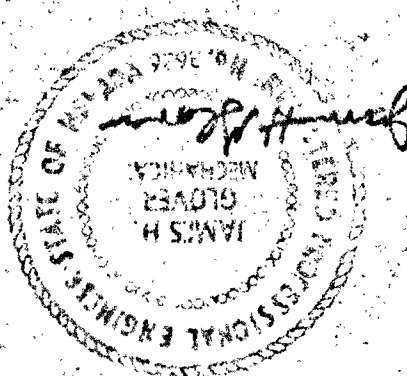

sheet no. P-1

checked by B.G.

drawn by B.G.

date 5-26-81

job no. 01098

sheet title: PLUMBING PLAN

FOR: CITY OF LAS VEGAS JAIL ANNEX RENOVATION

GRUZEN & SILVERMAN AND KEITH FARRIS & ASSOCIATES

architecture planning interiors

844 E. Sahara Las Vegas, NV (702) 737-7444

JAMES H. GLOVER AND ASSOCIATES

consulting engineers

Las Vegas, Nevada