



PLUMBING FIXTURE CONNECTION SCHEDULE									
SYMBOL	ITEM	CONNECTION SIZE (INCHES)					REMARKS		
		H.W.	C.W.	V.	TRAP	SOIL			
P-1	WATER CLOSET	-	1	2	-	4	FLUSH VALVE		
P-2	LAVATORY	1/2	1/2	1/2	3	1/2	WALL HUNG		

PLUMBING LEGEND		
ABBR.	SYMBOL	DESCRIPTION
S	_____	SOIL, WASTE OR SEWER
CW	_____	COLD WATER
HW	_____	HOT WATER
WSP	_____ WSP _____	WET STAND PIPE
V	_____	VENT
FD	_____ O _____	FLOOR DRAIN
EXIST.	_____	EXISTING PIPE

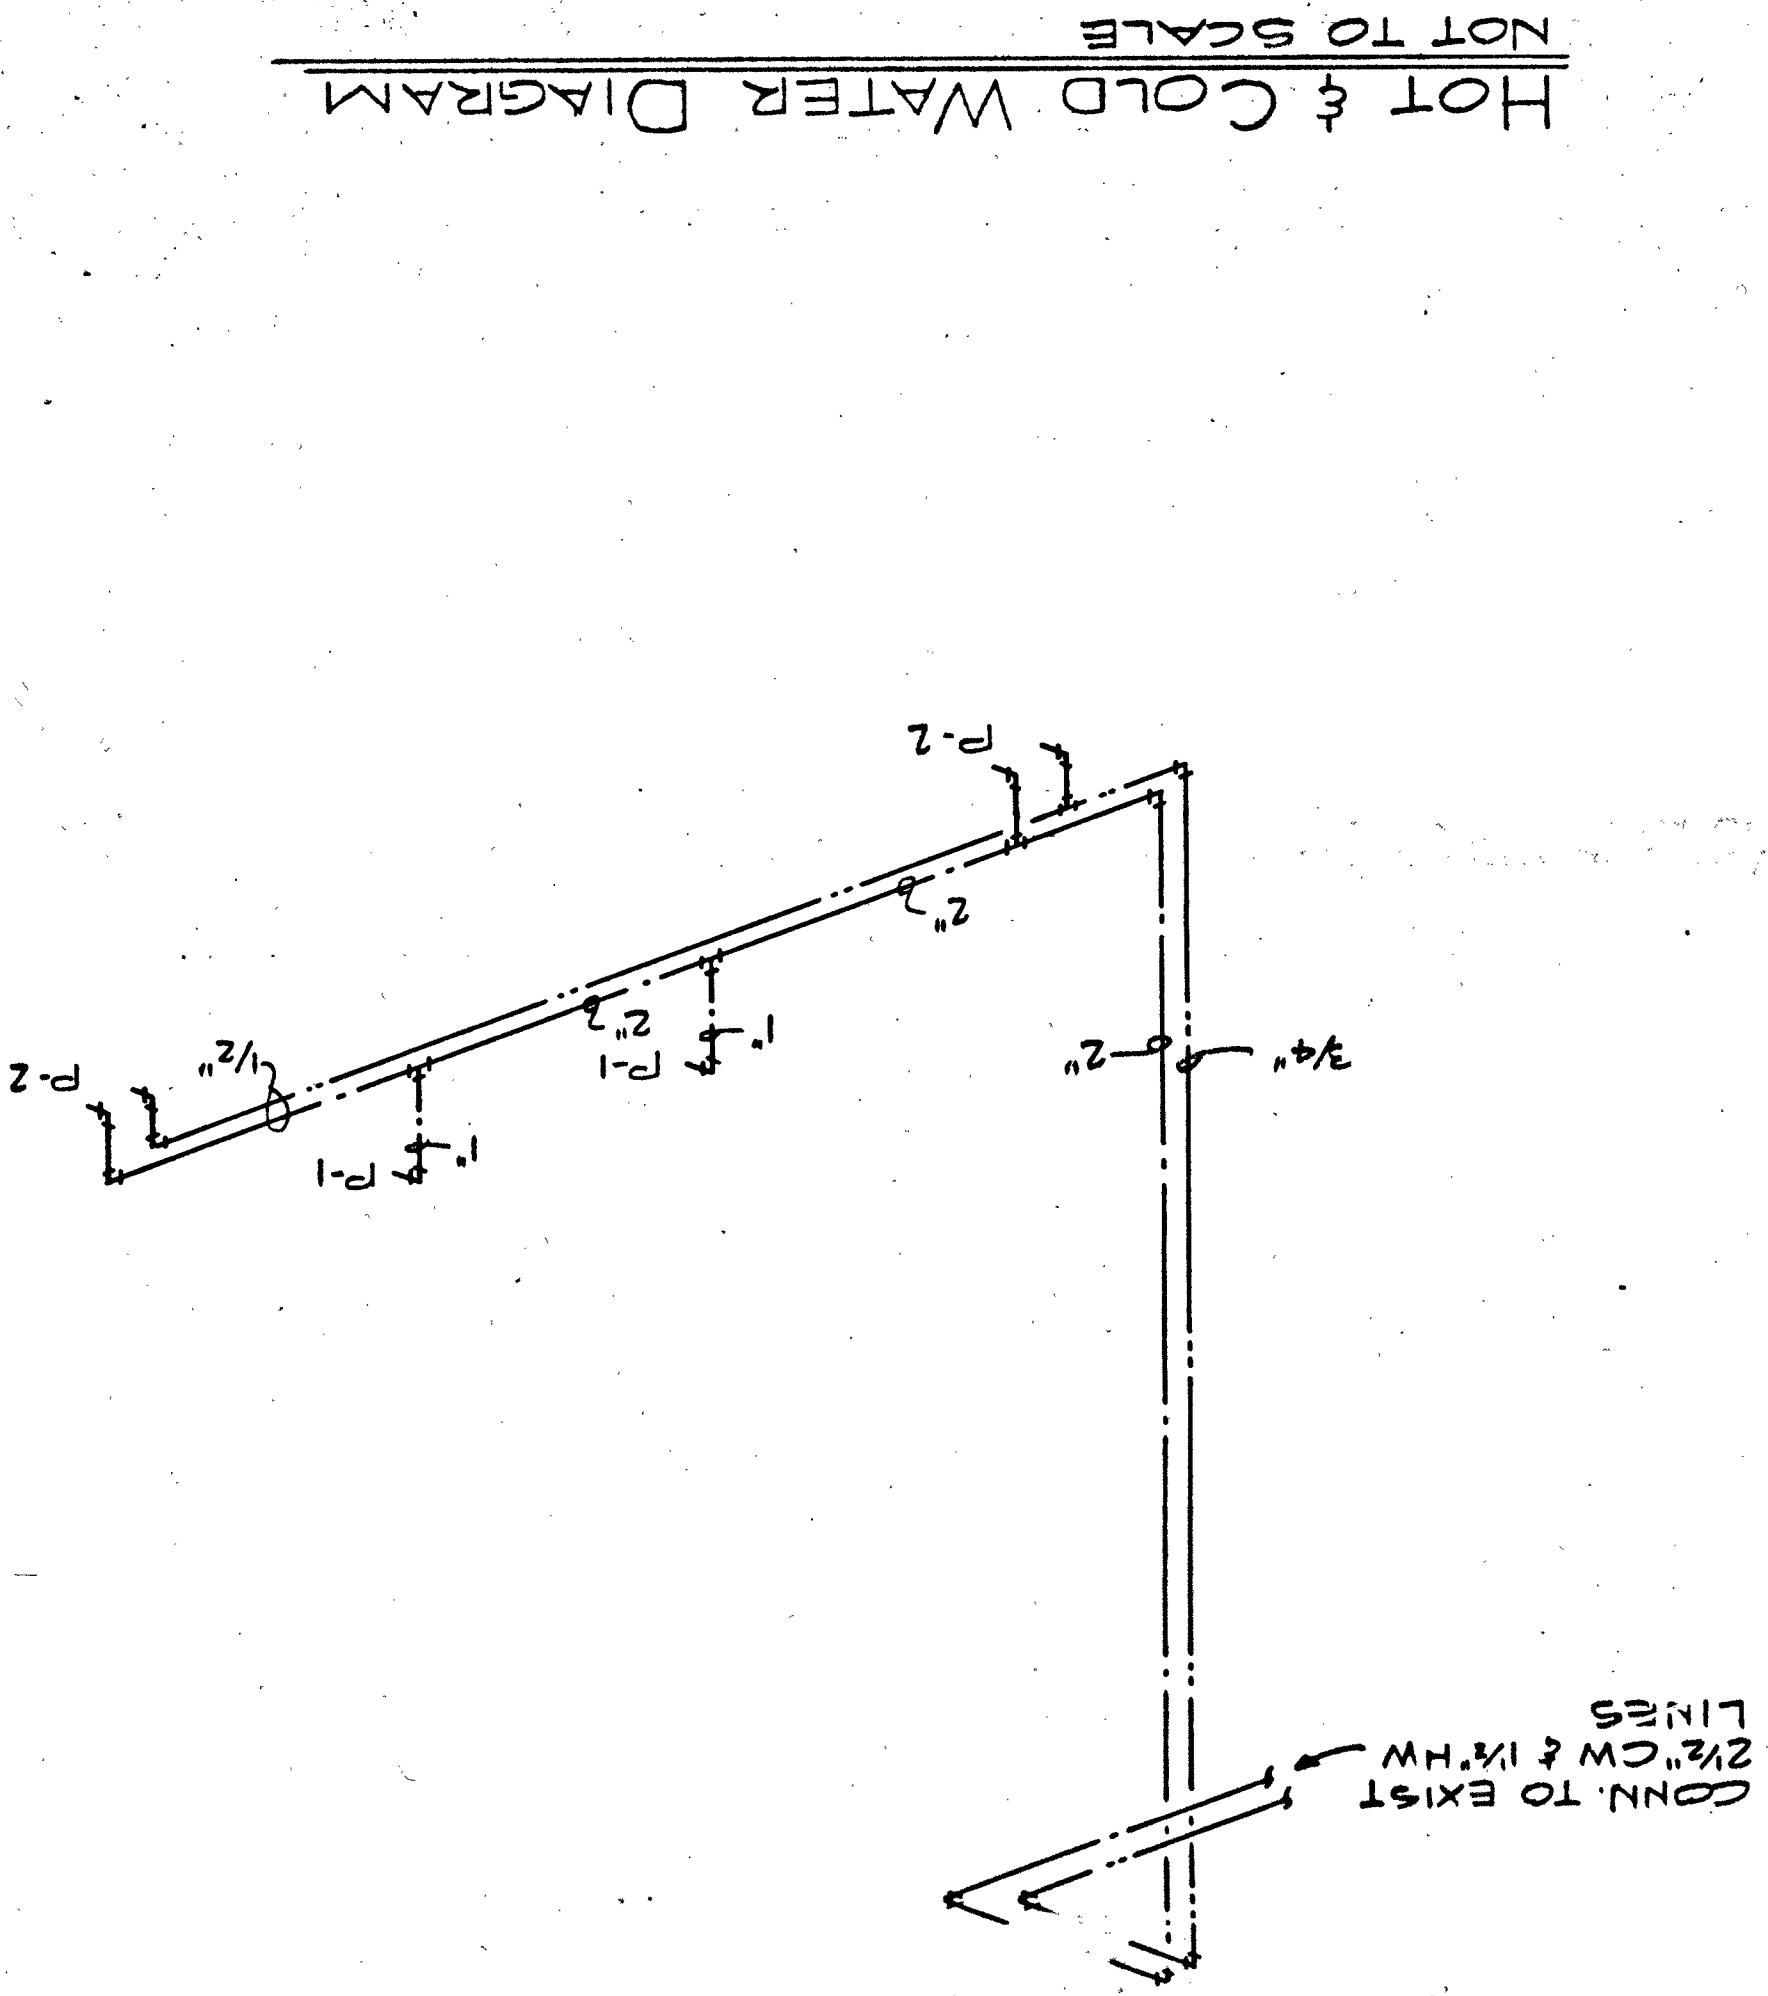


HOT & COLD WATER DIAGRAM
NOT TO SCALE

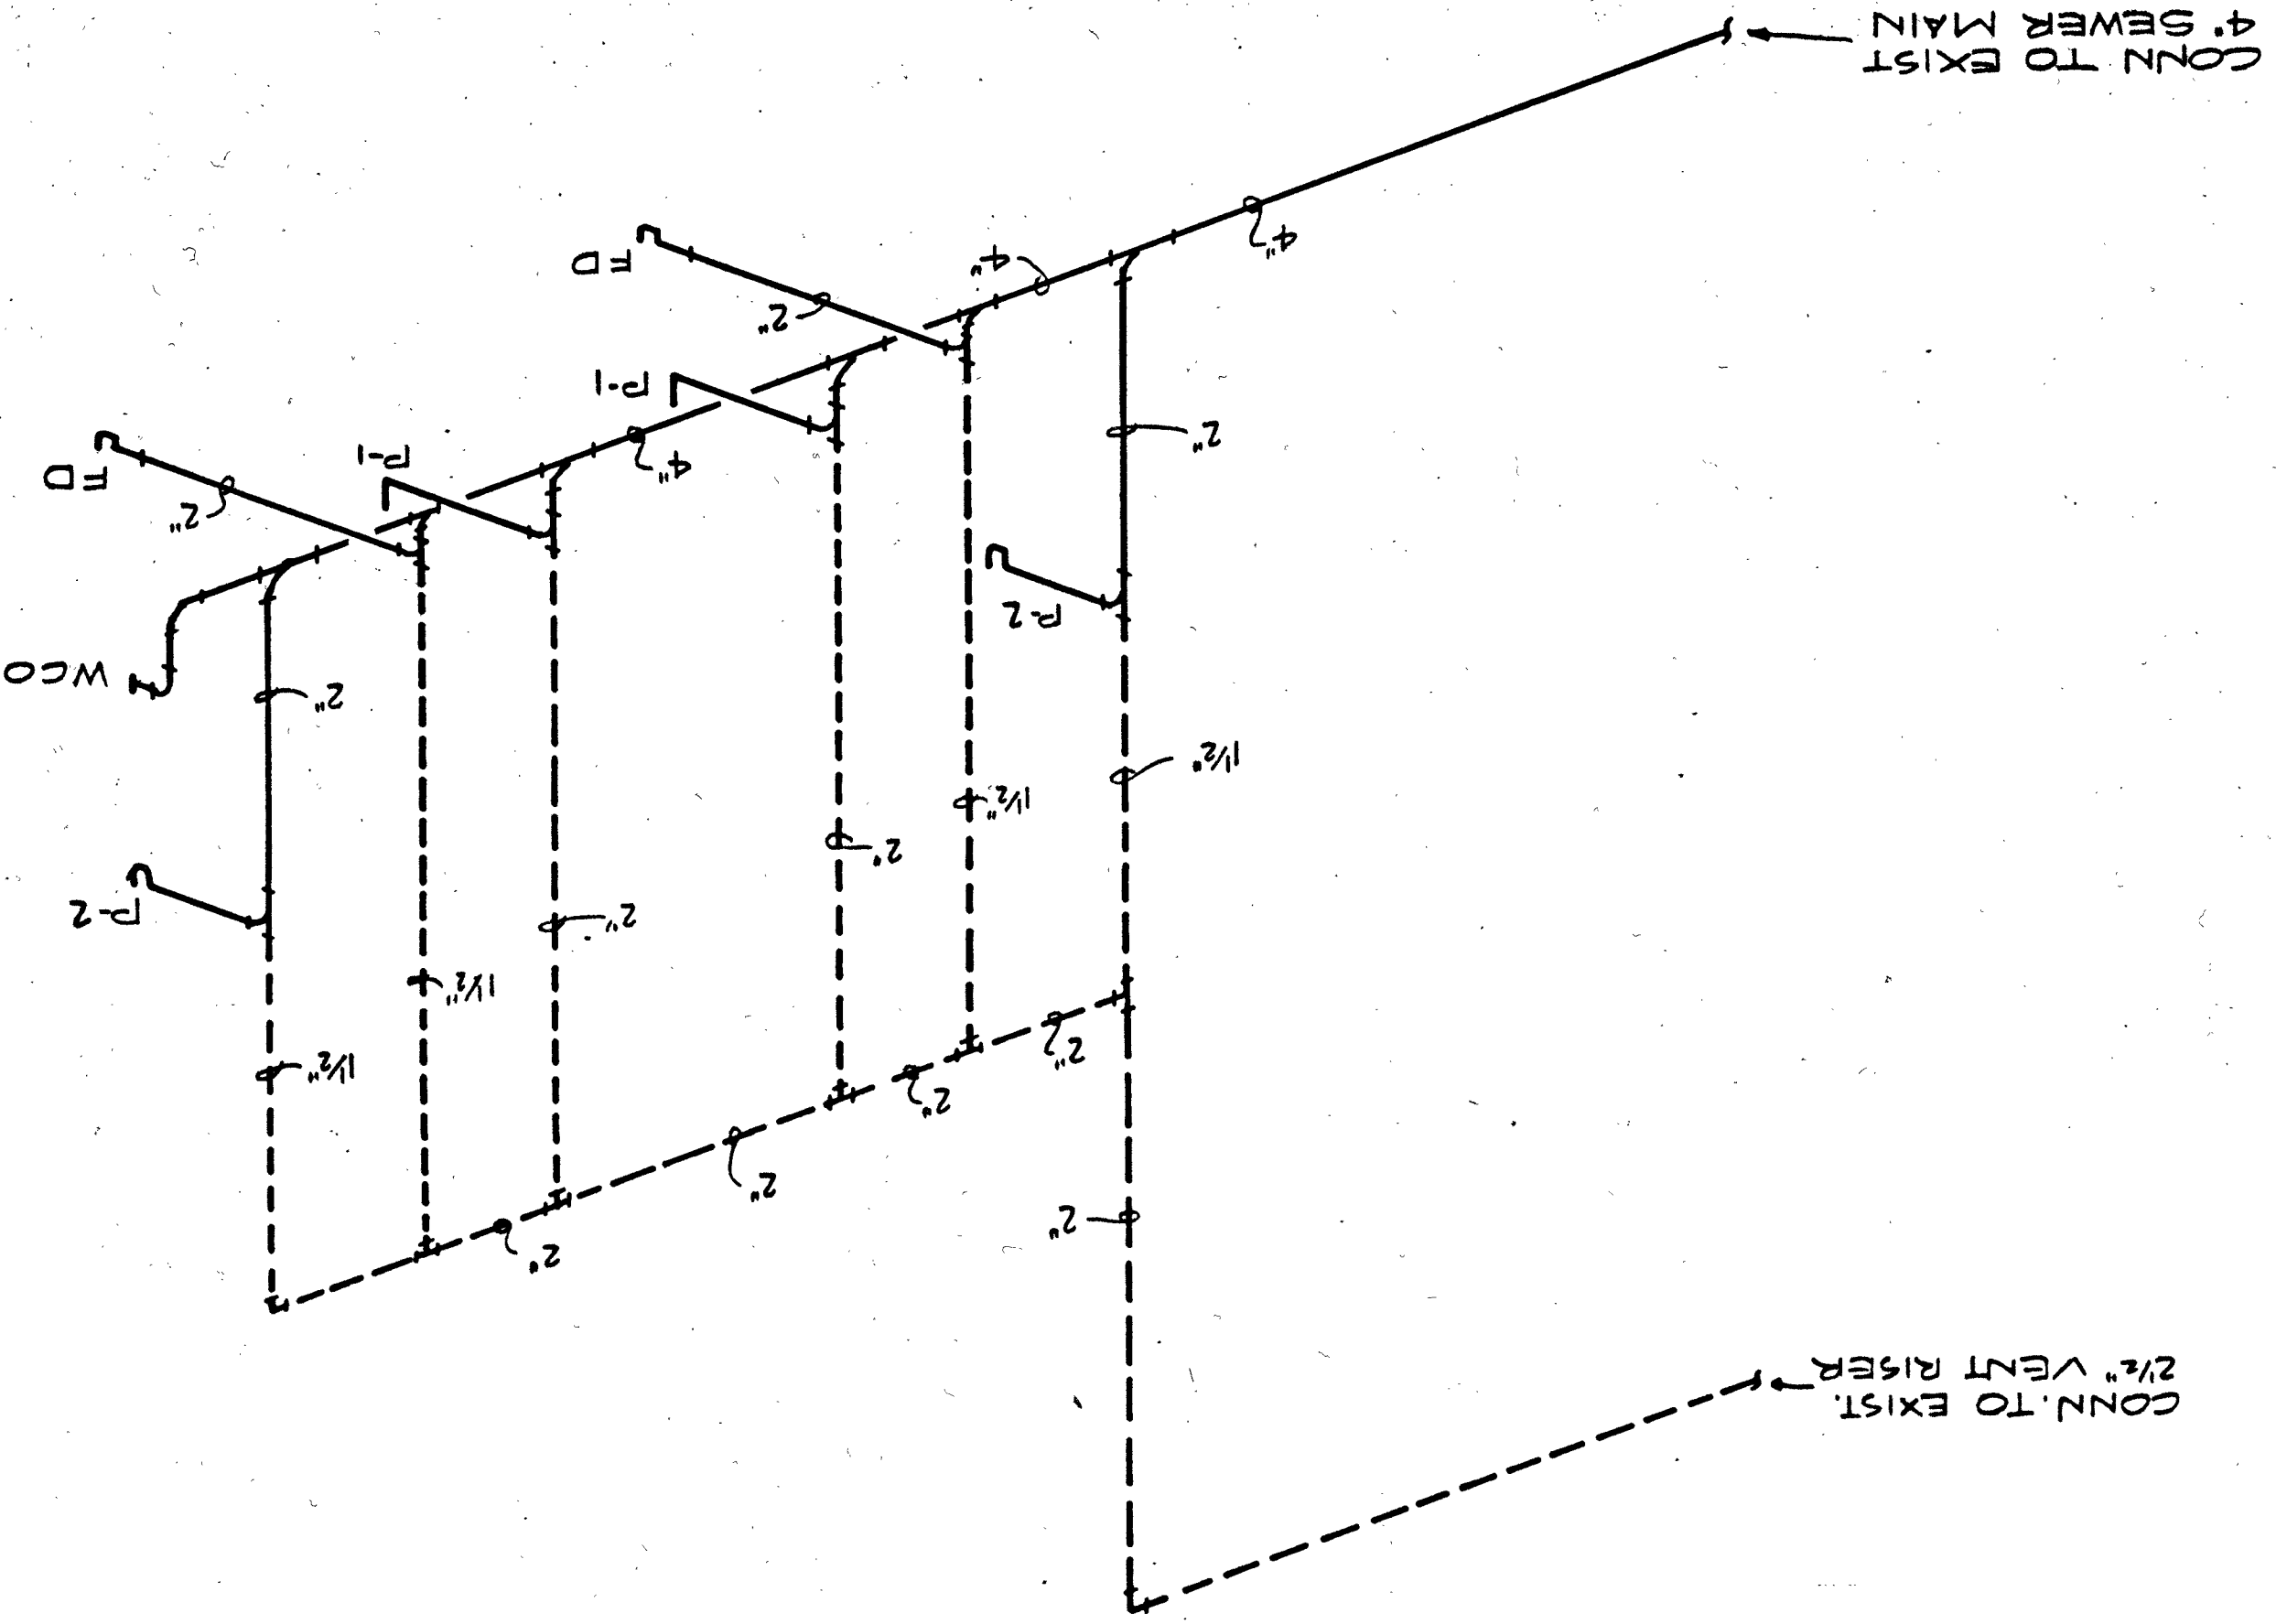

SOIL & VENT DIAGRAM
NOT TO SCALE

PLUMBING FIXTURES
P1 WATER CLOSET - ACORN NO 1693 FLOOR OUTLET ELONGATED 304 STAINLESS STEEL ROWL W/ INTERGRAL SEAT W/BACK SPUD ALL SEAMS SHALL BE WELDED & POLISHED WITH 2822. CONCEALED PUSH BUTTON PUSH VALVE WITH STOP VALVE & VACUUM BREAKER MOUNTED BEHIND PLOOR ACCESS PANEL.
P-2 LAVATORY - ACORN NO 1650 WALL HUNG 12 1/4" x 20" 304 STAINLESS STEEL SEAMS SHALL BE WELDED & POLISHED WITH 170-28 HIG LAVATORY VALVE & BURBLER W/ SCREW DRIVER STOPPS. 1770-1 DRAIN, 1771 ELBOW WASTE, 1773 P-TRAP W/ CLEANOUT
FIRE HOSE CABINET
POTTER-ROSEMER NO 1556 SURFACE MOUNTED WITH 100 FT 1 1/2" LINED HOSE TESTED TO 500 PSI & VARIABLE NOZZLE ASSEMBLY NO 2610, 2 1/2" FIRE DEPT. VALVE VERIFY THREAD PATTERN WITH FIRE DEPT. 10 LB ABC PORTABLE EXTINGUISHER NO 3010 AND TYPE C SOLID METAL DOOR W/ 1903 CYLINDER LOCK TO MATCH EXISTING KEY SYSTEM

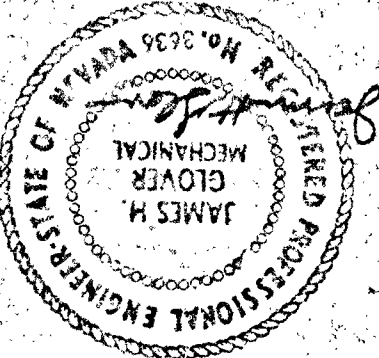

sheet title:
PLUMBING DETAILS
FOR: **CITY OF LAS VEGAS**
JAIL ANNEX RENOVATION

GRUZEN & SILVERMAN AND
KEITH FARRIS & ASSOCIATES
architecture planning interiors
844 E. Sahara Las Vegas, NV (702) 737-7444

JAMES H. GLOVER
AND ASSOCIATES
consulting engineers
las vegas, nevada

job no. 81098
date 5.26.81
drawn by B.G.
checked by B.G.

sheet no. P-2