


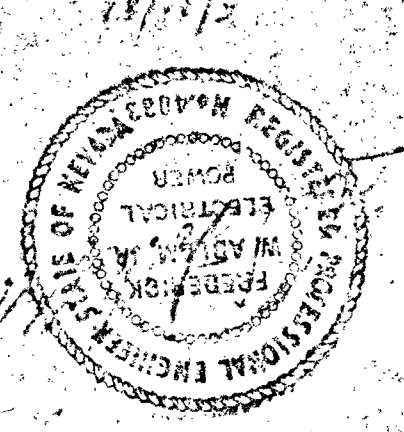



POLICE BUILDING PARTIAL 2ND LEVEL LIGHTING PLAN

SCALE: 1/8" = 1'-0"

GROUND LEVEL PLAN

NOT TO SCALE

SEE ARCHITECTURAL SHEET A-5

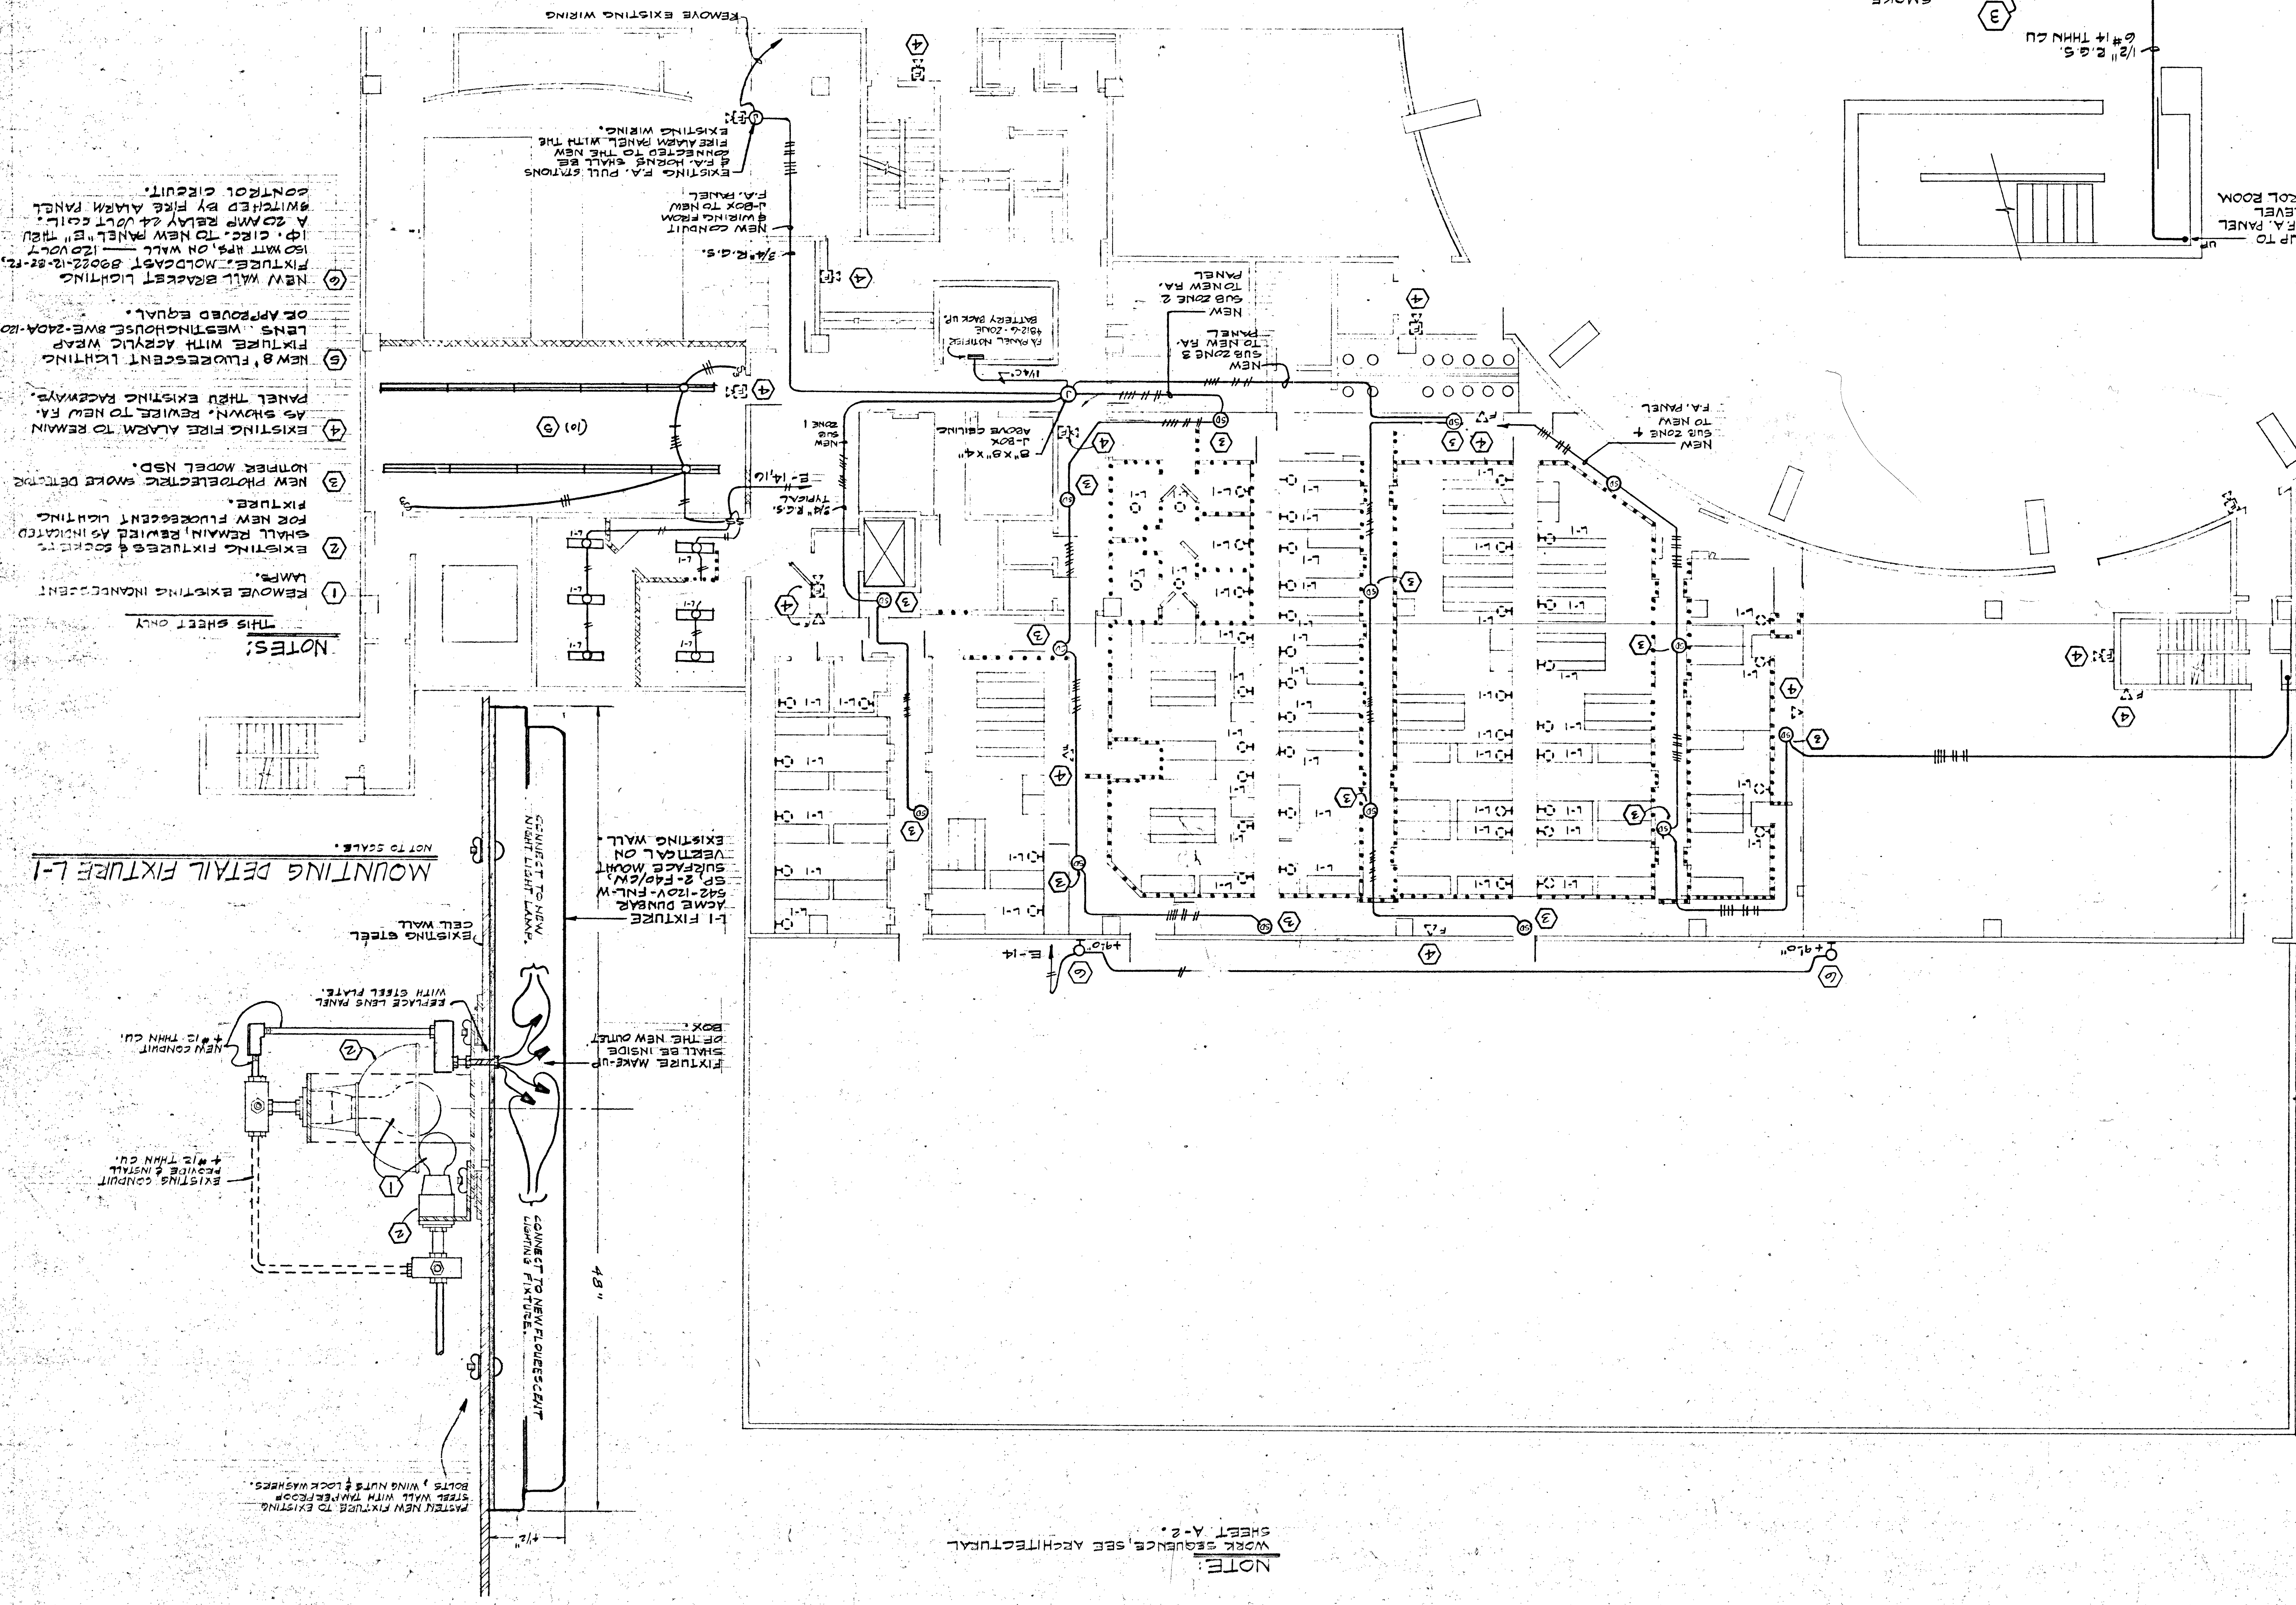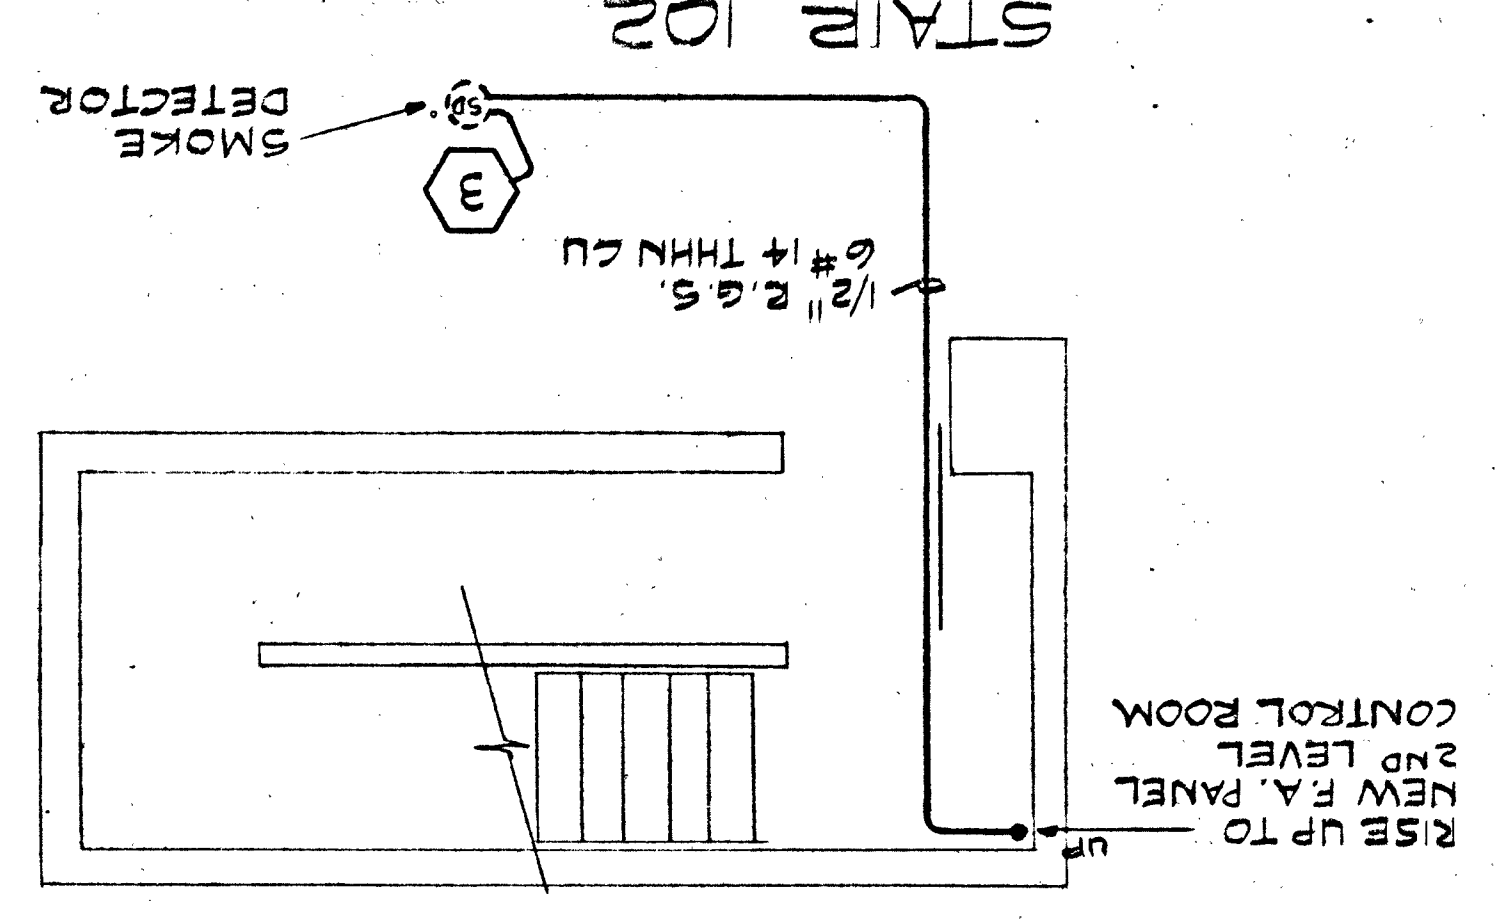

NOTE: WORK SEQUENCE, SEE ARCHITECTURAL SHEET A-2.

MOUNTING DETAIL FIXTURE L-1

