

REVISION	DATE	DESCRIPTION
1-20-78	1-20-78	DELETE "ALTERNATE" NOTES
1-29-78	1-29-78	MODIFIED TV OUTLETS
NO REV.	12-14-78	AS BUILT

10-21-77

DATE

ENGINEER

DRAWN

CHECKED

SHEET NO.

10-21-77

EXISTING ON-GRADE LEVEL

LIGHTING PLAN

FIXTURE LIST

PARKING GARAGE ADDITION

LAS VEGAS CITY HALL

400 STEWART AVE

LAS VEGAS, NEVADA

MARTIN & CASHDAN

STRUCTURAL ENGINEERS

844 EAST SAHARA AVENUE

LAS VEGAS, NEVADA 89104

TELEPHONE (702) 735-7166

ENGINEERS CONSULTANTS


Eggett & Heilm

4444 Riverside Drive, Suite 100

Las Vegas, Nevada 89103

Phone 735-7166

LE 2/1/85

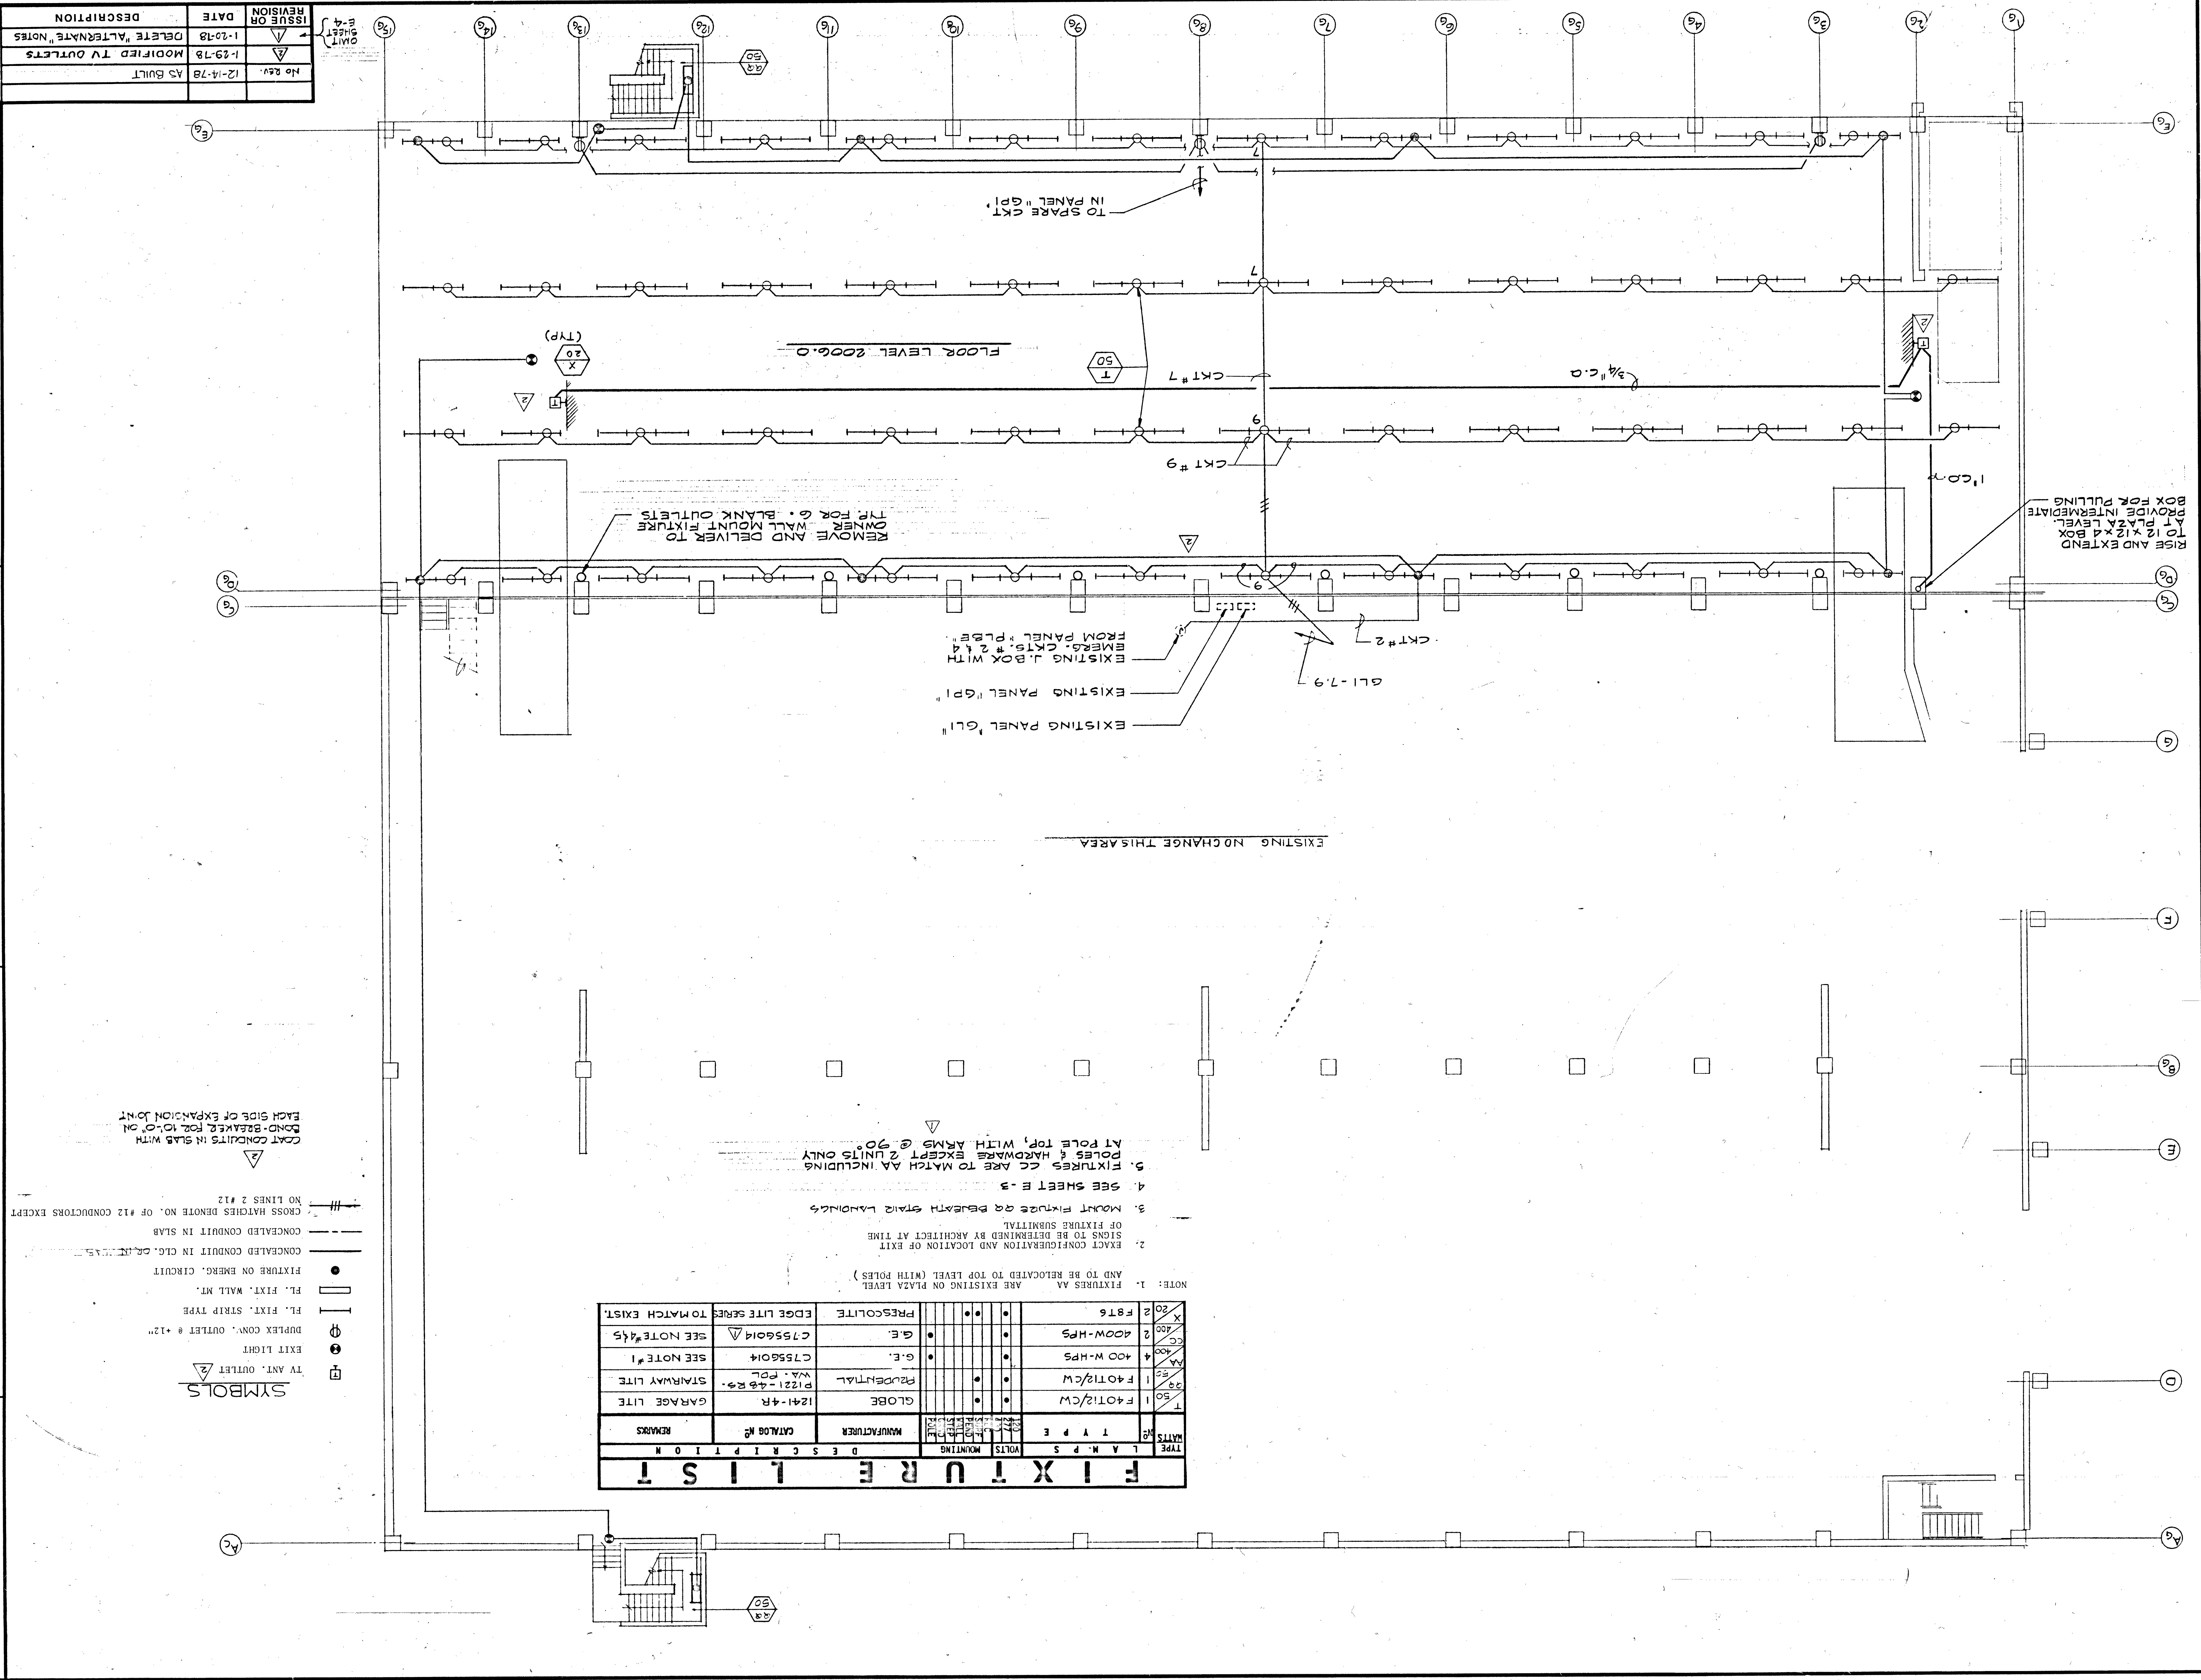

TYPE	MANUFACTURER	CATALOG NO.	REMARKS
1	400W-HPS	F40T12/CW	400W-HPS
2	400W-HPS	F40T12/CW	400W-HPS
3	400W-HPS	F40T12/CW	400W-HPS
4	400W-HPS	F40T12/CW	400W-HPS
5	400W-HPS	F40T12/CW	400W-HPS
6	400W-HPS	F40T12/CW	400W-HPS
7	400W-HPS	F40T12/CW	400W-HPS
8	400W-HPS	F40T12/CW	400W-HPS
9	400W-HPS	F40T12/CW	400W-HPS
10	400W-HPS	F40T12/CW	400W-HPS

- NOTE: 1. FIXTURES AA ARE EXISTING ON PLAZA LEVEL AND TO BE RELOCATED TO TOP LEVEL (WITH POLES)
2. EXACT CONFIGURATION AND LOCATION OF EXIT SIGNS TO BE DETERMINED BY ARCHITECT AT TIME OF FIXTURE SUBMITTAL
3. MOUNT FIXTURES ON BEJEATH STAIR LANDINGS
4. SEE SHEET E-3
5. FIXTURES CC ARE TO MATCH AA INCLUDING POLES & HARDWARE EXCEPT 2 UNITS ONLY AT POLE TOP, WITH ARMS @ 90°
6. COAT CONDUITS IN SLAB WITH BOND-BREAKER FOR 10'-0" ON EACH SIDE OF EXPANSION JOINT

SYMBOLS

TV ANT. OUTLET

EXIT LIGHT

DUPLEX CONN. OUTLET @ 12"

FL. FIXT. STRIP TYPE

FL. FIXT. WALL MT.

FIXTURE ON EMERG. CIRCUIT

CONCEALED CONDUIT IN CLG. OR UNDER SLAB

CROSS HATCHES DENOTE NO. OF #12 CONDUCTORS EXCEPT NO LINES 2 #12