

REVISION	DATE	DESCRIPTION
1-20-78	1-20-78	DELETE "ALTERNATE" NOTES
1-29-78	1-29-78	MODIFIED TV OUTLETS
12-14-78	12-14-78	AS BUILT
NO REV.		

SHEET NO. 1
 CHECKED
 DRAWN
 ENGINEER
 DATE 10-21-77
 JOB NO.

SHEET TITLE
 EXISTING ON-GRADE LEVEL
 LIGHTING PLAN
 FIXTURE LIST

JOB TITLE
 PARKING GARAGE ADDITION
 LAS VEGAS CITY HALL
 400 STEWART AVE
 LAS VEGAS, NEVADA


MARTIN & CASHDAN
 STRUCTURAL ENGINEERS
 844 EAST SAHARA AVENUE
 LAS VEGAS, NEVADA 89104
 TELEPHONE (702) 735-7166

ENGINEERS CONSULTANTS
 Eggett & Heilm
 4444 Riverside Drive, Suite 100
 Las Vegas, Nevada 89103
 Telephone (702) 735-7166

SYMBOLS
 TV ANT. OUTLET
 EXIT LIGHT
 DUPLEX CONN. OUTLET @ 12"
 FL. FIXT. STRIP TYPE
 FL. FIXT. WALL MT.
 FIXTURE ON EMERG. CIRCUIT
 CONCEALED CONDUIT IN CLG. OR PARTIALLY EXPOSED
 CONCEALED CONDUIT IN SLAB
 CROSS HATCHES DENOTE NO. OF #12 CONDUCTORS EXCEPT
 NO LINES 2 #12
 COAT CONDUITS IN SLAB WITH
 BOND-BREAKER FOR 10'-0" ON
 EACH SIDE OF EXPANSION JOINT

TYPE	MANUFACTURER	CATALOG NO.	REMARKS
1	400 W-HPS	F40T12/CW	STAIRWAY LITE
2	400 W-HPS	C7556014	SEE NOTE #1
3	400 W-HPS	C7556014	SEE NOTE #4 & 5
4	1241-4-R	GLOBE	GARAGE LITE
5	1241-4-R	GLOBE	STAIRWAY LITE
6	1241-4-R	GLOBE	STAIRWAY LITE
7	1241-4-R	GLOBE	STAIRWAY LITE
8	1241-4-R	GLOBE	STAIRWAY LITE
9	1241-4-R	GLOBE	STAIRWAY LITE
10	1241-4-R	GLOBE	STAIRWAY LITE
11	1241-4-R	GLOBE	STAIRWAY LITE
12	1241-4-R	GLOBE	STAIRWAY LITE
13	1241-4-R	GLOBE	STAIRWAY LITE
14	1241-4-R	GLOBE	STAIRWAY LITE
15	1241-4-R	GLOBE	STAIRWAY LITE
16	1241-4-R	GLOBE	STAIRWAY LITE
17	1241-4-R	GLOBE	STAIRWAY LITE
18	1241-4-R	GLOBE	STAIRWAY LITE
19	1241-4-R	GLOBE	STAIRWAY LITE
20	1241-4-R	GLOBE	STAIRWAY LITE

NOTE: 1. FIXTURES AA ARE EXISTING ON PLAZA LEVEL AND TO BE RELOCATED TO TOP LEVEL (WITH POLES)
 2. EXACT CONFIGURATION AND LOCATION OF EXIT SIGNS TO BE DETERMINED BY ARCHITECT AT TIME OF FIXTURE SUBMITTAL
 3. MOUNT FIXTURES ON BEJEATH STAIR LANDINGS
 4. SEE SHEET E-3
 5. FIXTURES CC ARE TO MATCH AA INCLUDING POLES & HARDWARE EXCEPT 2 UNITS ONLY AT POLE TOP, WITH ARMS @ 90°

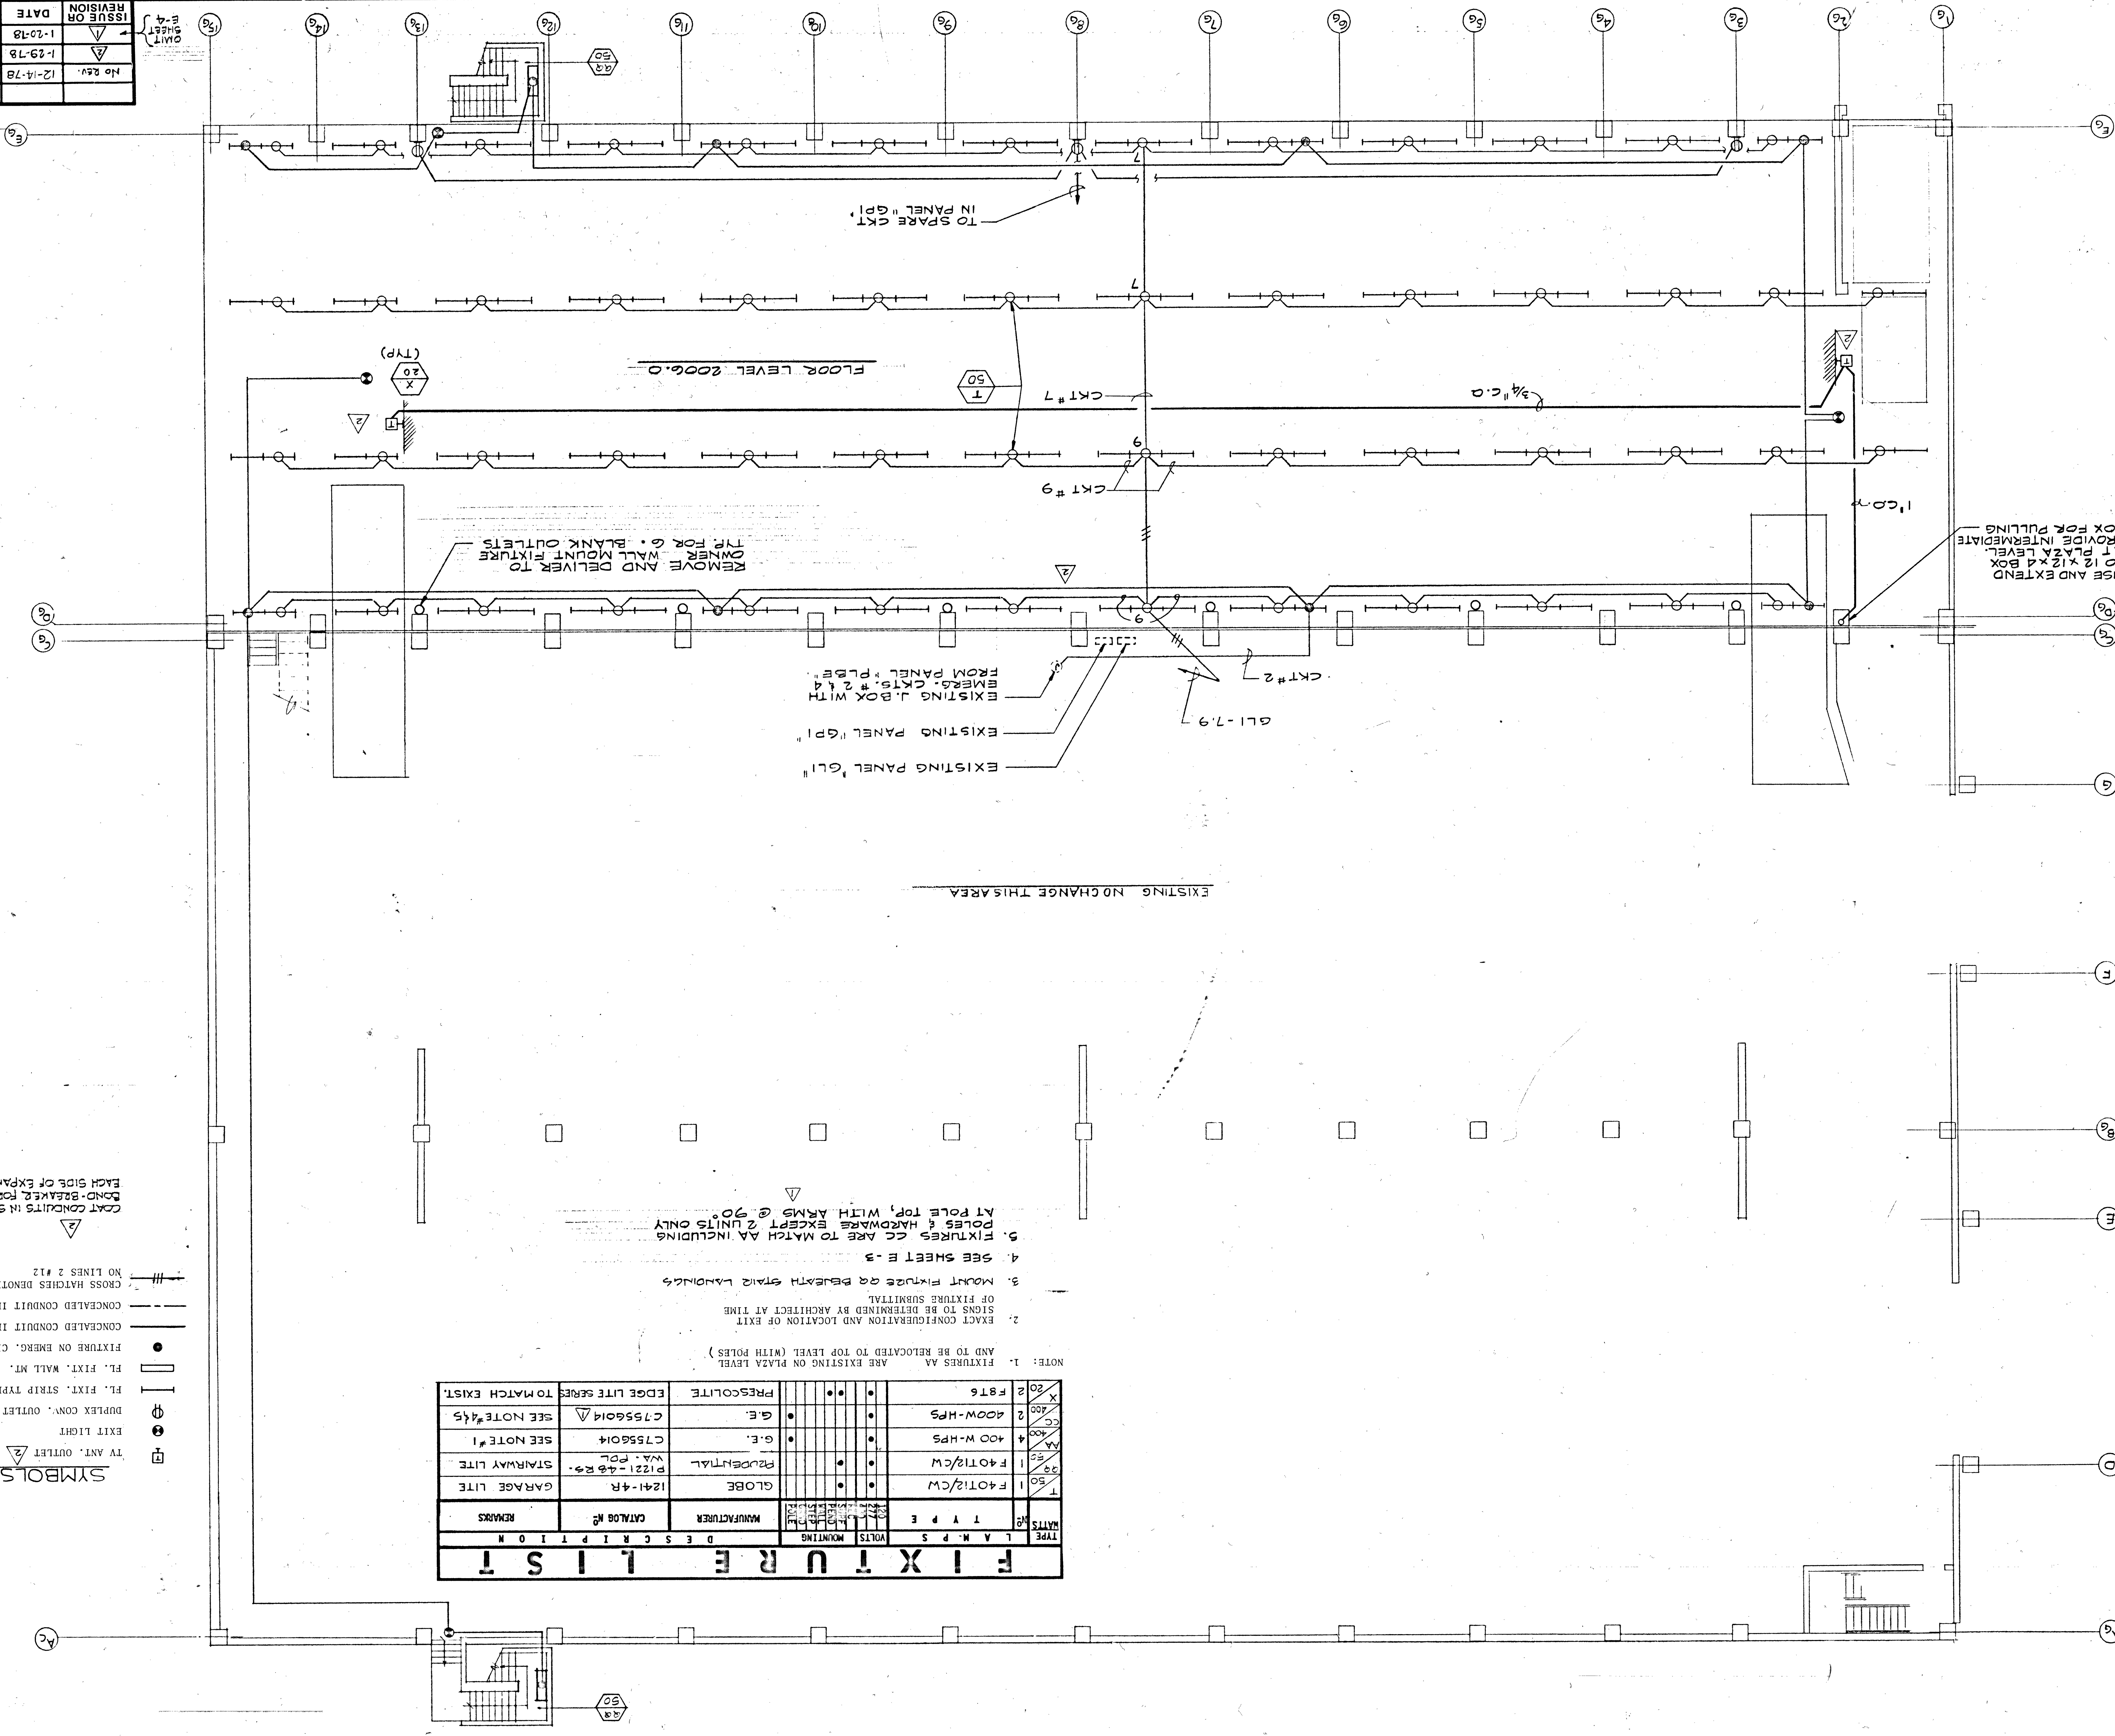

RISE AND EXTEND TO 12' PLAZA LEVEL. PROVIDE INTERMEDIATE BOX FOR PULLING

EXISTING PANEL 'GLI'
 EXISTING PANEL 'GPI'
 EXISTING J. BOX WITH EMERG. CKTS. #2 & 4
 FROM PANEL 'PLBE'

REMOVE AND DELIVER TO OWNER WALL MOUNT FIXTURE TYP. FOR 6" BLANK OUTLETS

TO SPARE CKT. IN PANEL "GPI"

EXISTING NO CHANGE THIS AREA