


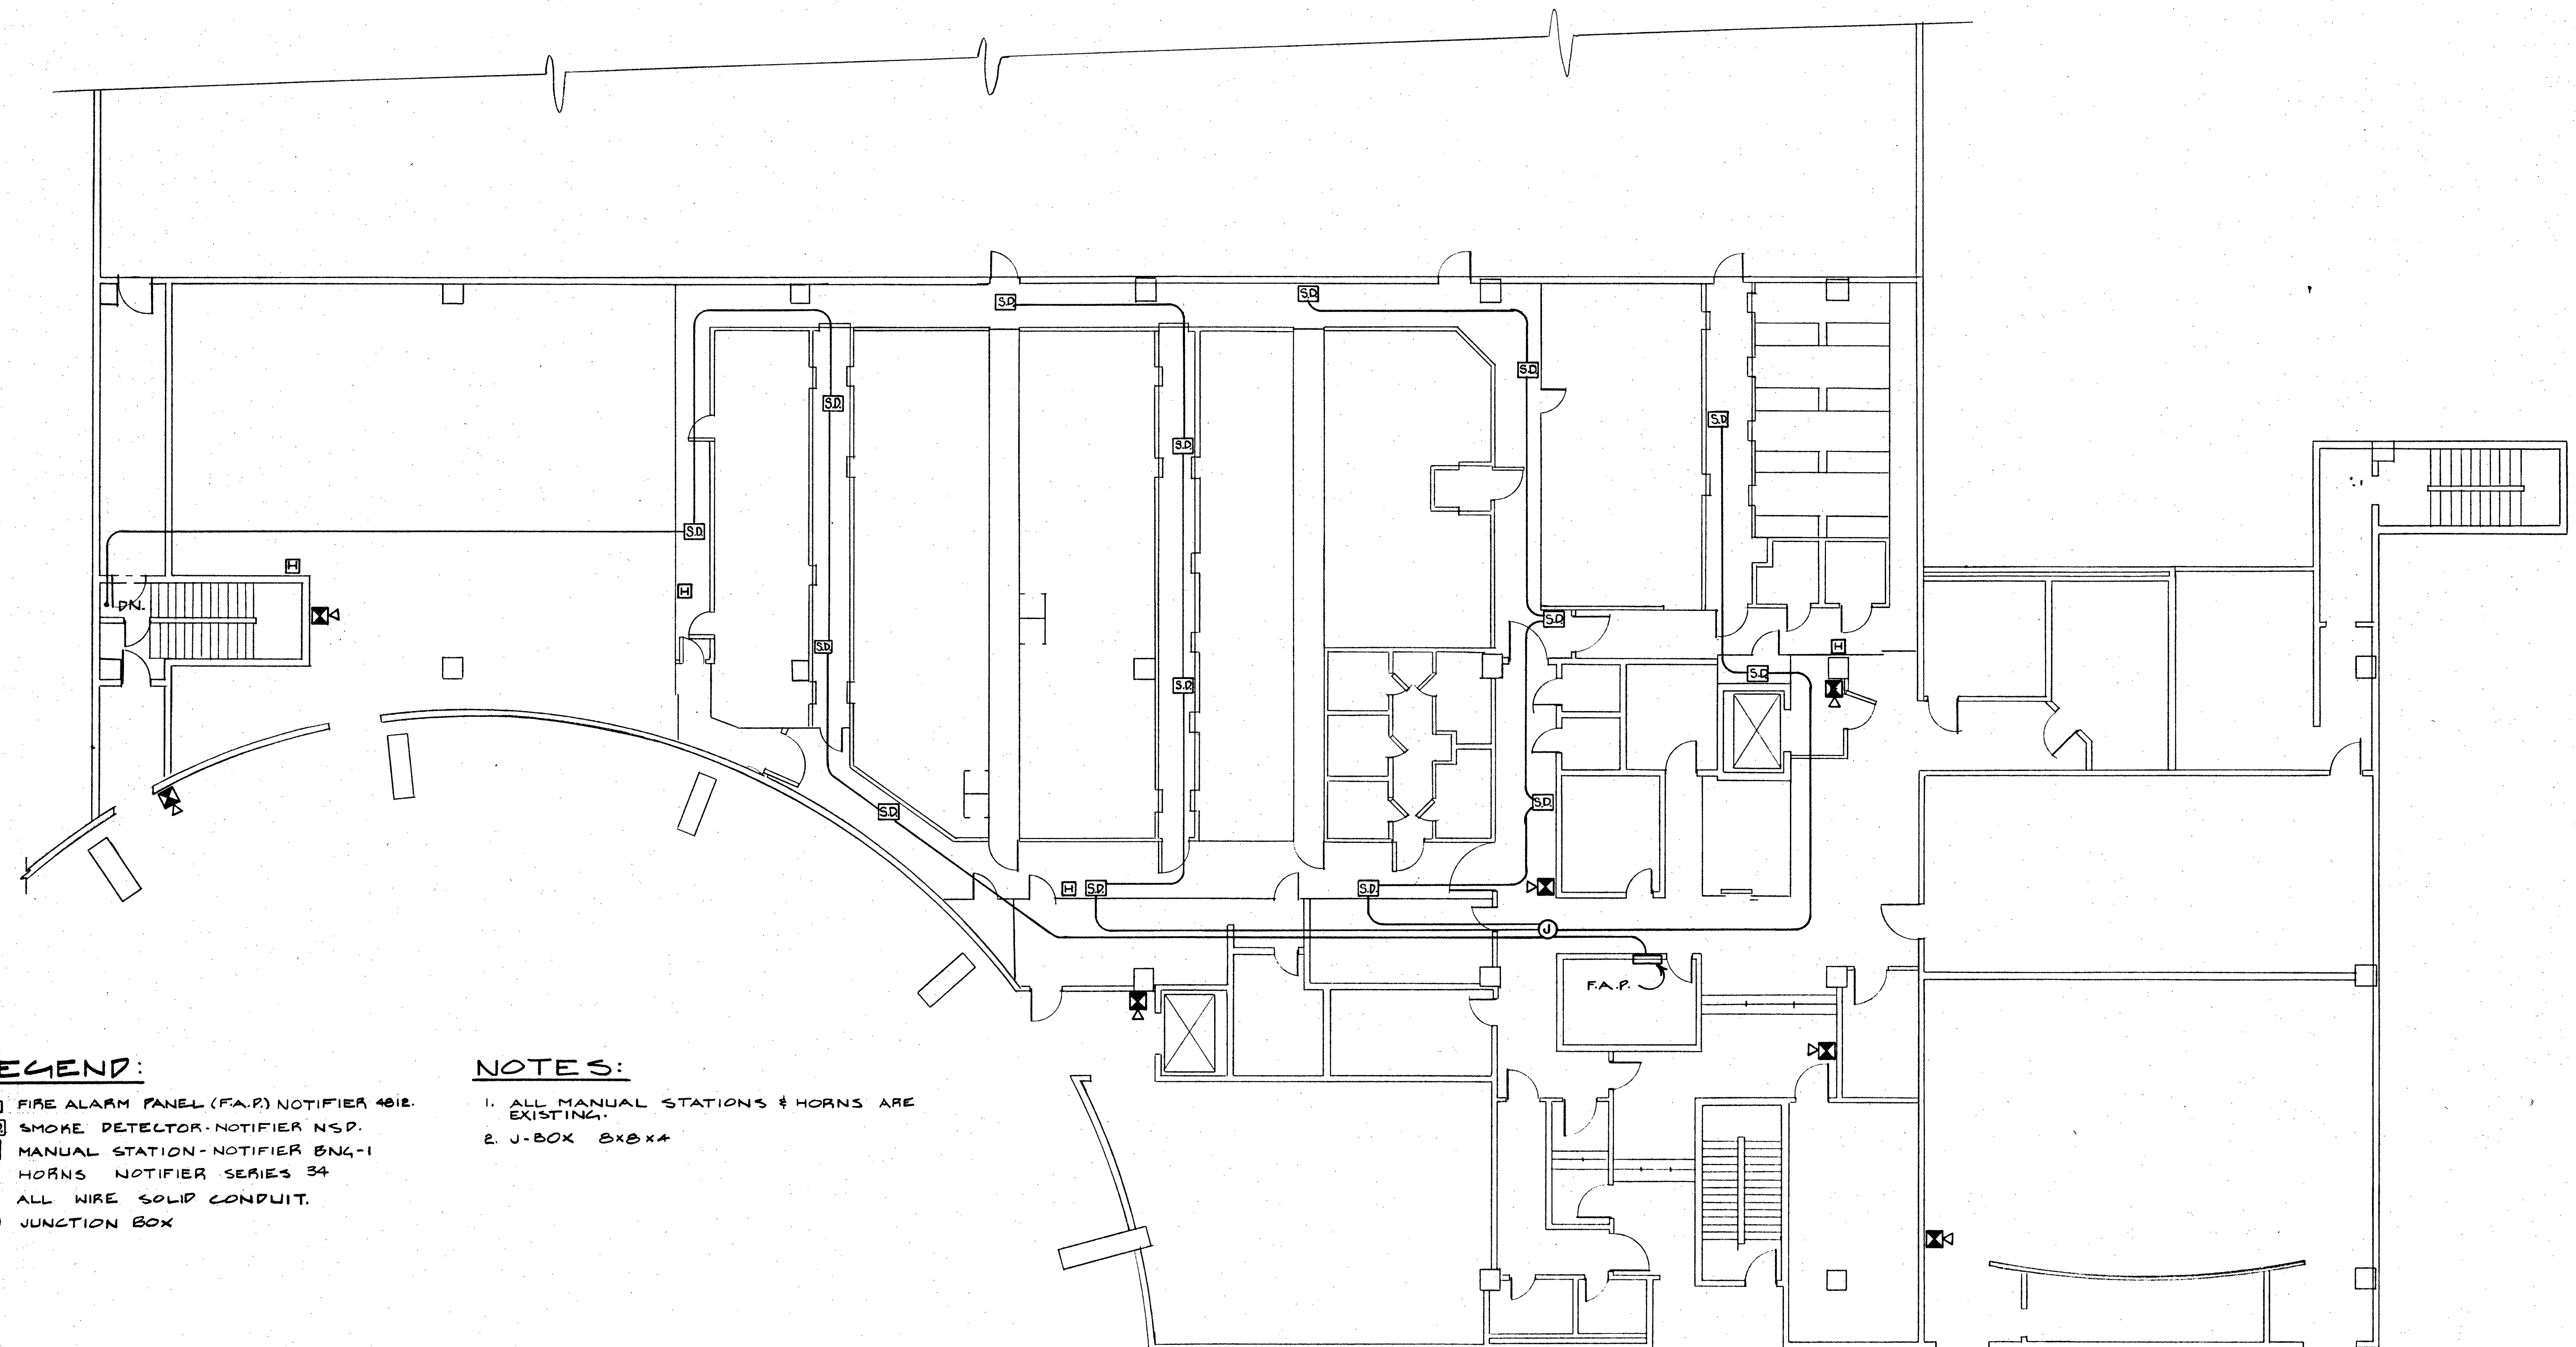

# **LEGEND:**

- FIRE ALARM PANEL (F.A.P.) NOTIFIER 4012.
- SD SMOKE DETECTOR-NOTIFIER NSD.
- ⊠ MANUAL STATION-NOTIFIER BN4-1
- ⊠ HORN NOTIFIER SERIES 34
- ALL WIRE SOLID CONDUIT.
- JUNCTION BOX

# **NOTES:**

1. ALL MANUAL STATIONS & HORNS ARE EXISTING.
2. J-BOX 8x8x4

## POLICE BUILDING PARTIAL 2<sup>ND</sup> LEVEL FIRE ALARM SYSTEM.

N.T.S.

| CITY JAIL                    |                        |                                         |        |
|------------------------------|------------------------|-----------------------------------------|--------|
| SCALE: N.T.S.                | APPROVED BY: AS BUILT. | DRAWN BY: R.A.J.                        |        |
| DATE: 8-12-81                | REVISED                | POLICE BLDG. PART. 2 <sup>ND</sup> LEV. |        |
| FIRE ALARM SYSTEM.           |                        | DRAWING NUMBER                          |        |
| ELLIS INDUSTRIAL ELECTRONICS |                        | 385-5580                                | 2 OF 4 |