


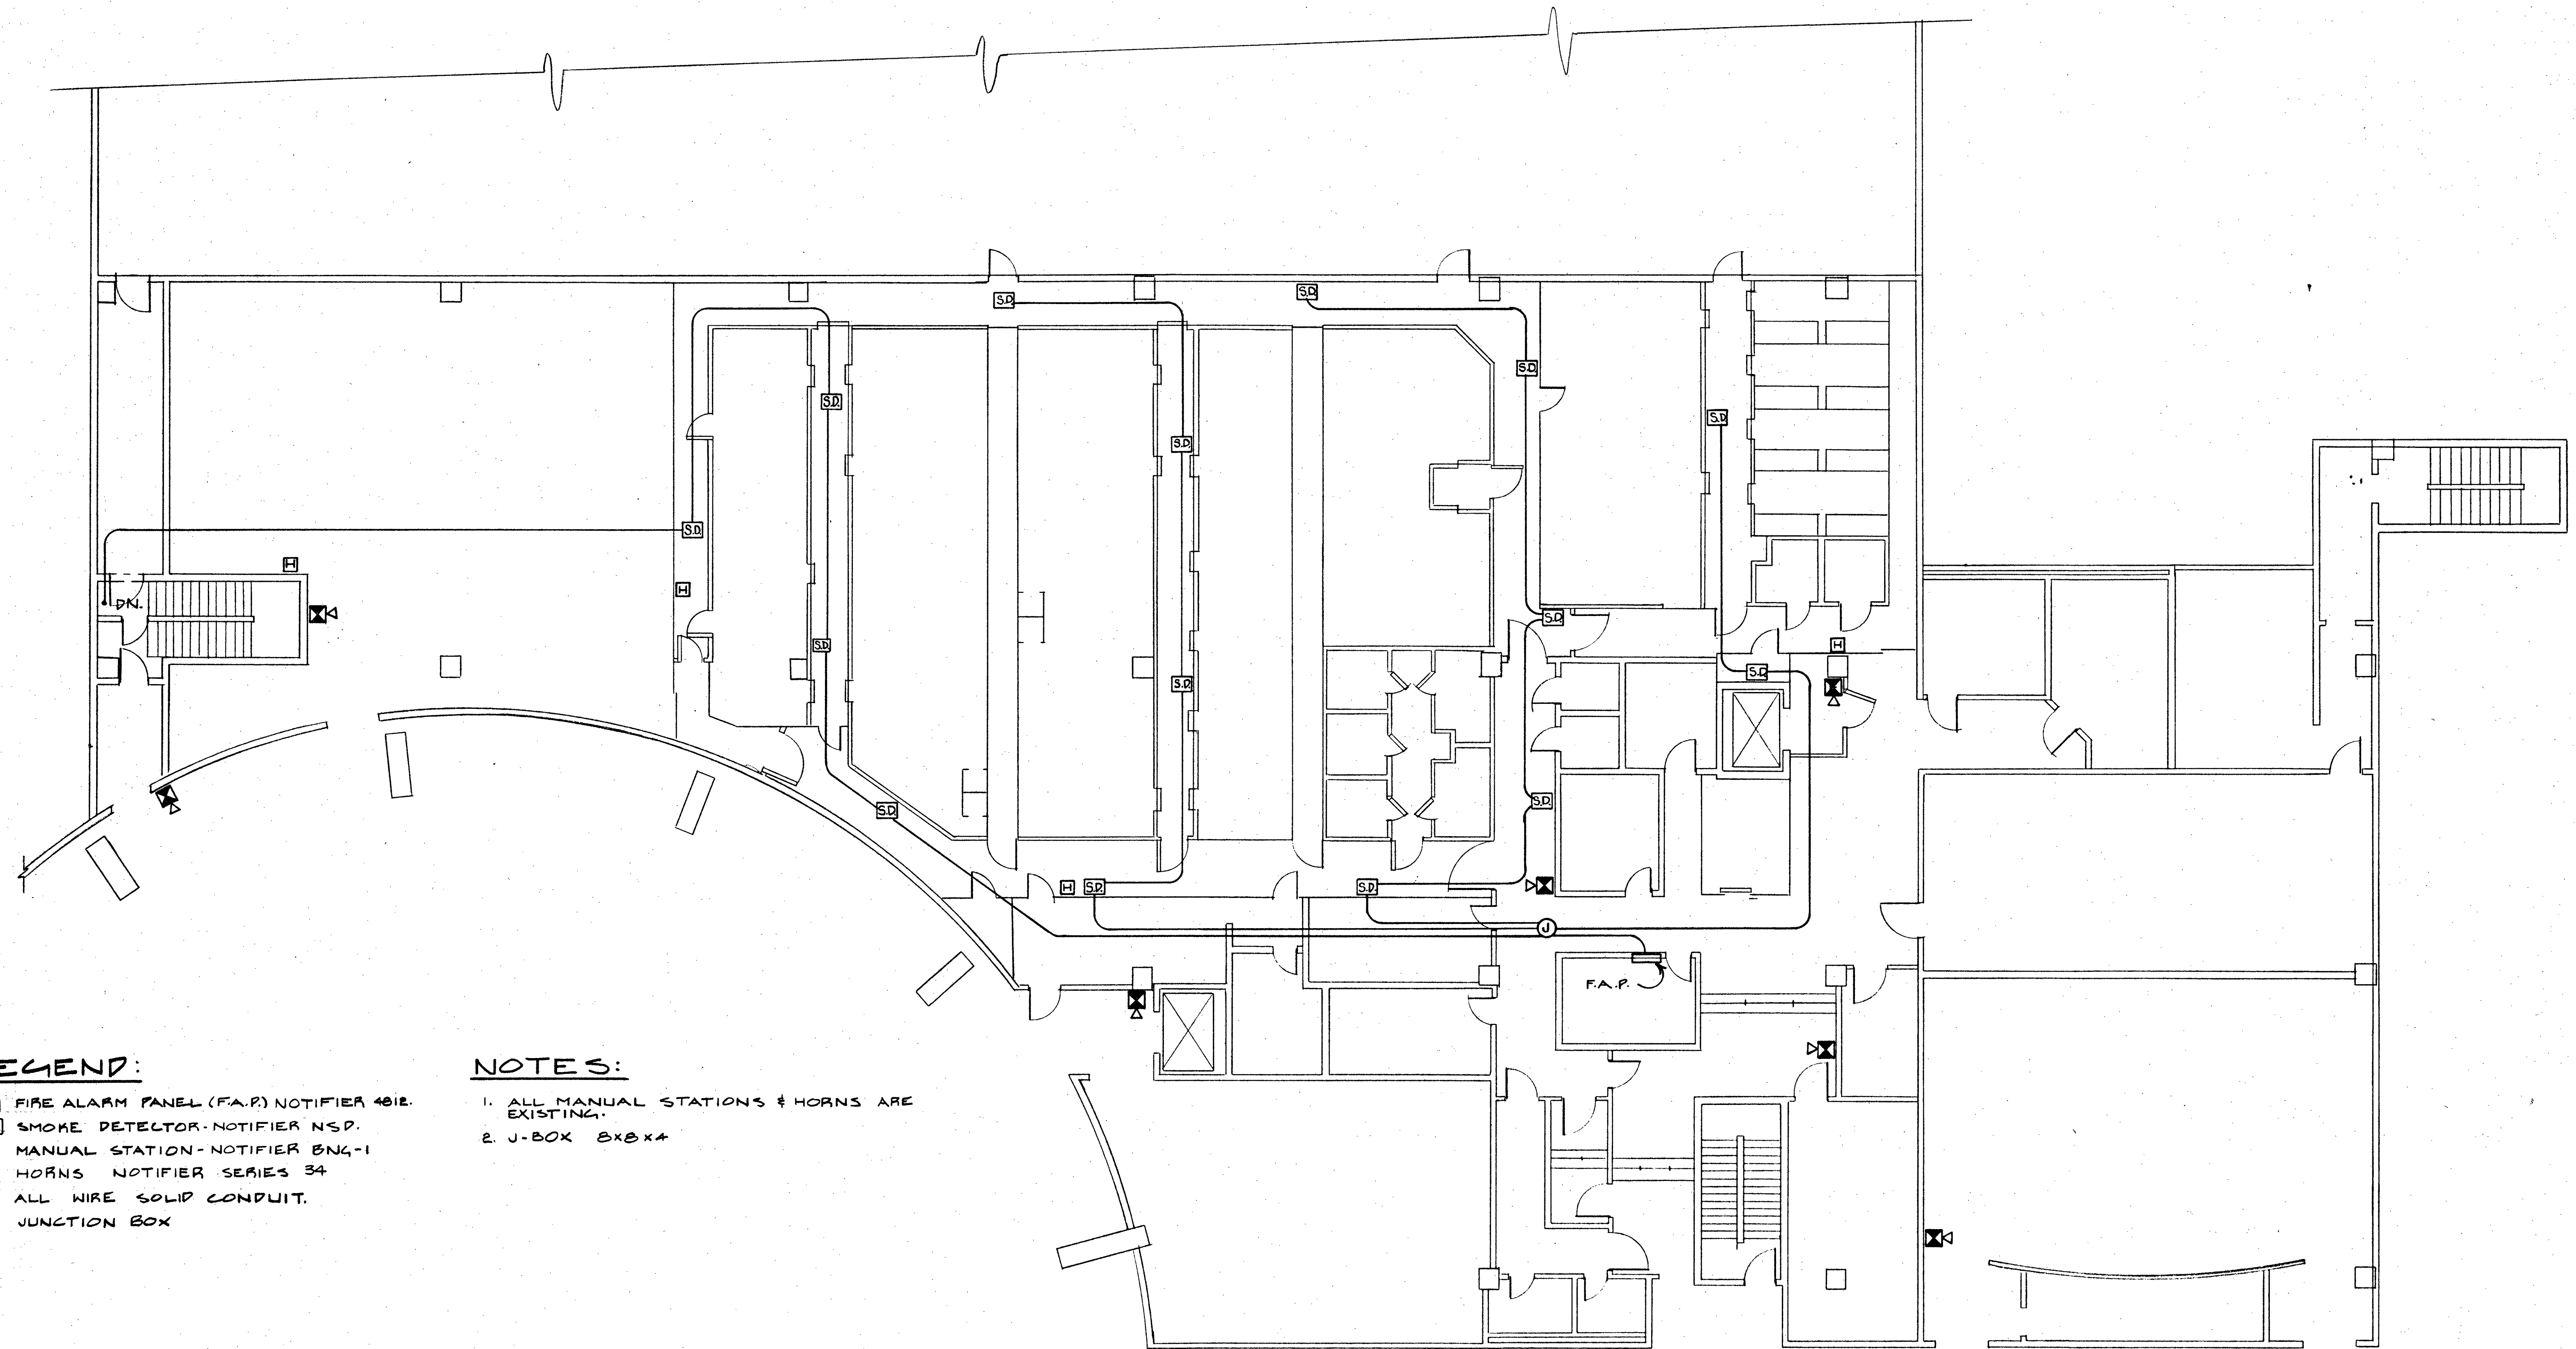

LEGEND:

- FIRE ALARM PANEL (F.A.P.) NOTIFIER 4012.
- SD SMOKE DETECTOR-NOTIFIER NSD.
- ⊠ MANUAL STATION-NOTIFIER BN4-1
- ⊠ HORNS NOTIFIER SERIES 34
- ALL WIRE SOLID CONDUIT.
- JUNCTION BOX

NOTES:

1. ALL MANUAL STATIONS & HORNS ARE EXISTING.
2. J-BOX 8x8x4

POLICE BUILDING PARTIAL 2ND LEVEL FIRE ALARM SYSTEM.

N.T.S.

CITY JAIL			
SCALE: N.T.S.	APPROVED BY: AS BUILT.	DRAWN BY: R.A.J.	
DATE: 8-12-81	REVIEWED	POLICE BLDG. PART. 2 ND LEV.	
FIRE ALARM SYSTEM.		DRAWING NUMBER	
ELLIS INDUSTRIAL ELECTRONICS		385-5580	2 OF 4