
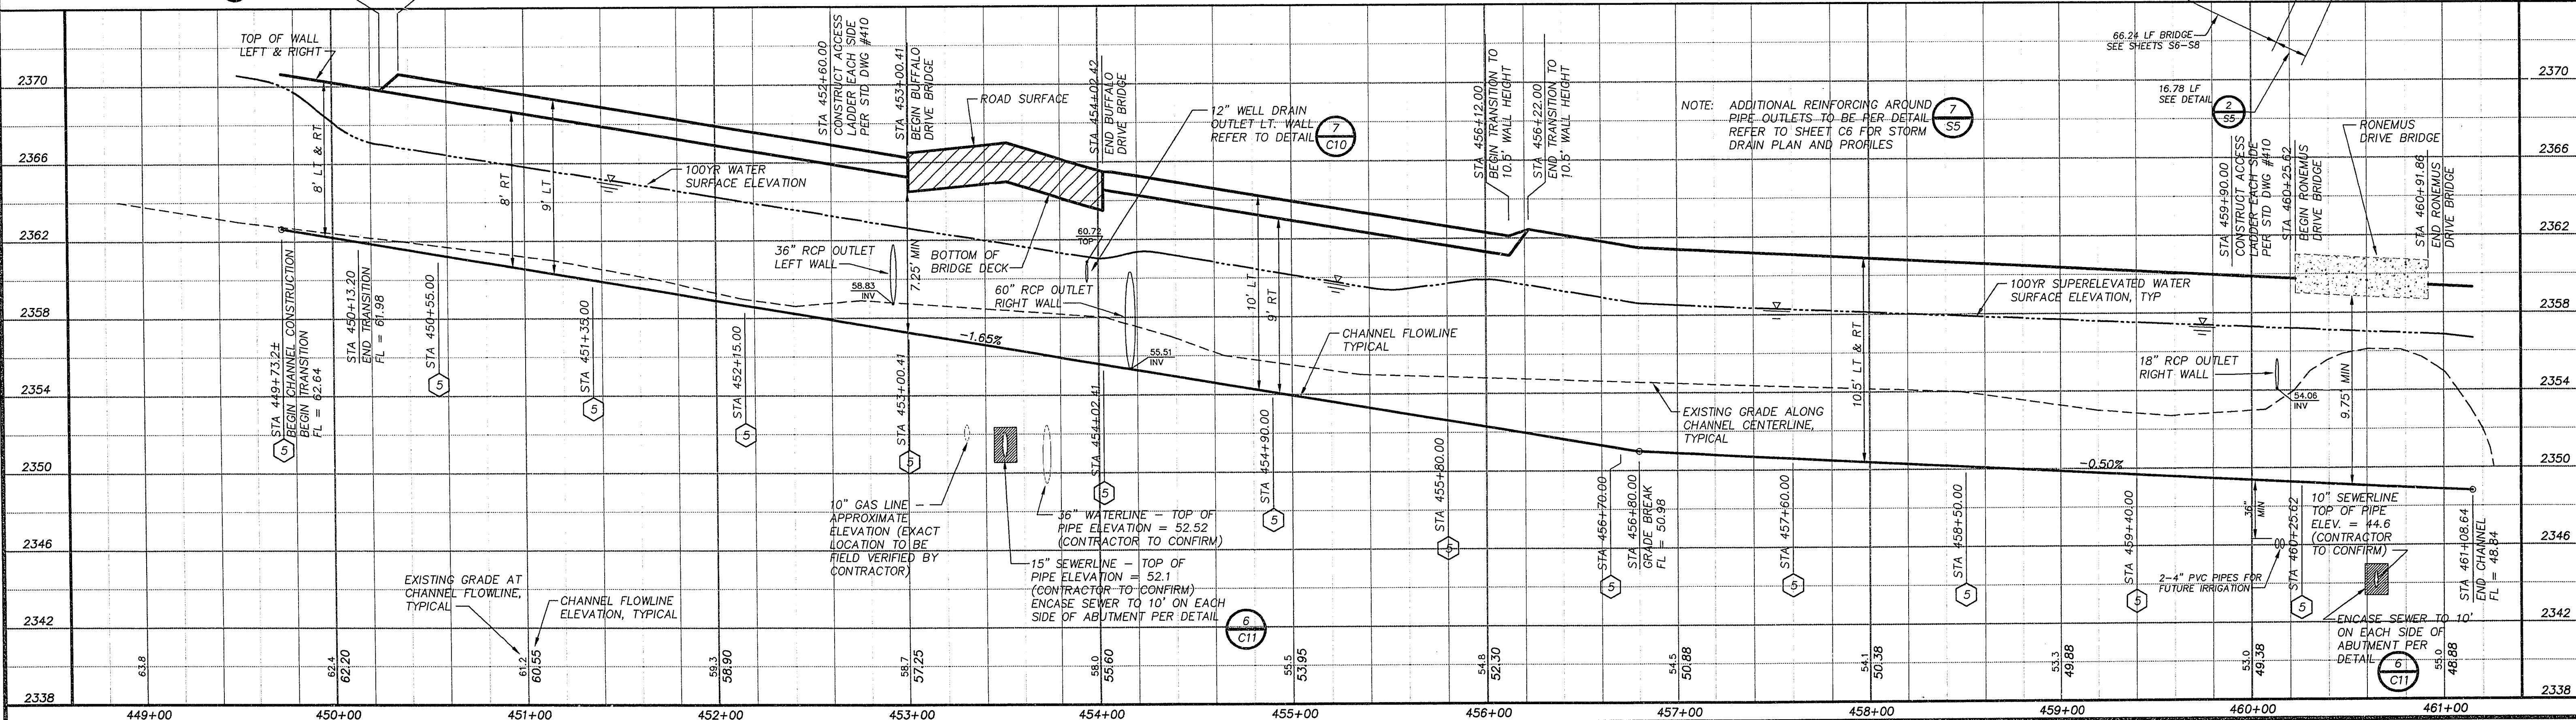


RECORD
DRAWINGS


DRAFTED BY: JMA DATE 2-2-95
CHECKED BY: DTA DATE 2-2-95

Call
before you
Dig
1-800-227-2600

BUFFALO
DRIVE
(REFER TO SHEET C8
FOR PLAN AND PROFILE)

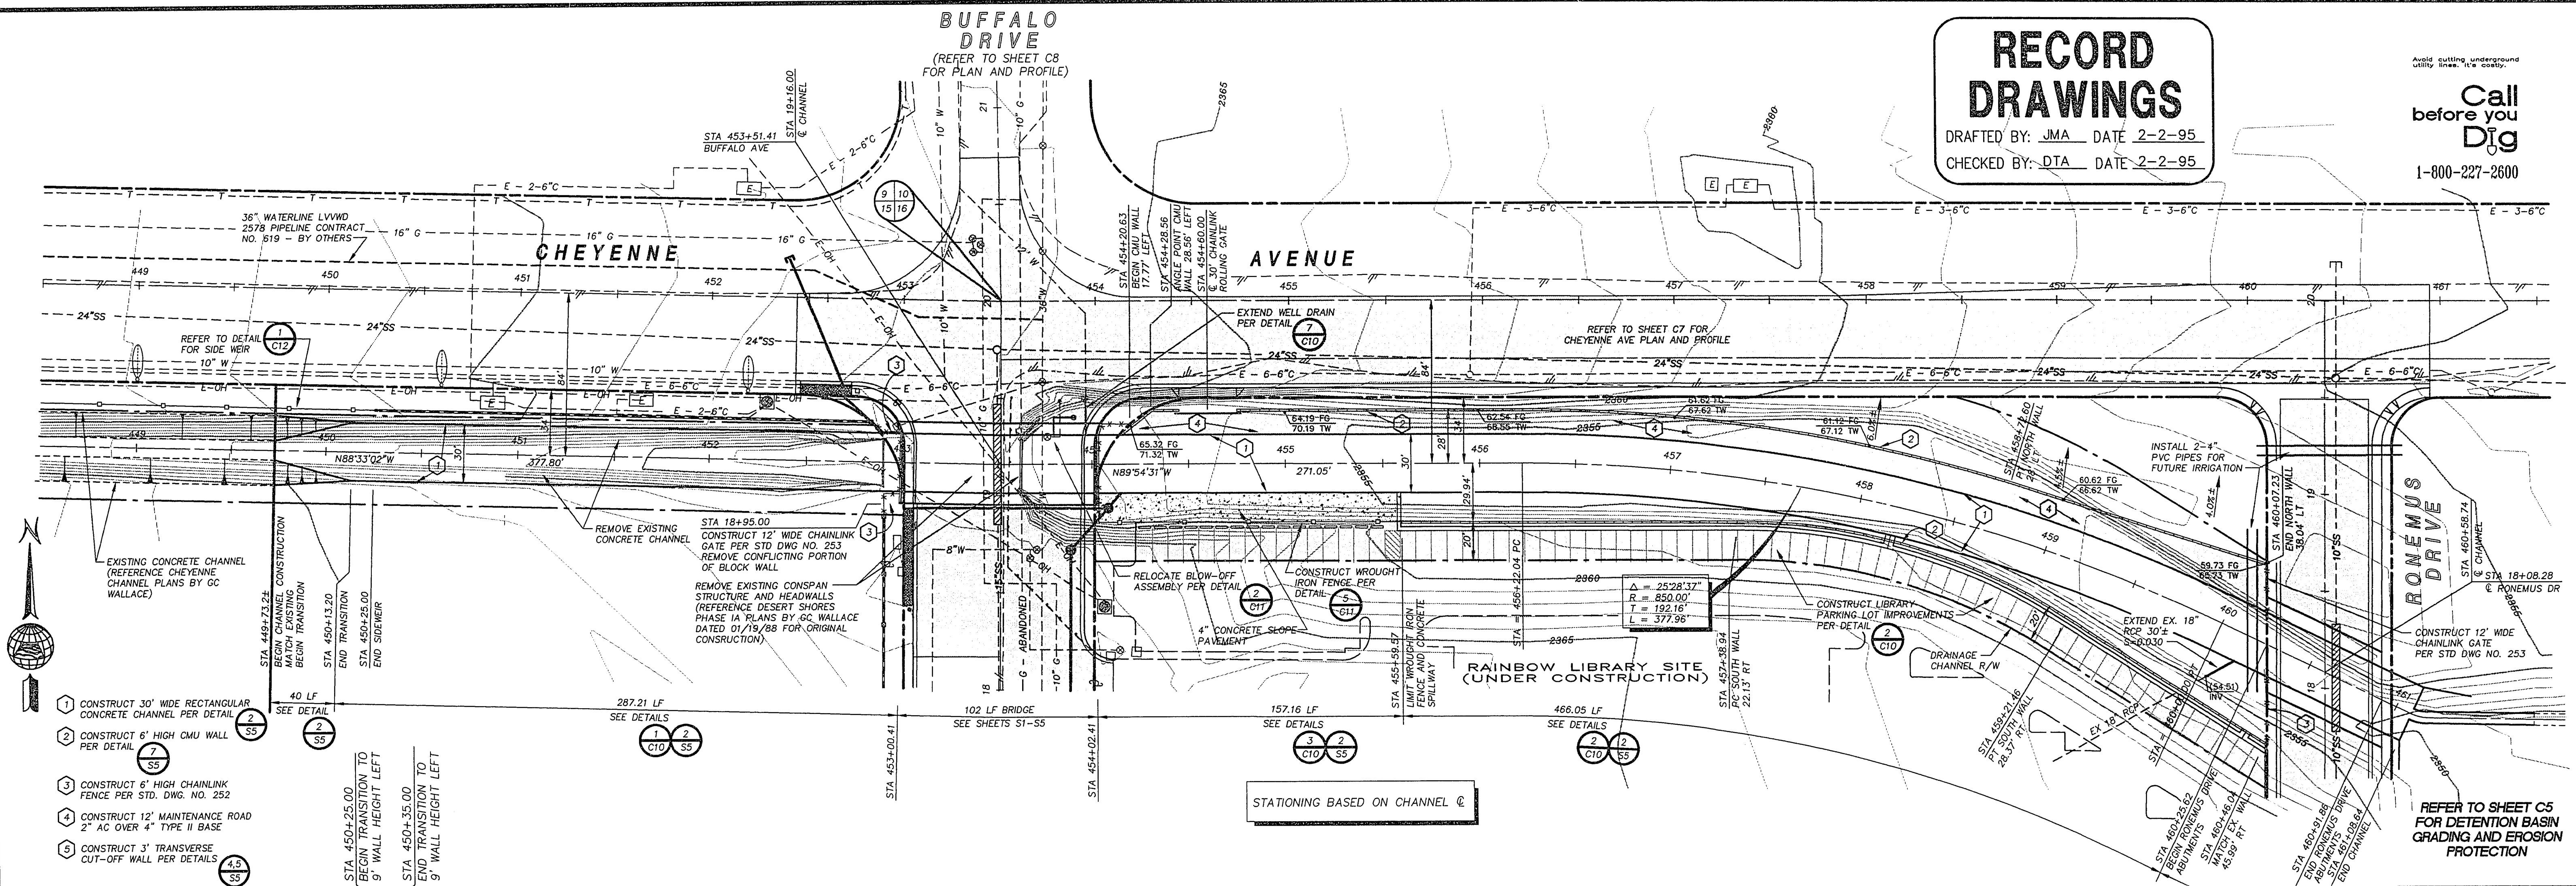

REVISIONS				
REV.	DESCRIPTION	BY	DATE	APPROVAL

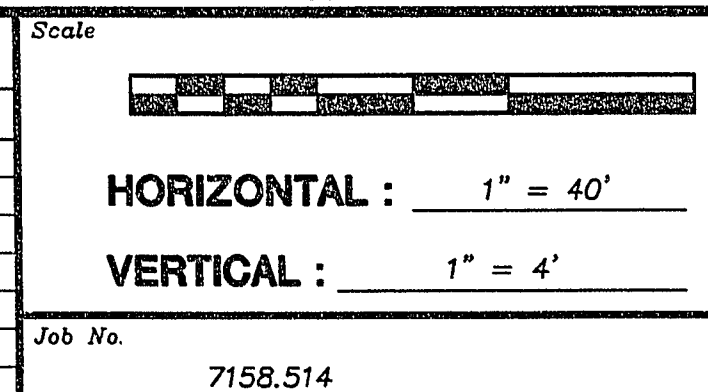

Church Engineering
A Division of
PBS
6600 West Charleston Blvd.
Suite 140
Las Vegas, Nevada 89102
Telephone: 702/878-6244
Fax: 702/878-7758
ENGINEERING • PLANNING • SURVEYING • CONSTRUCTION SERVICES

Designed by:	WEH	Date:	12/21/93
Drawn by:	AAS	Date:	12/21/93
Checked by:	PAA	Date:	12/21/93
File No.:	514IMP	Dwg No.:	514-04

CITY OF LAS VEGAS
CHEYENNE CHANNEL IMPROVEMENTS
BID No. 94.1730.12
CHANNEL PLAN AND PROFILE
CITY OF LAS VEGAS DRAWING No. 731-58
SHEET C4