



Call before you Dig
1-800-227-2600

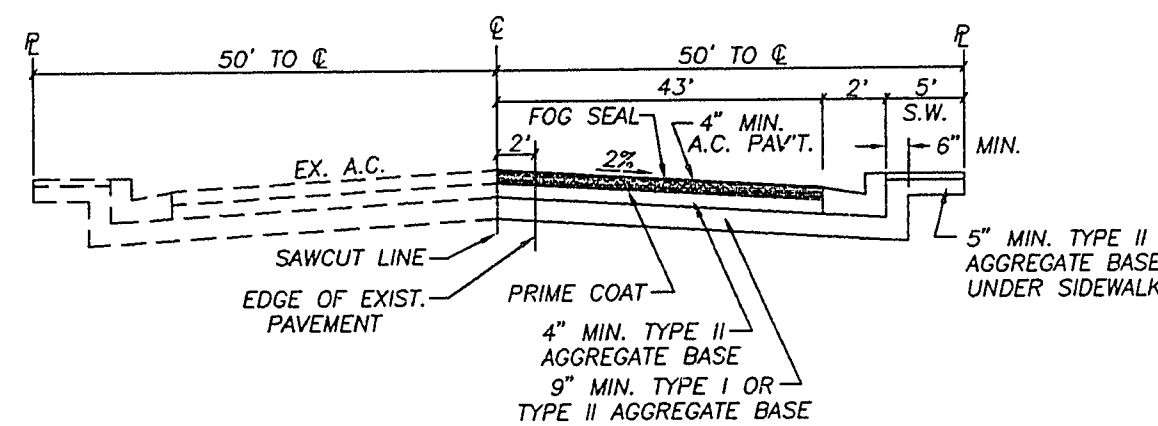

BUFFALO DRIVE


STA 16+38.68 TO STA 18+17.00

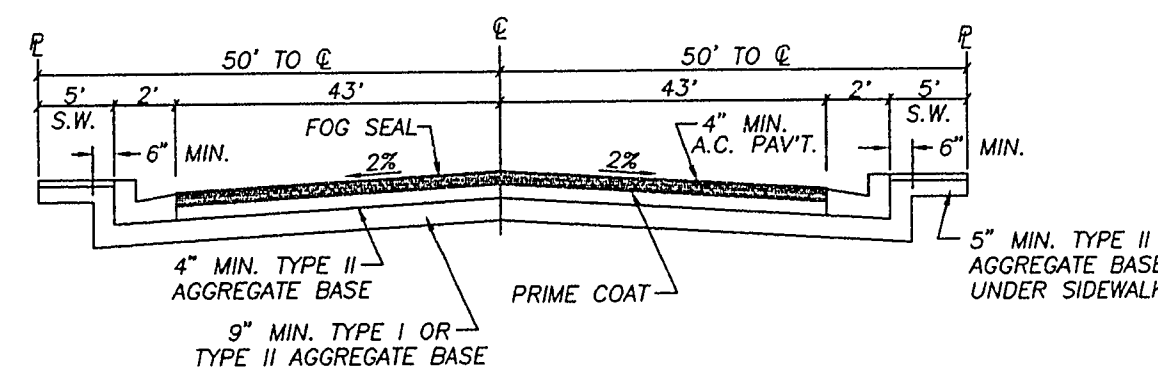

BUFFALO DRIVE

STA 18+17.00 TO STA 18+94.00


CHEYENNE AVENUE

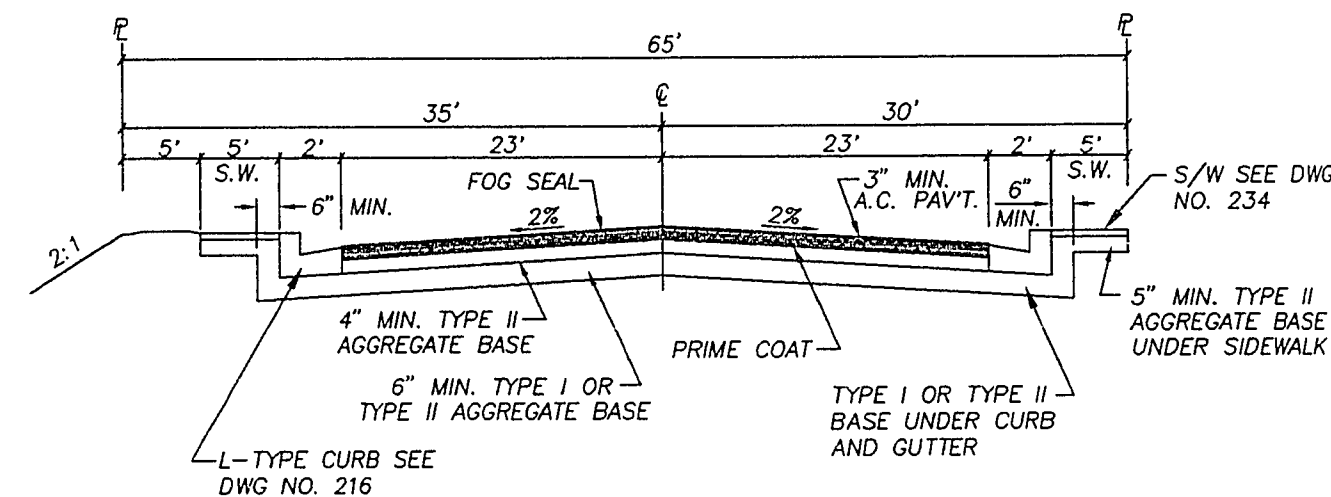

RONEMUS DRIVE


TYPICAL SECTIONS

NOT TO SCALE

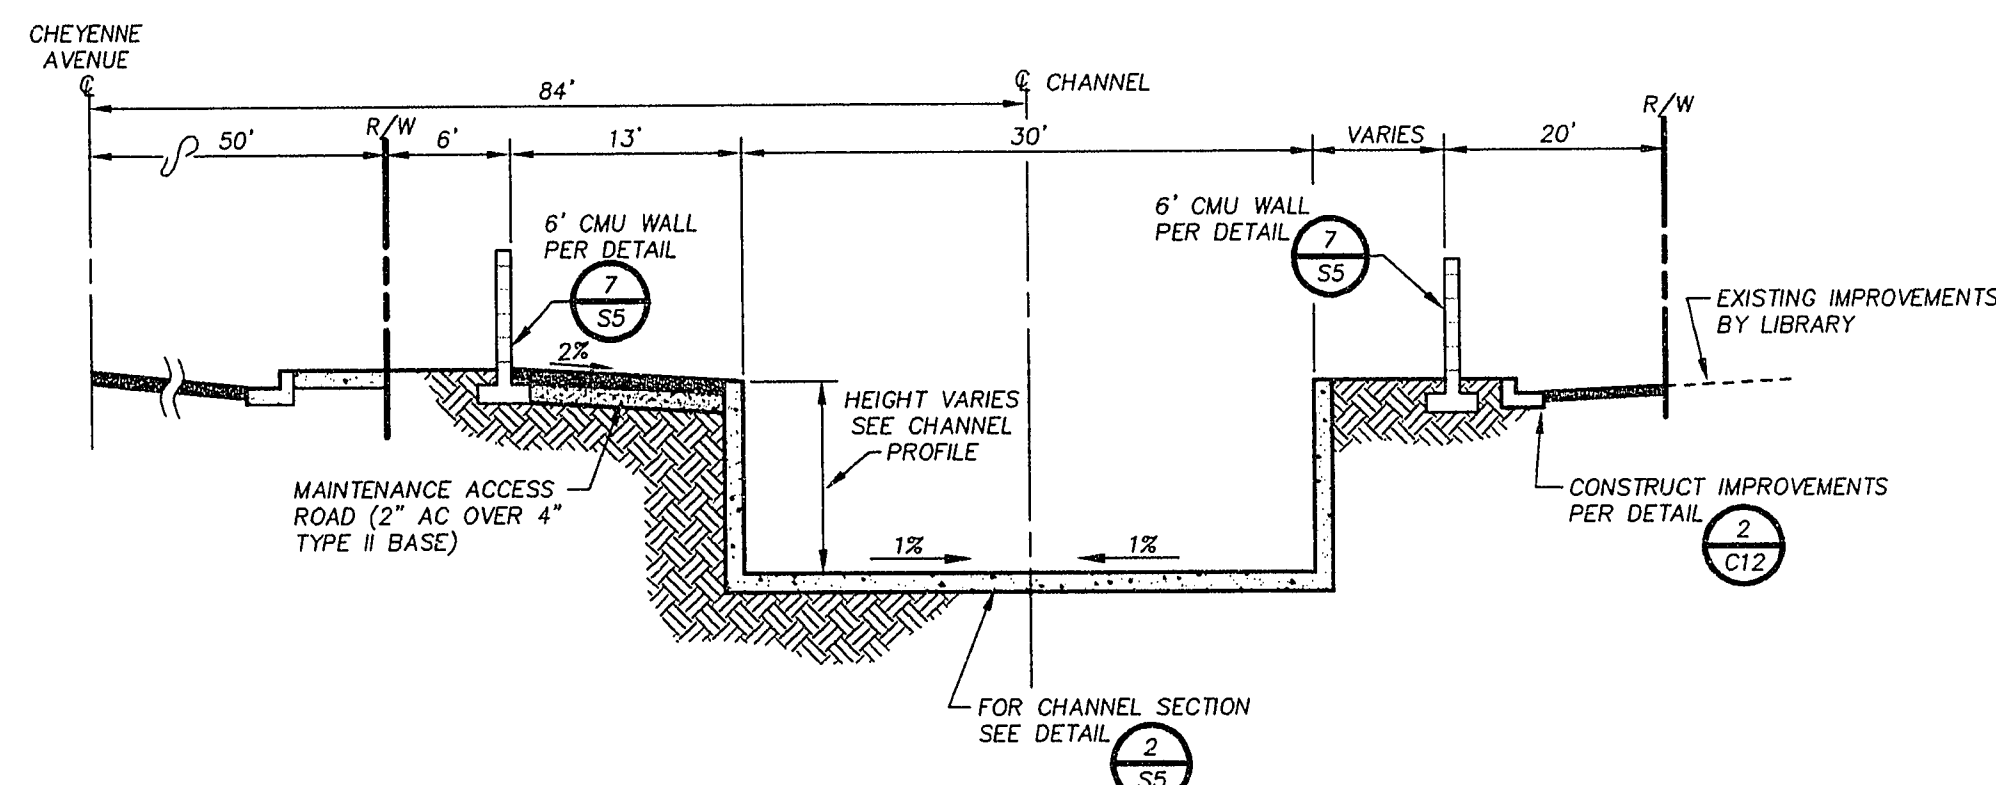


SECTION

NOT TO SCALE

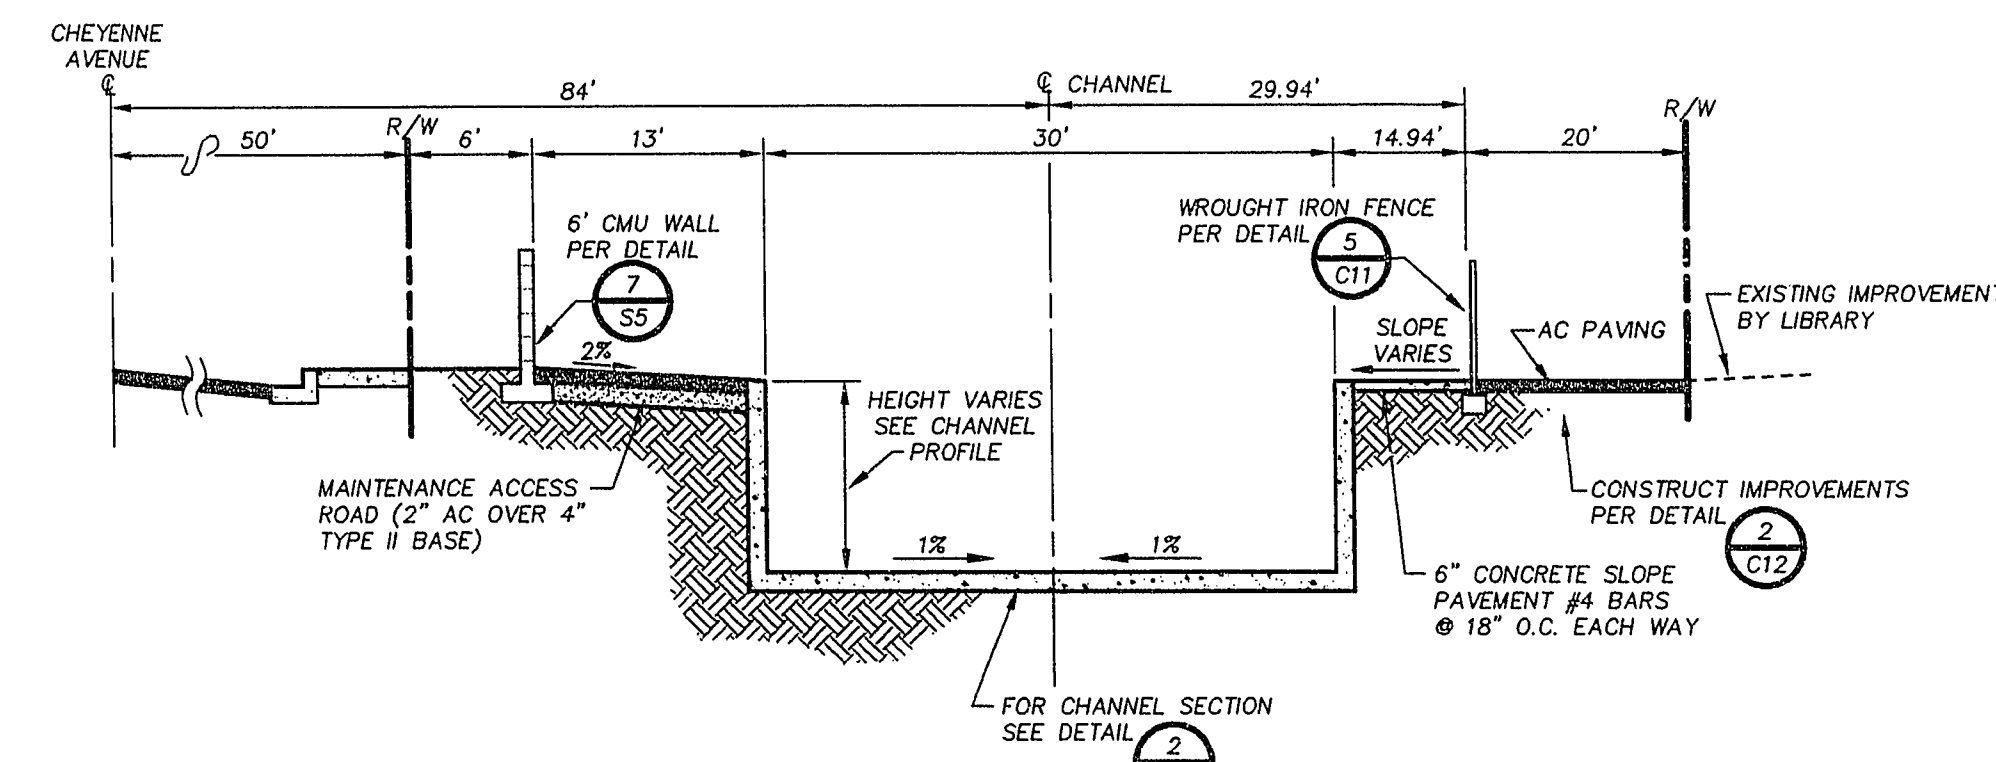


SECTION

NOT TO SCALE

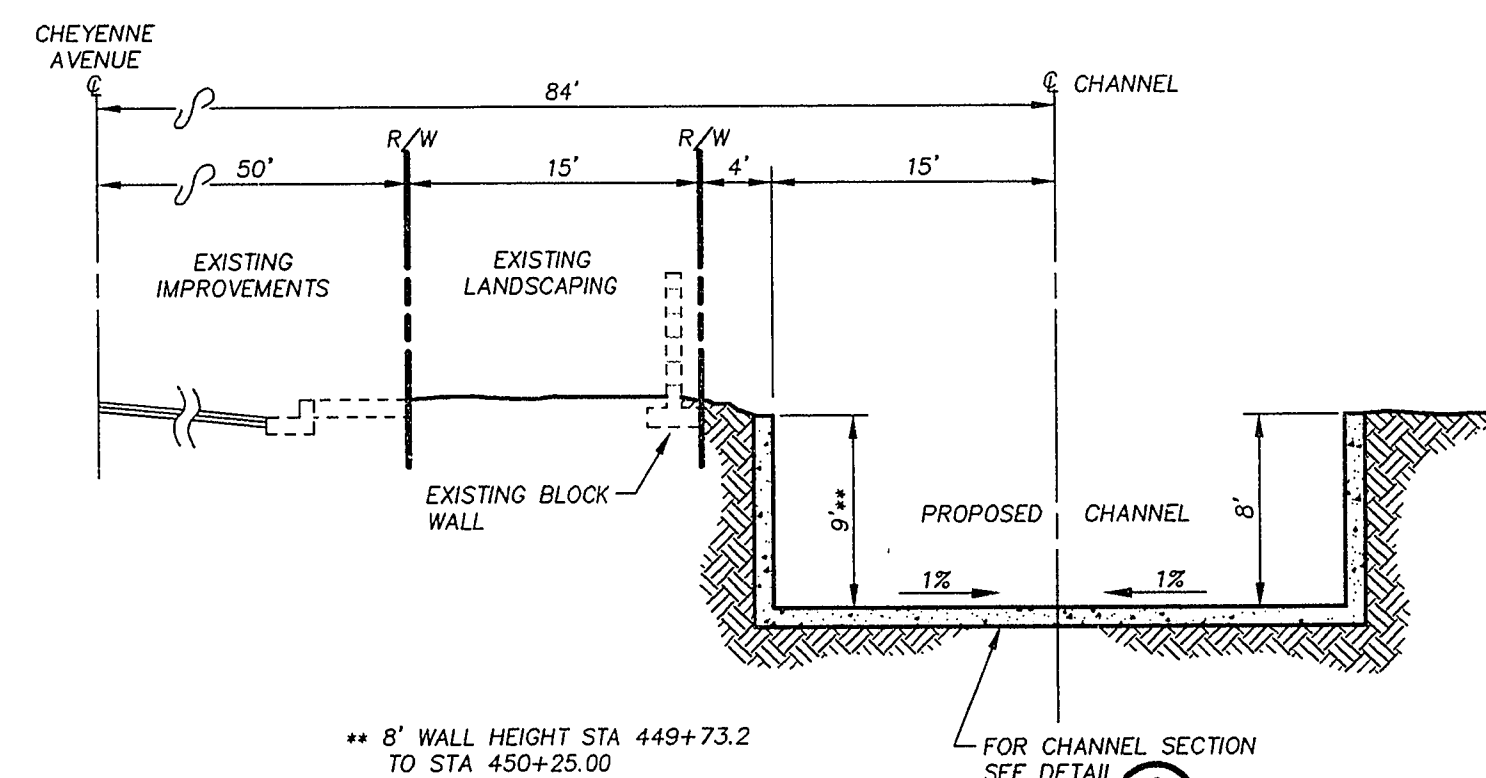

SECTION

NOT TO SCALE

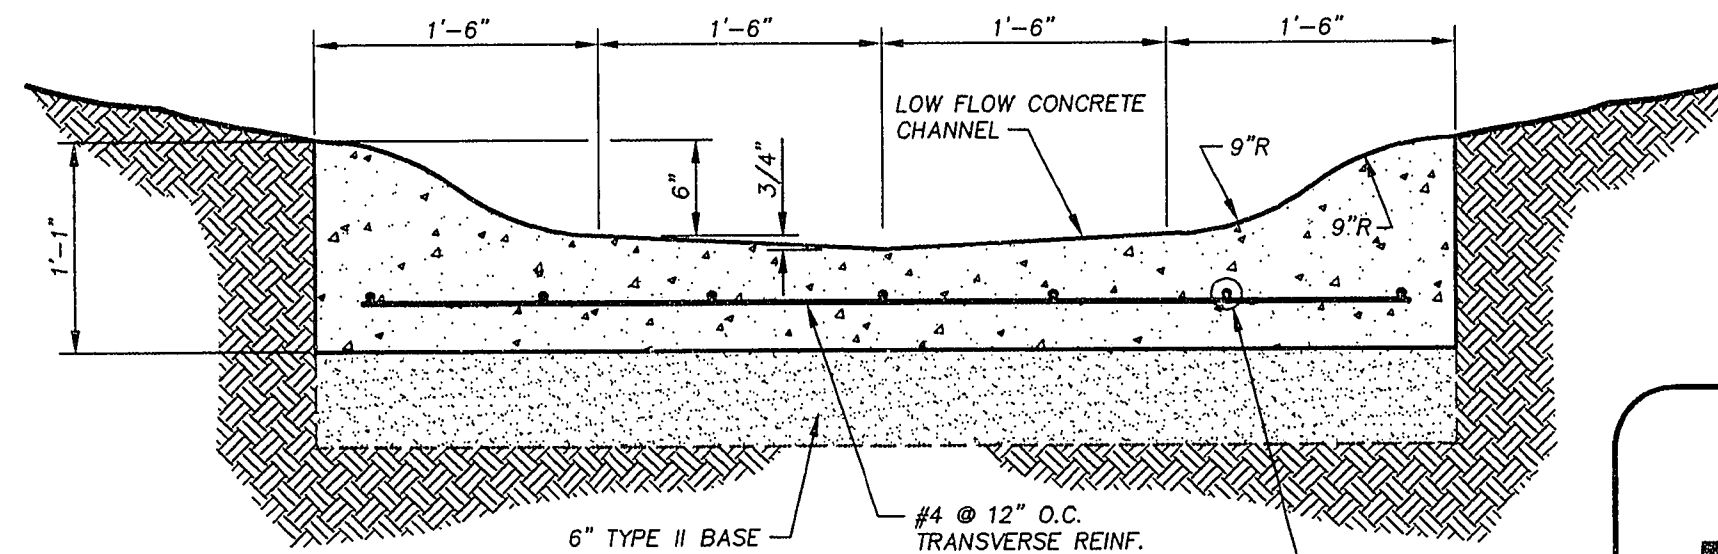


NOTE:

CONSTRUCT TRANSVERSE JOINTS IN LOW FLOW CHANNEL AT 20' SPACING


DETAIL - LOW FLOW CHANNEL

SCALE: 1" = 1'-0"

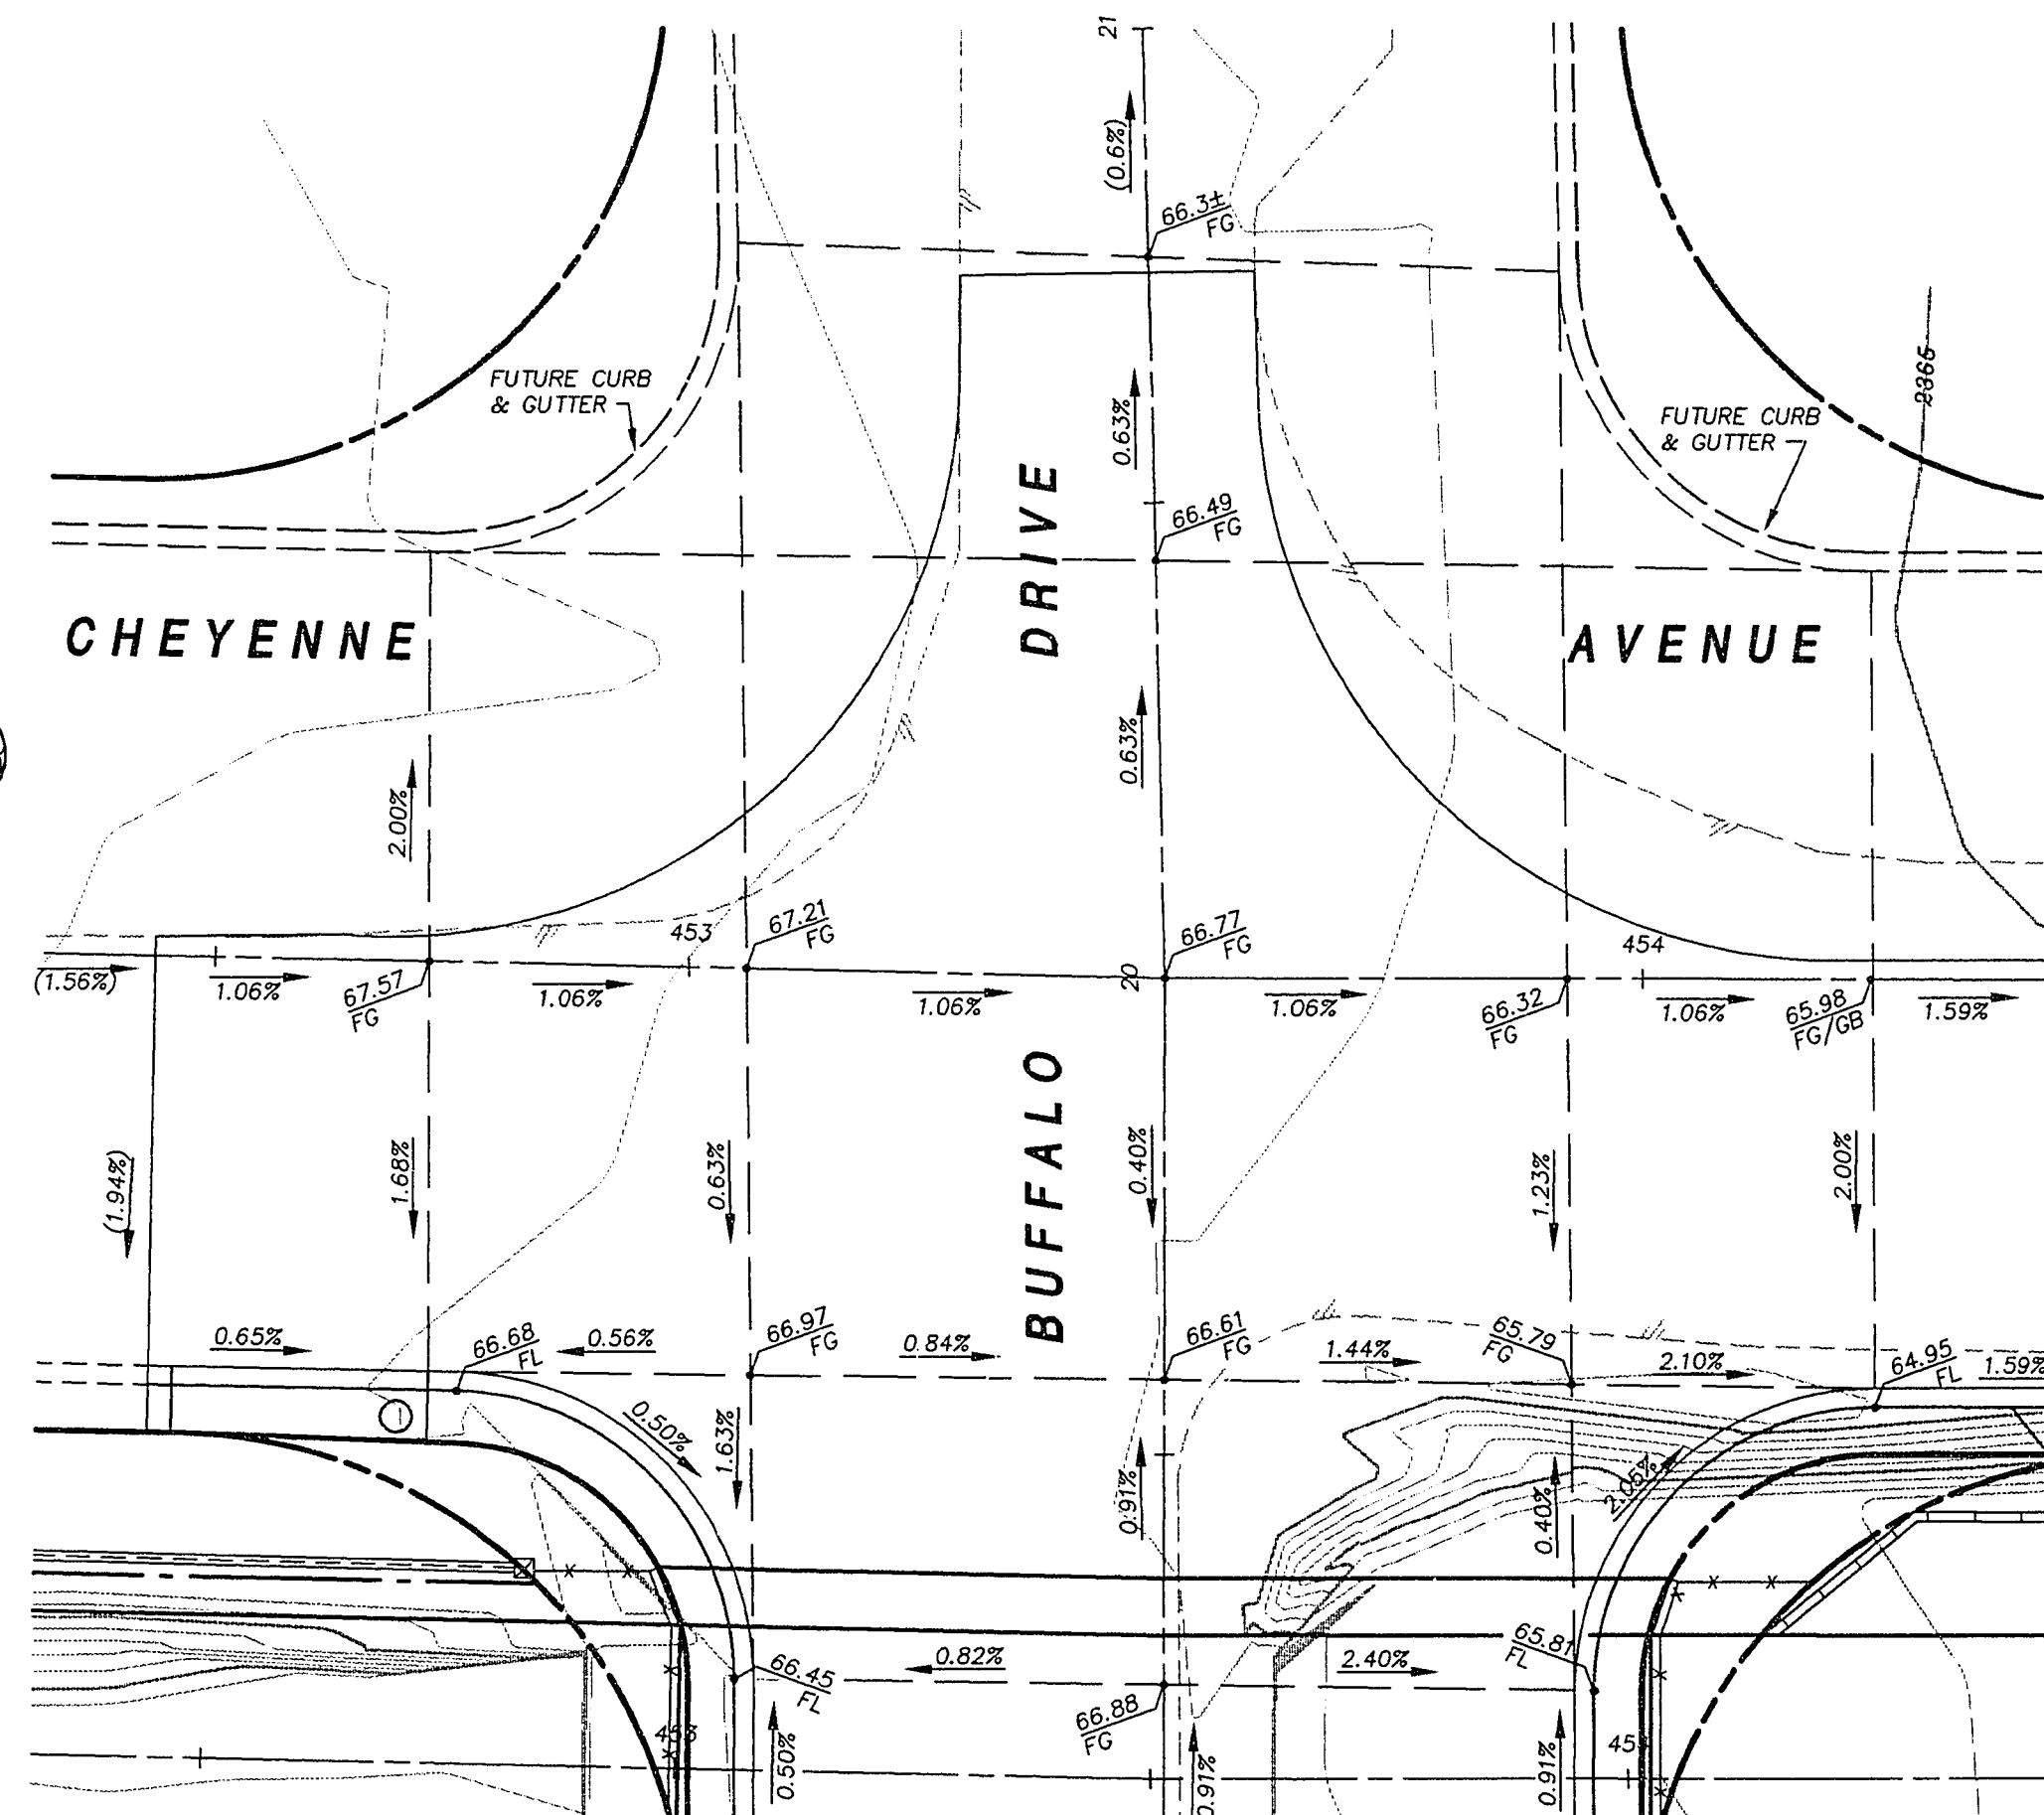

INTERSECTION GRADING PLAN

SCALE: 1" = 20'

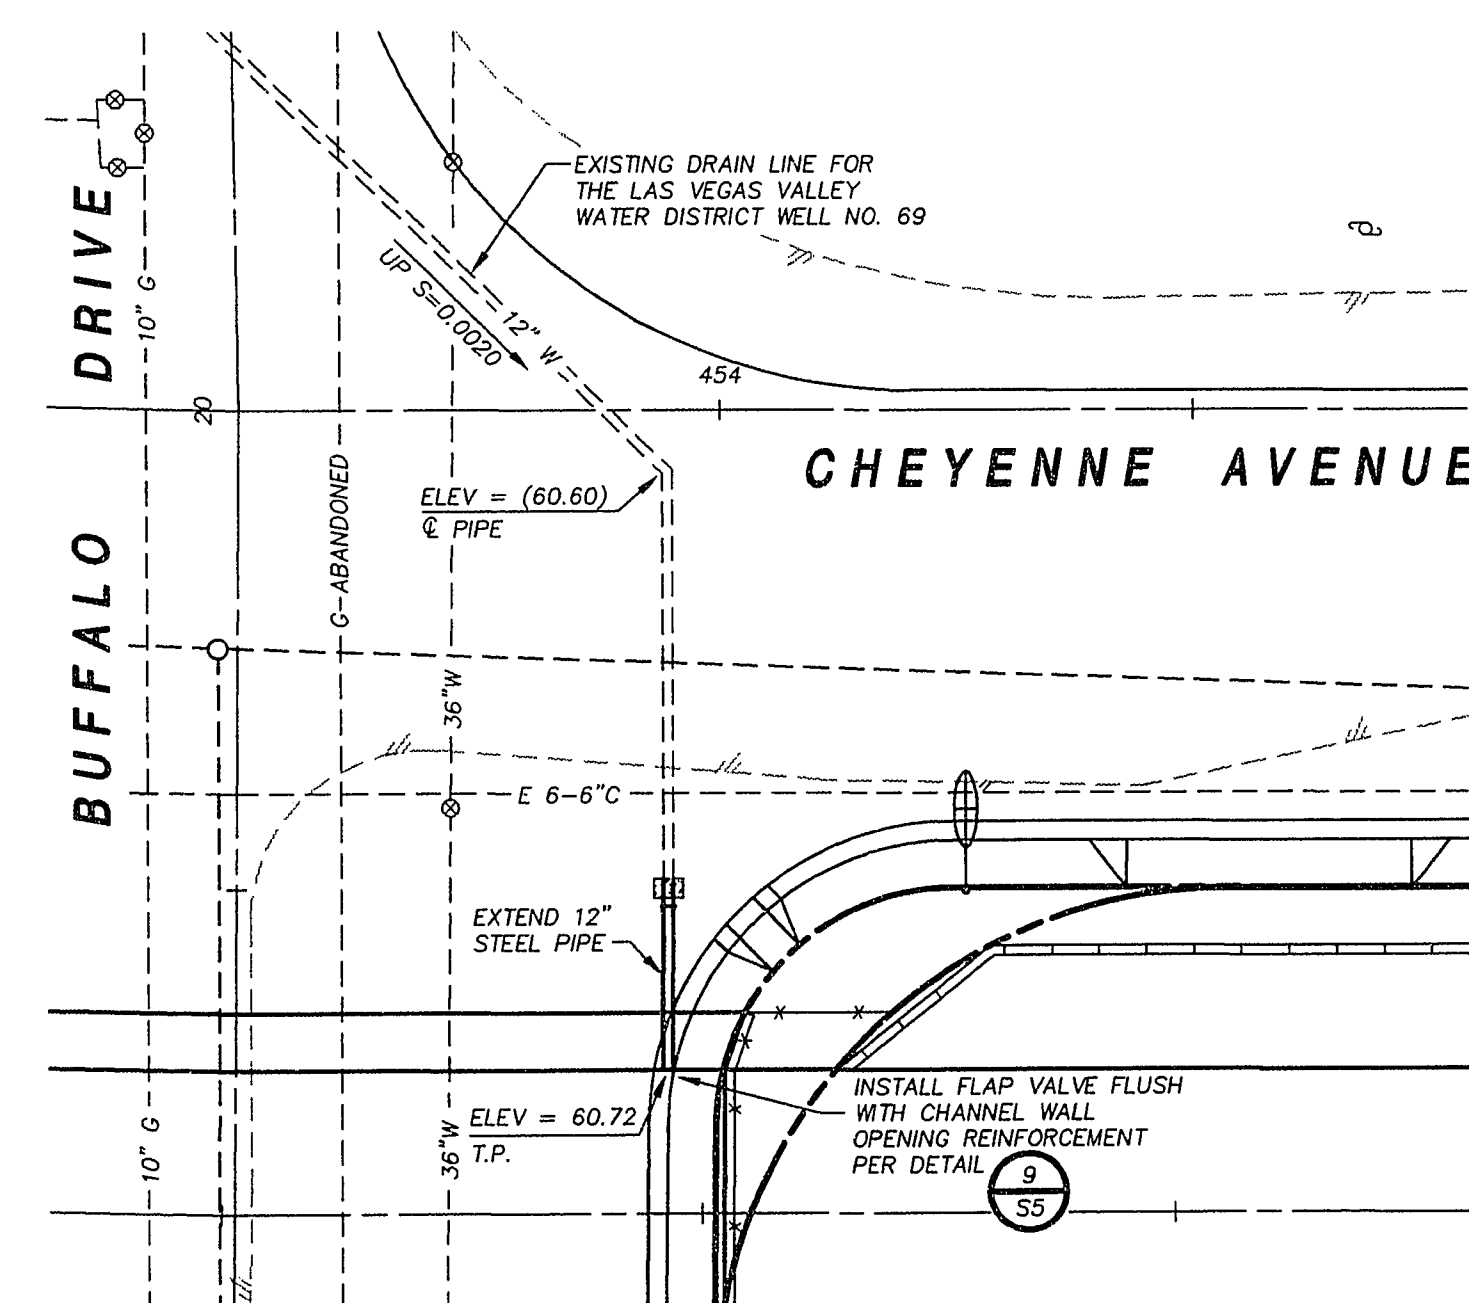

DRAIN LINE EXTENSION

SCALE: 1" = 20'

RECORD DRAWINGS

DRAFTED BY: JMA DATE 2-2-95

CHECKED BY: DTA DATE 2-2-95

REVISIONS

REV.	DESCRIPTION	BY	DATE	APPROVAL

HORIZONTAL : AS SHOWN

VERTICAL :

Job No. 7158.514

Church Engineering


A Division of
PBSI
POST
BUCKLEY,
SCHULZ &
BERNARD
ENGINEERING • PLANNING • SURVEYING • CONSTRUCTION SERVICES
6600 West Charleston Blvd.
Suite 140
Las Vegas, Nevada 89002
Telephone 702/878-6244
Fax 702/878-7758

Designed by : WEH Date : 12/21/93

Drawn by : AAS Date : 12/21/93

Checked by : PAA Date : 12/21/93

File No. : 514IMP Dwg No. : 514-10

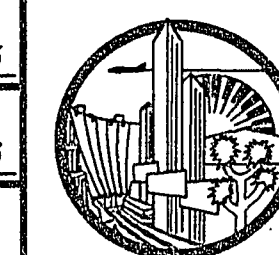

CITY OF LAS VEGAS
CHEYENNE CHANNEL IMPROVEMENTS
BID No. 94.1730.12

DETAILS

CITY OF LAS VEGAS DRAWING No. 731-58

SHEET C10