





City of Las Vegas, Nevada
Department of Design and Development
 Thomas B. Graham, AICP, RLA, Director
 INTERIOR DESIGN DIVISION
 DESIGN BY: F. TELUPANO
 DRAWN BY: F. TELUPANO
 SCALE: 1/8"=1'-0"
 DATE: 12-90

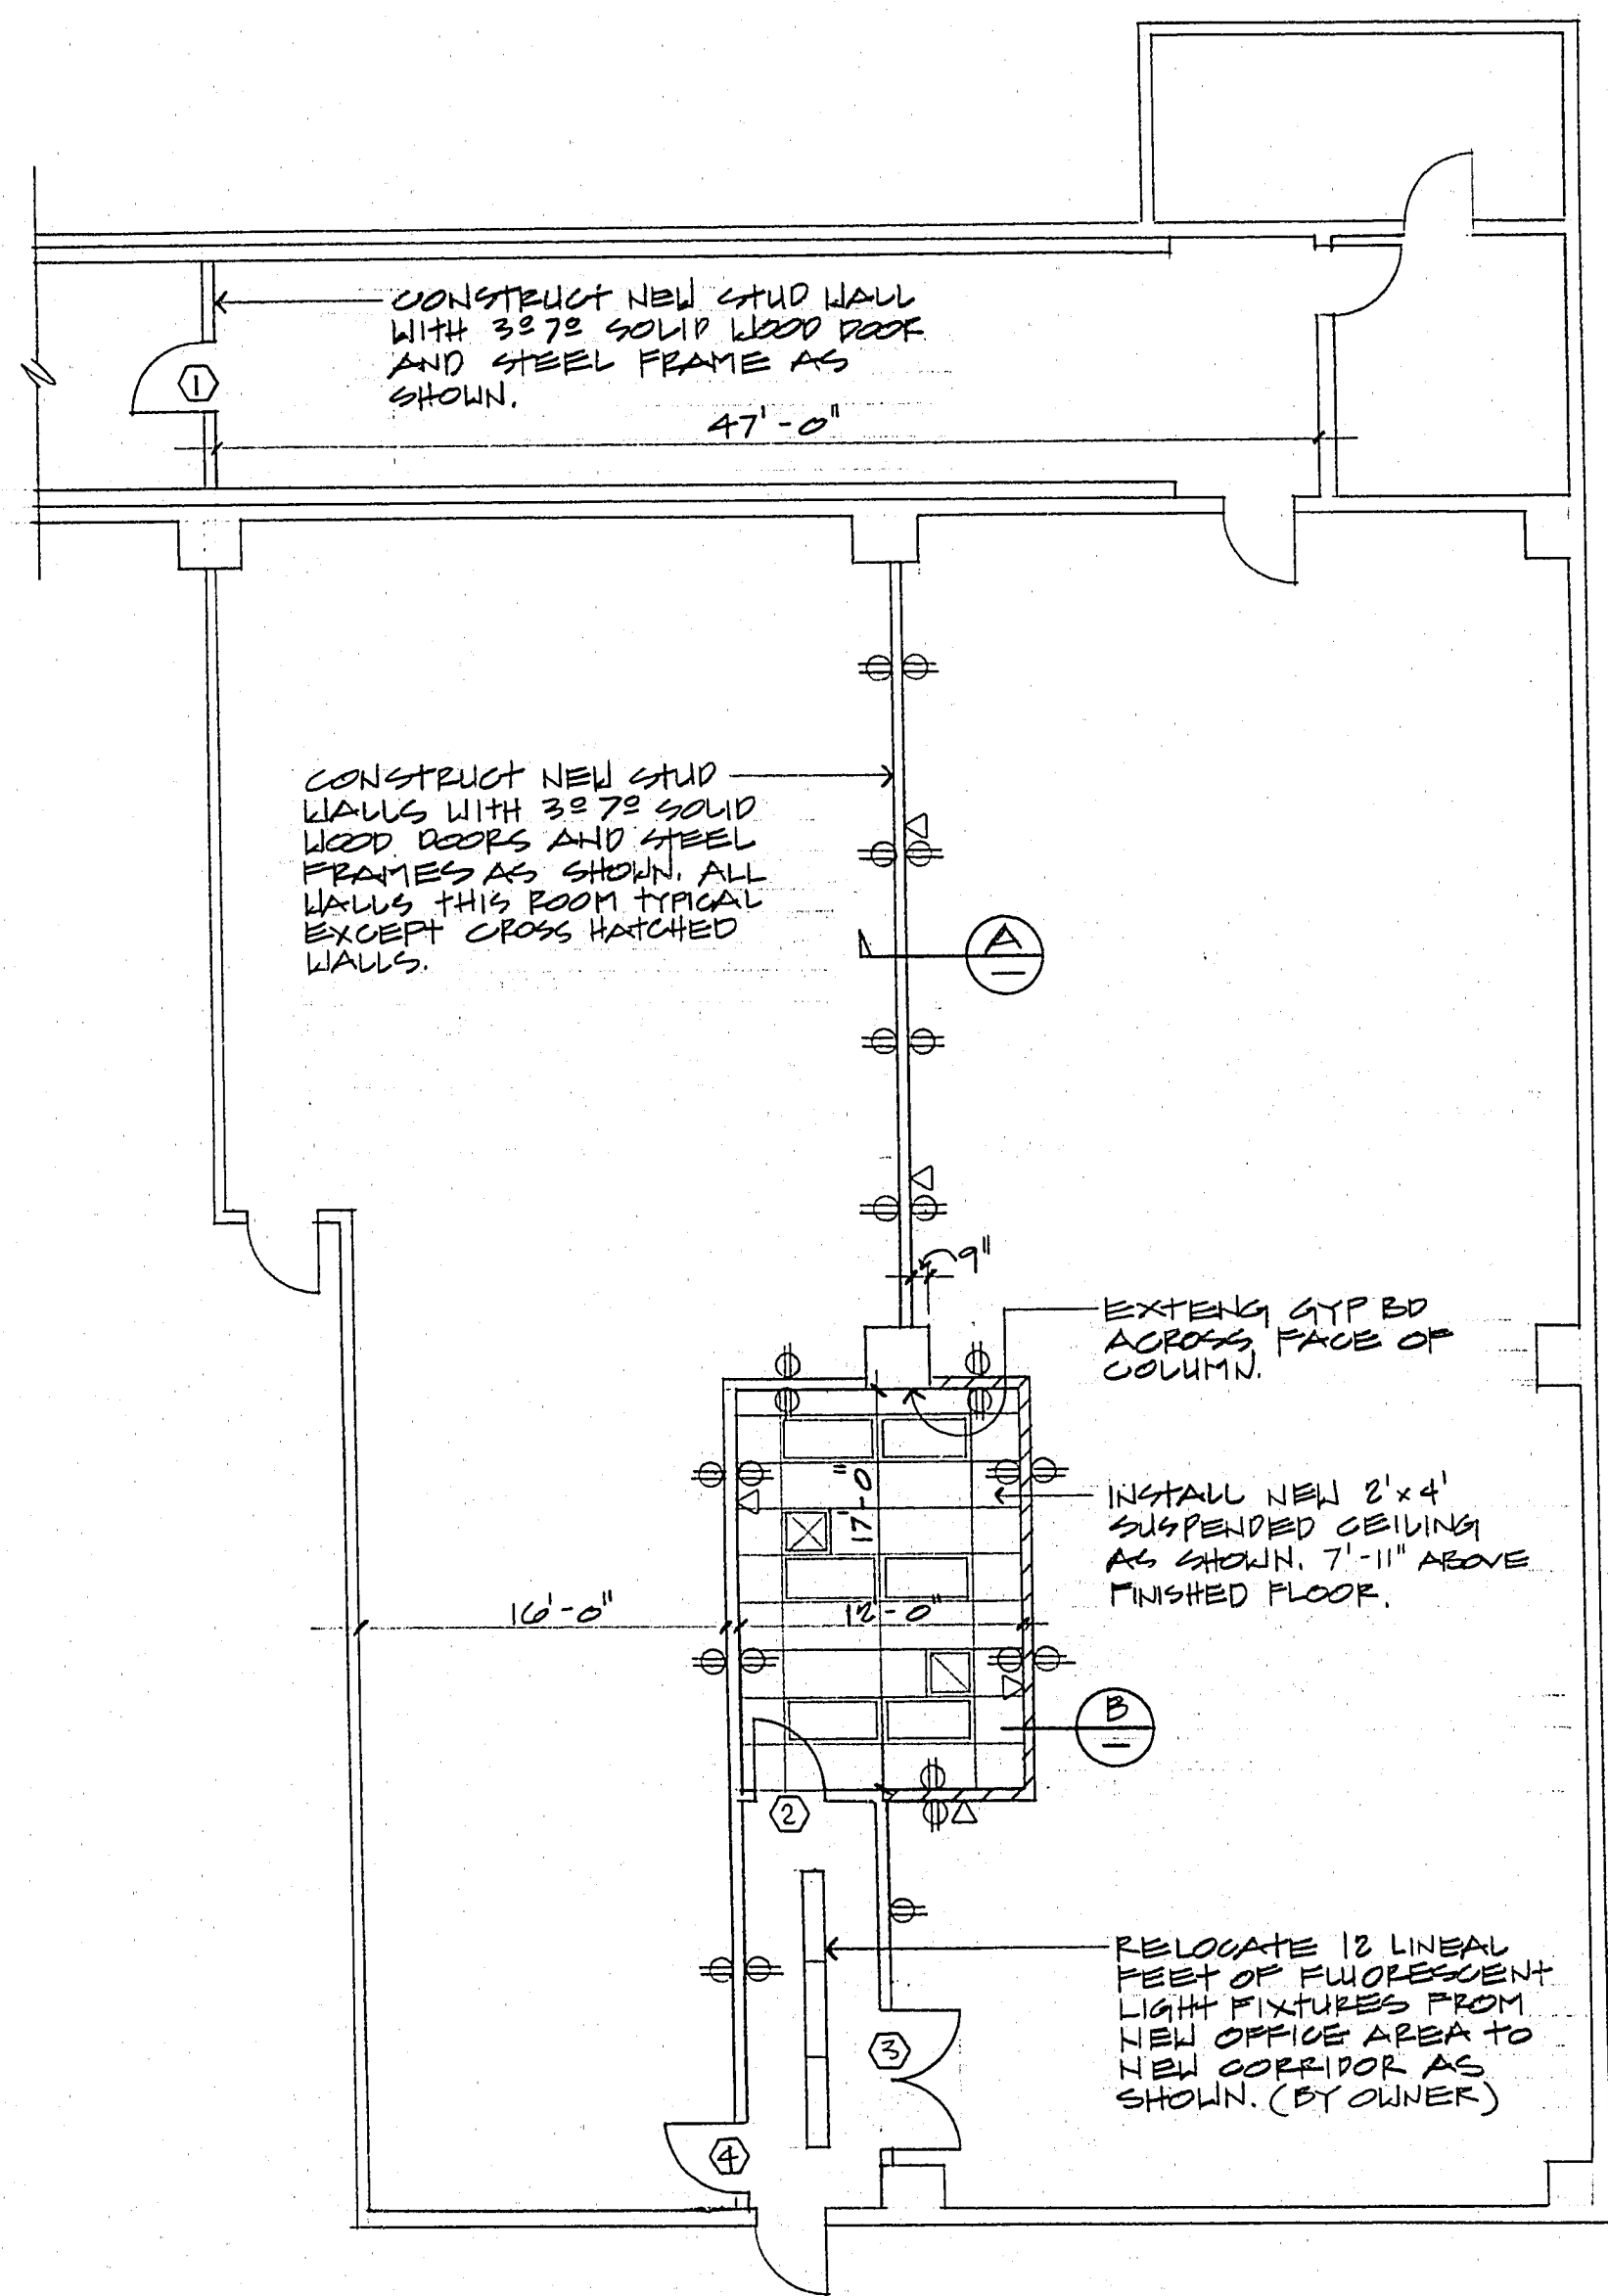


FLOOR PLAN

1/8"=1'-0"

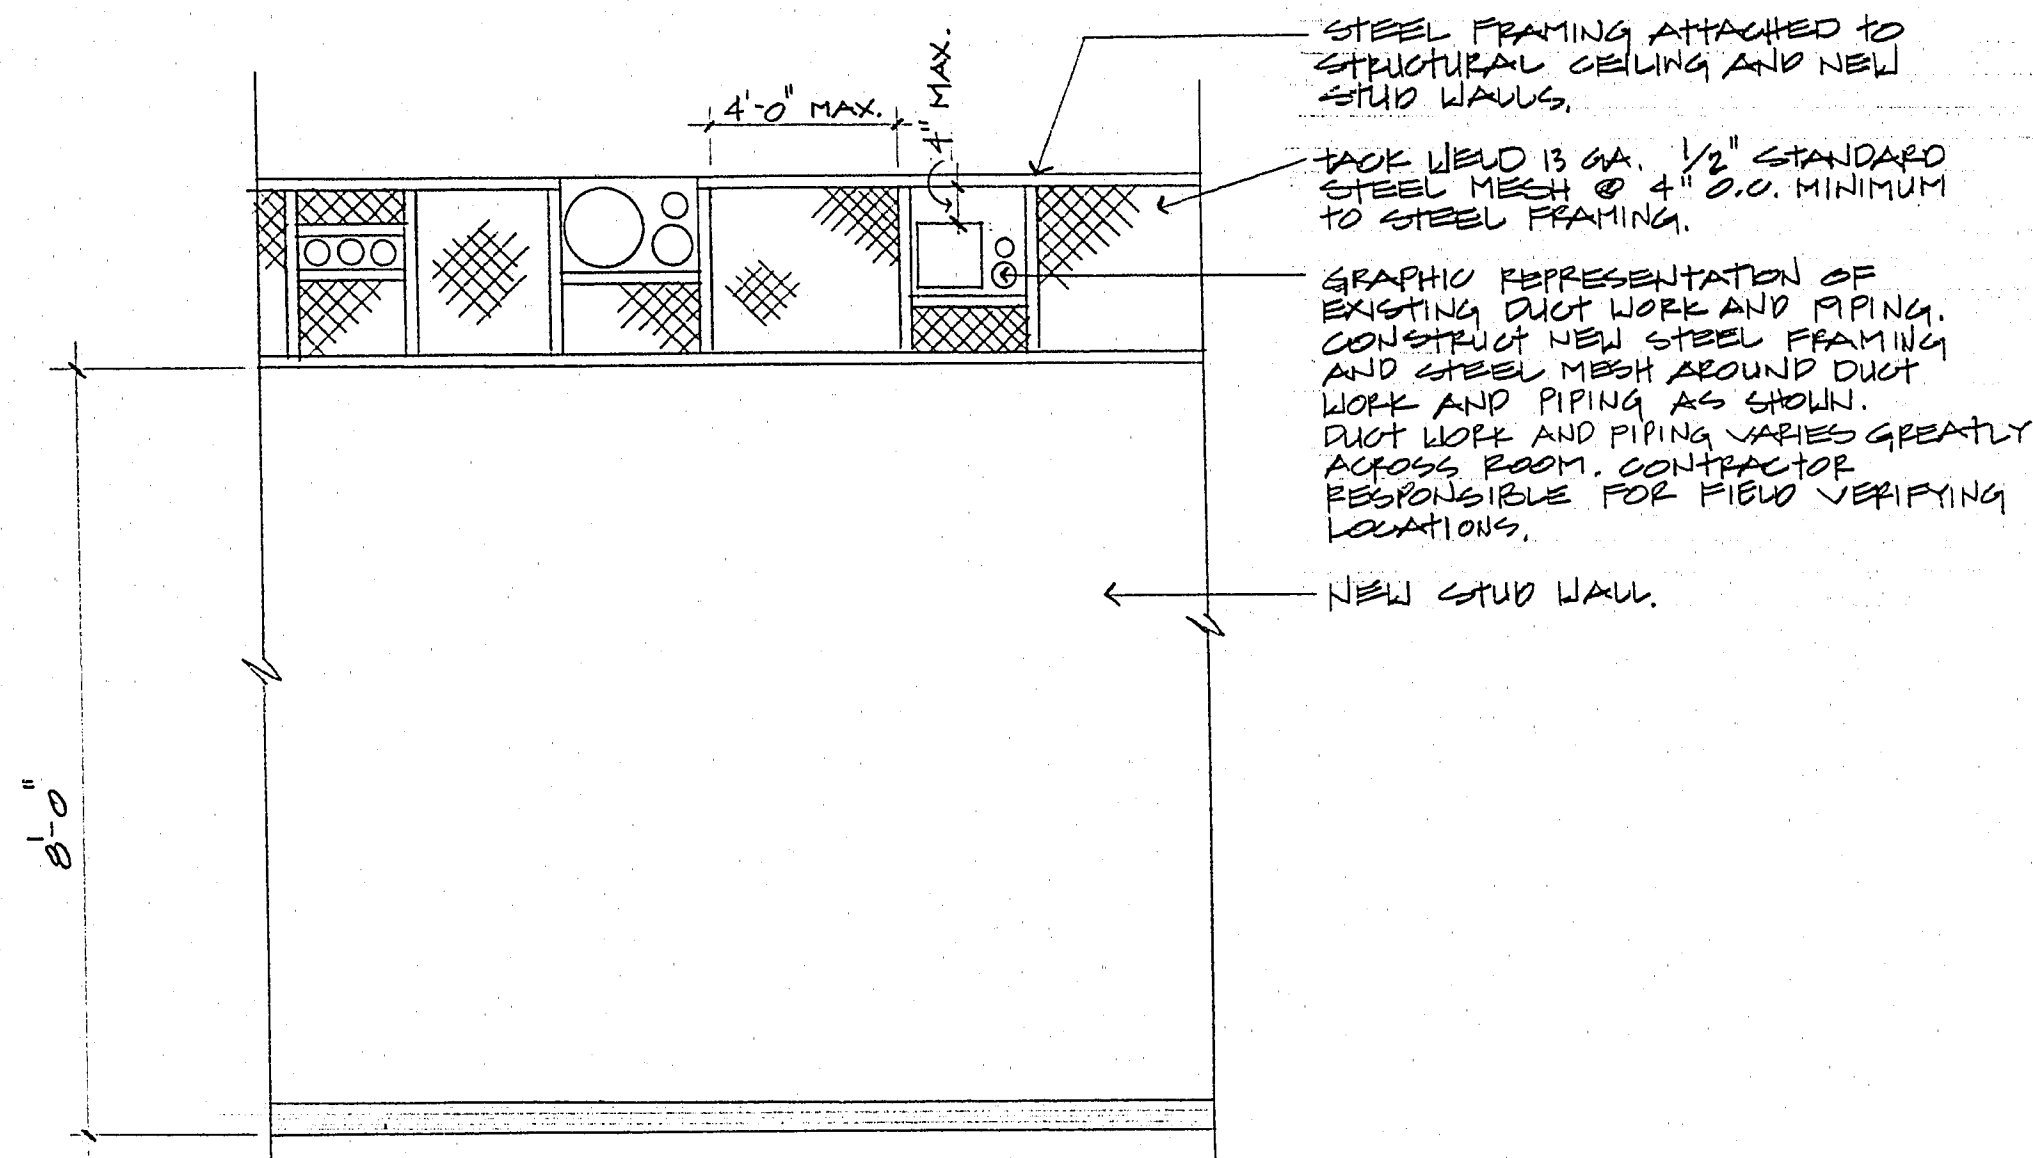

CROSS SECTION "A"

1/2"=1'-0"

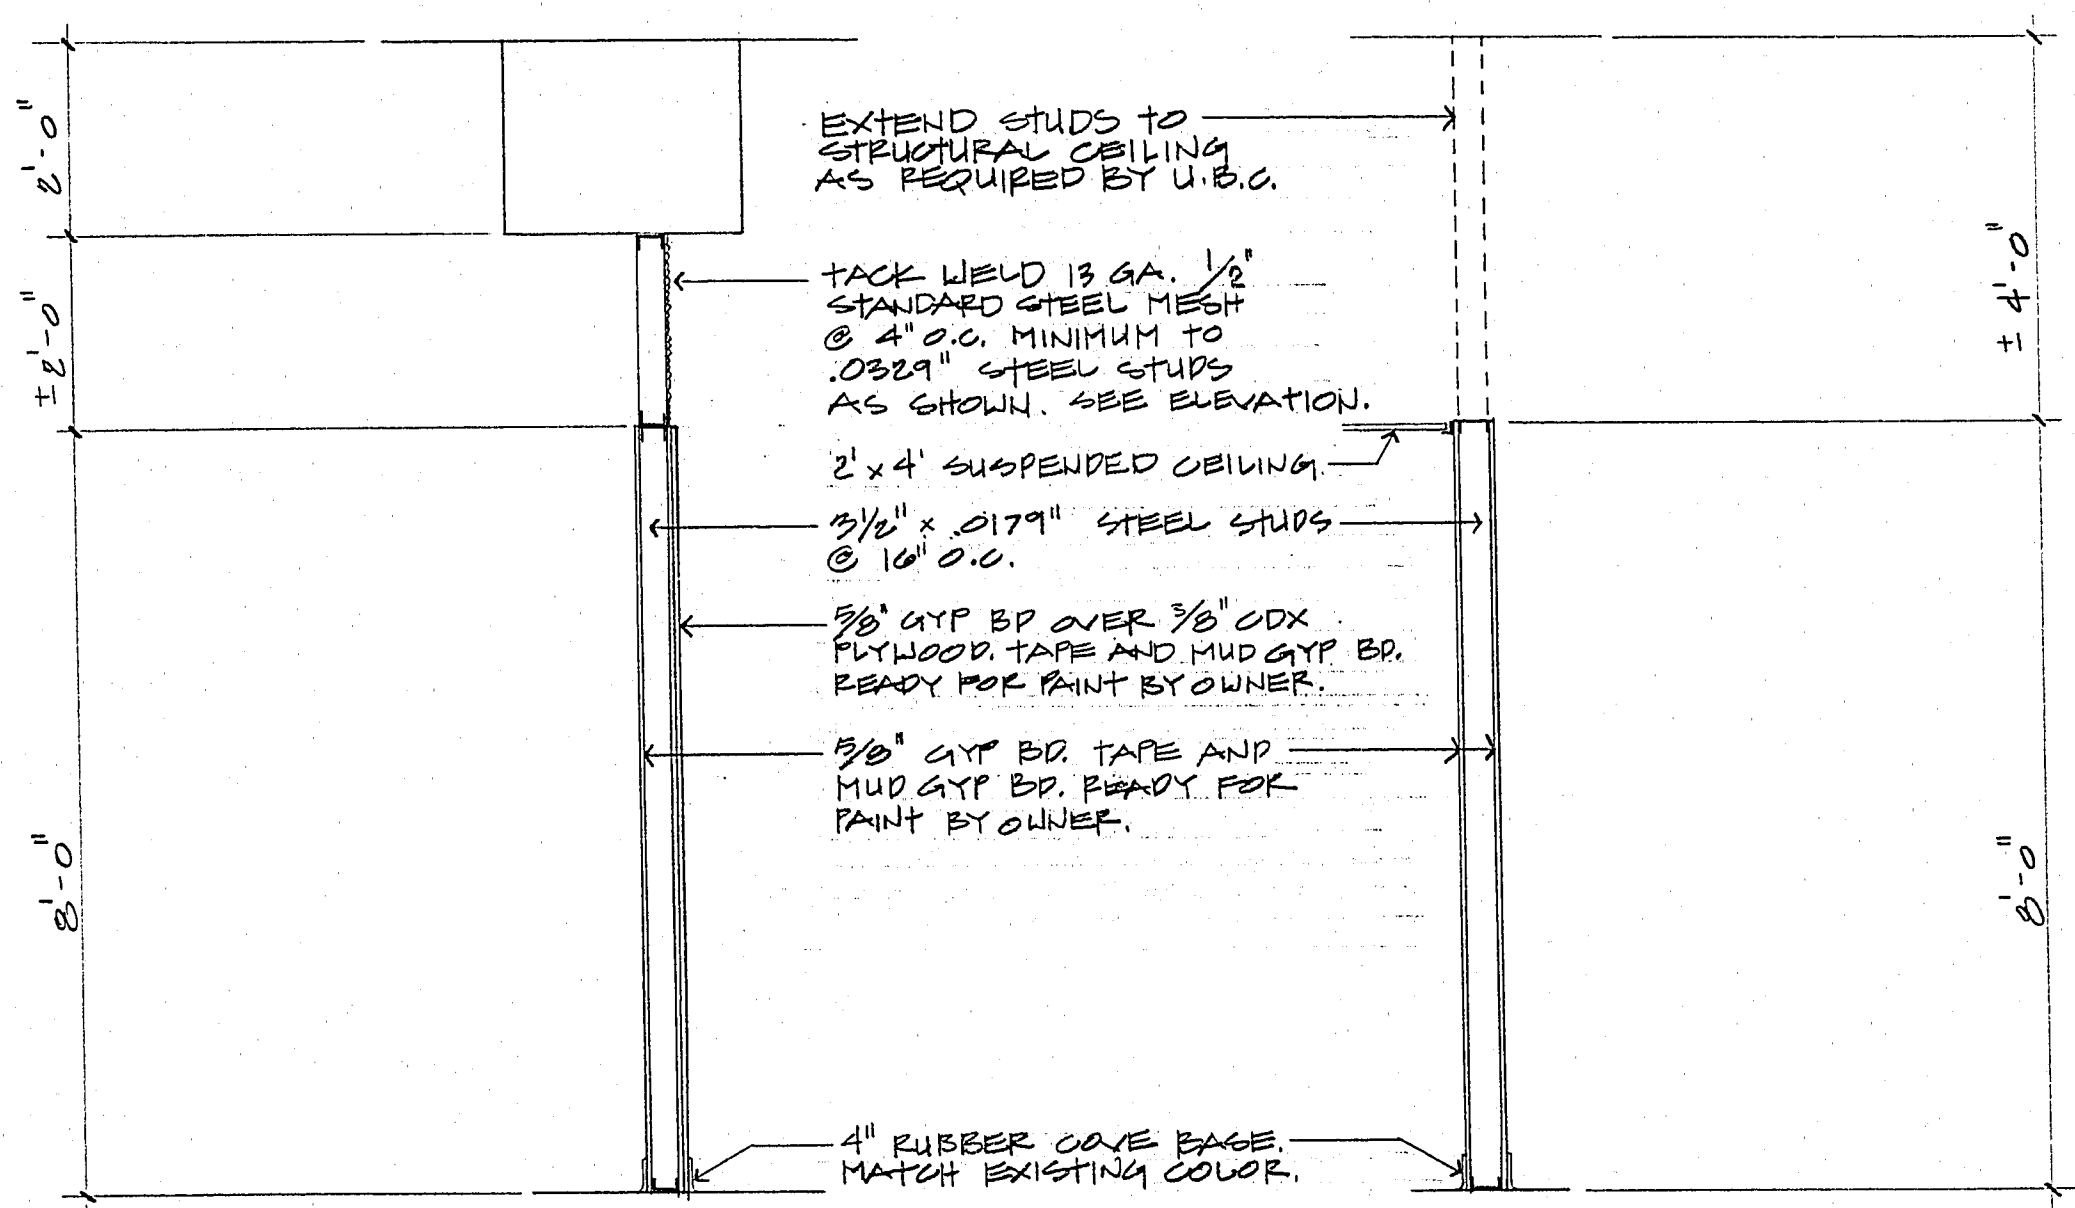

CROSS SECTION "B"

1/2"=1'-0"

NOTES

- WORK PERFORMED BY OWNER:
- ALL TELEPHONE, ELECTRICAL AND LIGHTING WORK.
 - ALL MECHANICAL WORK.
 - ALL PAINTING OF EXISTING AND NEW WALLS.
 - REPAIR EXISTING VINYL FLOOR TILE, CLEAN AND WAX ENTIRE FLOOR.

APPROVALS

DATE

Dick J. ... 11/10/91
 METROPOLITAN POLICE DEPARTMENT

Thomas B. Graham 11-11-91
 GENERAL SERVICES

Michael L. ... 11/11/91
 PUBLIC WORKS

CITY HALL RENOVATION
 BASEMENT - METRO P.D. WAREHOUSE
 FLOOR PLAN

PROJECT NO.
 DRAWING NO.
 521-213
 SHEET OF