




10-34

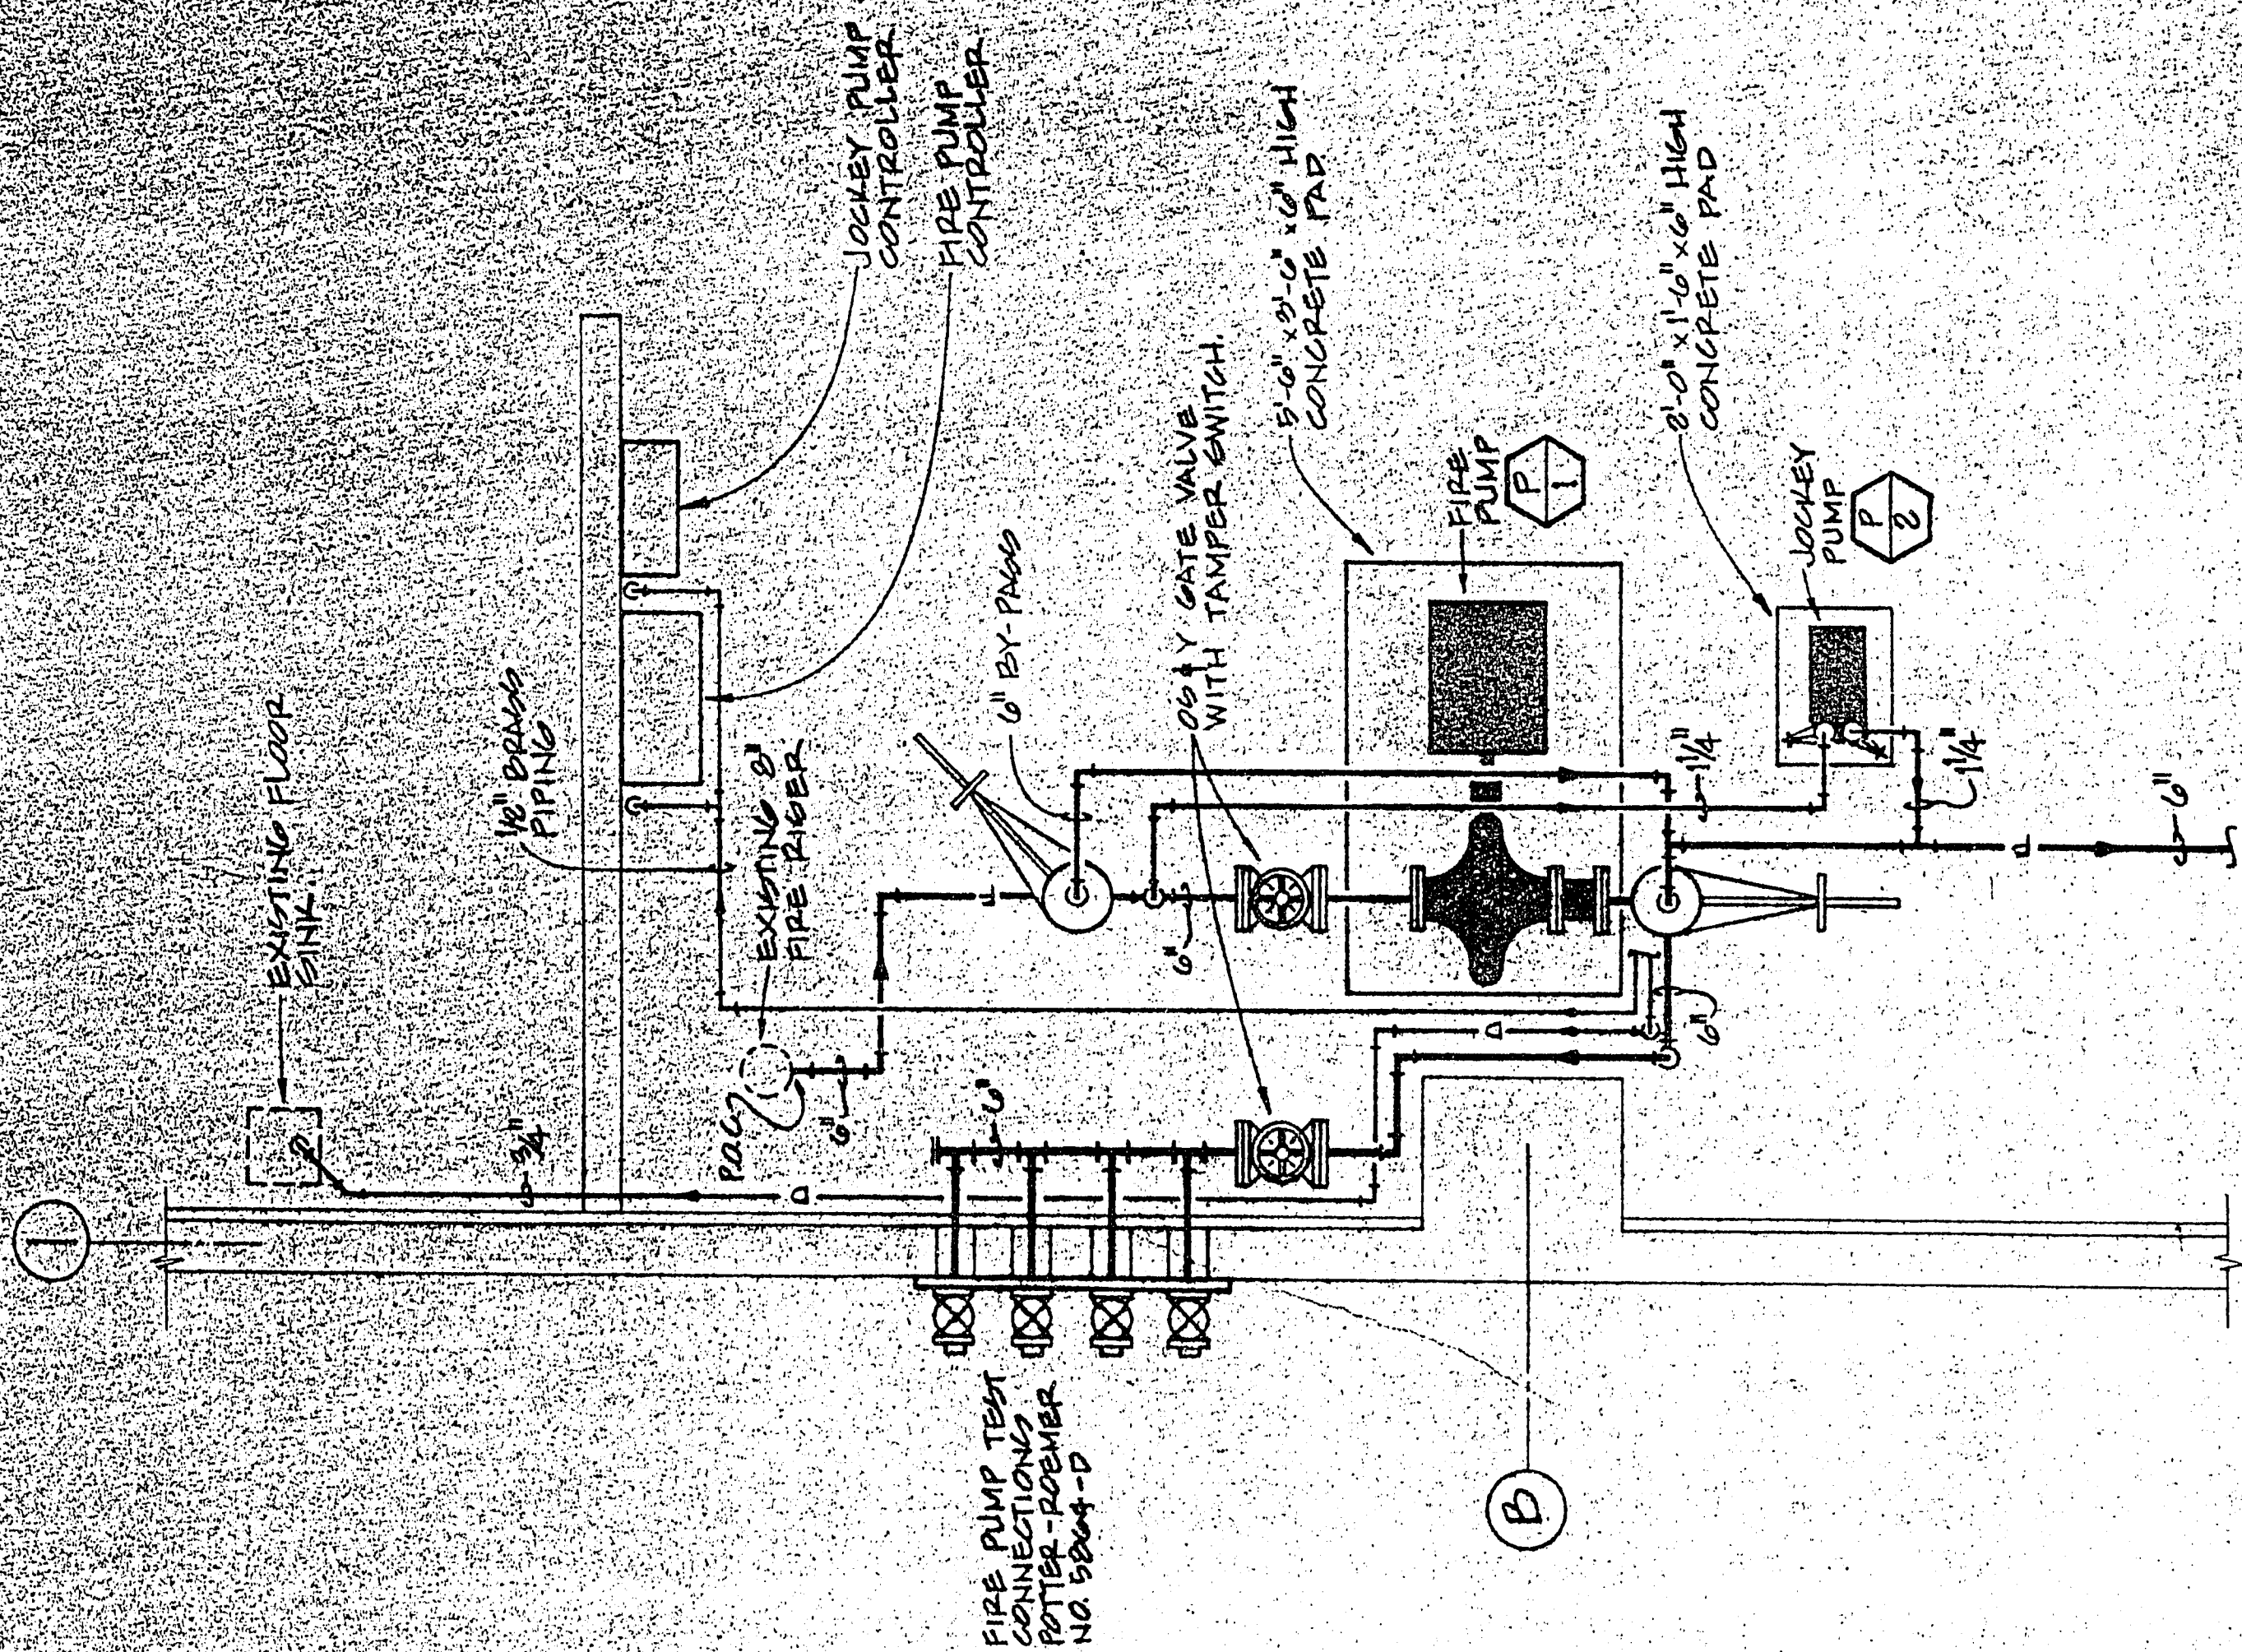

FIRE PUMP INSTALLATION
SCALE: 1/2" = 1' - 0"

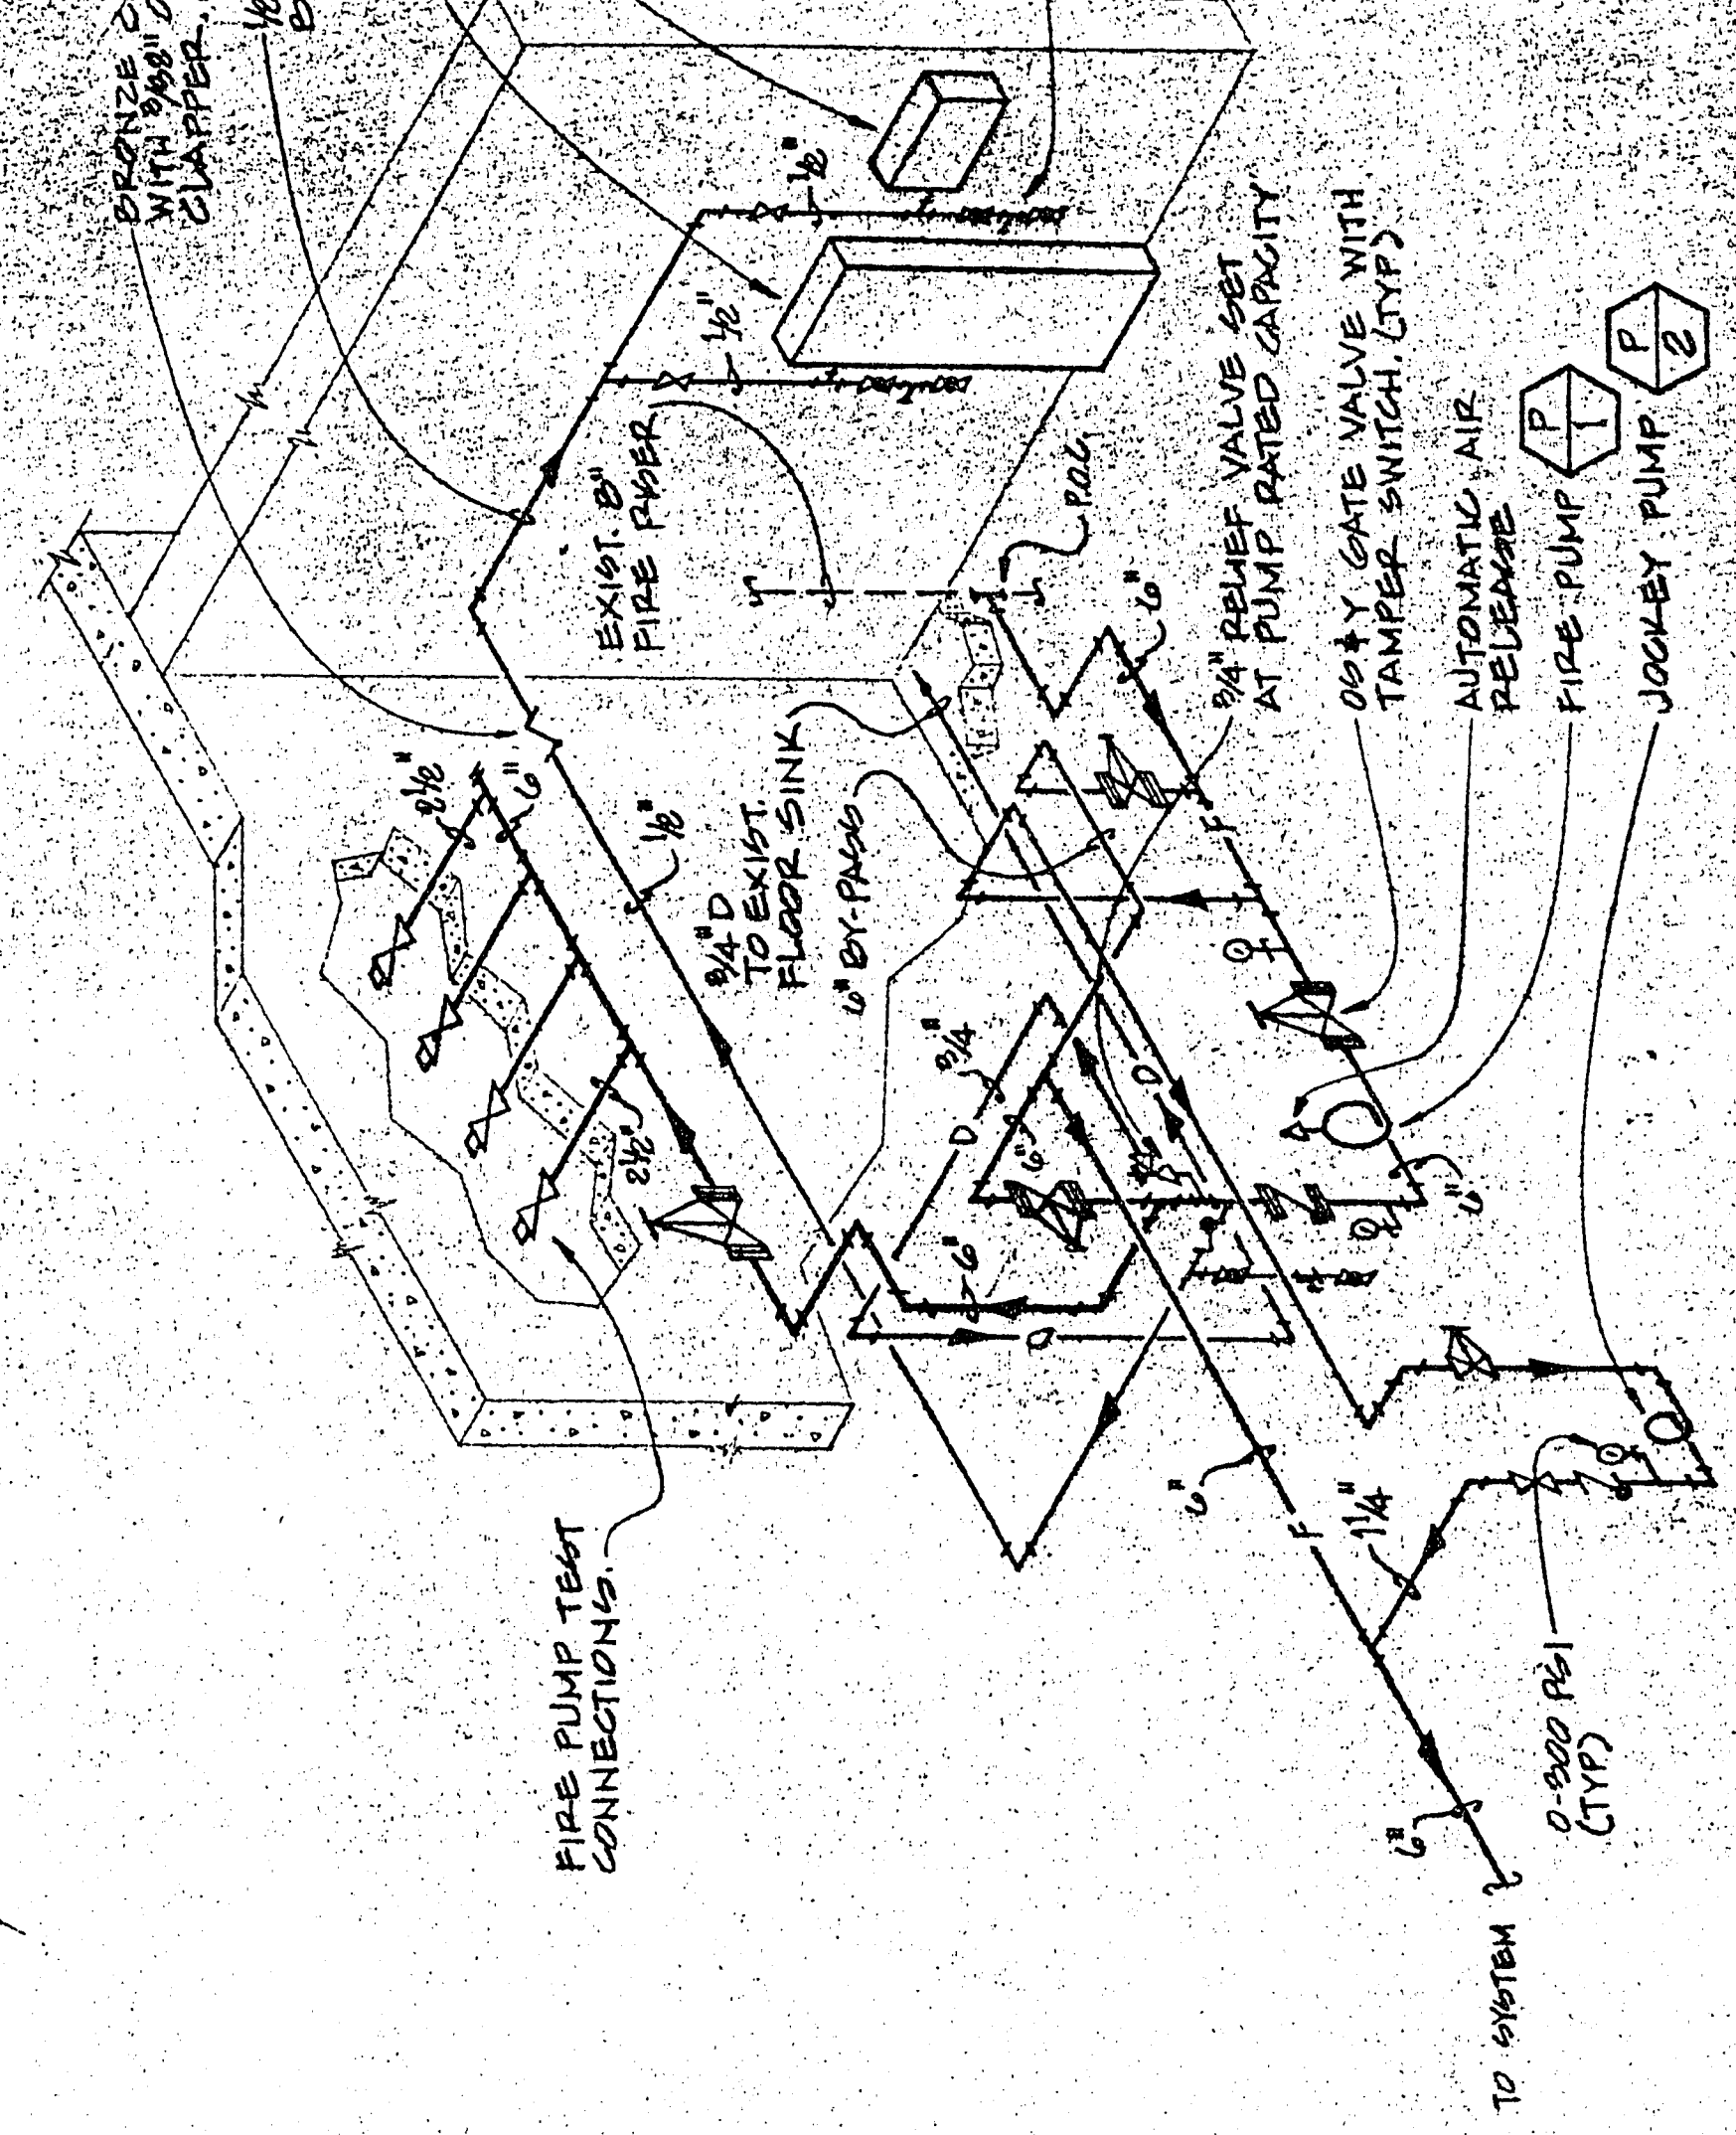

FIRE PUMP INSTALLATION - ISOMETRIC
NOT TO SCALE

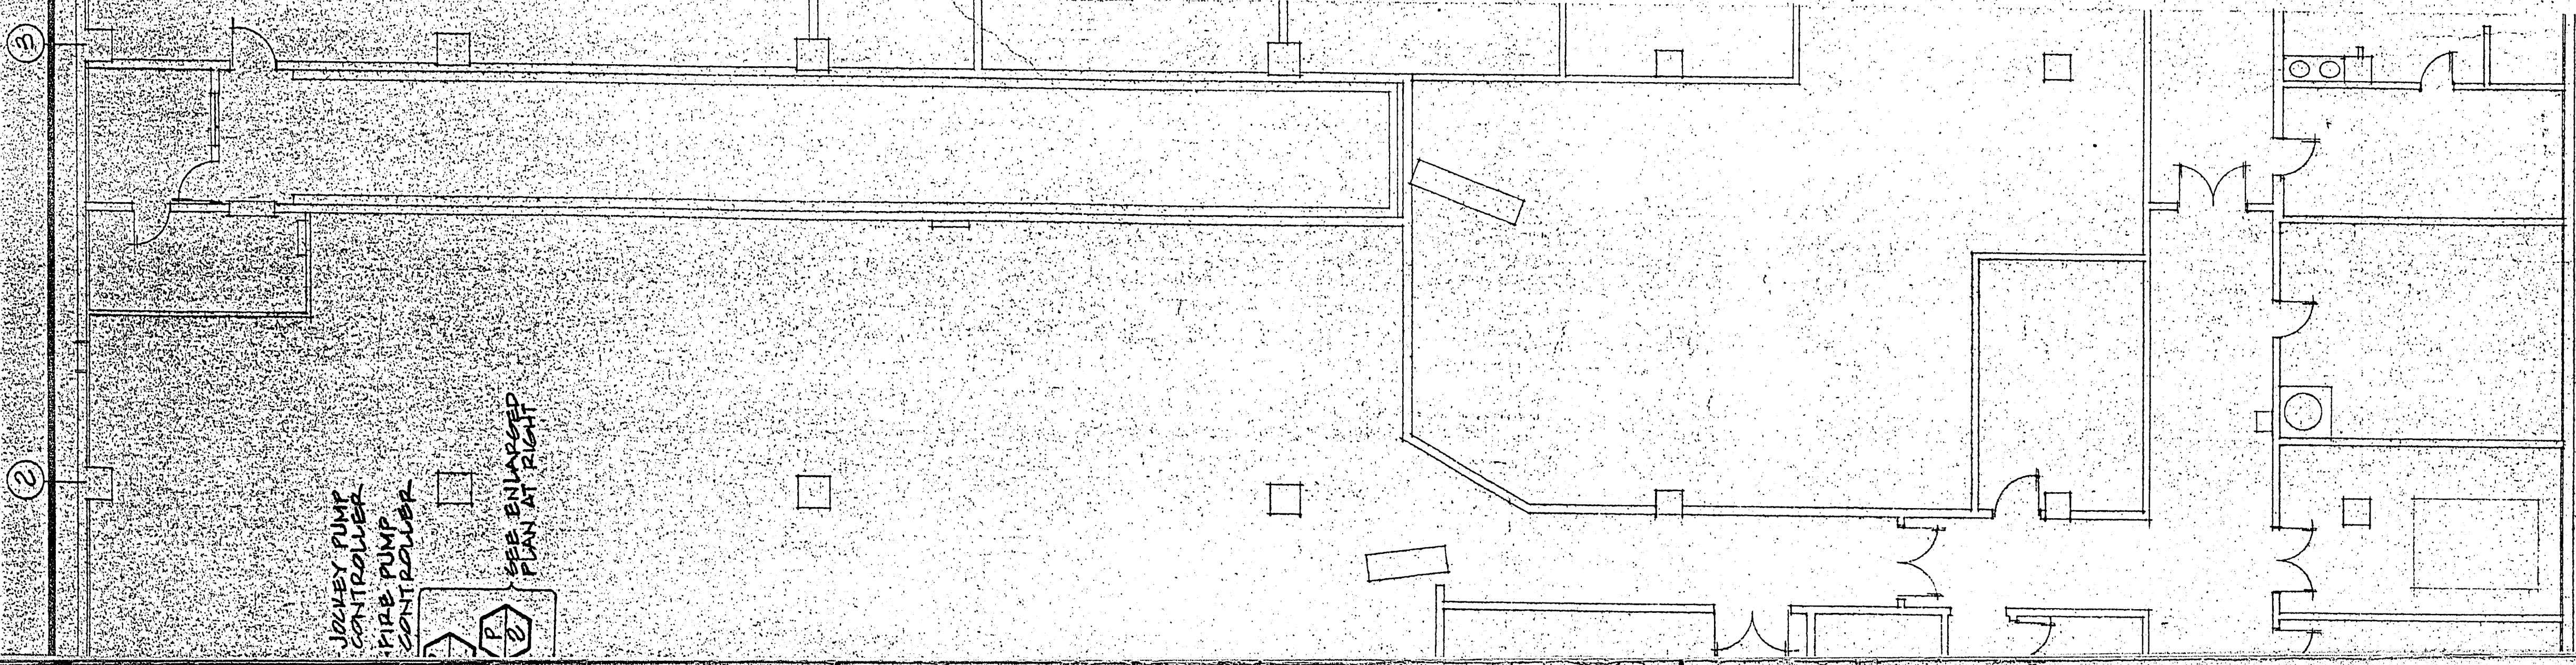

F LAS VEGAS

JOB TITLE: CITY HALL RETROFIT
SHEET TITLE: BASEMENT FLOOR PLAN

REVISION	DATE	DESCRIPTION	BY	DATE

DESIGNED BY: HP
DRAWN BY: WJ
CHECKED BY: LJA
DATE: 10/1/89

PROJECT NO. 521-216
SHEET NO. 4 OF 8

