


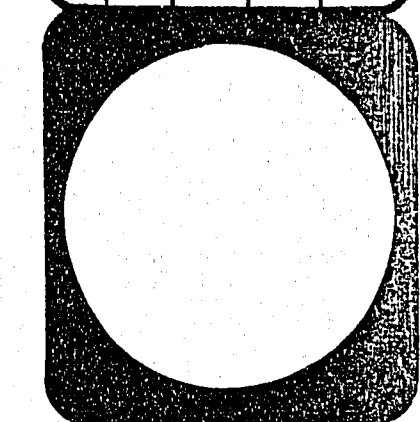

City of Las Vegas, Nevada  
**Department of Design and Development**  
 Thomas B. Graham, AICP, RLA, Director  
 INTERIOR DESIGN DIVISION  
 DESIGN BY: F. TRUFIANO  
 SCALE: 1/8" = 1'-0"  
 DATE: 5-11

REVISIONS	DATE




**CITY HALL - THIRD FLOOR RENOVATION**  
 CONTRACT "D" - FIRE SUPPRESSION SYSTEM  
 NEW FLOOR PLAN  
 BID NO. 92.0850.4

PROJECT NO.  
 DRAWING NO.  
 521-210D  
 SHEET OF 8

INDEX OF SHEETS

NO.	DESCRIPTION
1	FLOOR PLAN, NEW CONSTRUCTION
2	REFLECTED CEILING PLAN
3-8	AS-BUILT DRAWINGS - "IMPROVEMENTS - LIFE SAFETY SYSTEMS" PREPARED BY: DMJM-ARCHITECTS & ENGINEERS

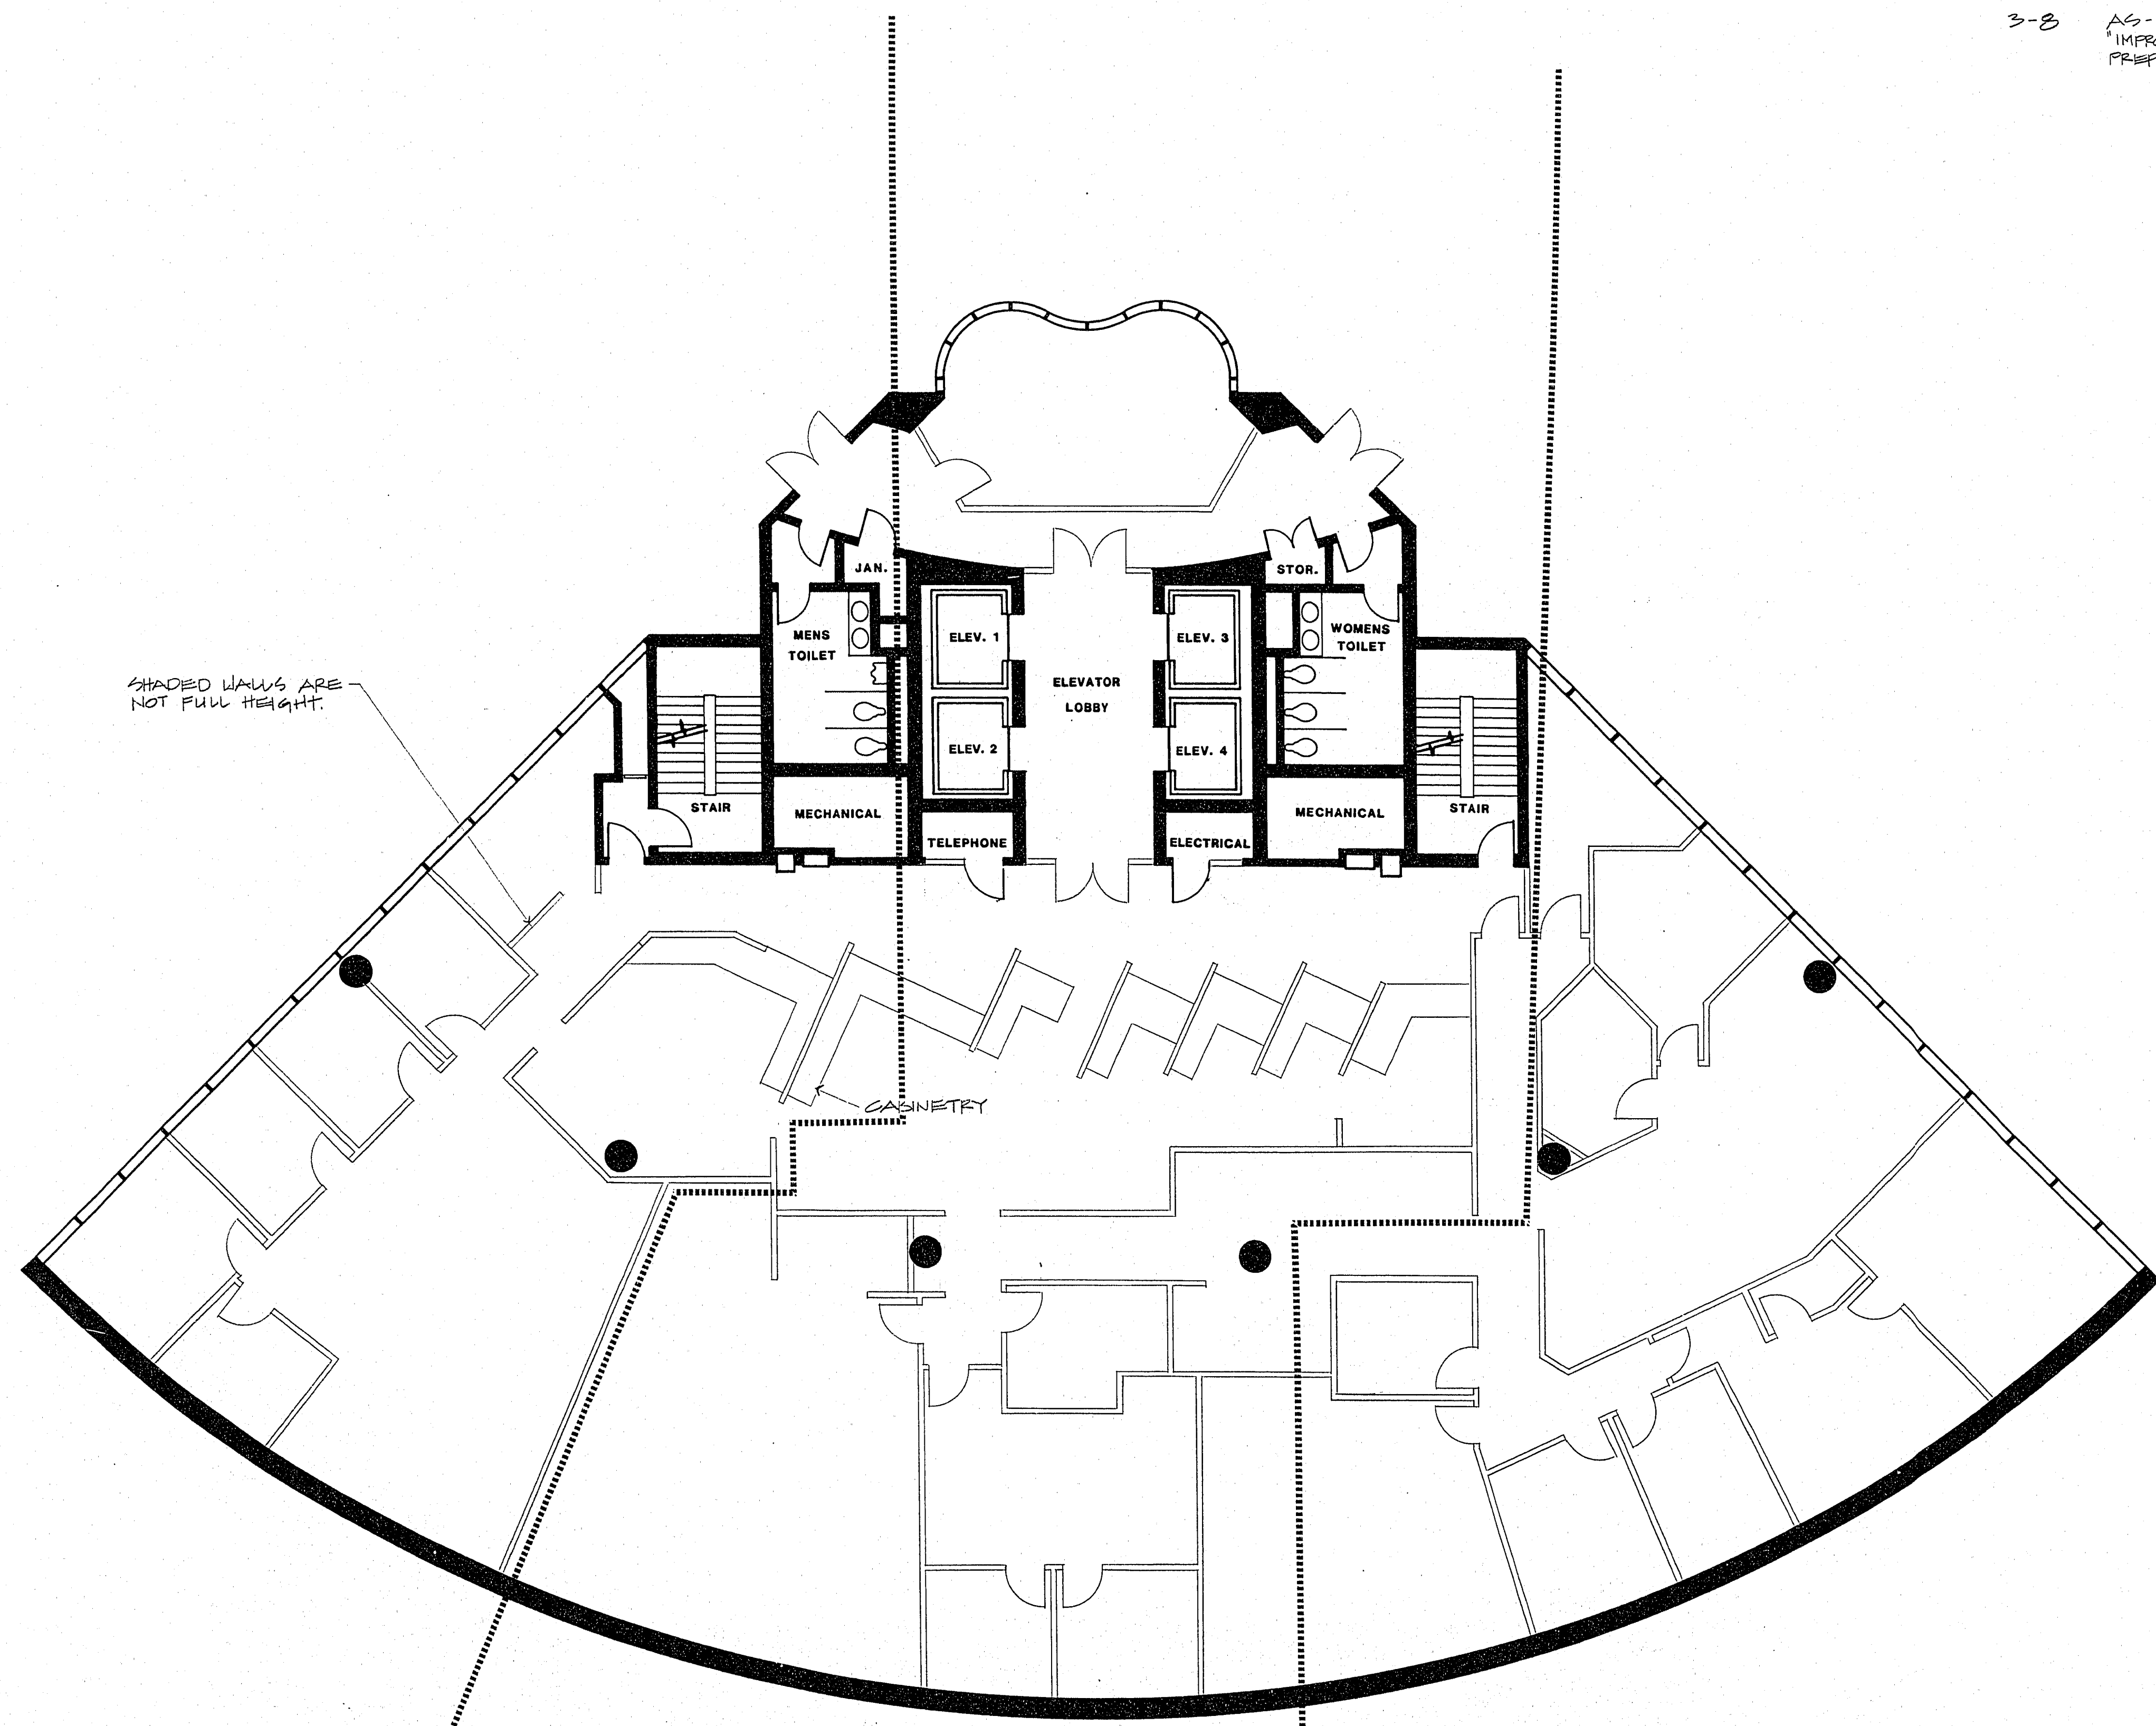

SHADED WALLS ARE NOT FULL HEIGHT.

PHASE ONE

PHASE TWO

PHASE THREE

CITY HALL - THIRD FLOOR NEW FLOOR PLAN

1/8" = 1'-0"