




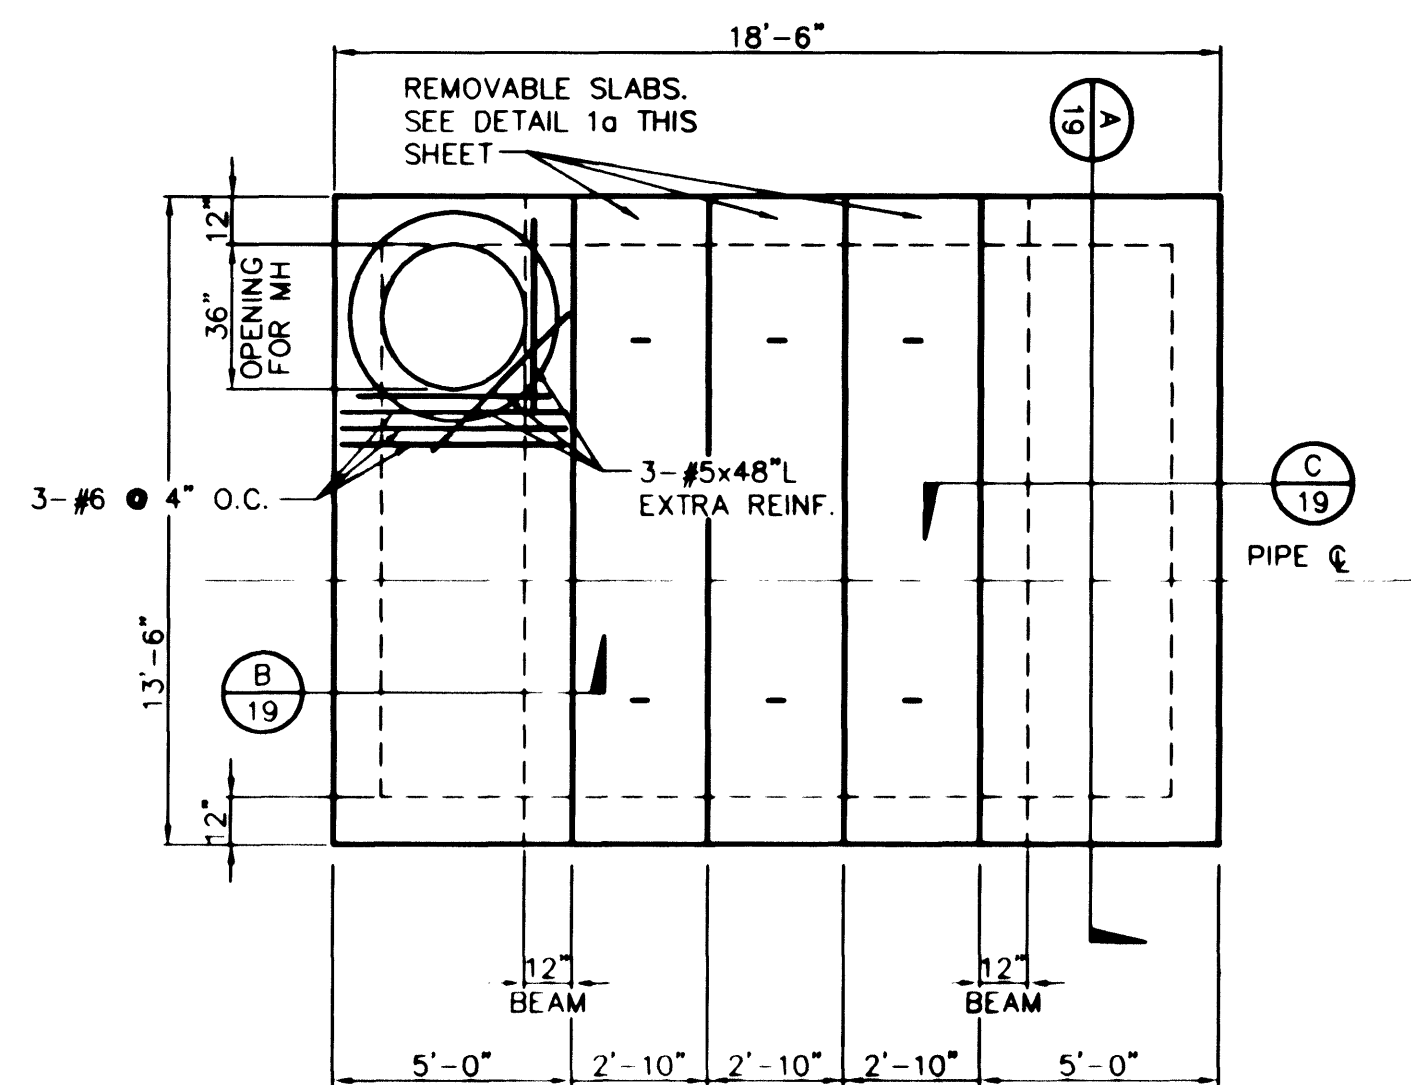


1 PLAN - ROOF SLAB
SCALE: 1/4"=1'-0"

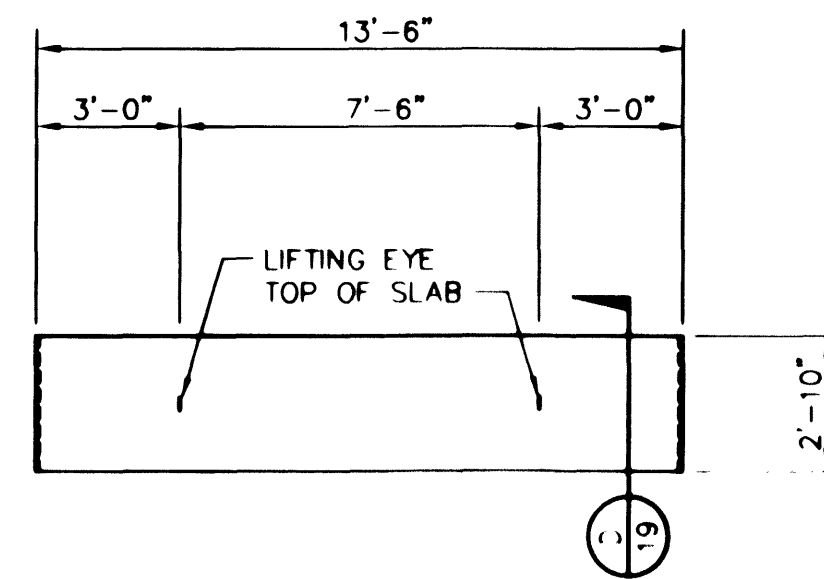


1a REMOVABLE ROOF SLAB
SCALE: 1/4"=1'-0"

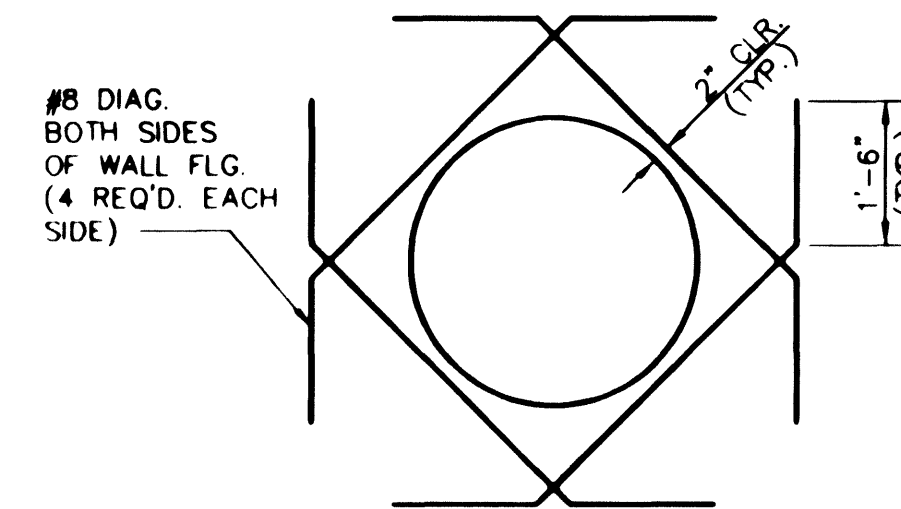


2 WALL OPENING REINFORCEMENT DETAIL
SCALE: 1/4"=1'-0"

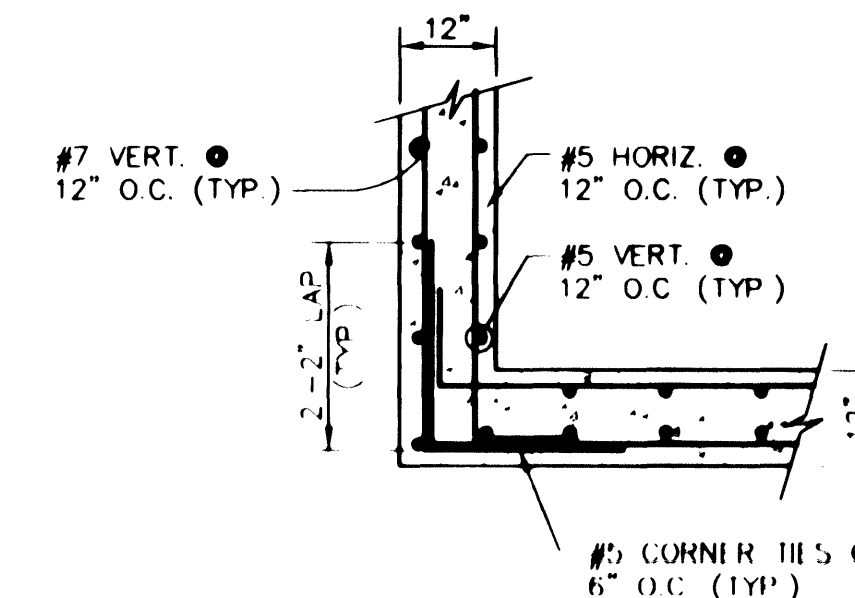


3 WALL CORNER BAR DETAIL
N.T.S.

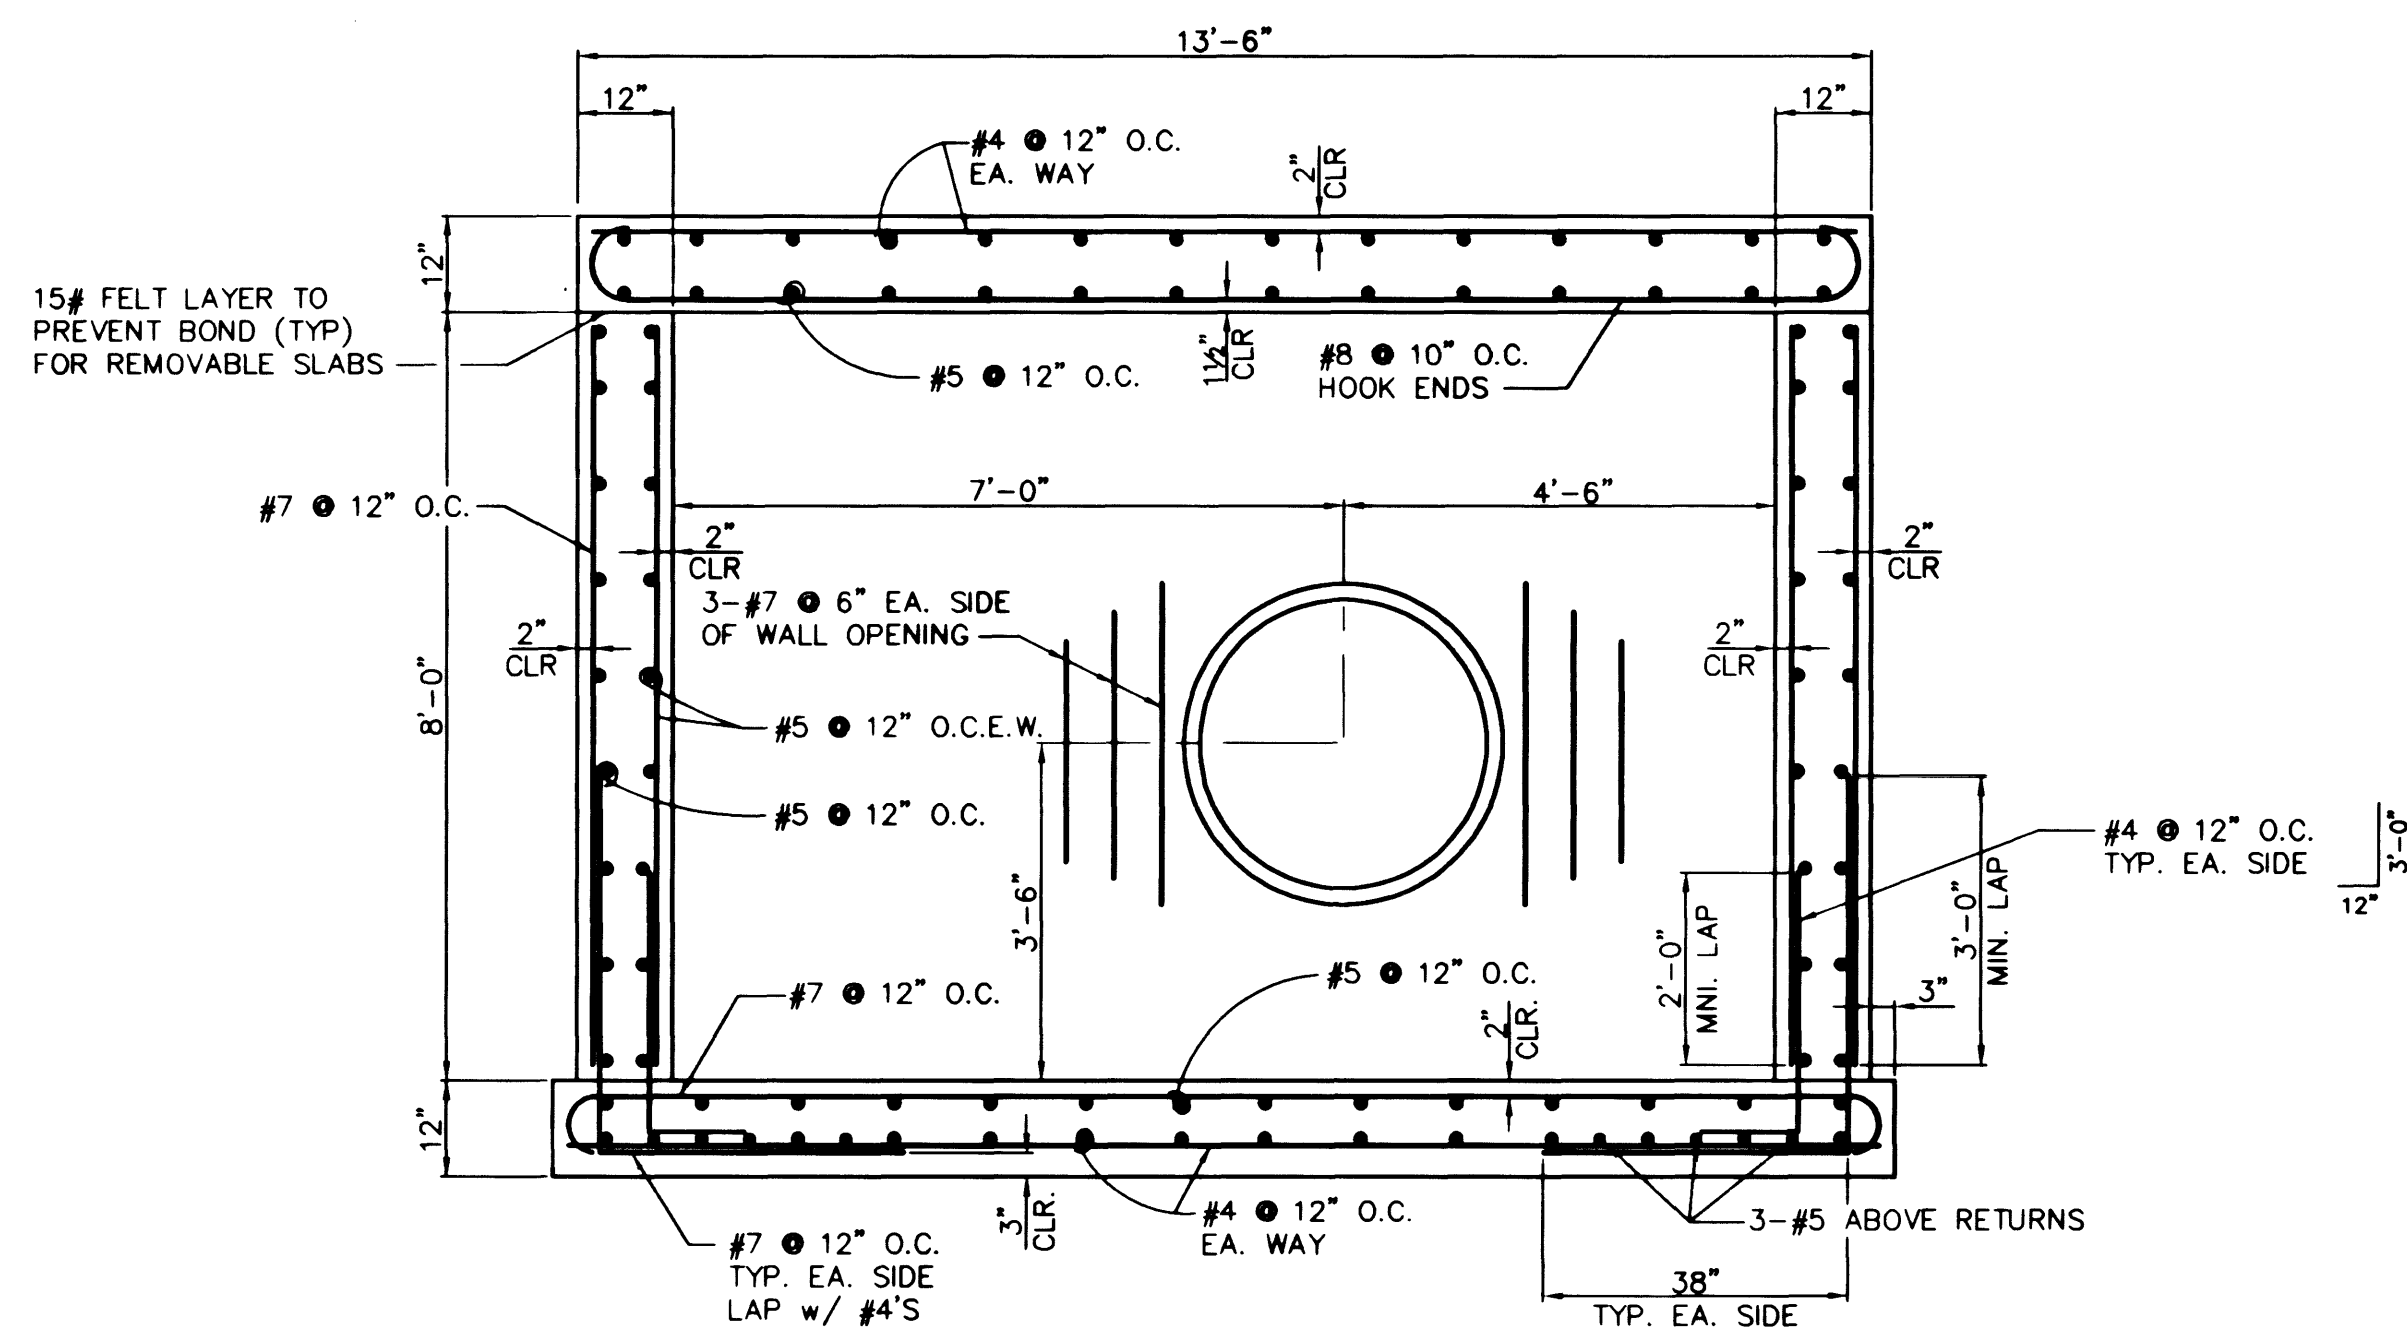


A TYPICAL SECTION
SCALE: 1/4"=1'-0"

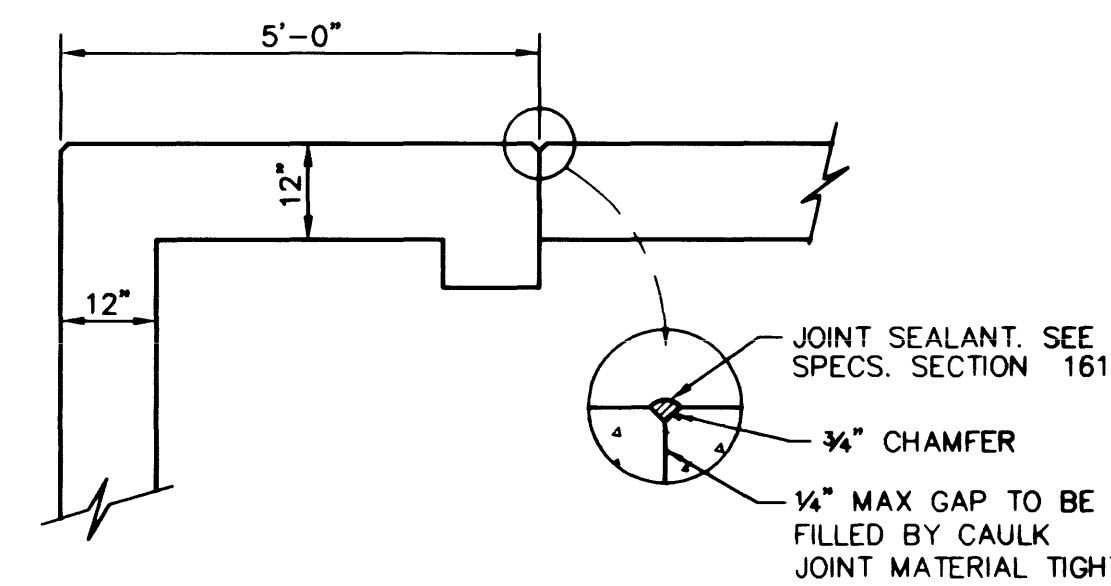

B SECTION
N.T.S.

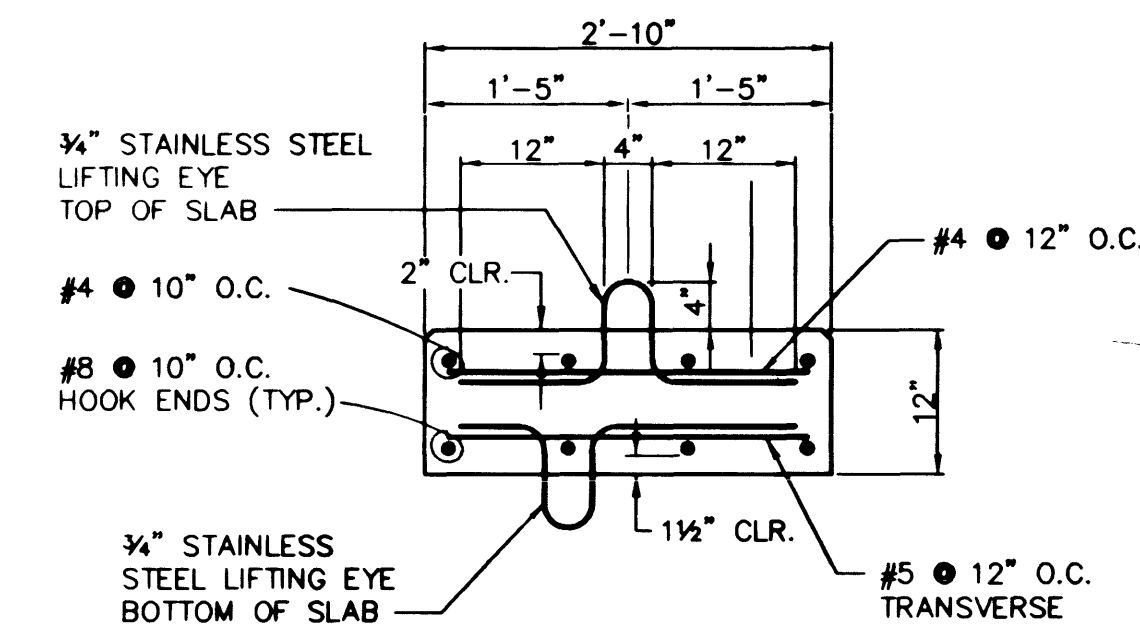

D SECTION
N.T.S.

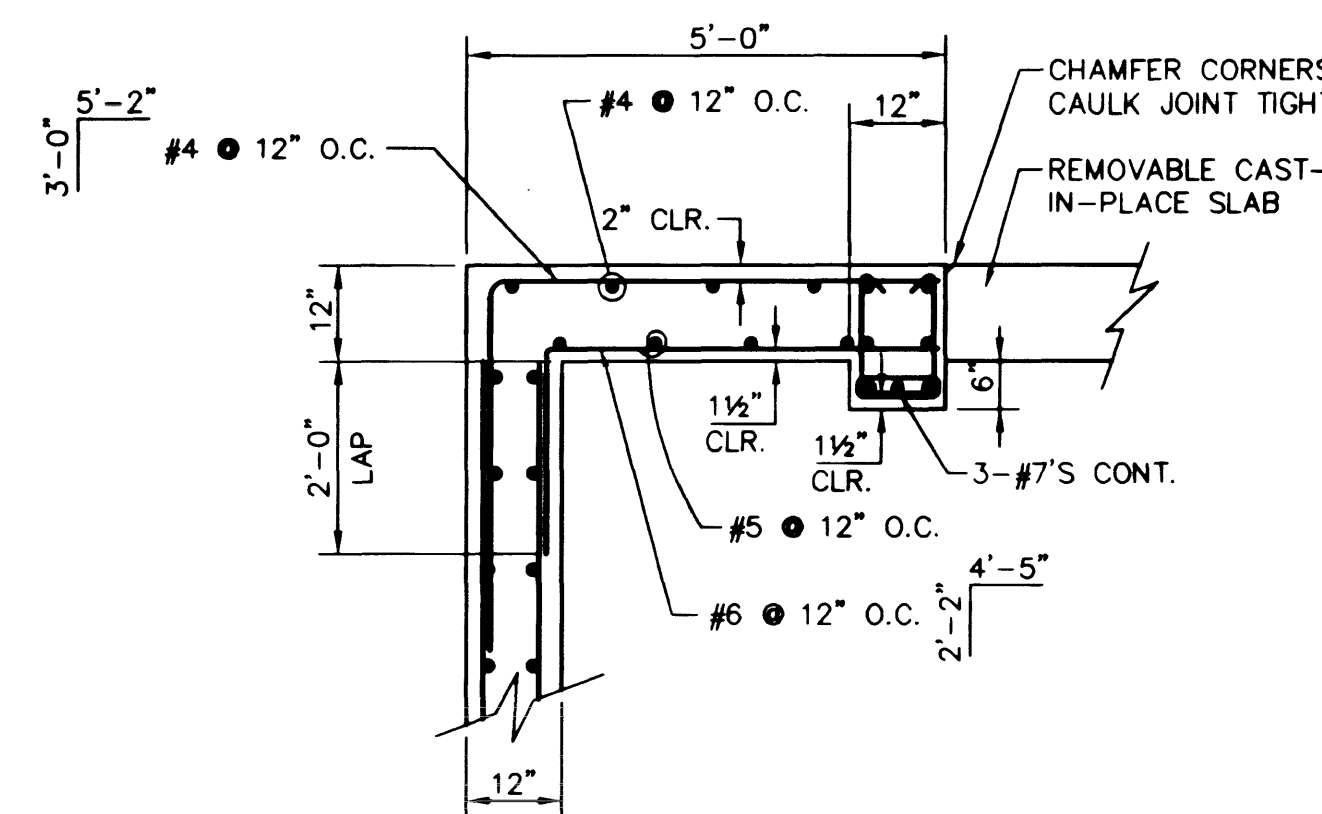


C SECTION
N.T.S.

LAS VEGAS VALLEY WATER DISTRICT
CITY OF LAS VEGAS, NEVADA

vtm nevada

CONSULTING ENGINEERS • PLANNERS • LAND SURVEYORS
2727 SOUTH RAINBOW BOULEVARD
LAS VEGAS, NEVADA 89122-5148 PHONE (702) 873-7550 FAX (702) 362-2597

VALVE VAULT NO. 1 DETAILS
CIMARRON RD 2538 ZONE PIPELINE
PHASE I

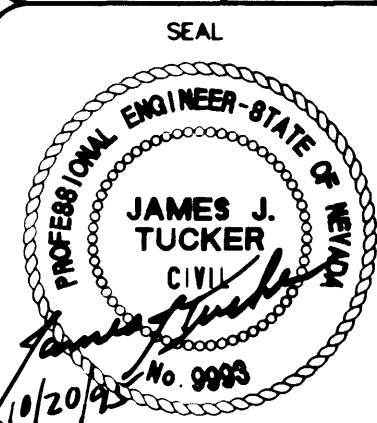

WO NO. 4891
BY SNA
DATE 7/25/95
SCALE HORIZ. AS NOTED
VERT. 1/2"=1'-0"

SHEET 19 OF 20 SHEETS

CONTRACT NO. 719

RS 9545

565-270