



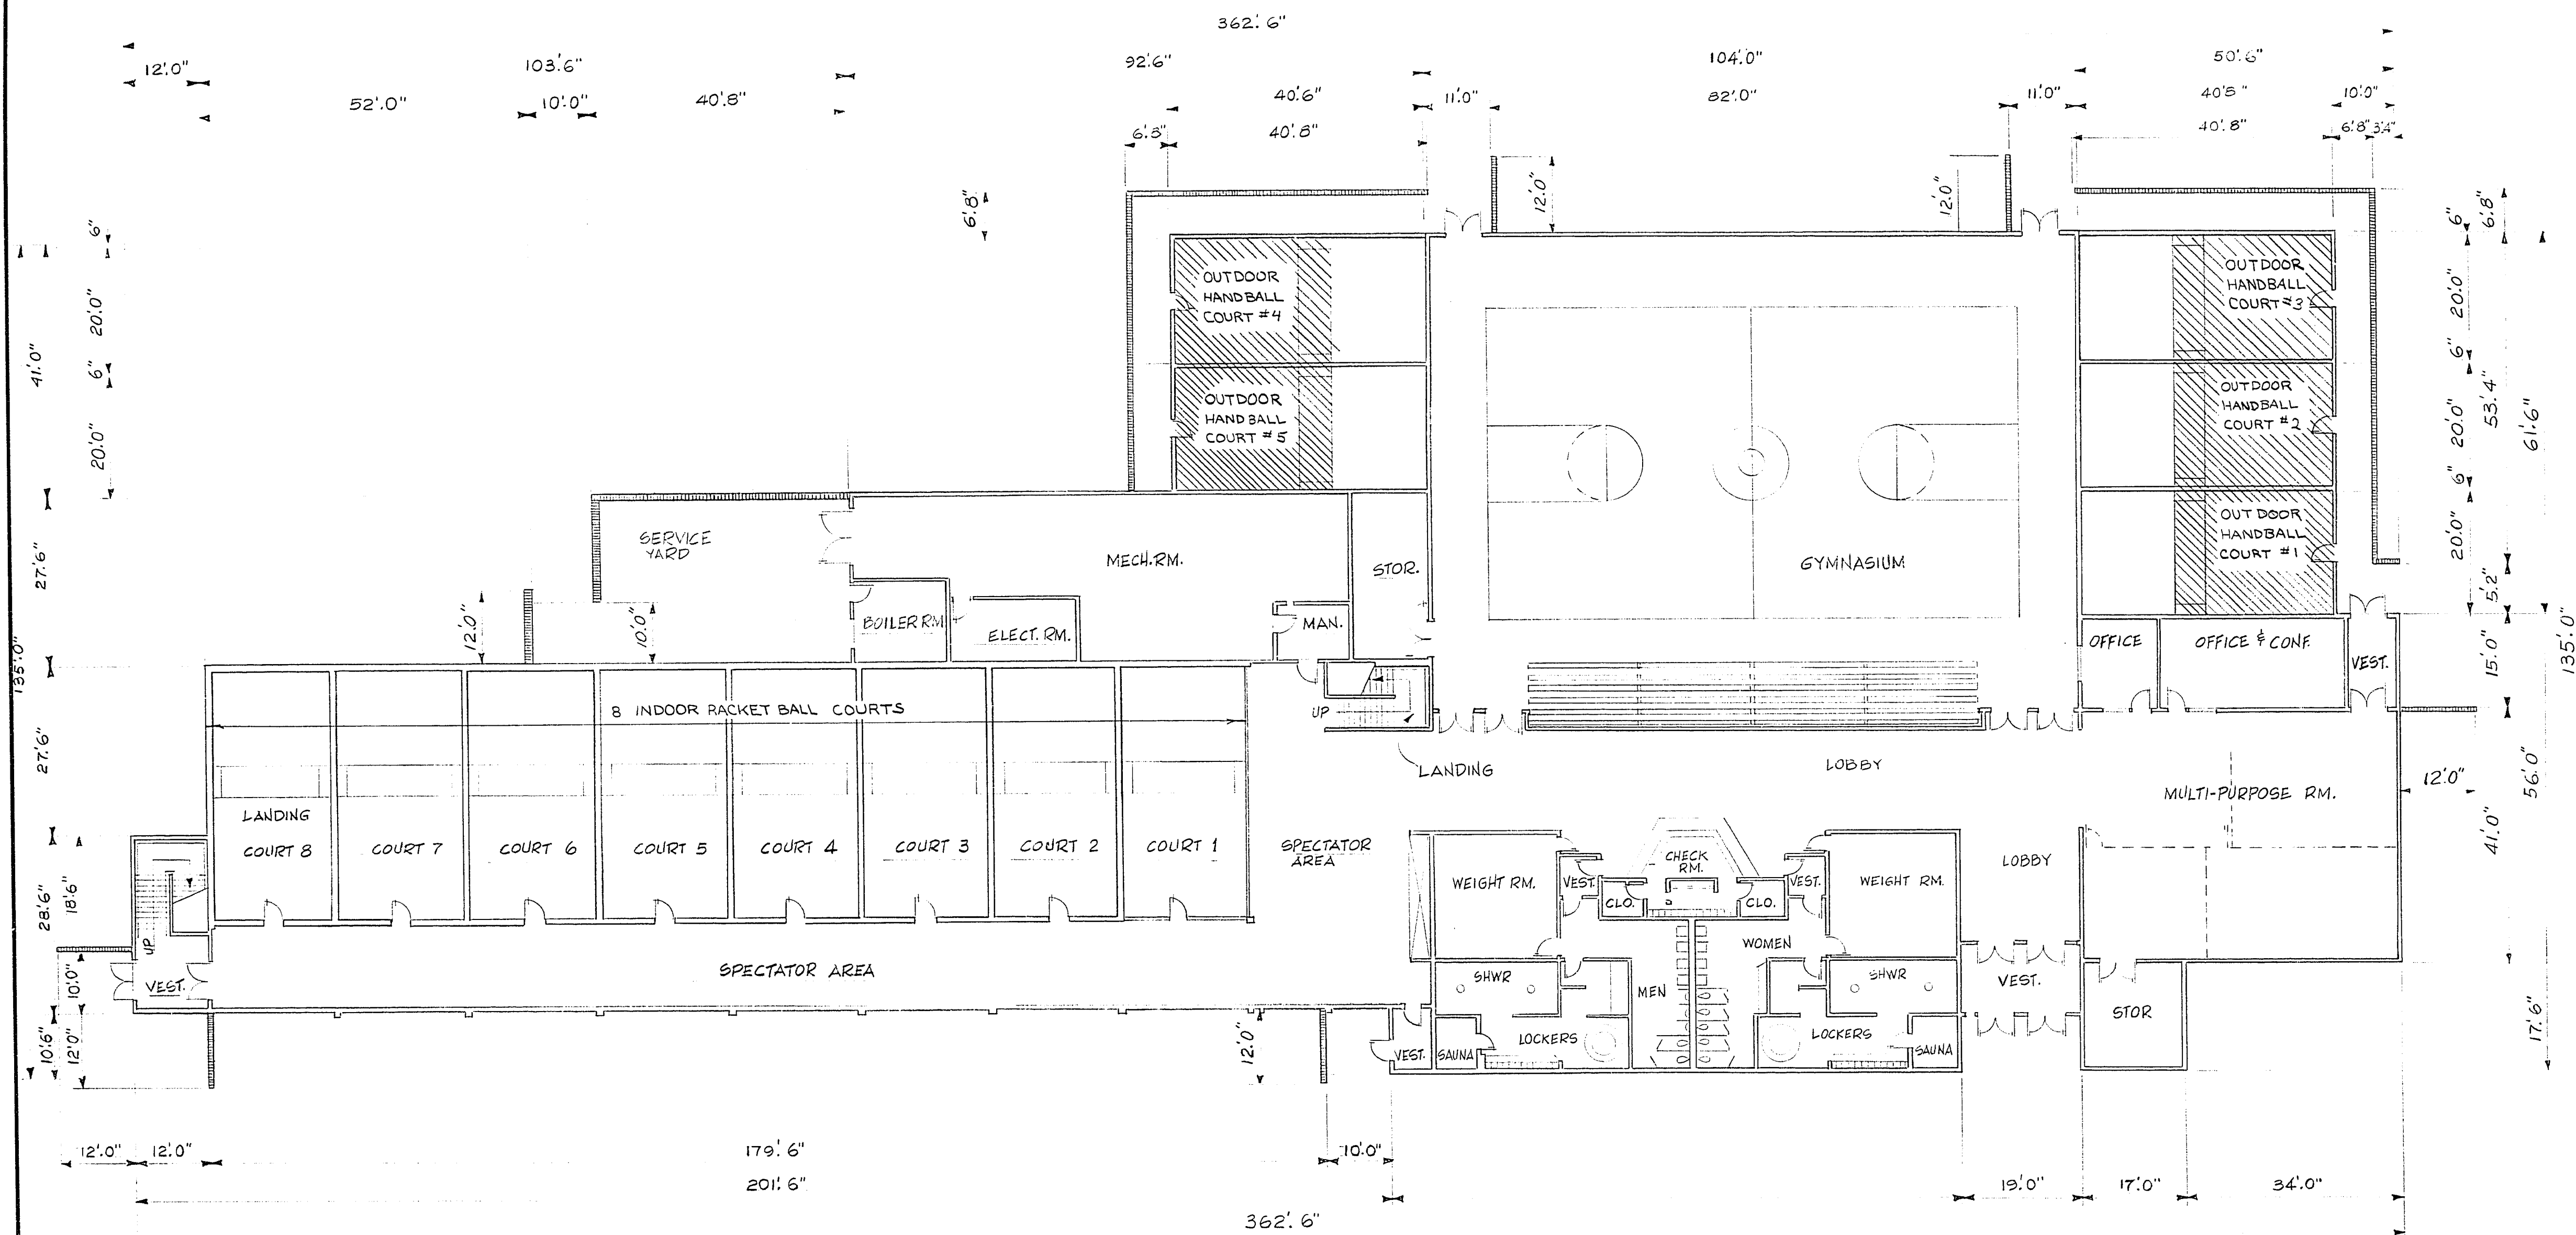

PLAN VIEW

— AREA OF CONSTRUCTION

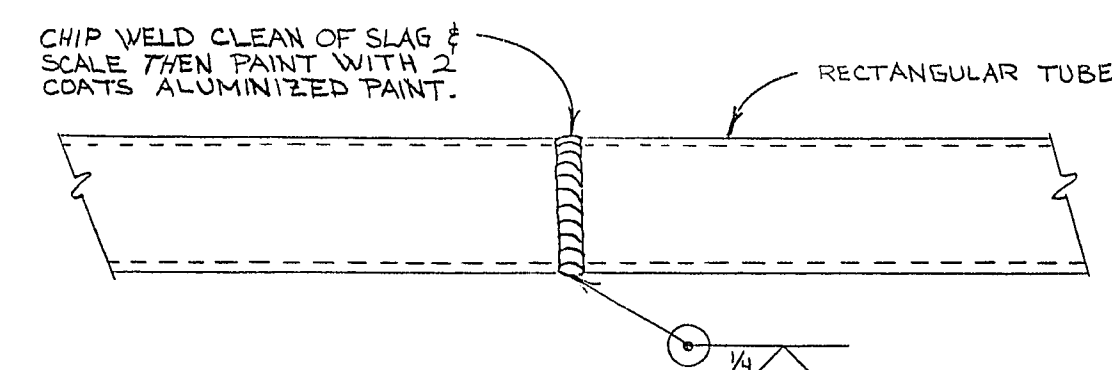

TYPICAL SUPPORT TUBE SPLICE

NOTE: DO NOT SPLICE TUBING MORE THAN 7' FROM SUPPORT


CONTRACT
DRAWING
JAN 2 1981

agency	approved
Deputy City Manager	<i>[Signature]</i> 12-17-80
Director of Public Services	<i>[Signature]</i> 12-15-80
City Engineer	<i>[Signature]</i> 12-15-80
Field Operations Engineer	N/A
Supervisor of Engineering Design	<i>[Signature]</i> 11/25/80
Supervisor of Traffic	N/A
Supervisor of Quality Control	<i>[Signature]</i> 12-2-80
Supervisor of Electrical Services	<i>[Signature]</i> 12-5-80
Supervisor of Sanitation	N/A
Supervisor of Building & Safety	<i>[Signature]</i> 12-2-80
Director of Comm. Plan. & Dev.	<i>[Signature]</i> 12-2-80
Director of Rec. & Leisure Activities	<i>[Signature]</i> 12-2-80
Director of Fire Services	N/A
Director of Arch. Serv. & Proj. Control	<i>[Signature]</i> 12-2-80

Department of Public Services Engineering Design Division

OUTDOOR HANDBALL COURT'S
ENCLOSURE FRAME
SITE PLAN

STEWART/MOJAVE
RECREATION CENTER

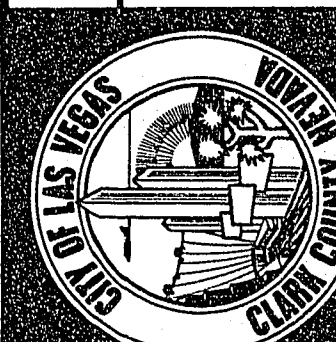

Drawing no.
671-43C

1/3

Scale (h)	Scale (v)	W.A. no.	Date	Revisions	Date
1/16"=1'-0"	1/16"=1'-0"	0010	JUNE 1980		
Fid. bk. no.	Drawn by				
	C. KATKOWSKI, P.E.				
	N. R. HAMP				