



LOCATION MAP

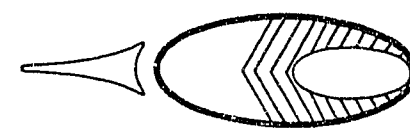

BID NO.- 73.148

CONTRACT NO.-CLV-10148

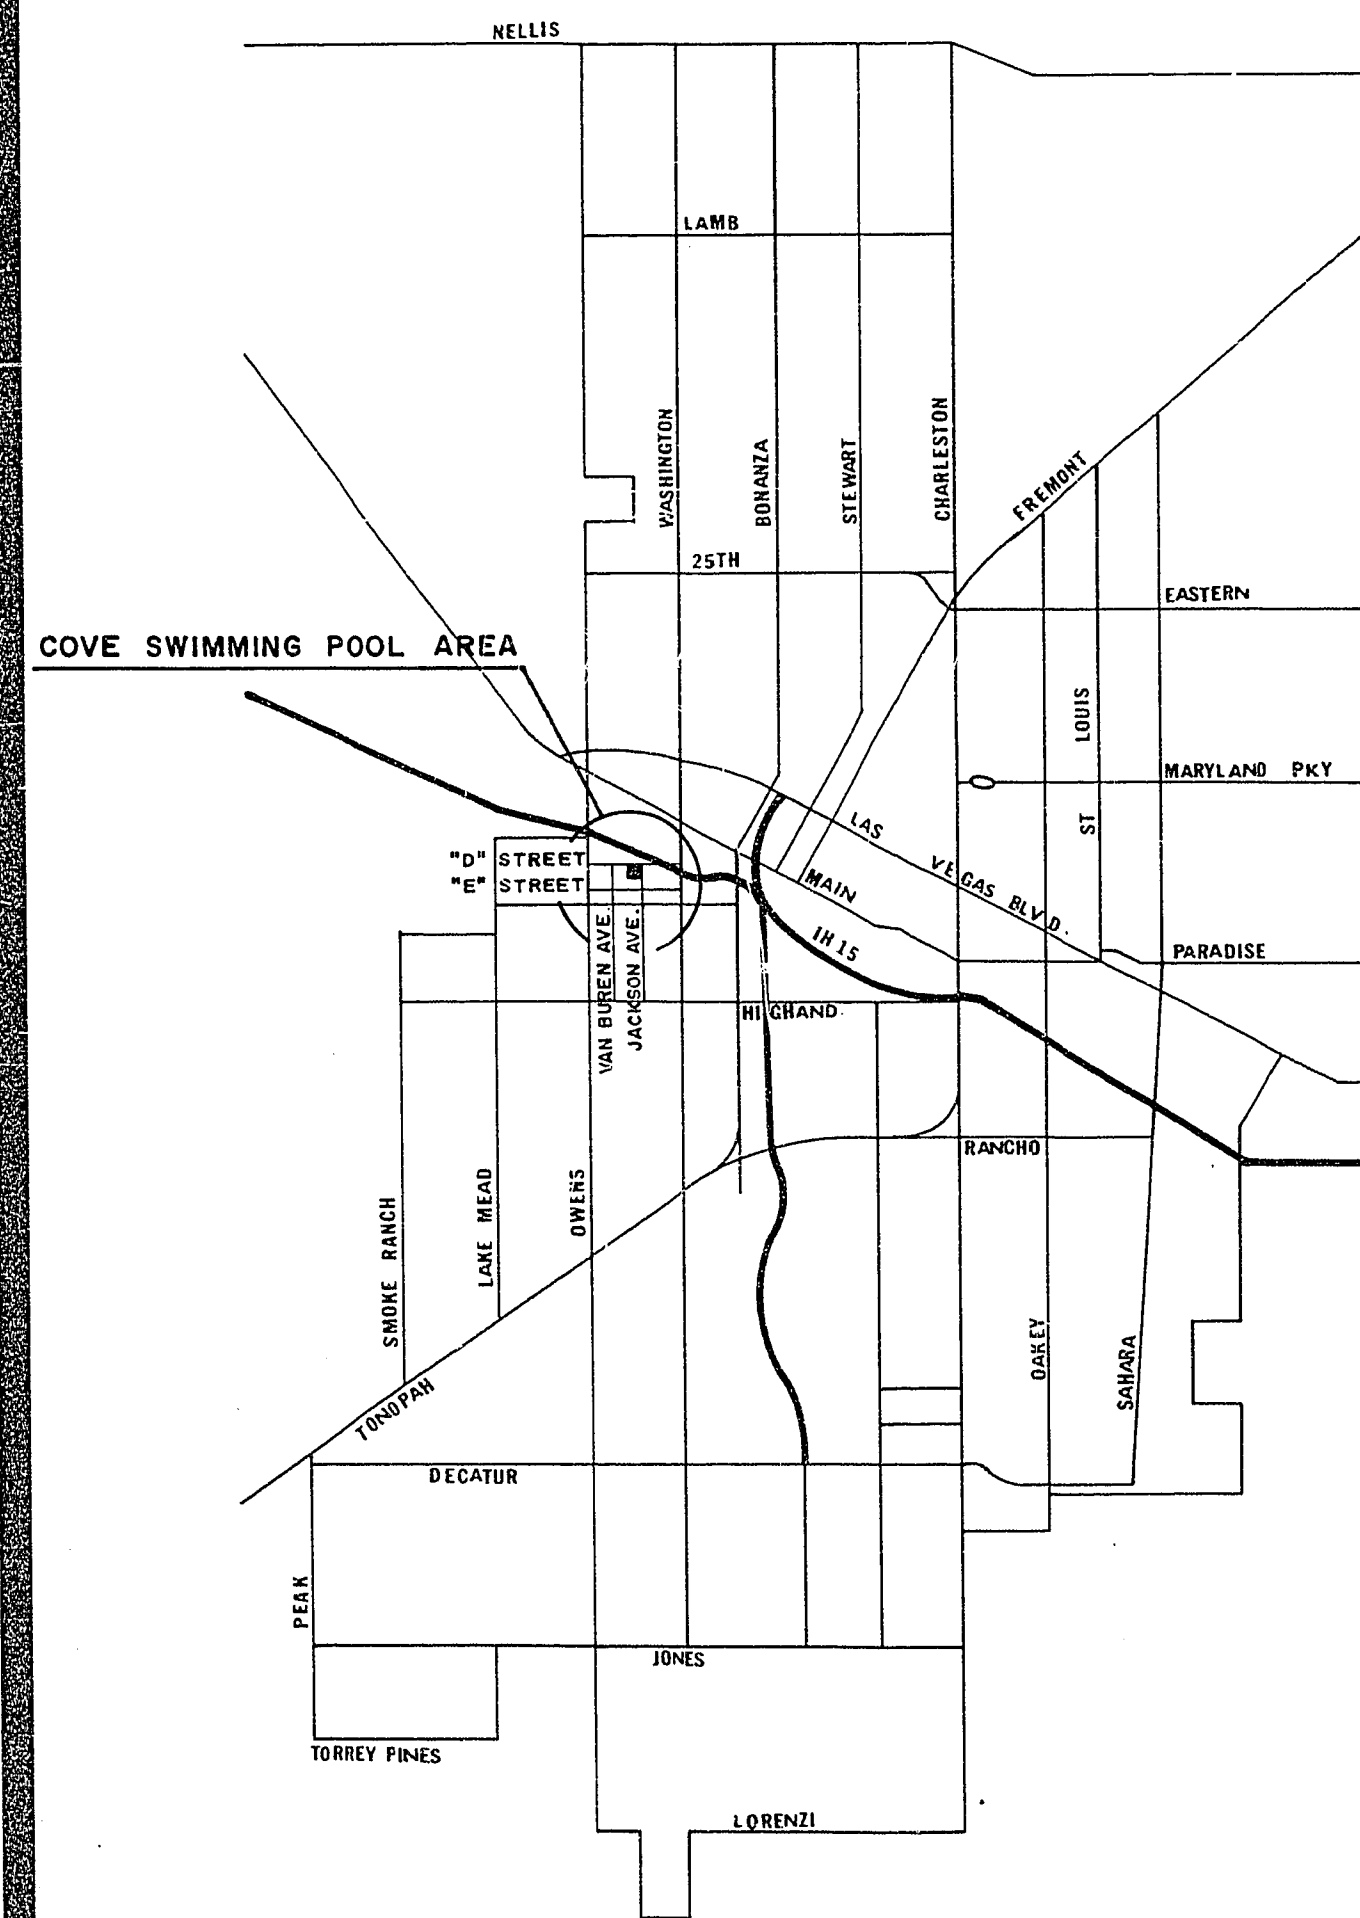

**MAYOR**  
ORAN K. GRAGSON

**COMMISSIONERS**  
GEORGE E. FRANKLIN JR.  
HAROLD F. MORELLI  
RON LURIE  
PAUL J. CHRISTENSEN

**CITY MANAGER**  
A. R. TRELEASE

**DIRECTOR OF PUBLIC WORKS**  
RICHARD P. SAUER

EXISTING UTILITIES ARE LOCATED ON THE PLANS FOR THE CONVENIENCE OF THE CONTRACTOR ONLY. THE CONTRACTOR SHALL BEAT FULL RESPONSIBILITY FOR PROTECTION OF UTILITIES AND THE CITY BEARS NO RESPONSIBILITY FOR UTILITIES NOT SHOWN ON THE PLANS OR REFER TO THE LOCATION SHOWN ON THE PLAN.

CONTRACT  
DRAWING  
MAY 10 1974

INDEX OF SHEETS 24-13-9

No.	DESCRIPTION
1	COVER SHEET
2	PLOT PLAN
3	FLOOR PLAN
4	FOUNDATION PLAN
5	ELEVATIONS
6	ROOF PLAN
7	ELECTRICAL PLAN
8	VENTILATION SYSTEM
9	PLUMBING PLAN
10	SWIMMING POOL AREA REPAIRS

TITLE	APPROVED	DATE
Supt. of Recreation	<i>Frank Heath</i>	11/2/73
Dir. of Bldg. & Safety	<i>John Miller</i>	11-6-73
Traffic Engr.	NA	
Const. Div. Engr.	<i>L.D. Decker</i>	11/2/73
Design Div. Engr.	<i>William Harris</i>	11/6/73
Dep. Dir. of Publ. Works	<i>W.B. Smith</i>	11/6/73
Director of Publ. Works	<i>R.P. Sauer</i>	11/5/73

AGENCY	NO SERVICE	REVIEWED BY	DATE
C.C. Health Dept.		<i>J.D. Smith</i>	11-9-73
R.S.&H.C.Mng. Engr.	NA		
N.S.H.D. Dist. Engr.	NA		
Elect. Coord.		<i>Bob Taylor</i>	11-6-73
Centel	NA		
L.V. Water Dist.	NA		
SW Gas Co.	NA		
Nev. Power Co.	NA		
Supt. of Sanitation	NA		
C.L.V. Electrician		<i>Wm. Harris</i>	11-6-73
C.L.V. Fire Chief	NA		

REVISIONS				DATE 21 Sep 73
No.	DESCRIPTION	BY	Date	APPR

DRAWING No.  
674-17

SHEET 1 OF 10