
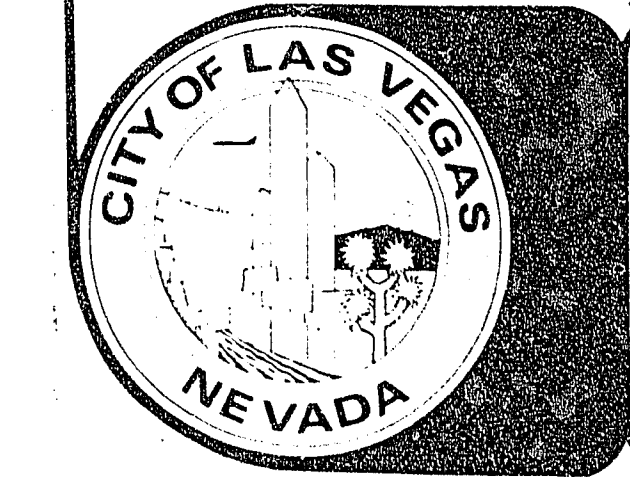


agency	approved	date
Deputy City Manager	<i>Clark B. Graham</i>	21 Dec '84
Director of Design & Development	<i>Clark B. Graham</i>	21 Dec '84
City Engineer	<i>Clark B. Graham</i>	21 Dec '84
Chief of Civil Engineering	N/A	
Chief of Traffic Engineering	N/A	
City Project Administrator	N/A	
Chief of Project Control	N/A	
Director of General Services	N/A	
Chief of Maintenance	N/A	
Director of Parks, Recreation & Senior Activities	N/A	
Director of Public Services	<i>Clark B. Graham</i>	21 Dec '84
Chief of Electrical Services	N/A	
Director of Community Planning & Development	N/A	
Director of Building & Safety	N/A	
Regional Transportation Commission	N/A	
Nevada State Department of Transportation	N/A	
Central Telephone Company	<i>Negla Lovell</i>	12-10-84
Las Vegas Valley Water District	<i>Thomas B. Graham</i>	12-10-84
Nevada Power Company	<i>B. Kistner</i>	12/7/84
Southwest Gas	<i>Benny W. Rob</i>	12/10/84
Cable Television	N/A	
CLARK COUNTY DIRECTOR OF PUBLIC WORKS	<i>Clark B. Graham</i>	1/29/85

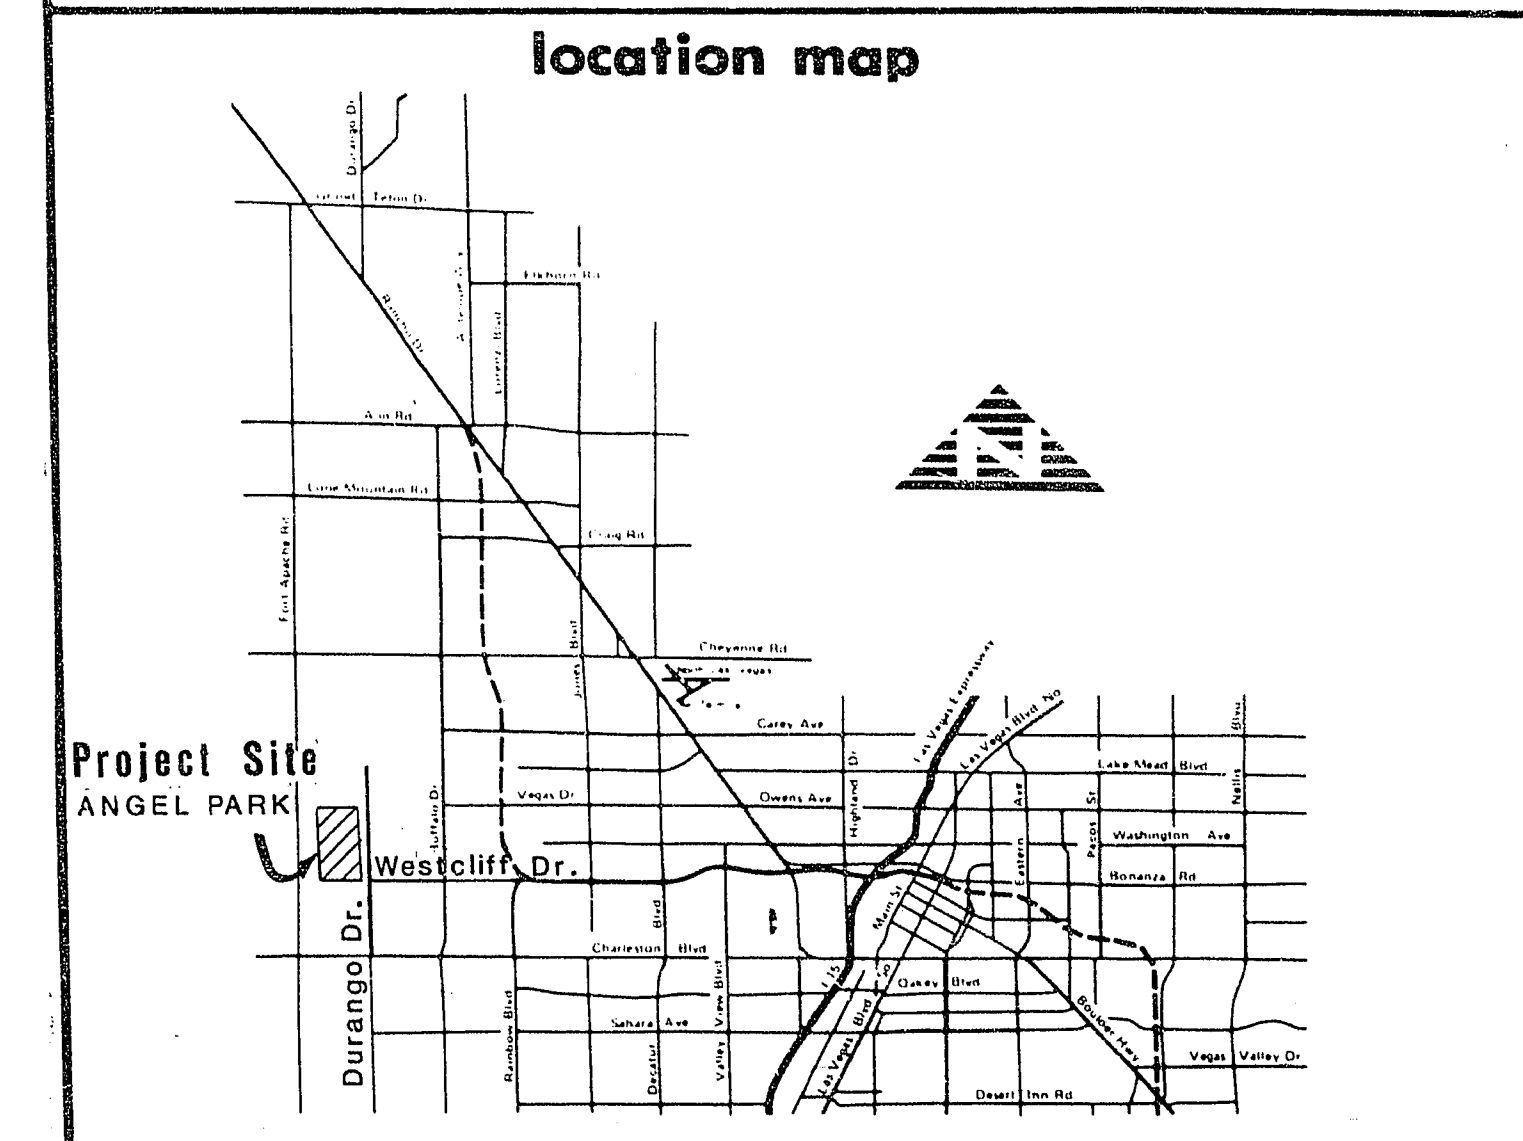

City of Las Vegas

FUNDED BY
1981 CLARK COUNTY BOND ISSUE

mayor:
Bill Briare

councilmen:
Ron Lurie
W. Wayne Bunker
Al Levy
Bob Nolen

city manager:
Ashley Hall

director of design & development:
Thomas B. Graham

index of sheets	
no.	description
1.	Cover, Location Map, Index of Sheets
2.	Abbreviations, Legend, General Notes
3.	Horizontal Control Plan, Watershed Boundary
4.	Grading Plan Sheet Index
5.	Grading Plan 1
6.	Grading Plan 2
7.	Grading Plan 3
8.	Grading Plan 4
9.	Grading Plan 5
10.	Grading Plan Sections
11.	Grading Plan Details
12.	Spillway Details
13.	Outlet Piping Plan and Profile
14.	Outlet Sluice Gate
15.	Outlet Pipe Discharge Structure
16.	Box Culvert Between Basins

revisions				
no.	description	by	date	app.

BID NO. 85.3550.1

ANGEL PARK DETENTION BASIN

PHASE IIB



date
2/6/85
drawing number
650.14-V9
sheet 1 of 16

AS BUILT