



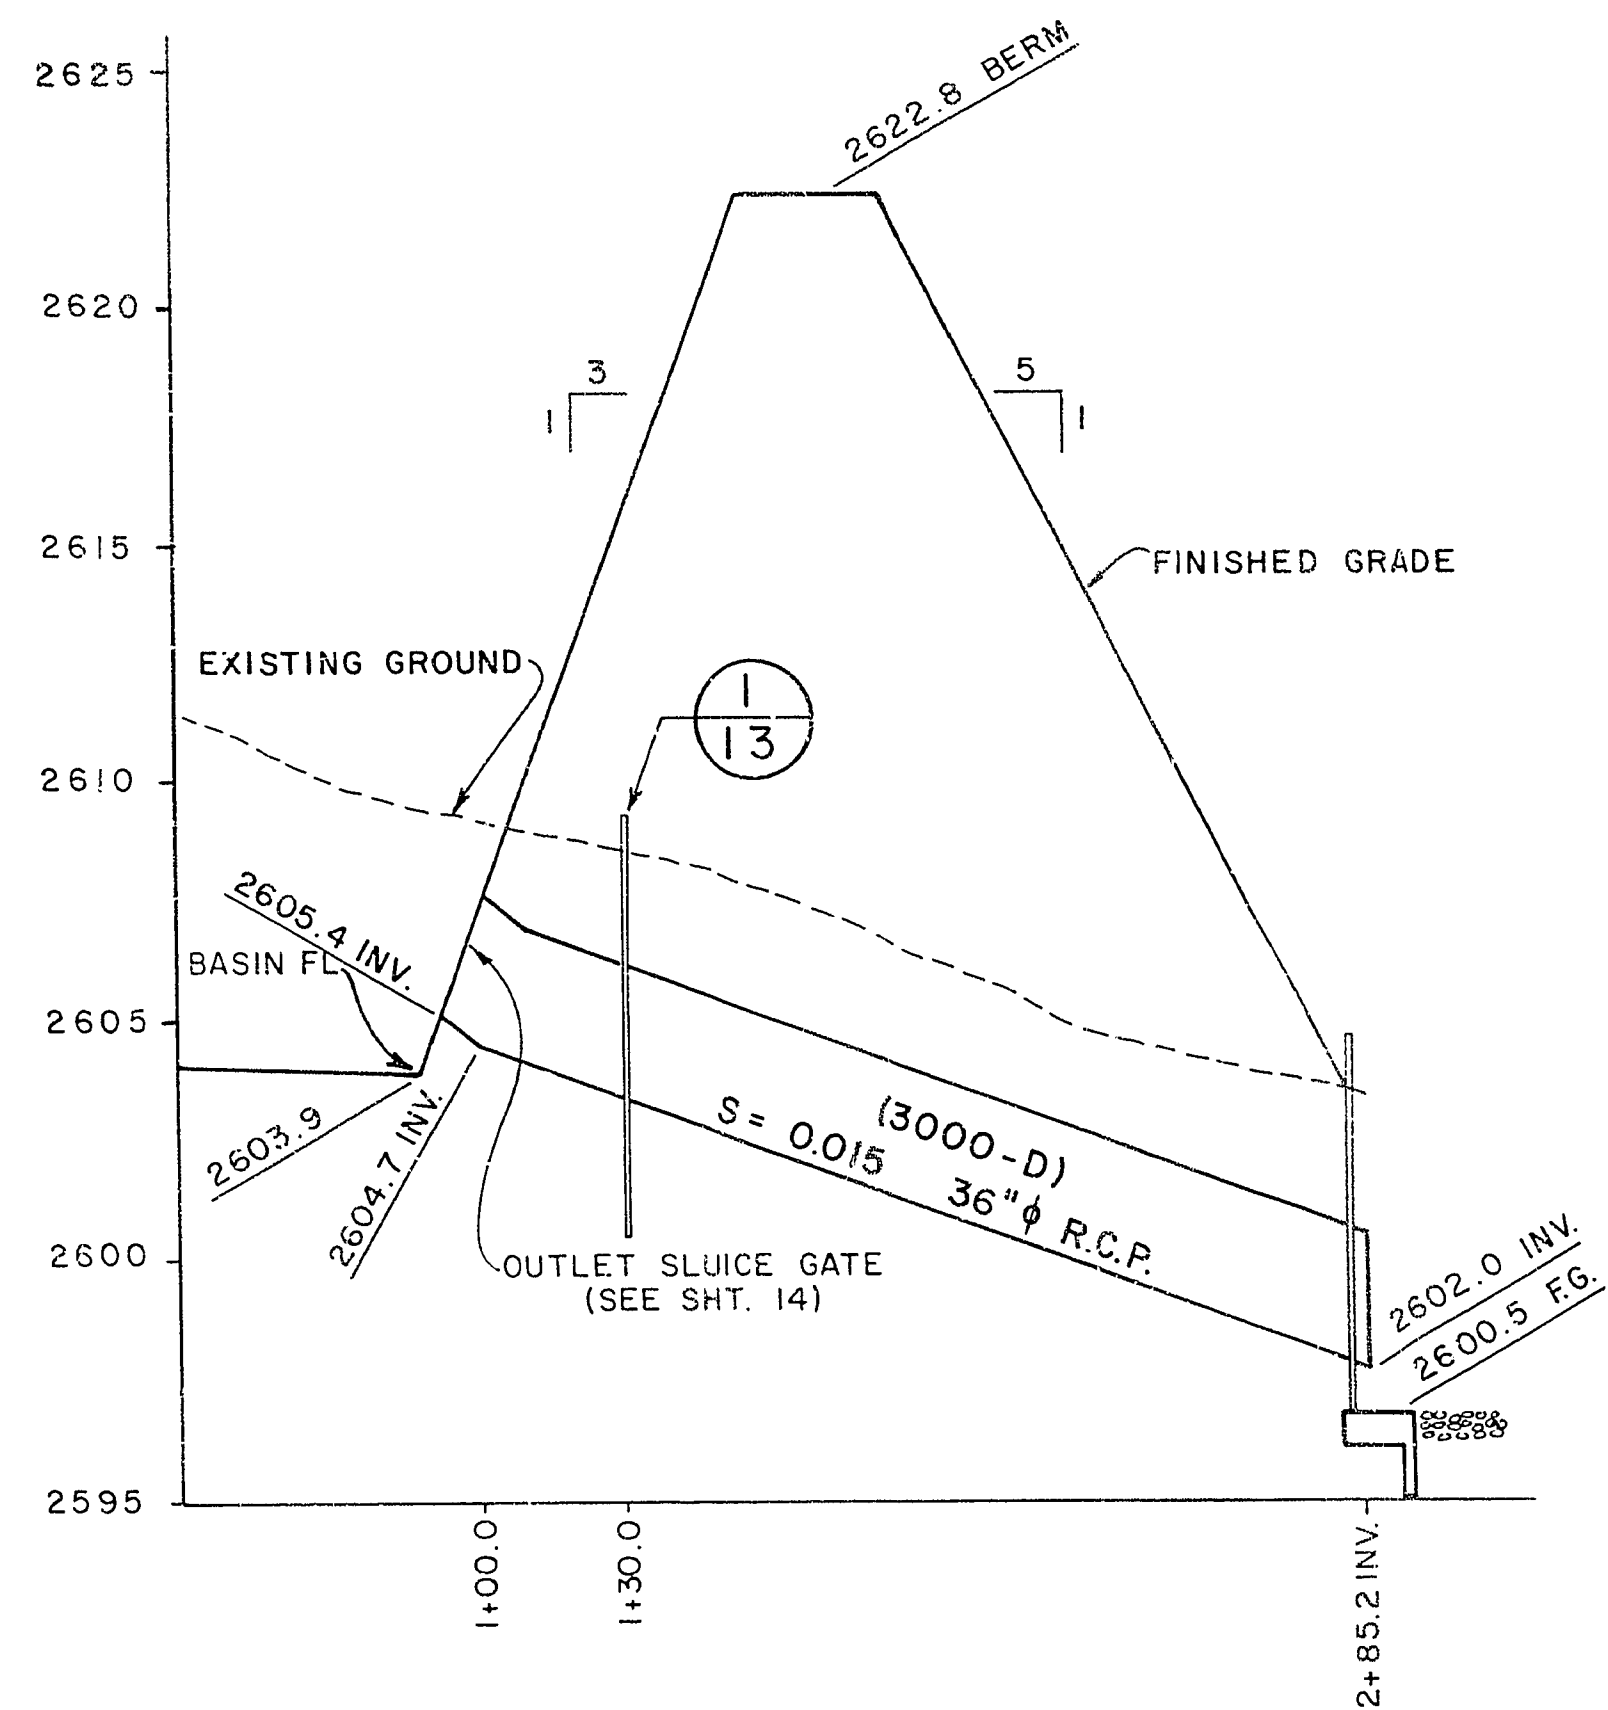


PROFILE
SCALE: 1" = 40' HORIZ.
1" = 4' VERT.

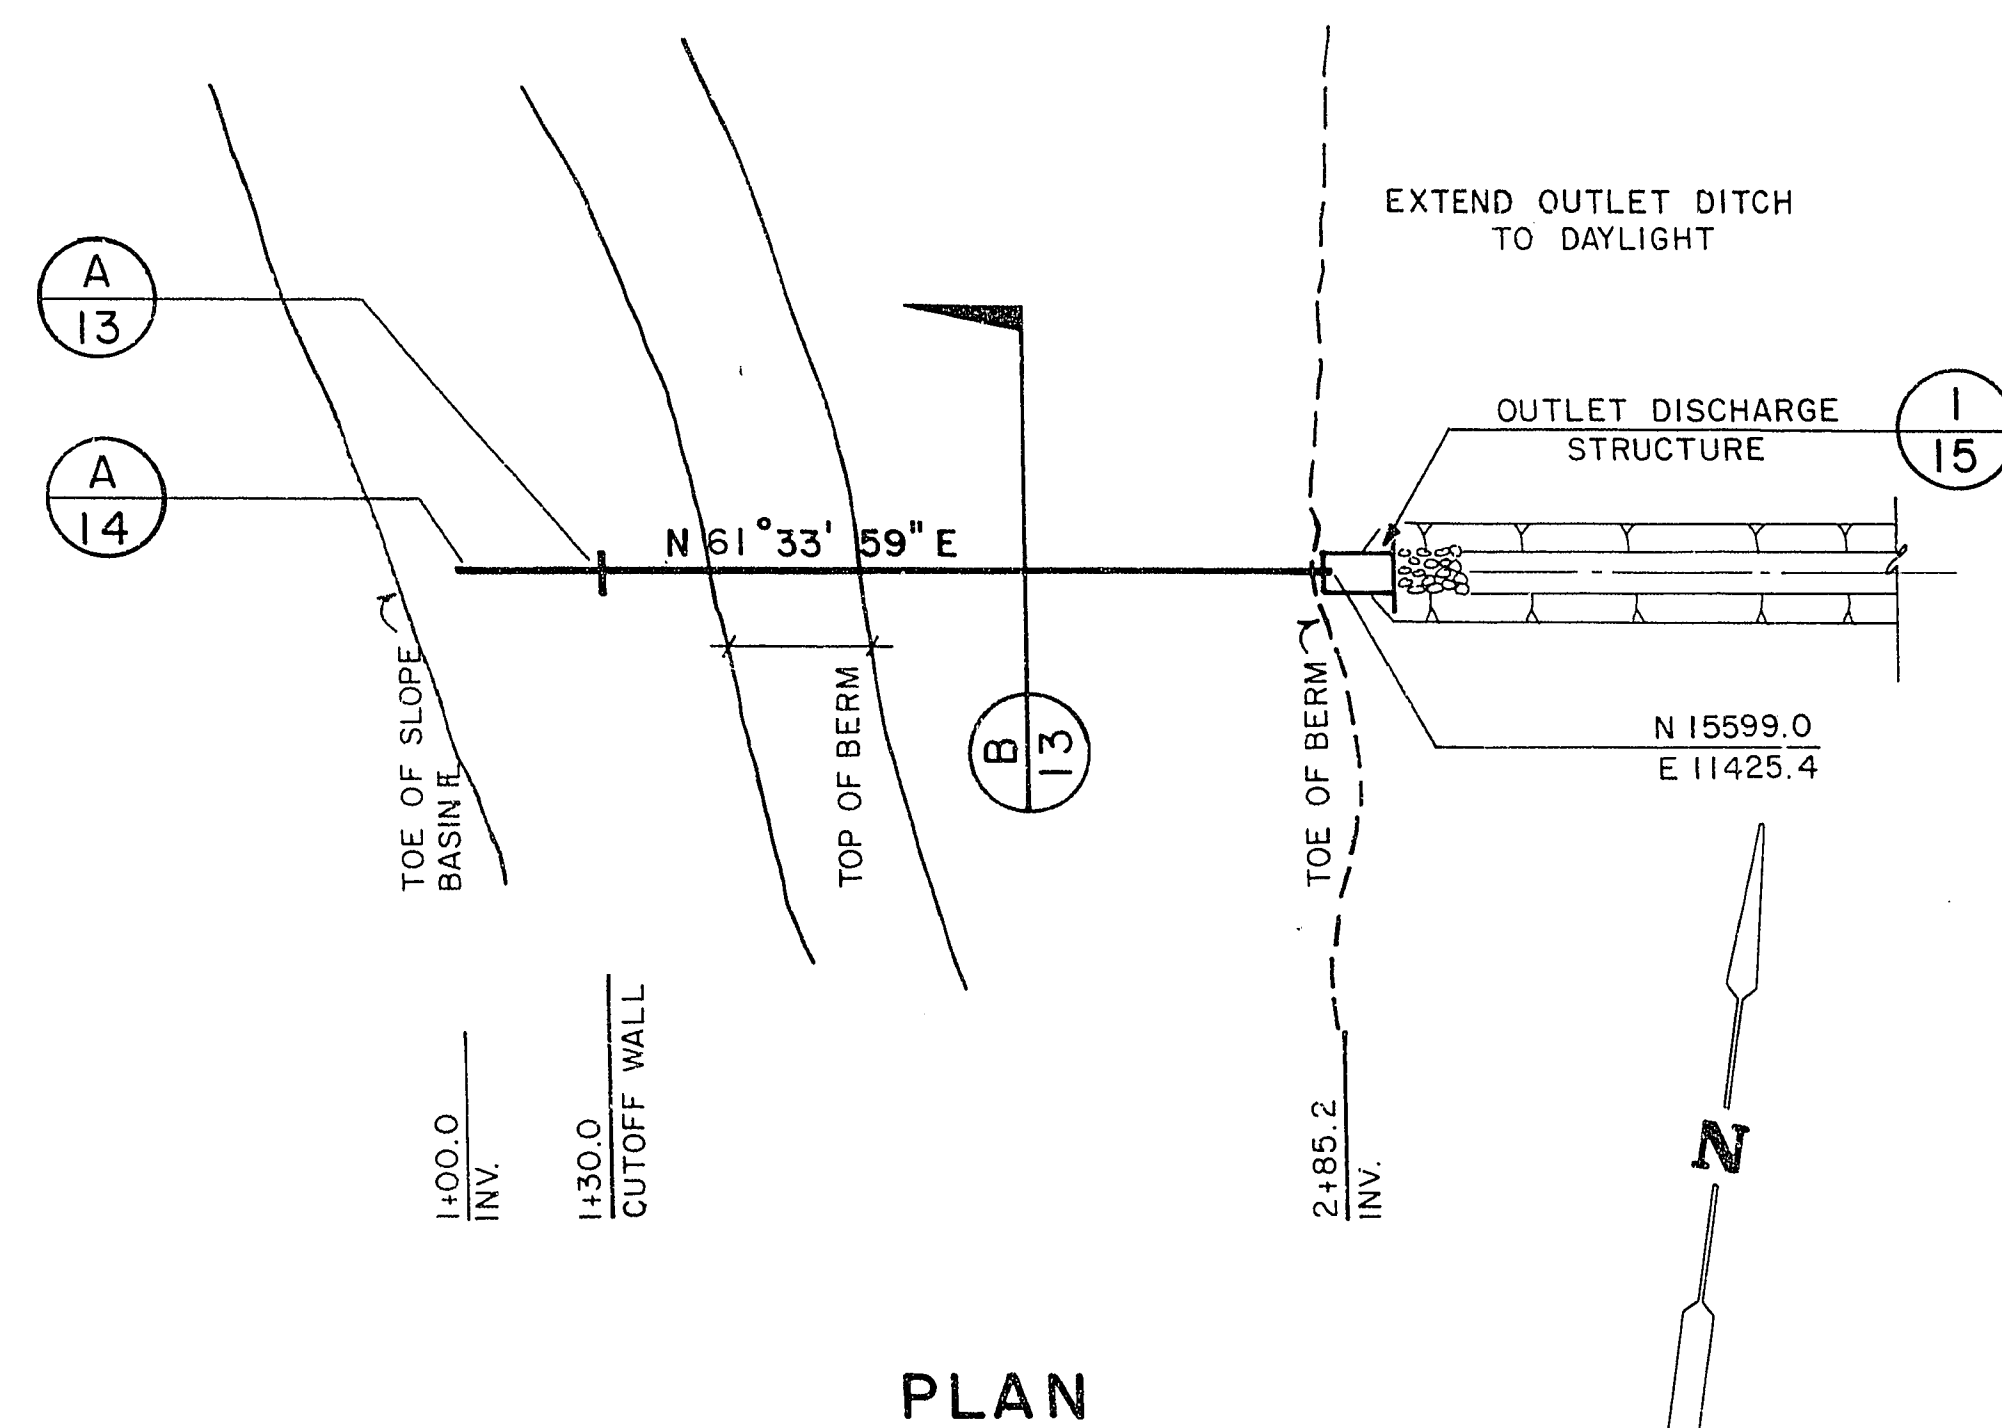

PLAN
OUTLET PIPE (SPILLWAY NO. 3)


SCALE: 1" = 40'

(SEE GRADING PLAN 4, SHT. 8 FOR LOCATION)

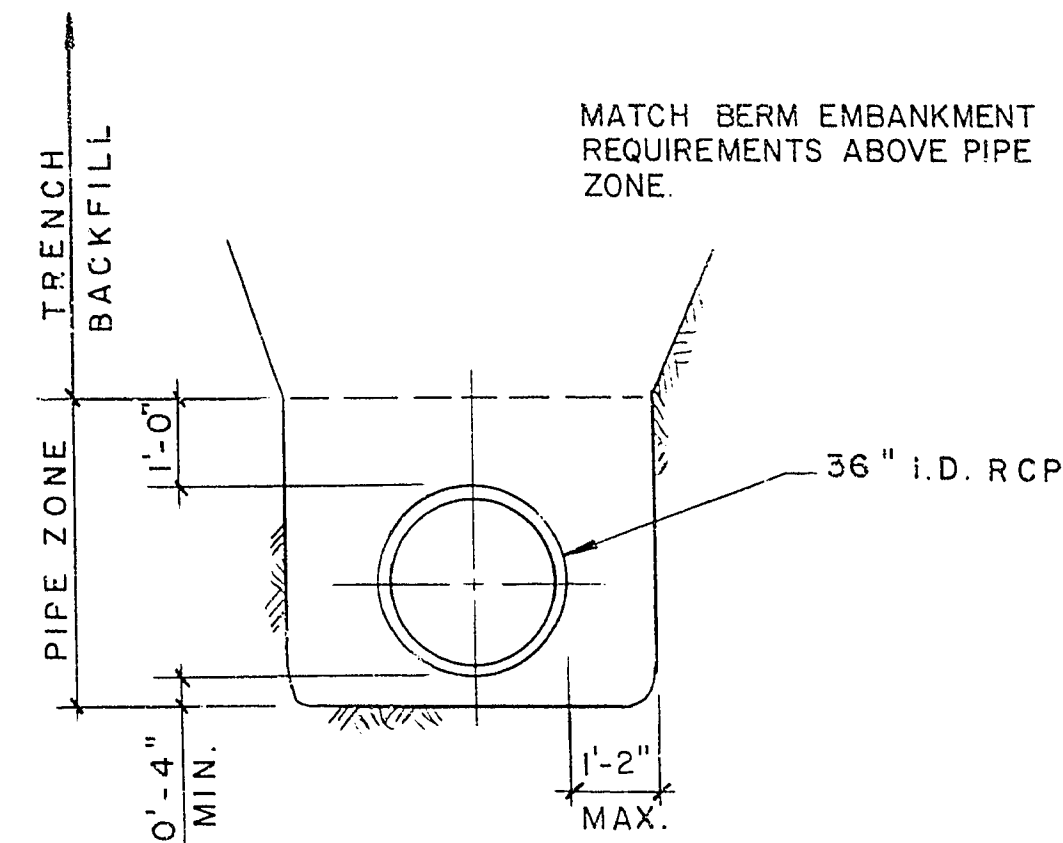


TYPICAL TRENCH SECTION
NO SCALE


(SEE SPECIFICATIONS FOR
BACKFILL & COMPACTION
REQUIREMENTS)

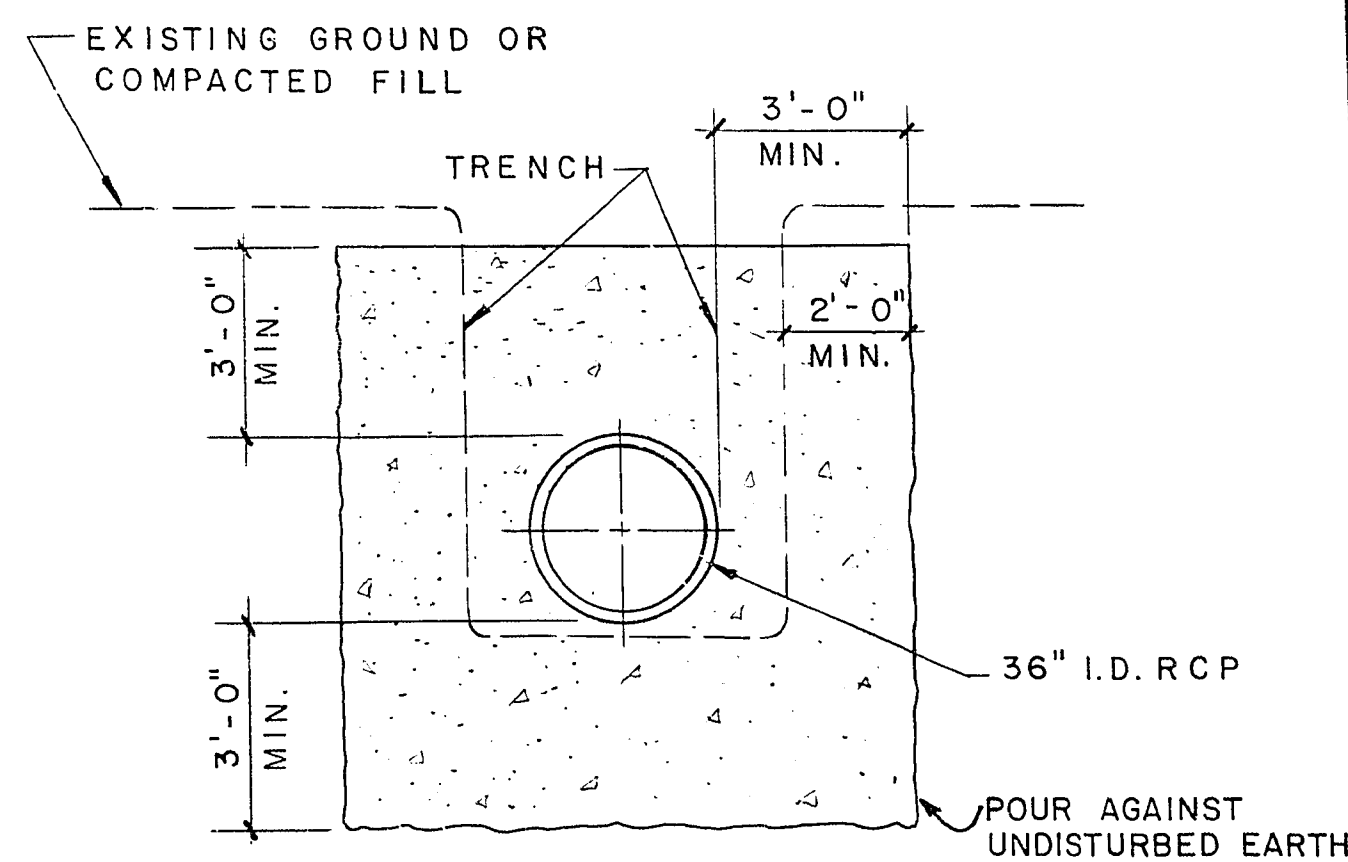


CUTOFF WALL SECTION
NO SCALE

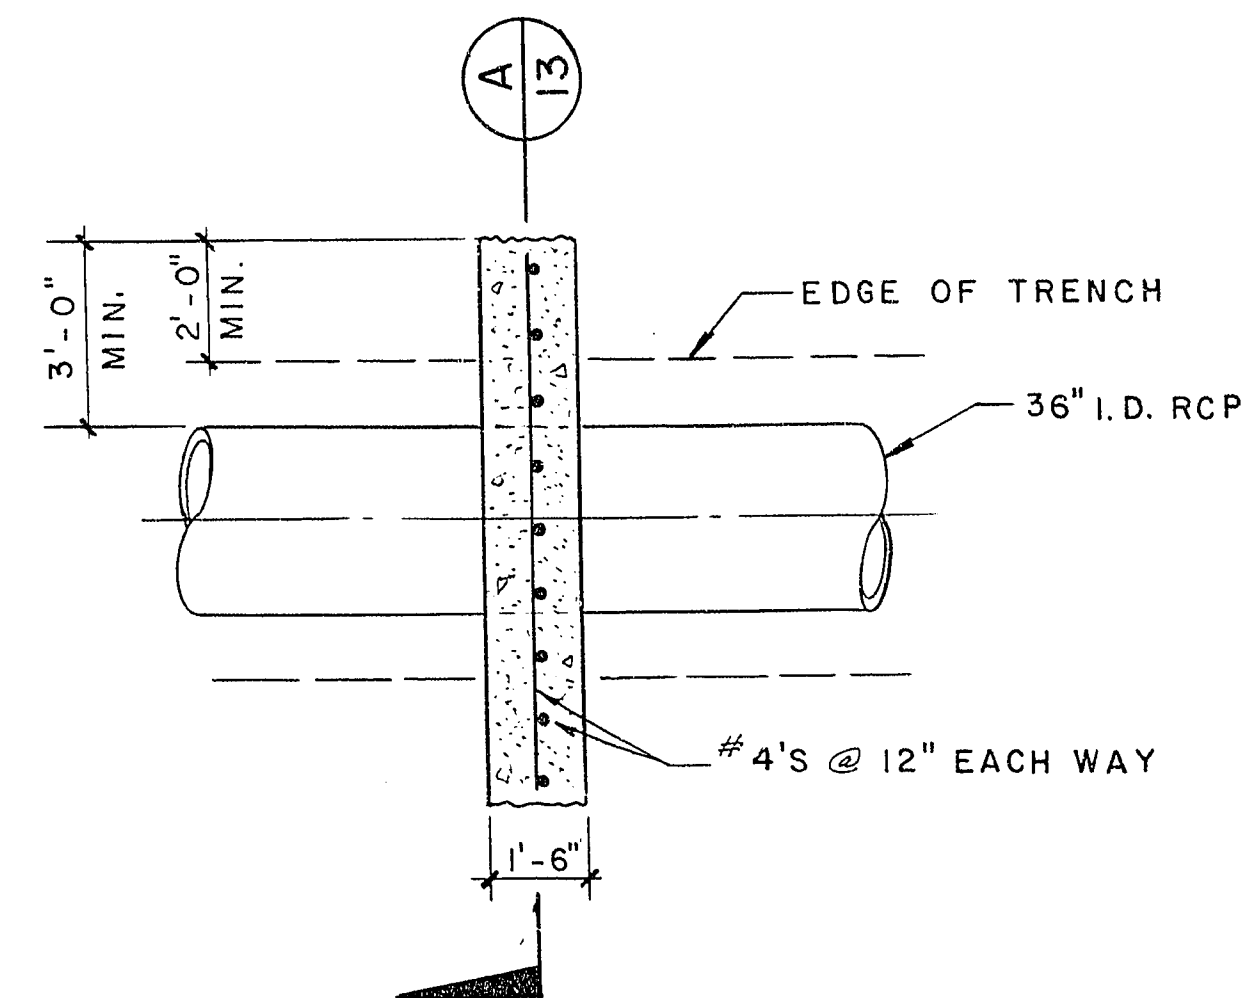

CUTOFF WALL DETAIL
NO SCALE

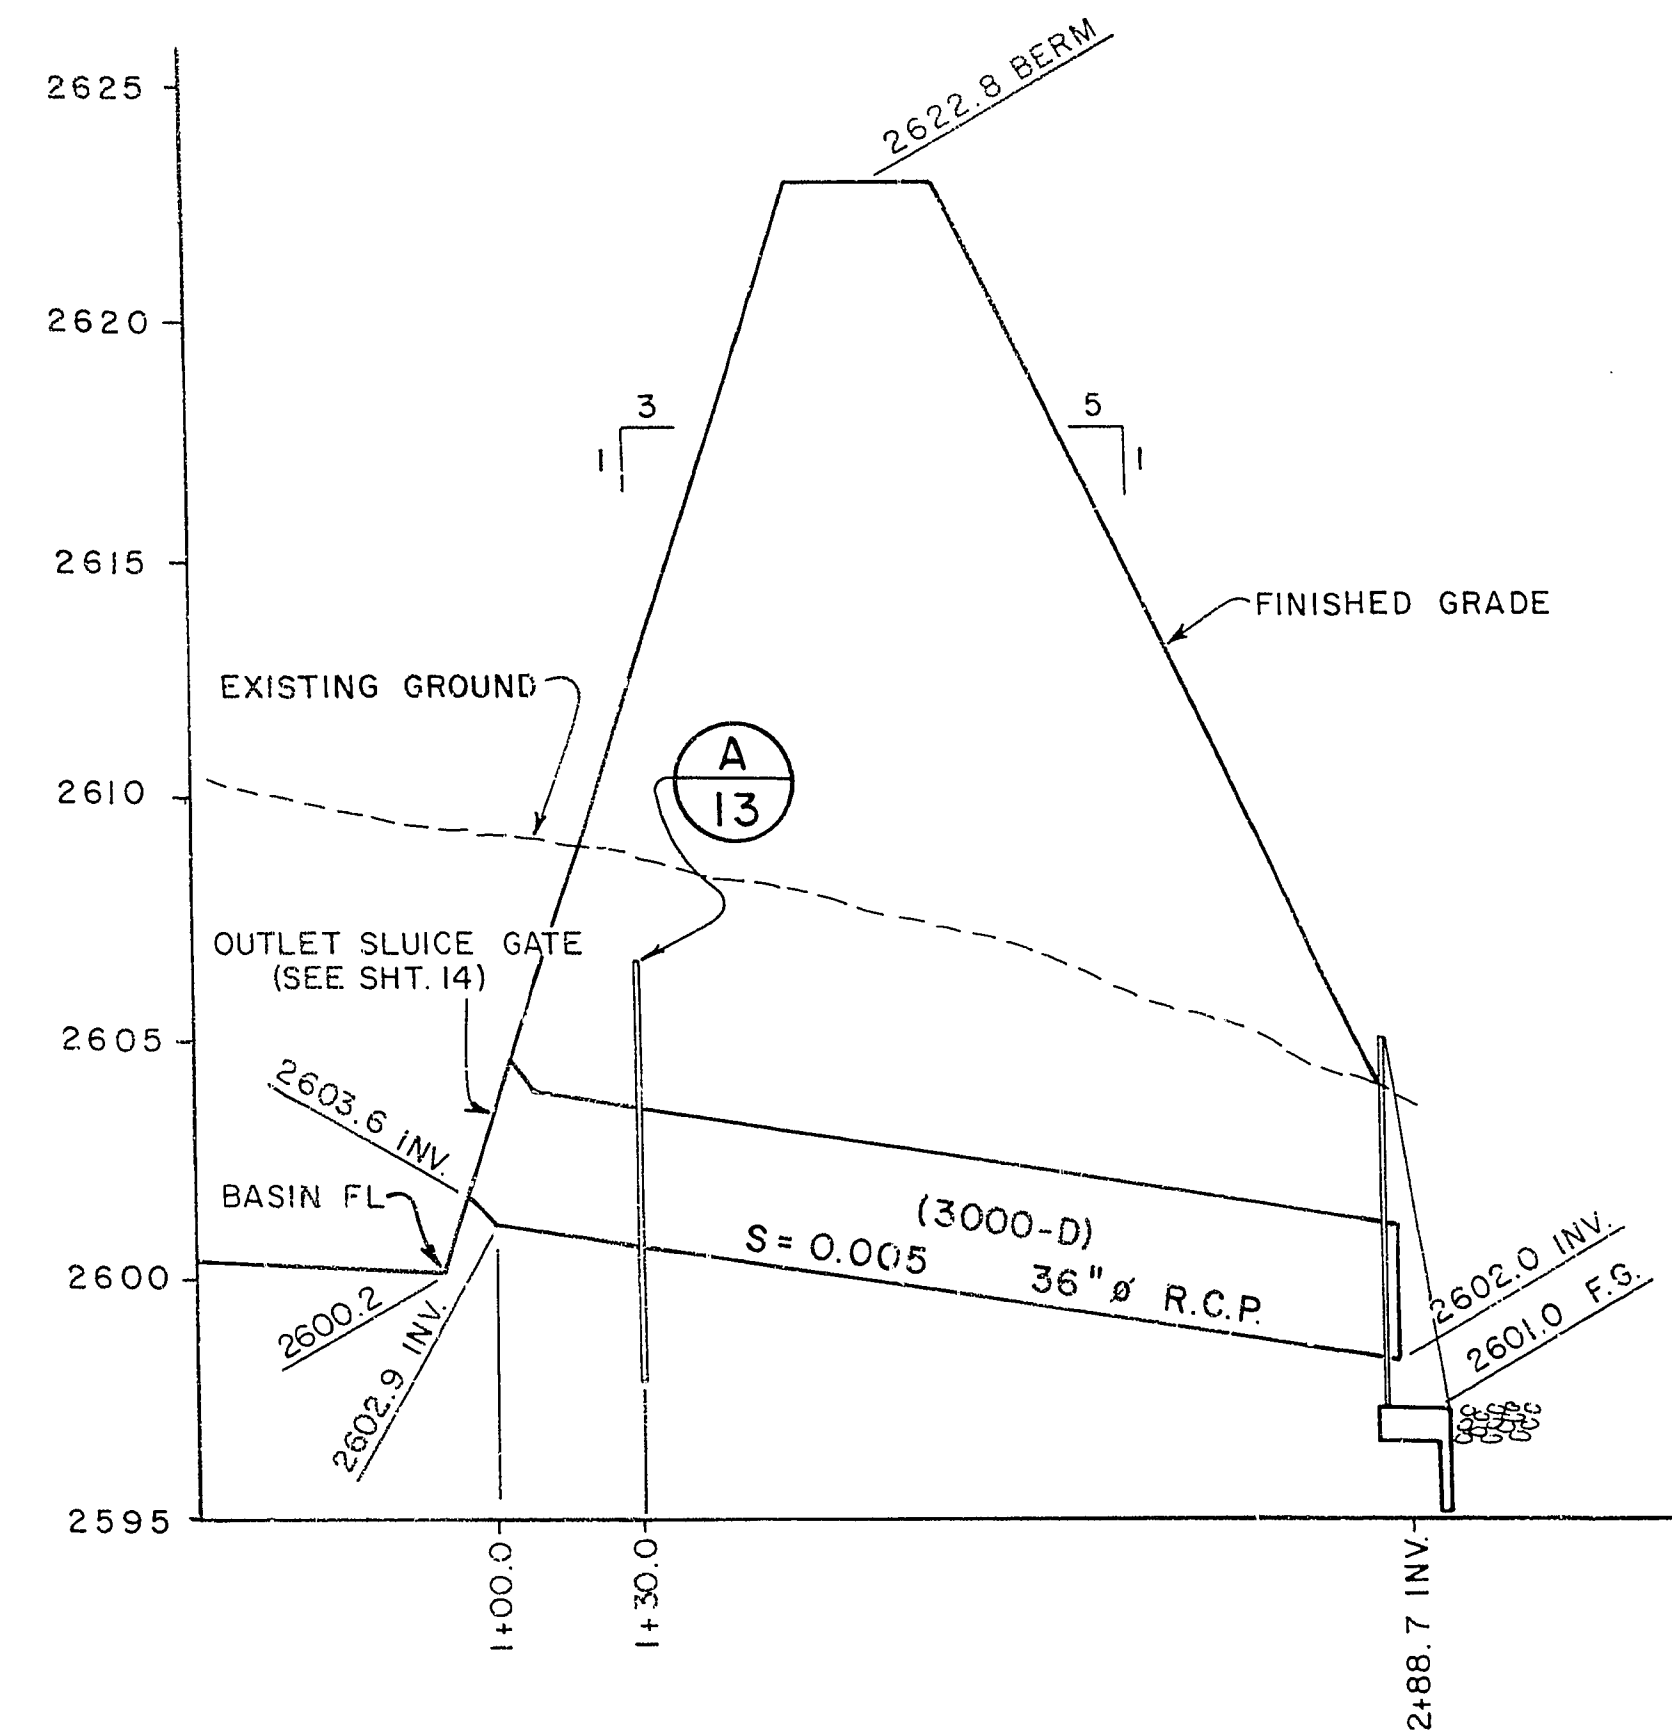

PROFILE
SCALE: 1" = 40' HORIZ.
1" = 4' VERT.

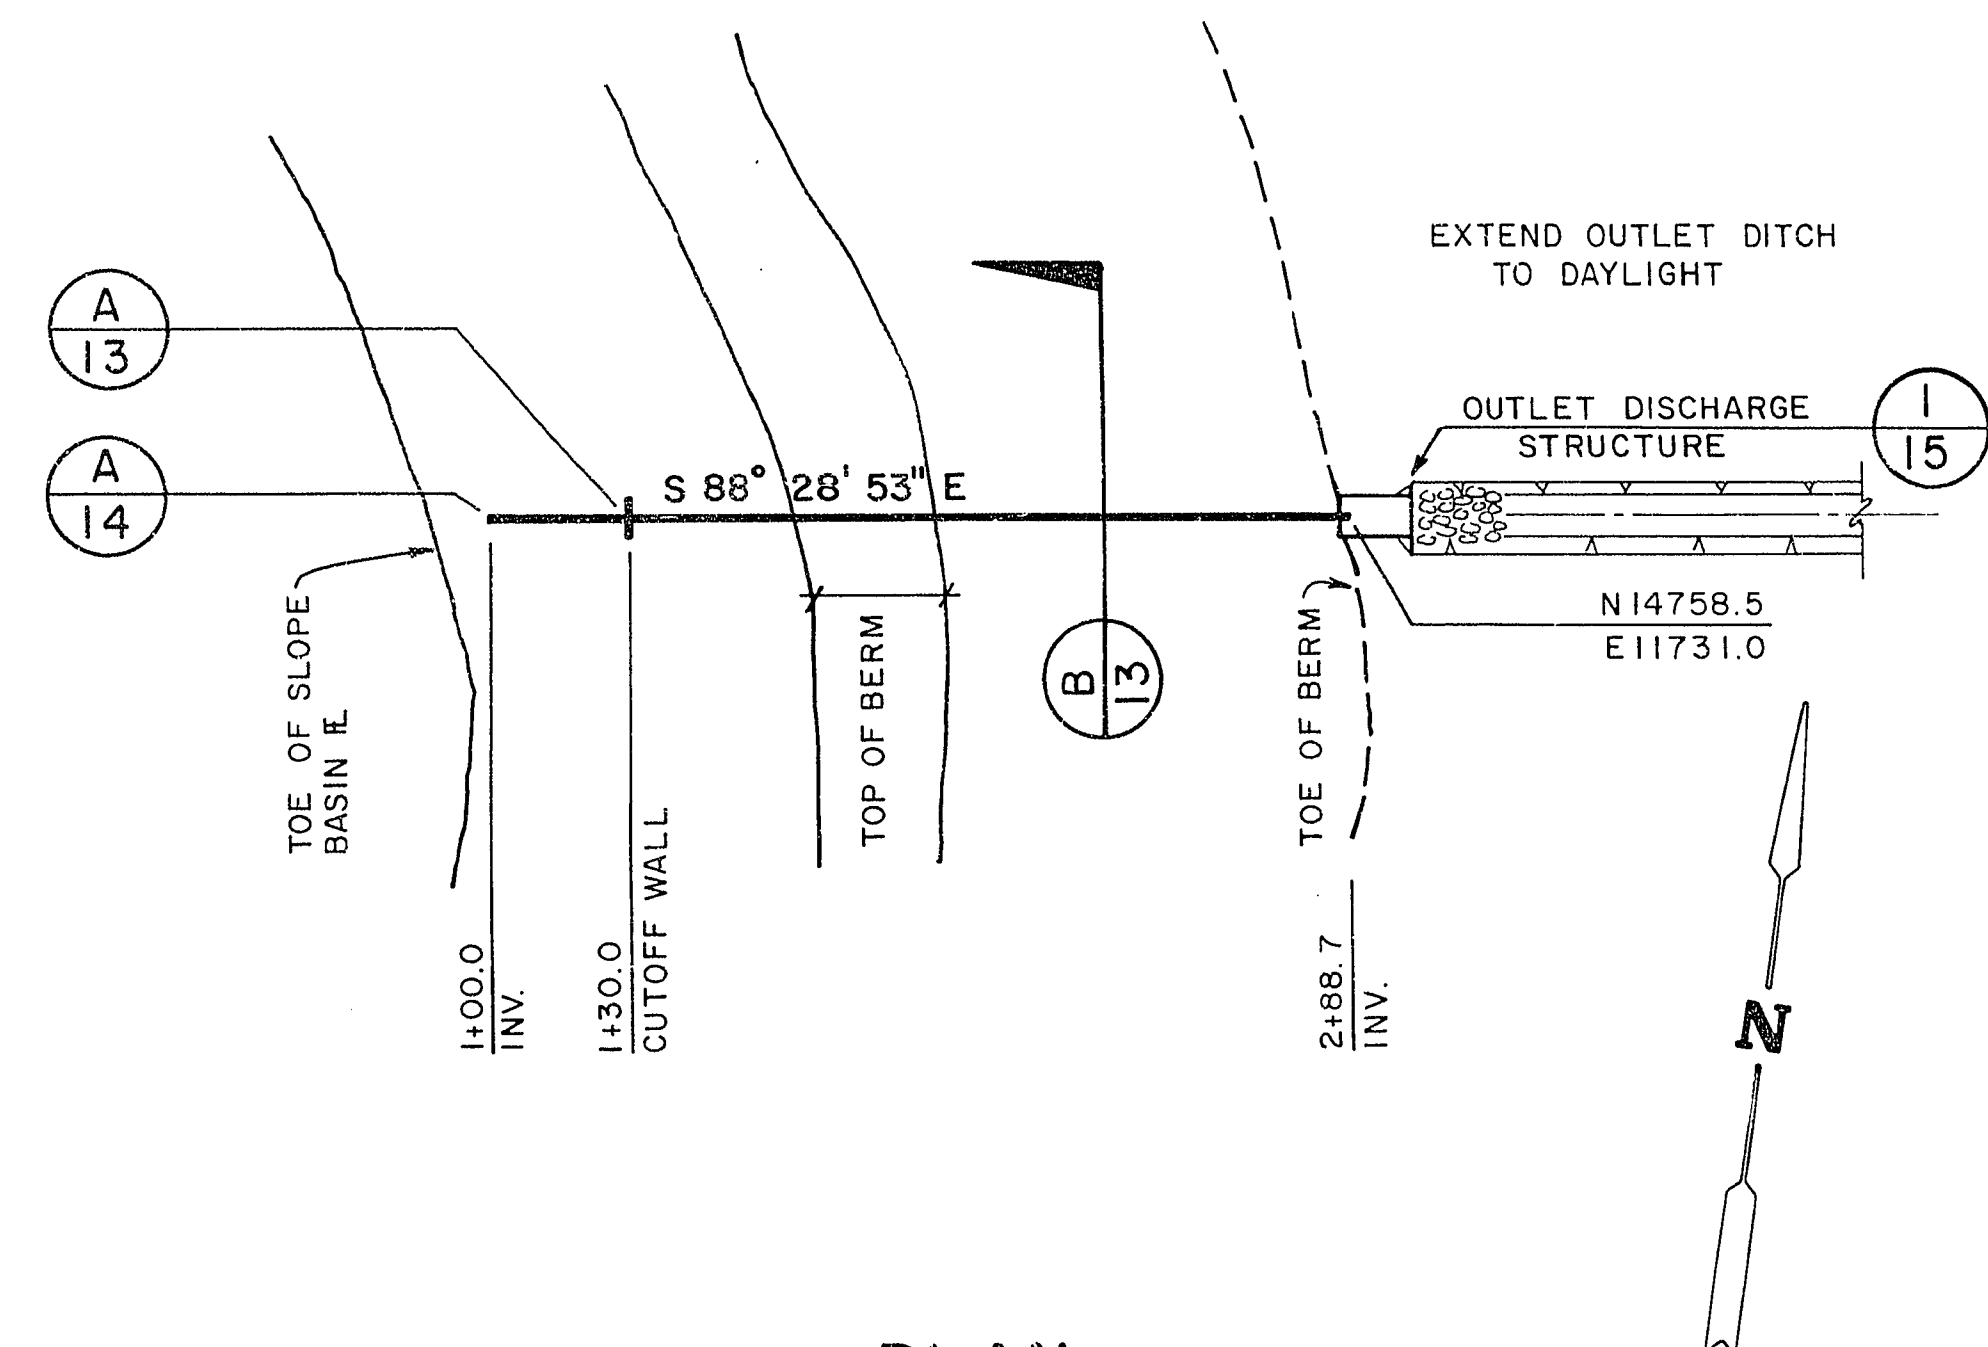

PLAN
OUTLET PIPE (SPILLWAY NO. 2)

SCALE: 1" = 40'

(SEE GRADING PLAN 3, SHT. 7 FOR LOCATION)

CITY OF LAS VEGAS,
NEVADA

neveda

CONSULTING ENGINEERS • PLANNERS
2300 PASEO DEL PRADO BUILDING A SUITE 100
LAS VEGAS, NEVADA 89102 PHONE (702) 873-7550



**OUTLET PIPING
PLAN AND PROFILE**
**ANGEL PARK DETENTION BASIN
PHASE II B**

WO NO. 3061/B
BY VJS
DATE 2/6/85
SCALE AS SHOWN

SHEET
13
OF 16 SHEETS

11/2/85
2/6/85

AS BUILT 650.14-V9