


NOT INCLUDED
IN CONTRACT

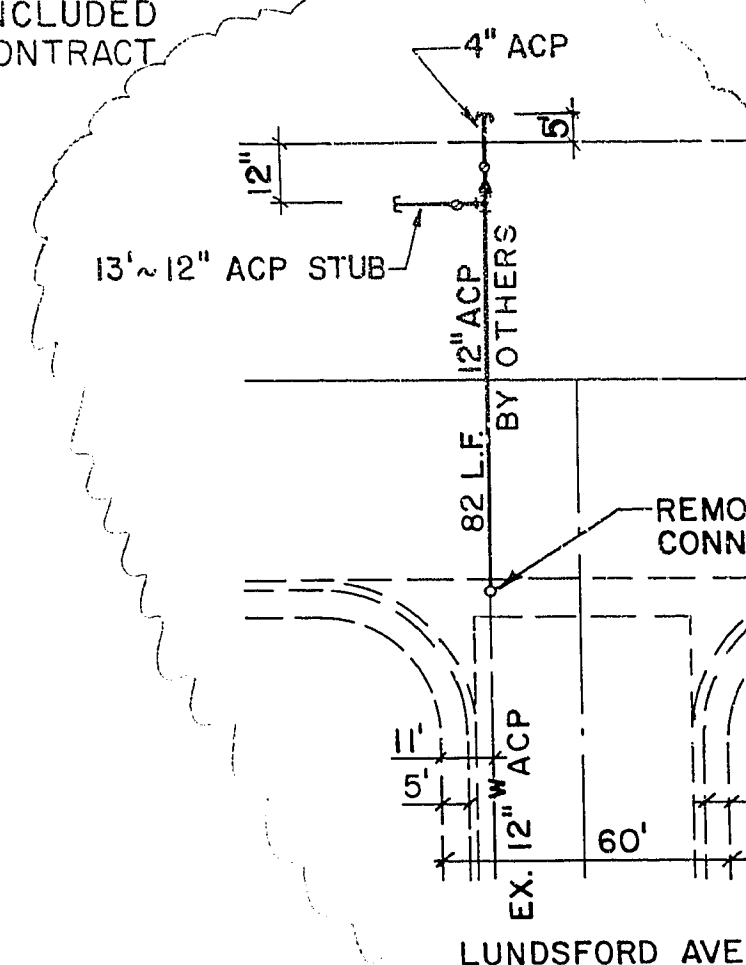

REMOVE BLOW-OFF &
CONNECT TO EXIST.


DURANGO

DRIVE

"WILLOWCREST UNIT - 2"

MATCH TO BOTTOM LEFT

1" = 40'

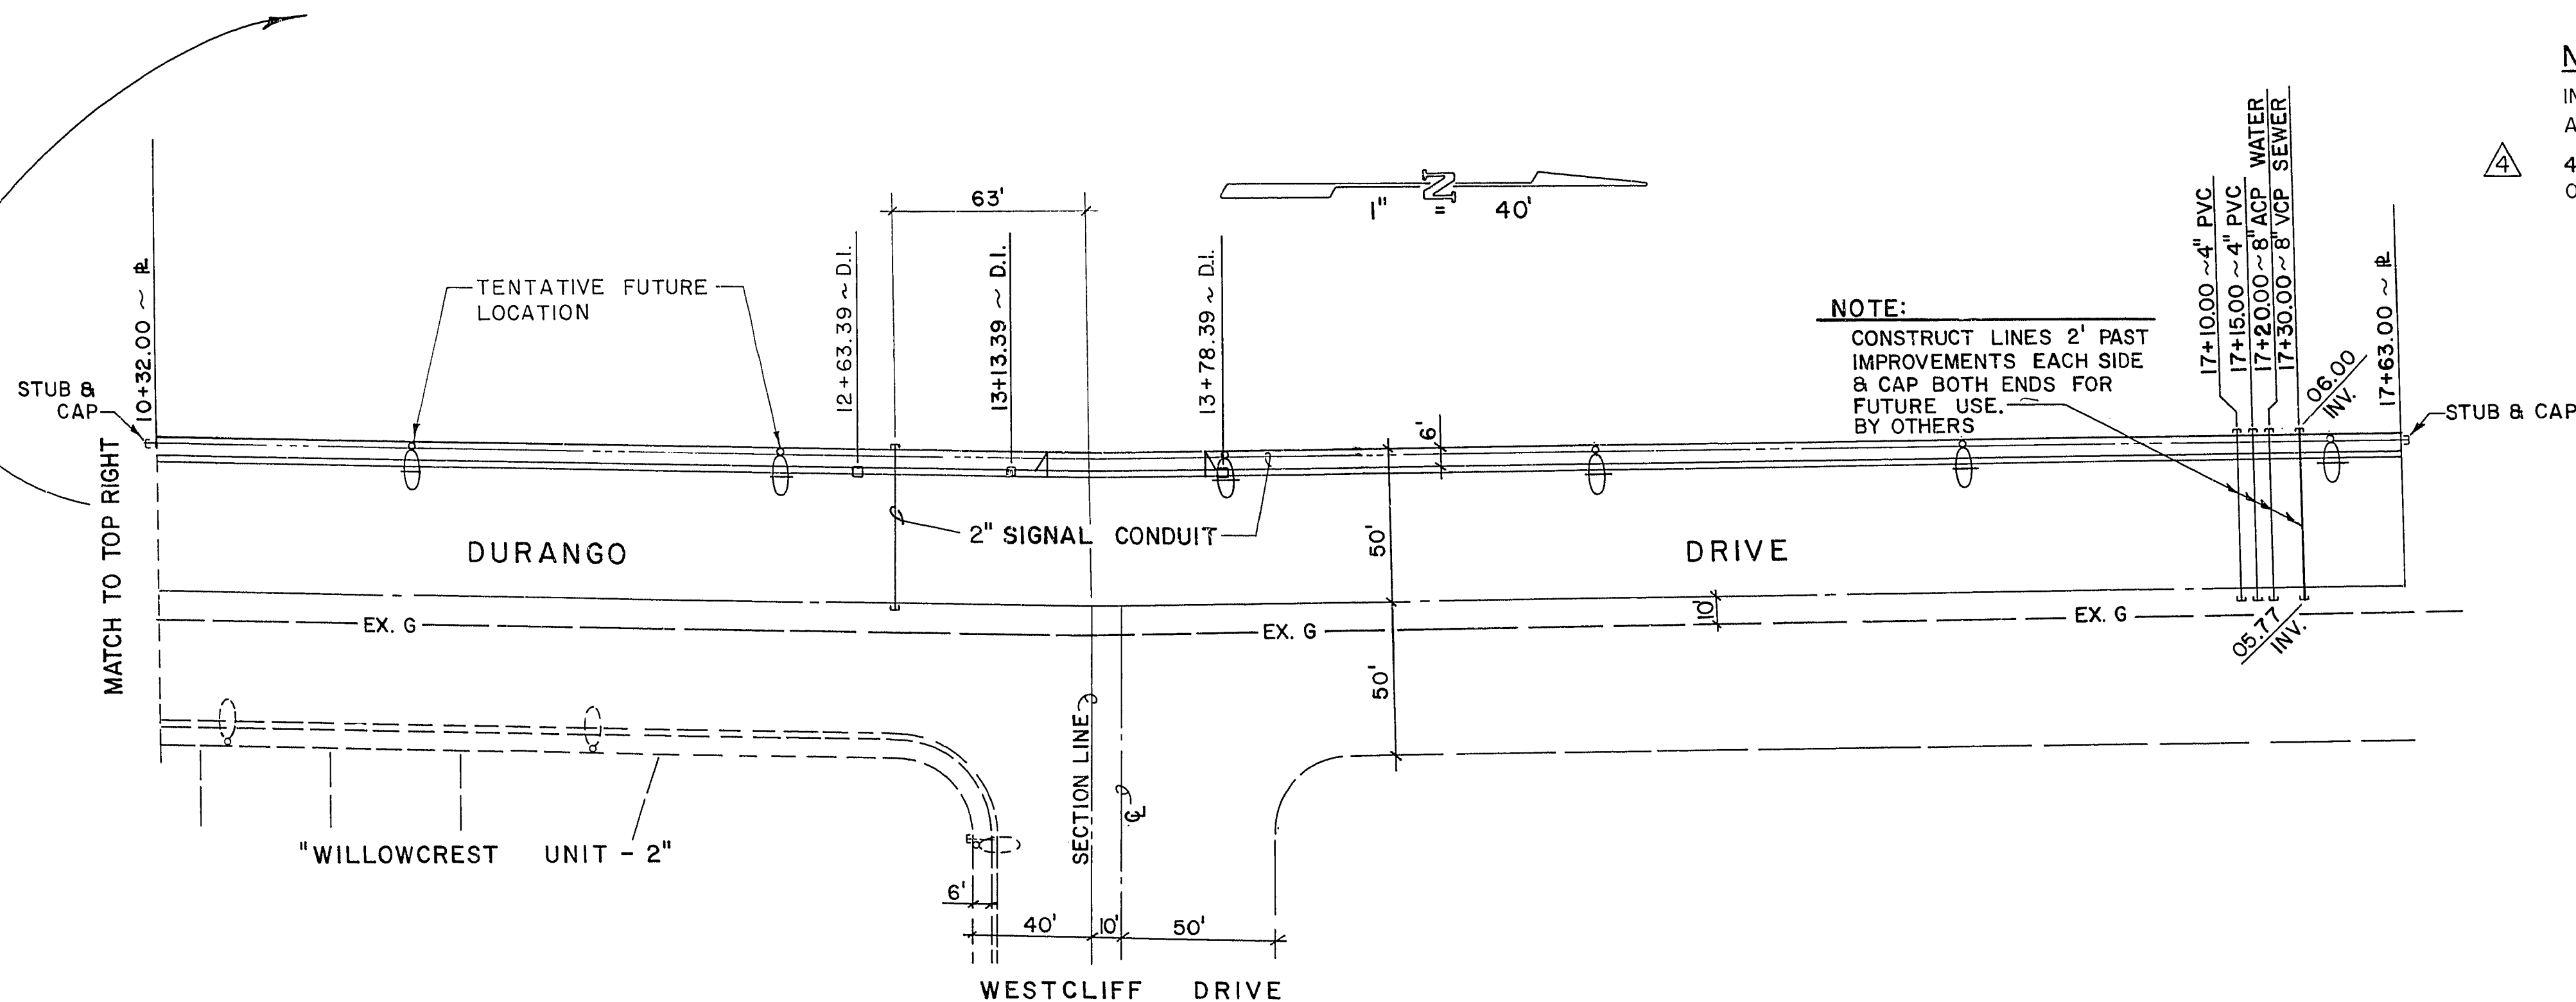


NOTE:
CONSTRUCT LINES 2' PAST
IMPROVEMENTS EACH SIDE
& CAP BOTH ENDS FOR
FUTURE USE
BY OTHERS

NOTE:

INSTALL STREET LIGHT CONDUIT
AND PULL WIRE ONLY.
4" PVC, 8" ACP PLACED 4 FT. TOP
OF PIPE TO FINISHED GRADE.

AS BUILT
11/15/84

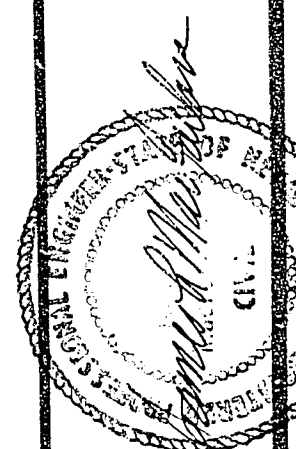

vtm nevada

REV	DATE	BY	ADD NOTE
1	10/4/83	RPF	ADDED GAS LINE
2	1/20/83	RPF	ADDED GAS LINE
3	12/30/83	EDY	PER LVWD
4	9/15/84	NW	ADD NOTE - COVER OVER PIPELINES

CONSULTING ENGINEERS • PLANNERS
2800 WEST SAHARA AVENUE BUILDING 4 SUITE B
LAS VEGAS, NEVADA 89102 PHONE (702) 873-7550

UTILITY PLAN

ANGEL PARK DETENTION BASIN
PHASE IIA

WO NO. 3061

BY RPF/MJB

DATE 10/2/83

SCALE 1" = 40'

SHEET

24

OF 36 SHEETS

650.14-7