


18-13-5

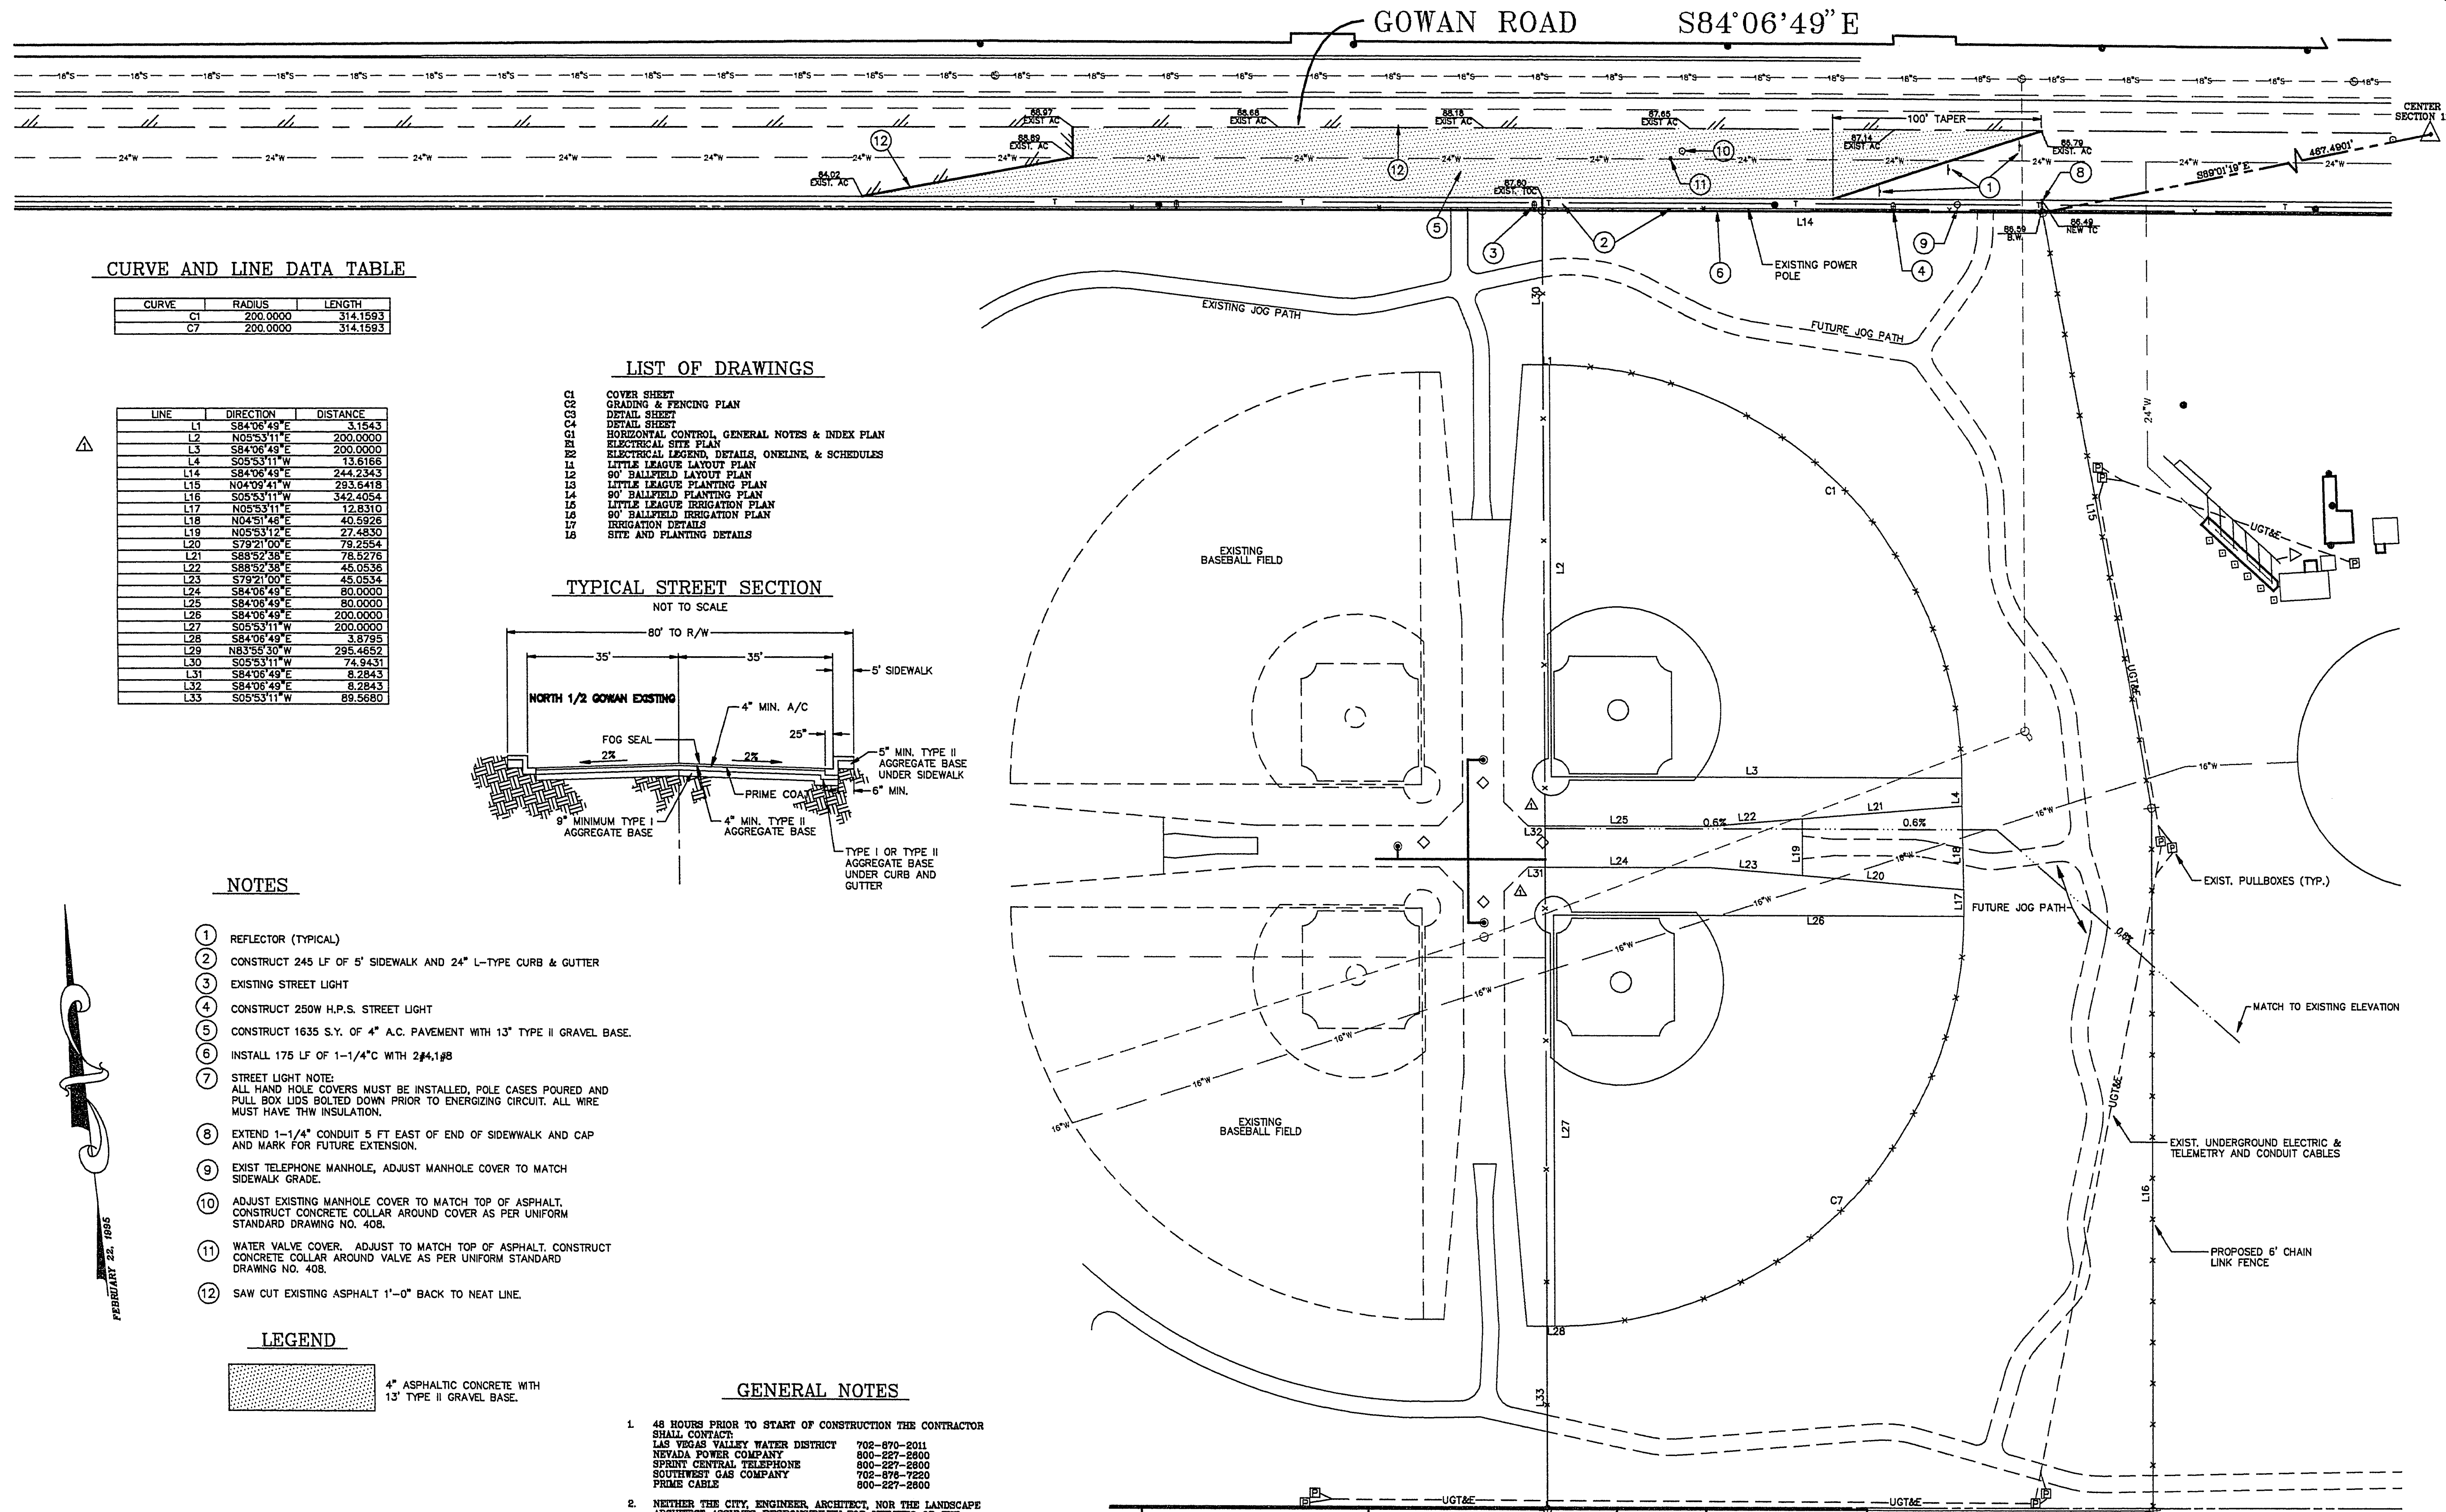

CURVE AND LINE DATA TABLE

CURVE	RADIUS	LENGTH
C1	200.0000	314.1593
C7	200.0000	314.1593


LINE	DIRECTION	DISTANCE
L1	S84°06'49"E	3.1543
L2	N05°53'11"E	200.0000
L3	S84°06'49"E	200.0000
L4	S05°53'11"W	13.6166
L14	S84°06'49"E	244.2343
L15	N04°09'41"W	233.5418
L16	S05°53'11"W	342.4054
L17	N05°53'11"E	12.8310
L18	N04°51'48"E	40.5926
L19	N05°53'12"E	27.4830
L20	S78°21'00"E	79.2554
L21	S88°52'38"E	78.5276
L22	S88°52'38"E	45.0536
L23	S79°21'00"E	45.0534
L24	S84°06'49"E	80.0000
L25	S84°06'49"E	80.0000
L26	S84°06'49"E	200.0000
L27	S05°53'11"W	200.0000
L28	S84°06'49"E	3.8795
L29	N83°55'30"W	295.4552
L30	S05°53'11"W	74.9431
L31	S84°06'49"E	8.2843
L32	S84°06'49"E	8.2843
L33	S05°53'11"W	89.5680

LIST OF DRAWINGS

- C1 COVER SHEET
- C2 GRADING & FENCING PLAN
- C3 DETAIL SHEET
- C4 DETAIL SHEET
- H1 HORIZONTAL CONTROL, GENERAL NOTES & INDEX PLAN
- E1 ELECTRICAL SITE PLAN
- E2 ELECTRICAL LEGEND, DETAILS, ONELINE, & SCHEDULES
- L1 LITTLE LEAGUE LAYOUT PLAN
- L2 90' BALLFIELD LAYOUT PLAN
- L3 LITTLE LEAGUE PLANTING PLAN
- L4 90' BALLFIELD PLANTING PLAN
- L5 LITTLE LEAGUE IRRIGATION PLAN
- L6 90' BALLFIELD IRRIGATION PLAN
- L7 IRRIGATION DETAILS
- L8 SITE AND PLANTING DETAILS

TYPICAL STREET SECTION


NOT TO SCALE

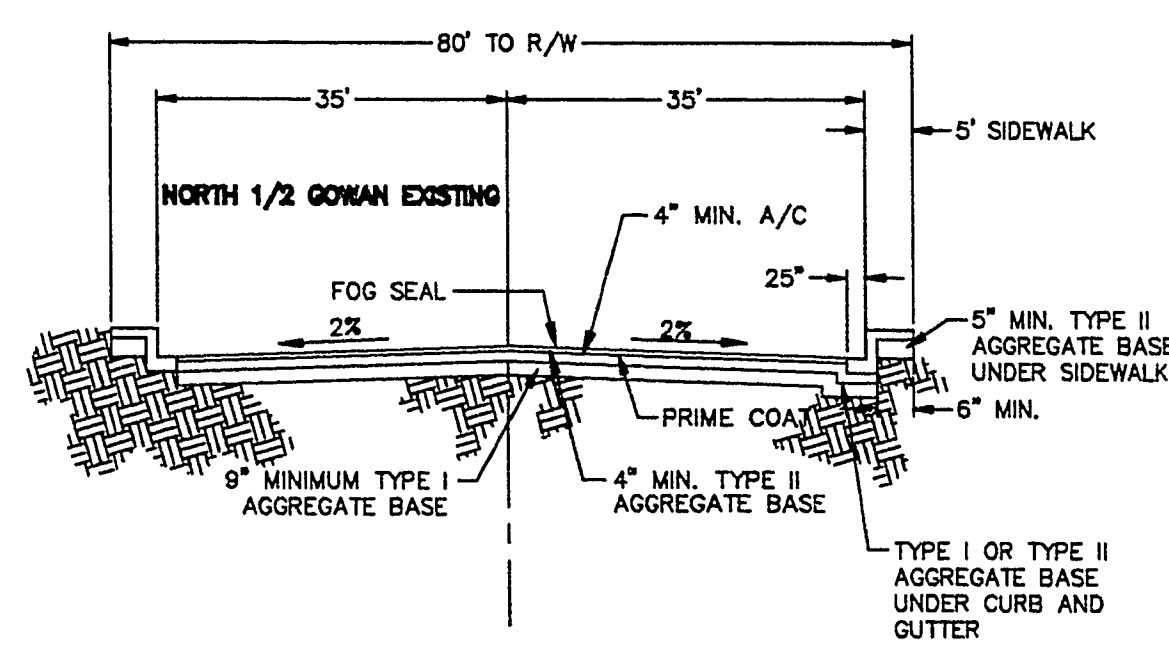

NOTES

- REFLECTOR (TYPICAL)
- CONSTRUCT 245 LF OF 5' SIDEWALK AND 24" L-TYPE CURB & GUTTER
- EXISTING STREET LIGHT
- CONSTRUCT 250W H.P.S. STREET LIGHT
- CONSTRUCT 1635 S.Y. OF 4" A.C. PAVEMENT WITH 13" TYPE II GRAVEL BASE.
- INSTALL 175 LF OF 1-1/4" C WITH 2#4,1#8
- STREET LIGHT NOTE:
ALL HAND HOLE COVERS MUST BE INSTALLED, POLE CASES POURED AND PULL BOX LIDS BOLTED DOWN PRIOR TO ENERGIZING CIRCUIT. ALL WIRE MUST HAVE THW INSULATION.
- EXTEND 1-1/4" CONDUIT 5 FT EAST OF END OF SIDEWALK AND CAP AND MARK FOR FUTURE EXTENSION.
- EXIST TELEPHONE MANHOLE, ADJUST MANHOLE COVER TO MATCH SIDEWALK GRADE.
- ADJUST EXISTING MANHOLE COVER TO MATCH TOP OF ASPHALT. CONSTRUCT CONCRETE COLLAR AROUND COVER AS PER UNIFORM STANDARD DRAWING NO. 408.
- WATER VALVE COVER. ADJUST TO MATCH TOP OF ASPHALT. CONSTRUCT CONCRETE COLLAR AROUND VALVE AS PER UNIFORM STANDARD DRAWING NO. 408.
- SAW CUT EXISTING ASPHALT 1'-0" BACK TO NEAT LINE.

 LEGEND





GENERAL NOTES

- 48 HOURS PRIOR TO START OF CONSTRUCTION THE CONTRACTOR SHALL CONTACT:
LAS VEGAS VALLEY WATER DISTRICT 702-670-2011
NEVADA POWER COMPANY 800-227-2800
SPELINT CENTRAL TELEPHONE 800-227-2800
SOUTHWEST GAS COMPANY 702-576-7220
PRIME CABLE 800-227-2800
- NEITHER THE CITY, ENGINEER, ARCHITECT, NOR THE LANDSCAPE ARCHITECT ASSUMES RESPONSIBILITY FOR UTILITIES OR THE STRUCTURES NOT SHOWN OR NOT IN THE LOCATION SHOWN ON THE DRAWINGS. CONTRACTOR SHALL VERIFY THE EXACT LOCATION OF THE UTILITIES PRIOR TO CONSTRUCTION CALL BEFORE YOU DIG. THE CONTRACTOR'S RESPONSIBILITY REGARDING UTILITIES SHALL BE AS REQUIRED UNDER SECTION 107.17 OF THE UNIFORM STANDARD SPECIFICATIONS FOR CLARK COUNTY AREA, NEVADA AND AS PROVIDED IN SPECIFICATIONS.
- THE CONTRACTOR SHALL TAKE ALL PRECAUTIONARY MEASURES NECESSARY TO PROTECT EXISTING IMPROVEMENTS FROM DAMAGE. IMPROVEMENTS OR STRUCTURES DAMAGED BY THE CONTRACTOR'S OPERATIONS SHALL BE REPAIRED OR RECONSTRUCTED TO THE SATISFACTION OF THE CITY'S REPRESENTATIVE AT THE EXPENSE OF THE CONTRACTOR.
- STAGING AREAS ARE TO BE COORDINATED WITH THE CITY'S REPRESENTATIVE.
DEVIATIONS FROM STANDARDS: NONE.
- BASES OF BEARING: CENTERLINE OF GOWAN ROAD WEST FROM CENTER SECTION 11, 2.50S., R.60E, WEST CENTERLINE BEARS N84°06'49"E.

CITY OF LAS VEGAS BENCHMARK

N.E. CORNER GOWAN AND RAINBOW. ALUMINUM PLATE IN C.L. RETURN: No. 11V001174; ELEVATION: 2297.65

GRAPHIC SCALE

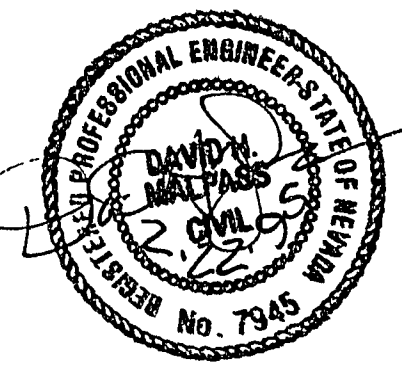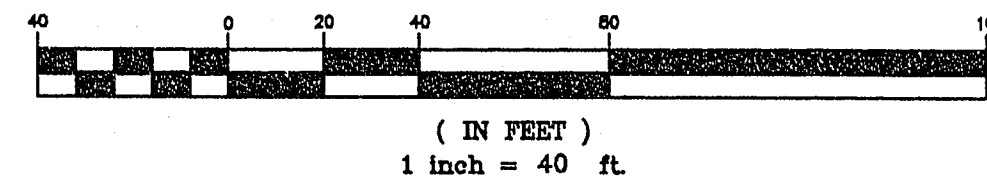

TITLE HORIZONTAL CONTROL & GENERAL NOTES

PROJECT CHILDREN'S MEMORIAL PARK PHASE III

PROJECT NO: 911246407.11
DATE: FEBRUARY 22, 1995
SCALE: HORIZ: 1" = 40'
VERT: AS SHOWN
DWG FILE: C:\MPARK\CHNL\G1.DWG

SHEET 5 of 15
G1
OF 7 SHEETS
Revised 650.35-4

CALL before you DIG
1-800-227-2600
UNDERGROUND SERVICE (USA)
AVOID CUTTING UNDERGROUND
UTILITY LINES. IT'S COSTLY.

