


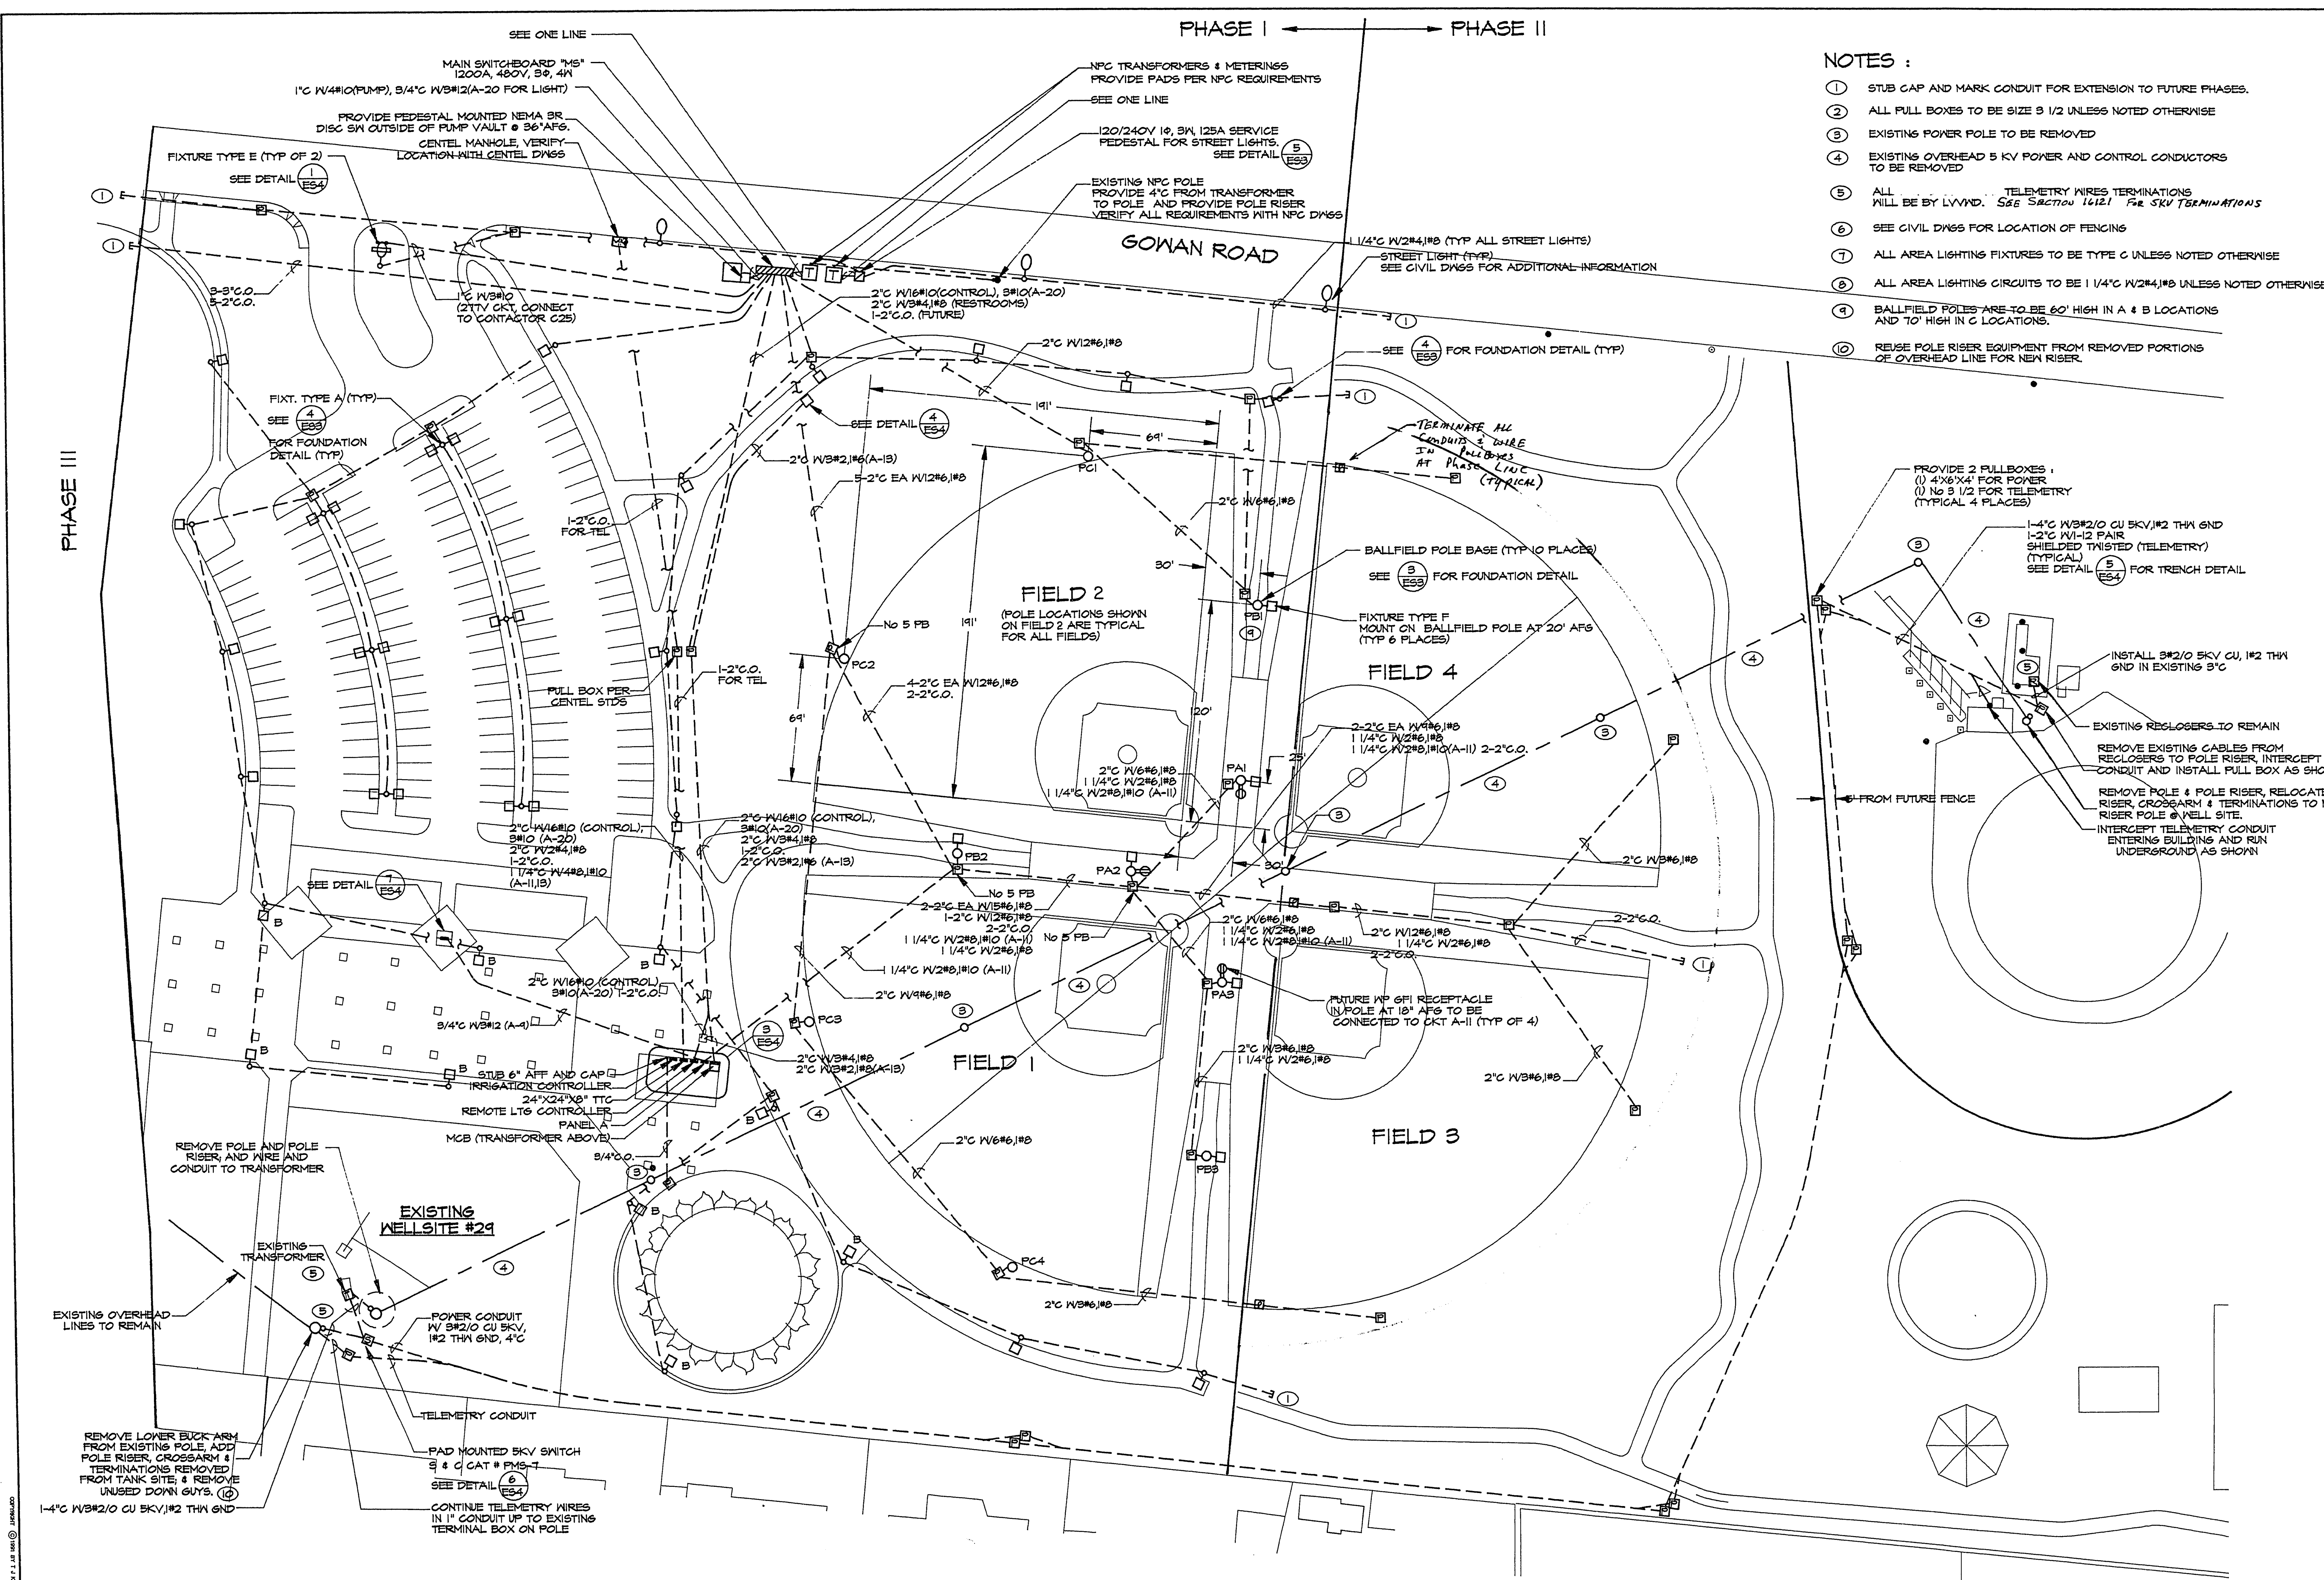

- NOTES :
- 1 STUB CAP AND MARK CONDUIT FOR EXTENSION TO FUTURE PHASES.
 - 2 ALL FULL BOXES TO BE SIZE 3 1/2 UNLESS NOTED OTHERWISE
 - 3 EXISTING POWER POLE TO BE REMOVED
 - 4 EXISTING OVERHEAD 5 KV POWER AND CONTROL CONDUCTORS TO BE REMOVED
 - 5 ALL TELEMETRY WIRES TERMINATIONS WILL BE BY WVD. SEE SECTION 16121 FOR SKV TERMINATIONS
 - 6 SEE CIVIL DWGS FOR LOCATION OF FENCING
 - 7 ALL AREA LIGHTING FIXTURES TO BE TYPE C UNLESS NOTED OTHERWISE
 - 8 ALL AREA LIGHTING CIRCUITS TO BE 1 1/4" W/2#4,1#8 UNLESS NOTED OTHERWISE
 - 9 BALLFIELD POLES ARE TO BE 60' HIGH IN A & B LOCATIONS AND 70' HIGH IN C LOCATIONS.
 - 10 REUSE POLE RISER EQUIPMENT FROM REMOVED PORTIONS OF OVERHEAD LINE FOR NEW RISER.

ELECTRICAL SITE PLAN
SCALE: 1"=40'-0"

AS BUILT

SHEET TITLE:		ELECTRICAL SITE PLAN	
PROJECT:		TORREY PINES PARK	
CITY OF LAS VEGAS PARKS & LEISURE ACTIVITIES			
JOB NUMBER:		238	
DATE:		5-18-92	
DRAWN BY:		NR	
CHECKED BY:		TOM KROB	
RECOMMENDED:			
DATE:		5-19-92	
SHEET:		19	
OF:		ESI	
OF:		38	

TJKROB CONSULTING ENGINEERS, INC. 3160 S. VALLEY VIEW BLVD. SUITE 207 LAS VEGAS, NEVADA 89102 (702) 871-2421	REV	DATE	DESCRIPTION
	1	5/1/92	REV. FIELD NO. 1 & 2 NUMBERING