



18-13-43

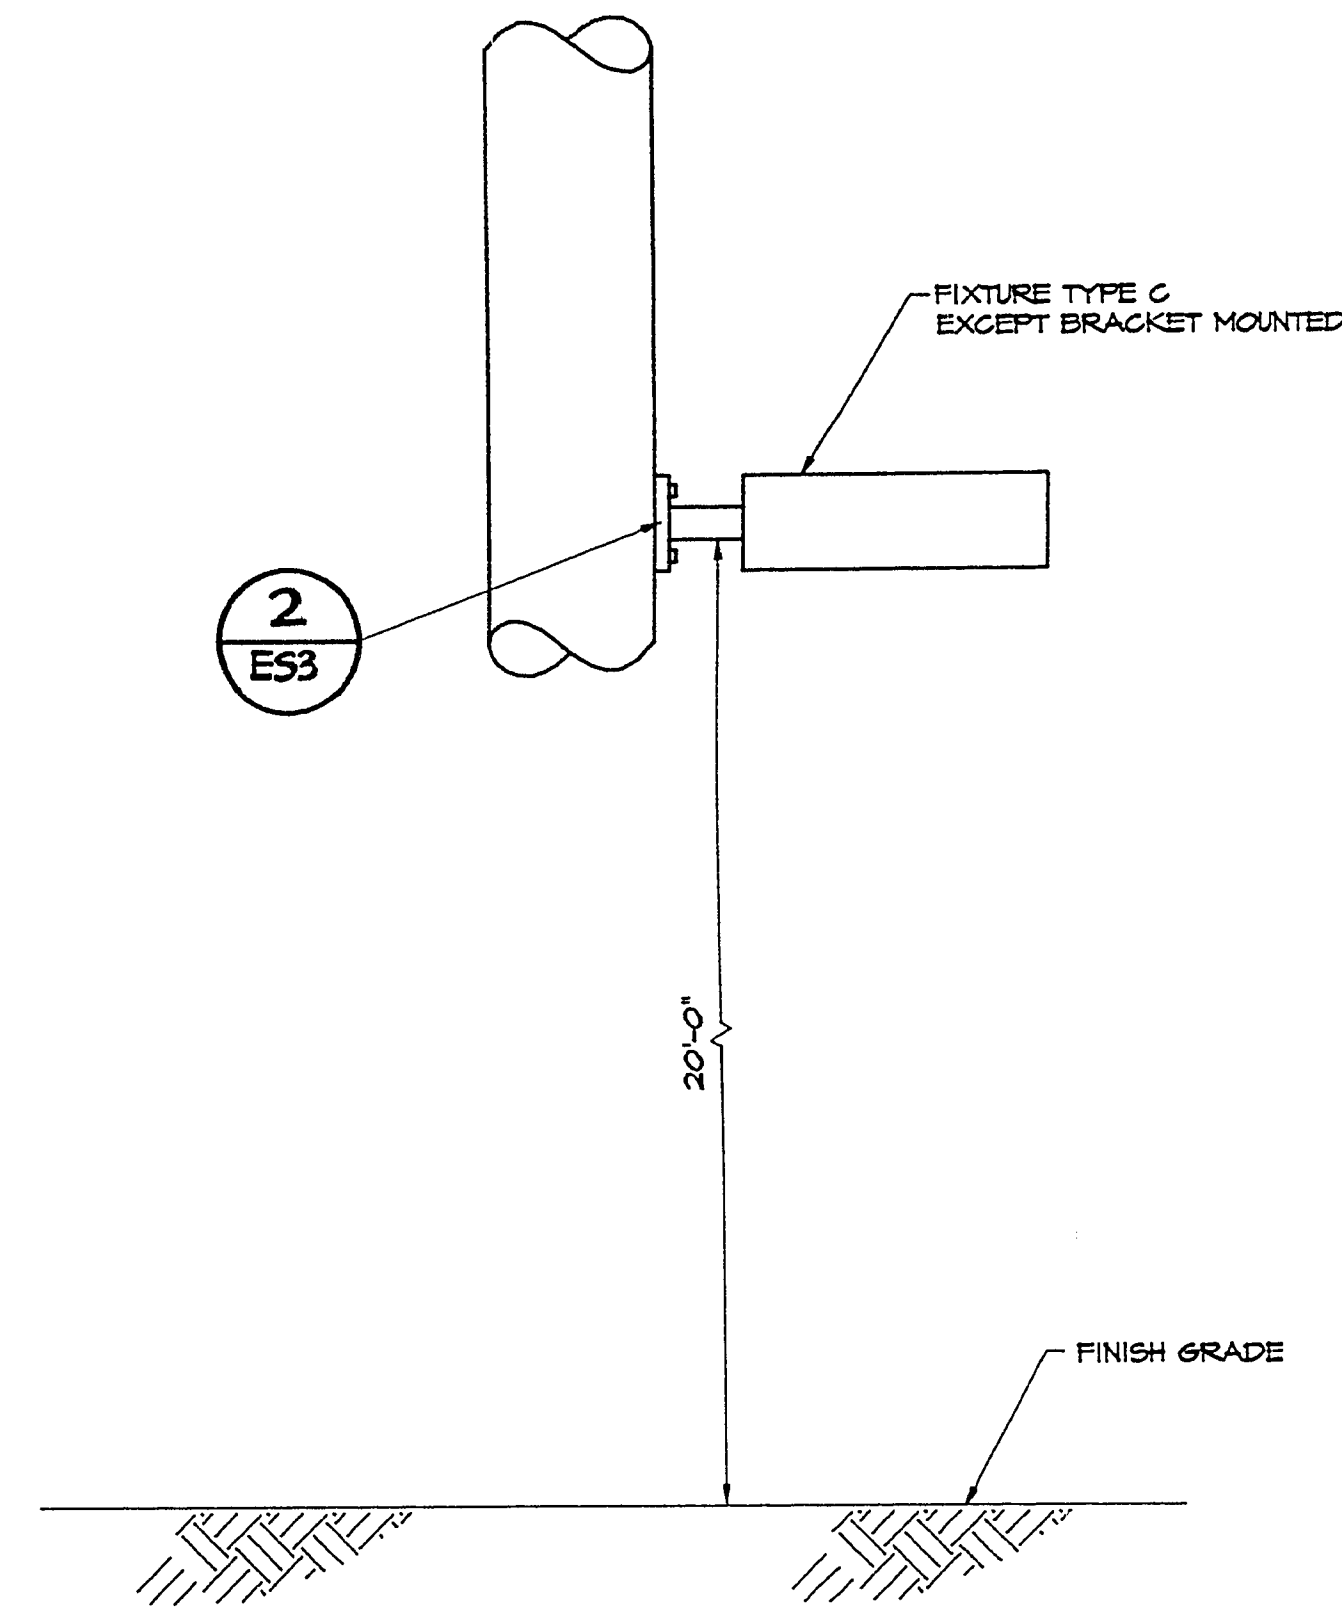

AREA LIGHTING MOUNTING DETAIL

NOT TO SCALE


1
ESS

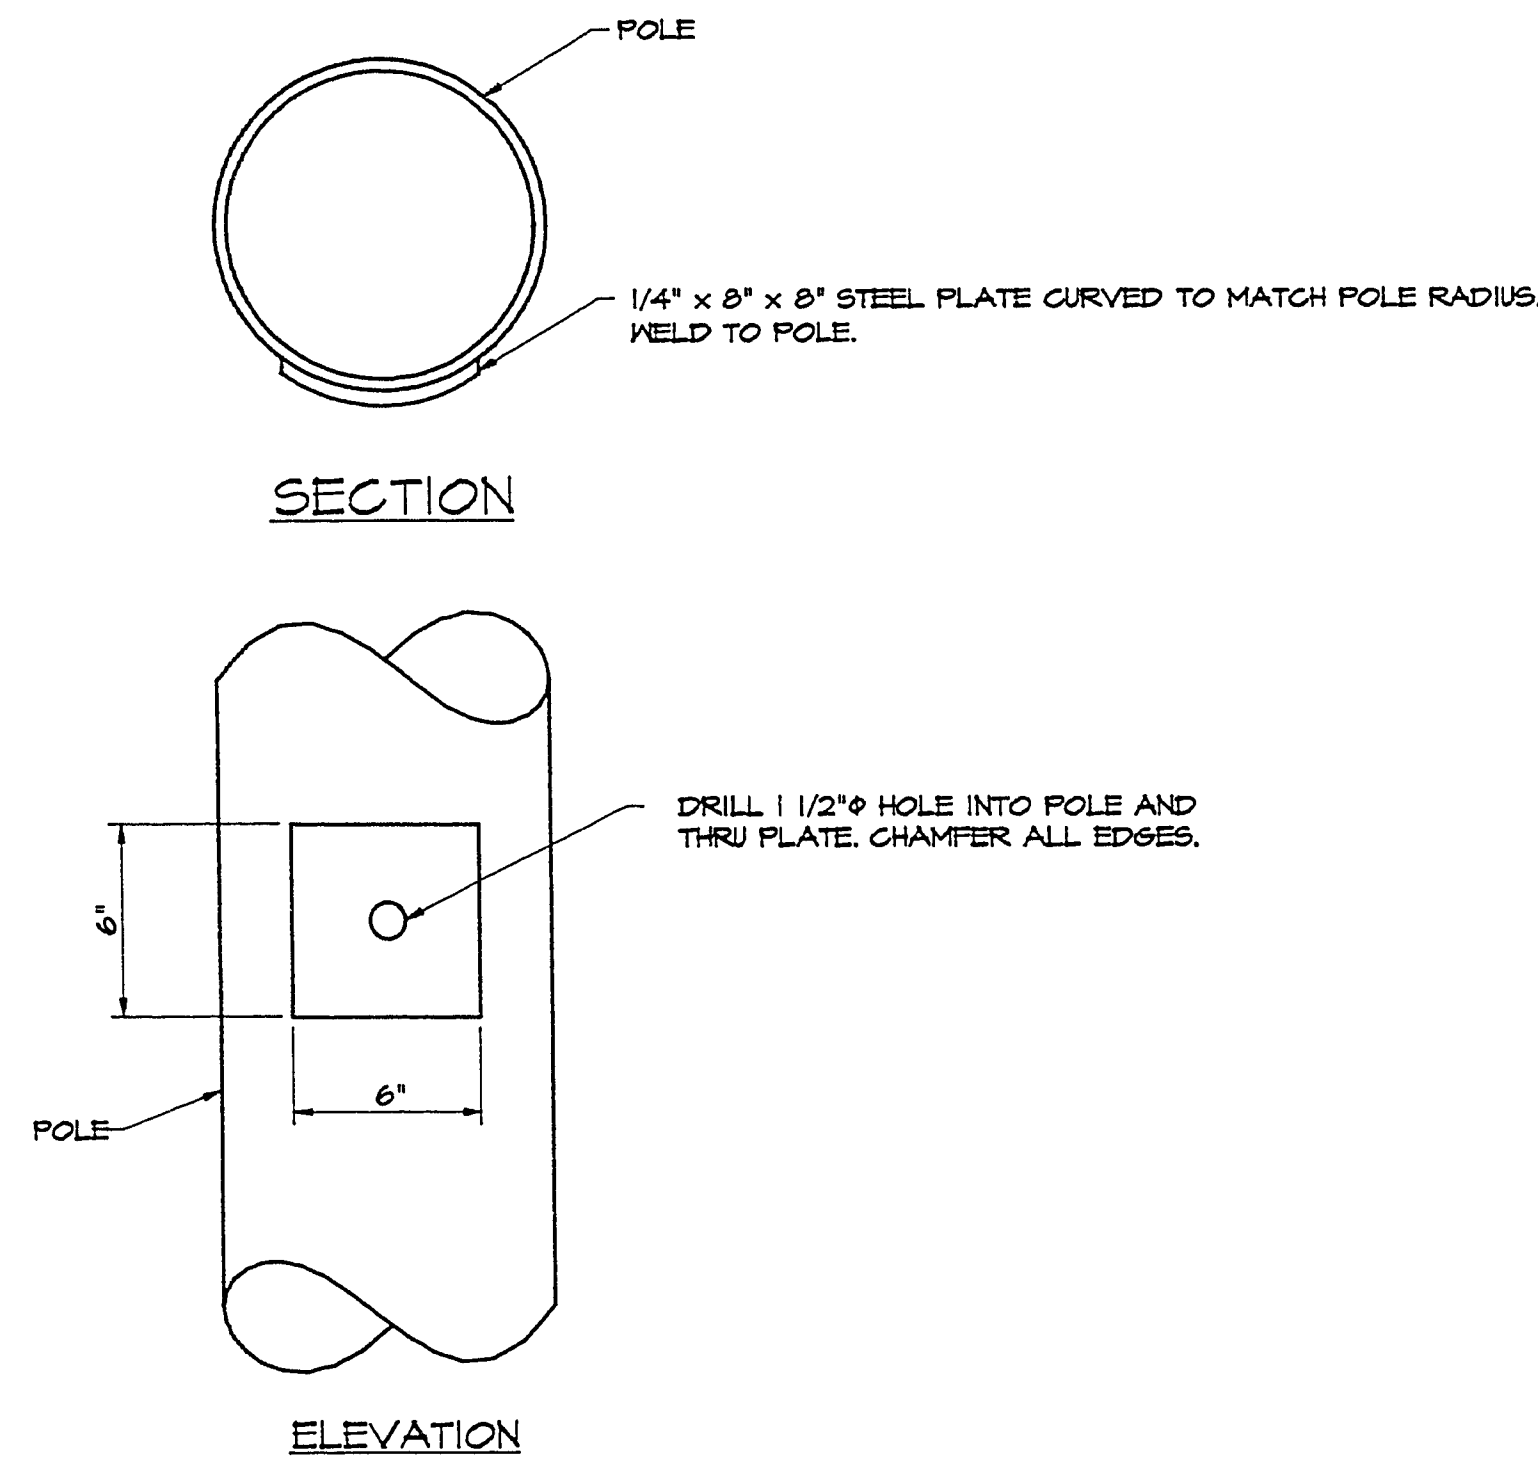

BRACKET MOUNT AREA LIGHTING

NOT TO SCALE


2
ESS

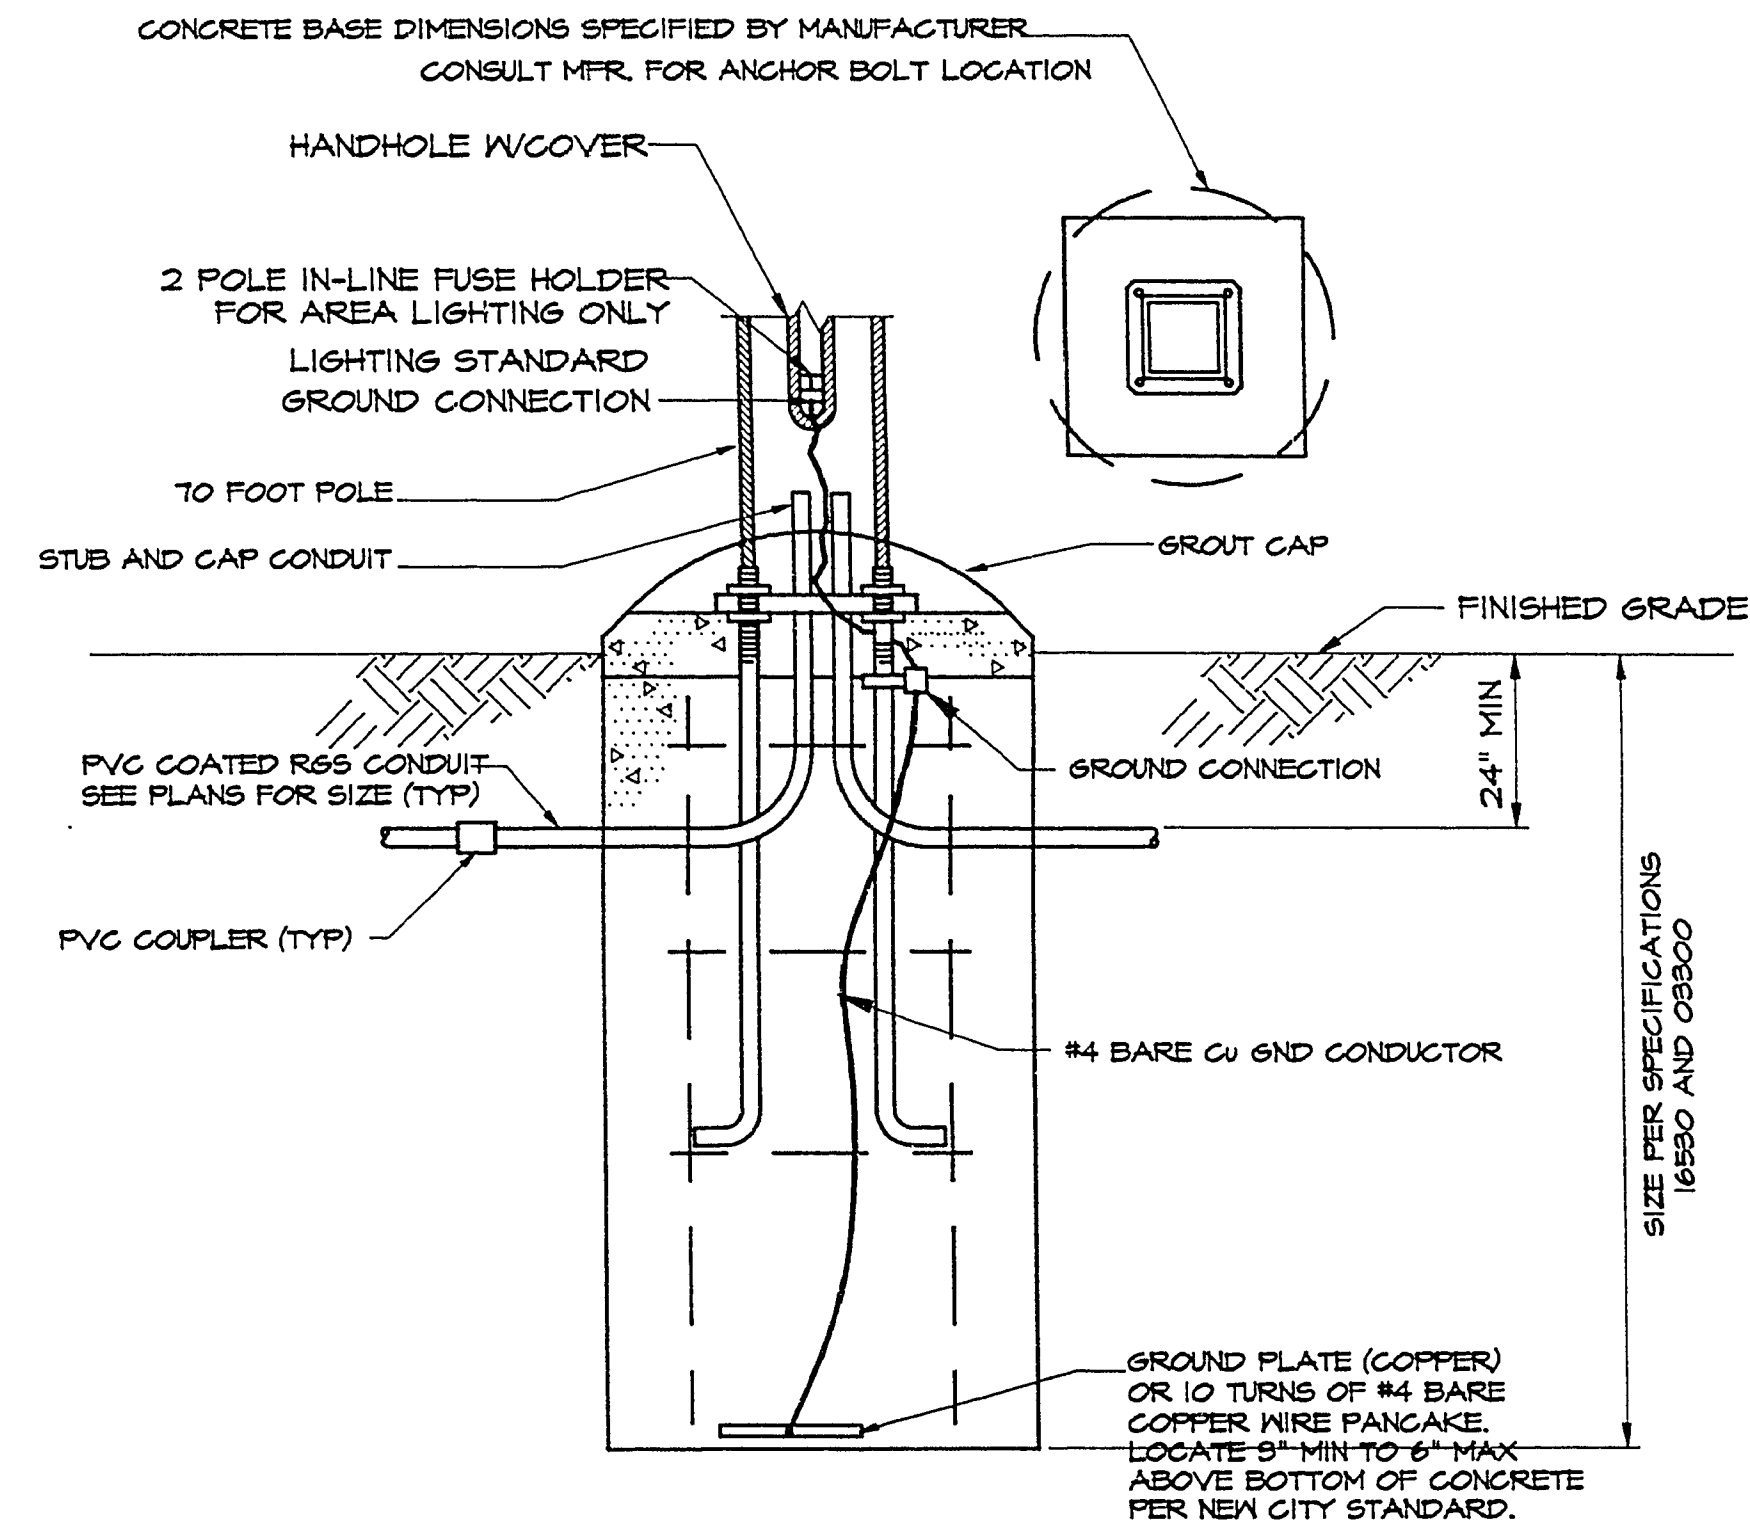

BALLFIELD POLE CONCRETE BASE DETAIL

NOT TO SCALE


3
ESS

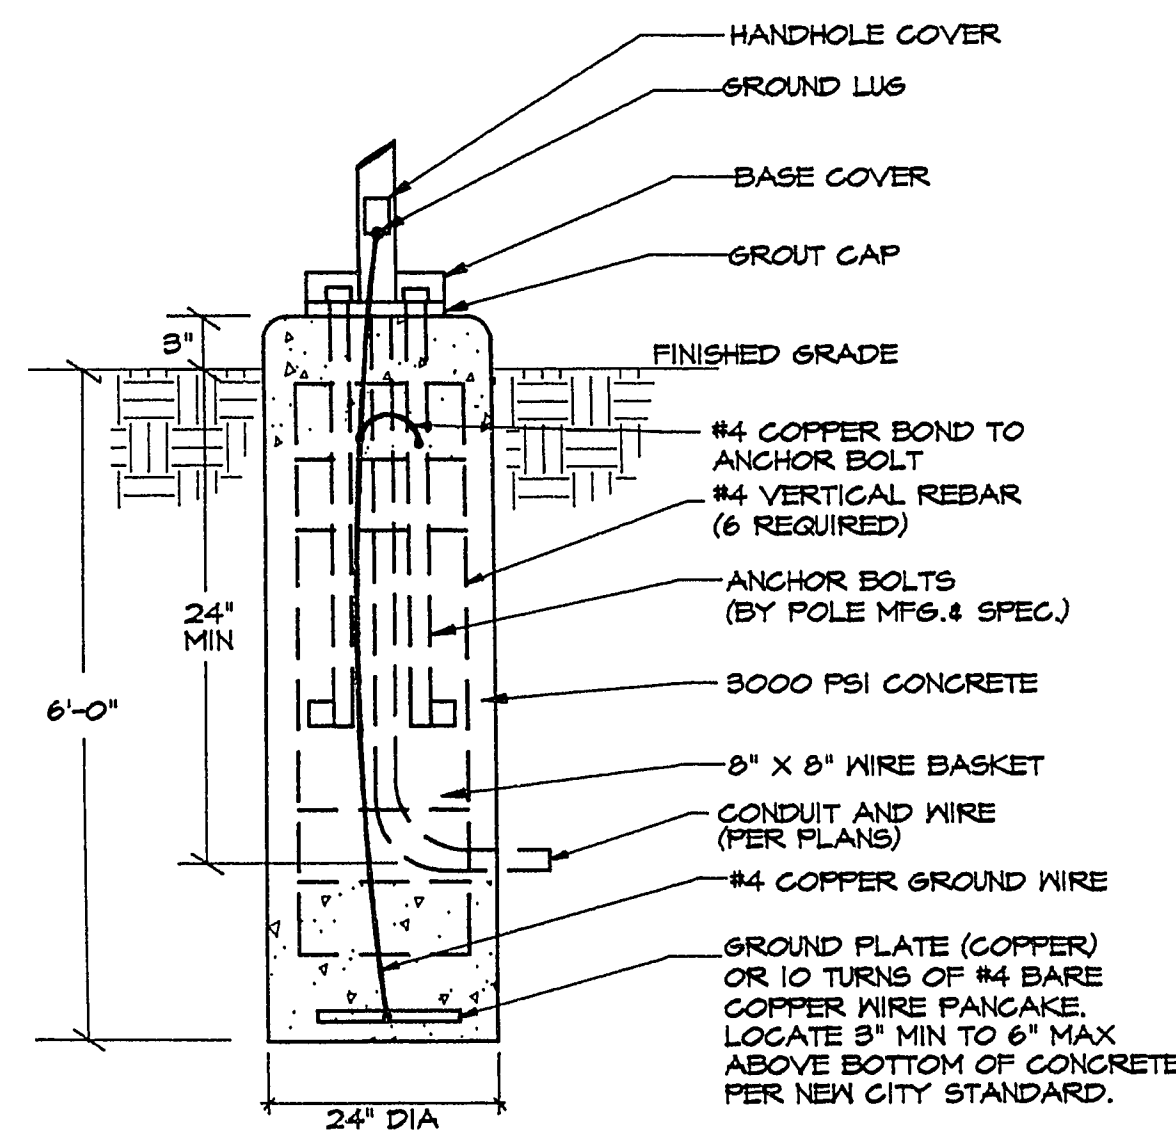

AREA LIGHTING POLE BASE DETAIL

NOT TO SCALE

4
ESS

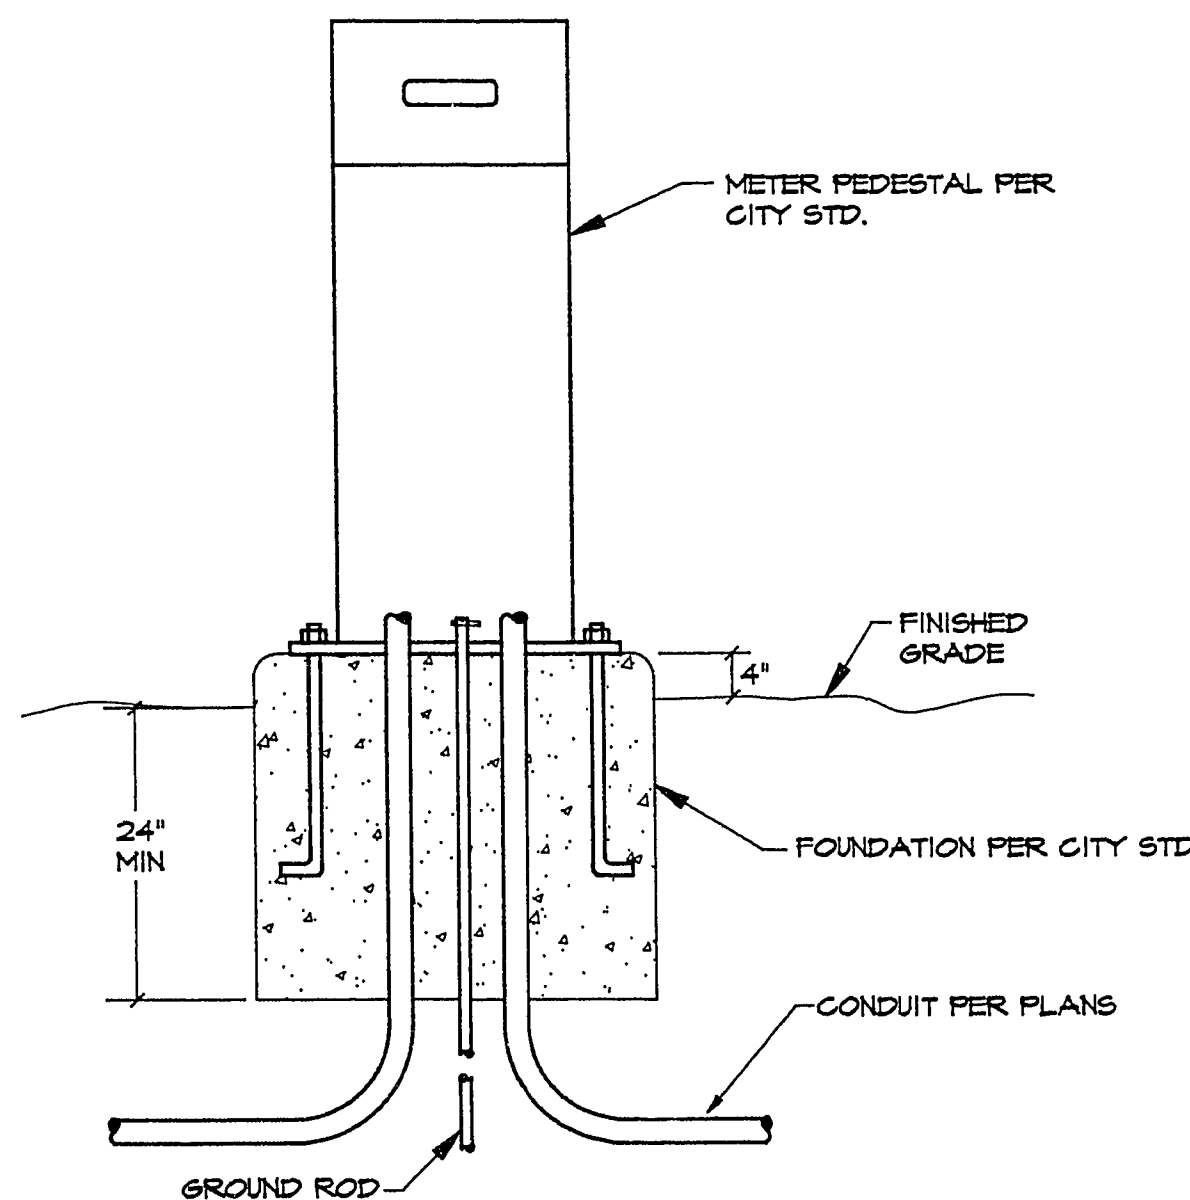

INSTALLATION DETAIL SERVICE PEDESTAL

NOT TO SCALE

5
ESS

PANEL A*1, 3 PH, 4 WIRE, 120/208 VOLTS 100 A MCB SURFACE MOUNTED											
MIN INTERRUPTING RATING 10,000 RMS SYM AMPS LOCATION: RESTROOM NEMA 1											
L = LIGHTS, R = RECEPTACLES, M = MECHANICAL EQUIPMENT, SO = SPACE ONLY, SC = SPARE CIRCUIT, E = EXISTING, G = GFI BREAKER											
MLO = MAIN LUGS ONLY, MCB = MAIN CIRCUIT BREAKERS, N = NEW											
POLE SPACE		CIRCUIT USE	CKT BKR RATING	CONNECTED LOAD VA			CKT BKR RATING	CIRCUIT USE	POLE SPACE		
ckt #	#			A	B	C			#	ckt #	
1	1	L -BUILDING	20	750			20	L -STORAGE	2	2	
				480							
3	3	L -BATH	20		750		20	R -STORAGE	4	4	
					900						
5	5	SC	20				20	HEAT LAMP	6	6	
						1875					
7	7	SC	20				20	HEAT LAMP	8	8	
						1875					
9	9	L -KIOSK *2	20		100		20	EXHAUST FAN	10	10	
					755						
11	11	R -AT BALLFIELD POLES	20			540	20	EXHAUST FAN	12	12	
						755					
13	13	SHOW MOBILE	60/2	4160			20	EXHAUST FAN	14	14	
				1440							
	15	X	X		4160		20	REMOTE LIGHTING CONTROLLER	16	16	
					1440						
	17	SO					20	REMOTE LIGHTING CONTROLLER	18	18	
						1440					
	19	SO					20	IRRIGATION CONTROLLERS	20	20	
								TIME CLOCK AND BOOSTER PUMP LTG.			
	21	SO		200			20		22	22	
	23	SO					20	SC	24	24	
	25	SO					20	SC	26	26	
	27	SO					20	SC	28	28	
	29	SO					20	SC	30	30	
	31						20	SC	32	32	
	33								34	34	
	35								36	36	
	37								38	38	
	39								40	40	
*1 THIS PANEL IS DUPLICATED FROM RESTROOM BLDG. DWGS.									42	42	
*2 VIA T/S #1				8905	8105	4610					
				21620							

AS BUILT

REV DATE DESCRIPTION

TJ KROB CONSULTING ENGINEERS, INC.
3180 S. VALLEY VIEW BLVD. SUITE 207
LAS VEGAS, NV 89102
(702) 871-2621

ELECTRICAL DETAILS

SHEET TITLE:

JOB NUMBER:
230

DATE:
5-18-42

DRAWN BY:
NR

CHECKED BY:
TOM KROB

RECOMMENDED:

DATE: 5-17-82

SHEET:
21

OF: 38

ESS

650.35-VI

TORREY PINES PARK
CITY OF LAS VEGAS PARKS & LEISURE ACTIVITIES

CHILDRENS MEMRIAL PARK