


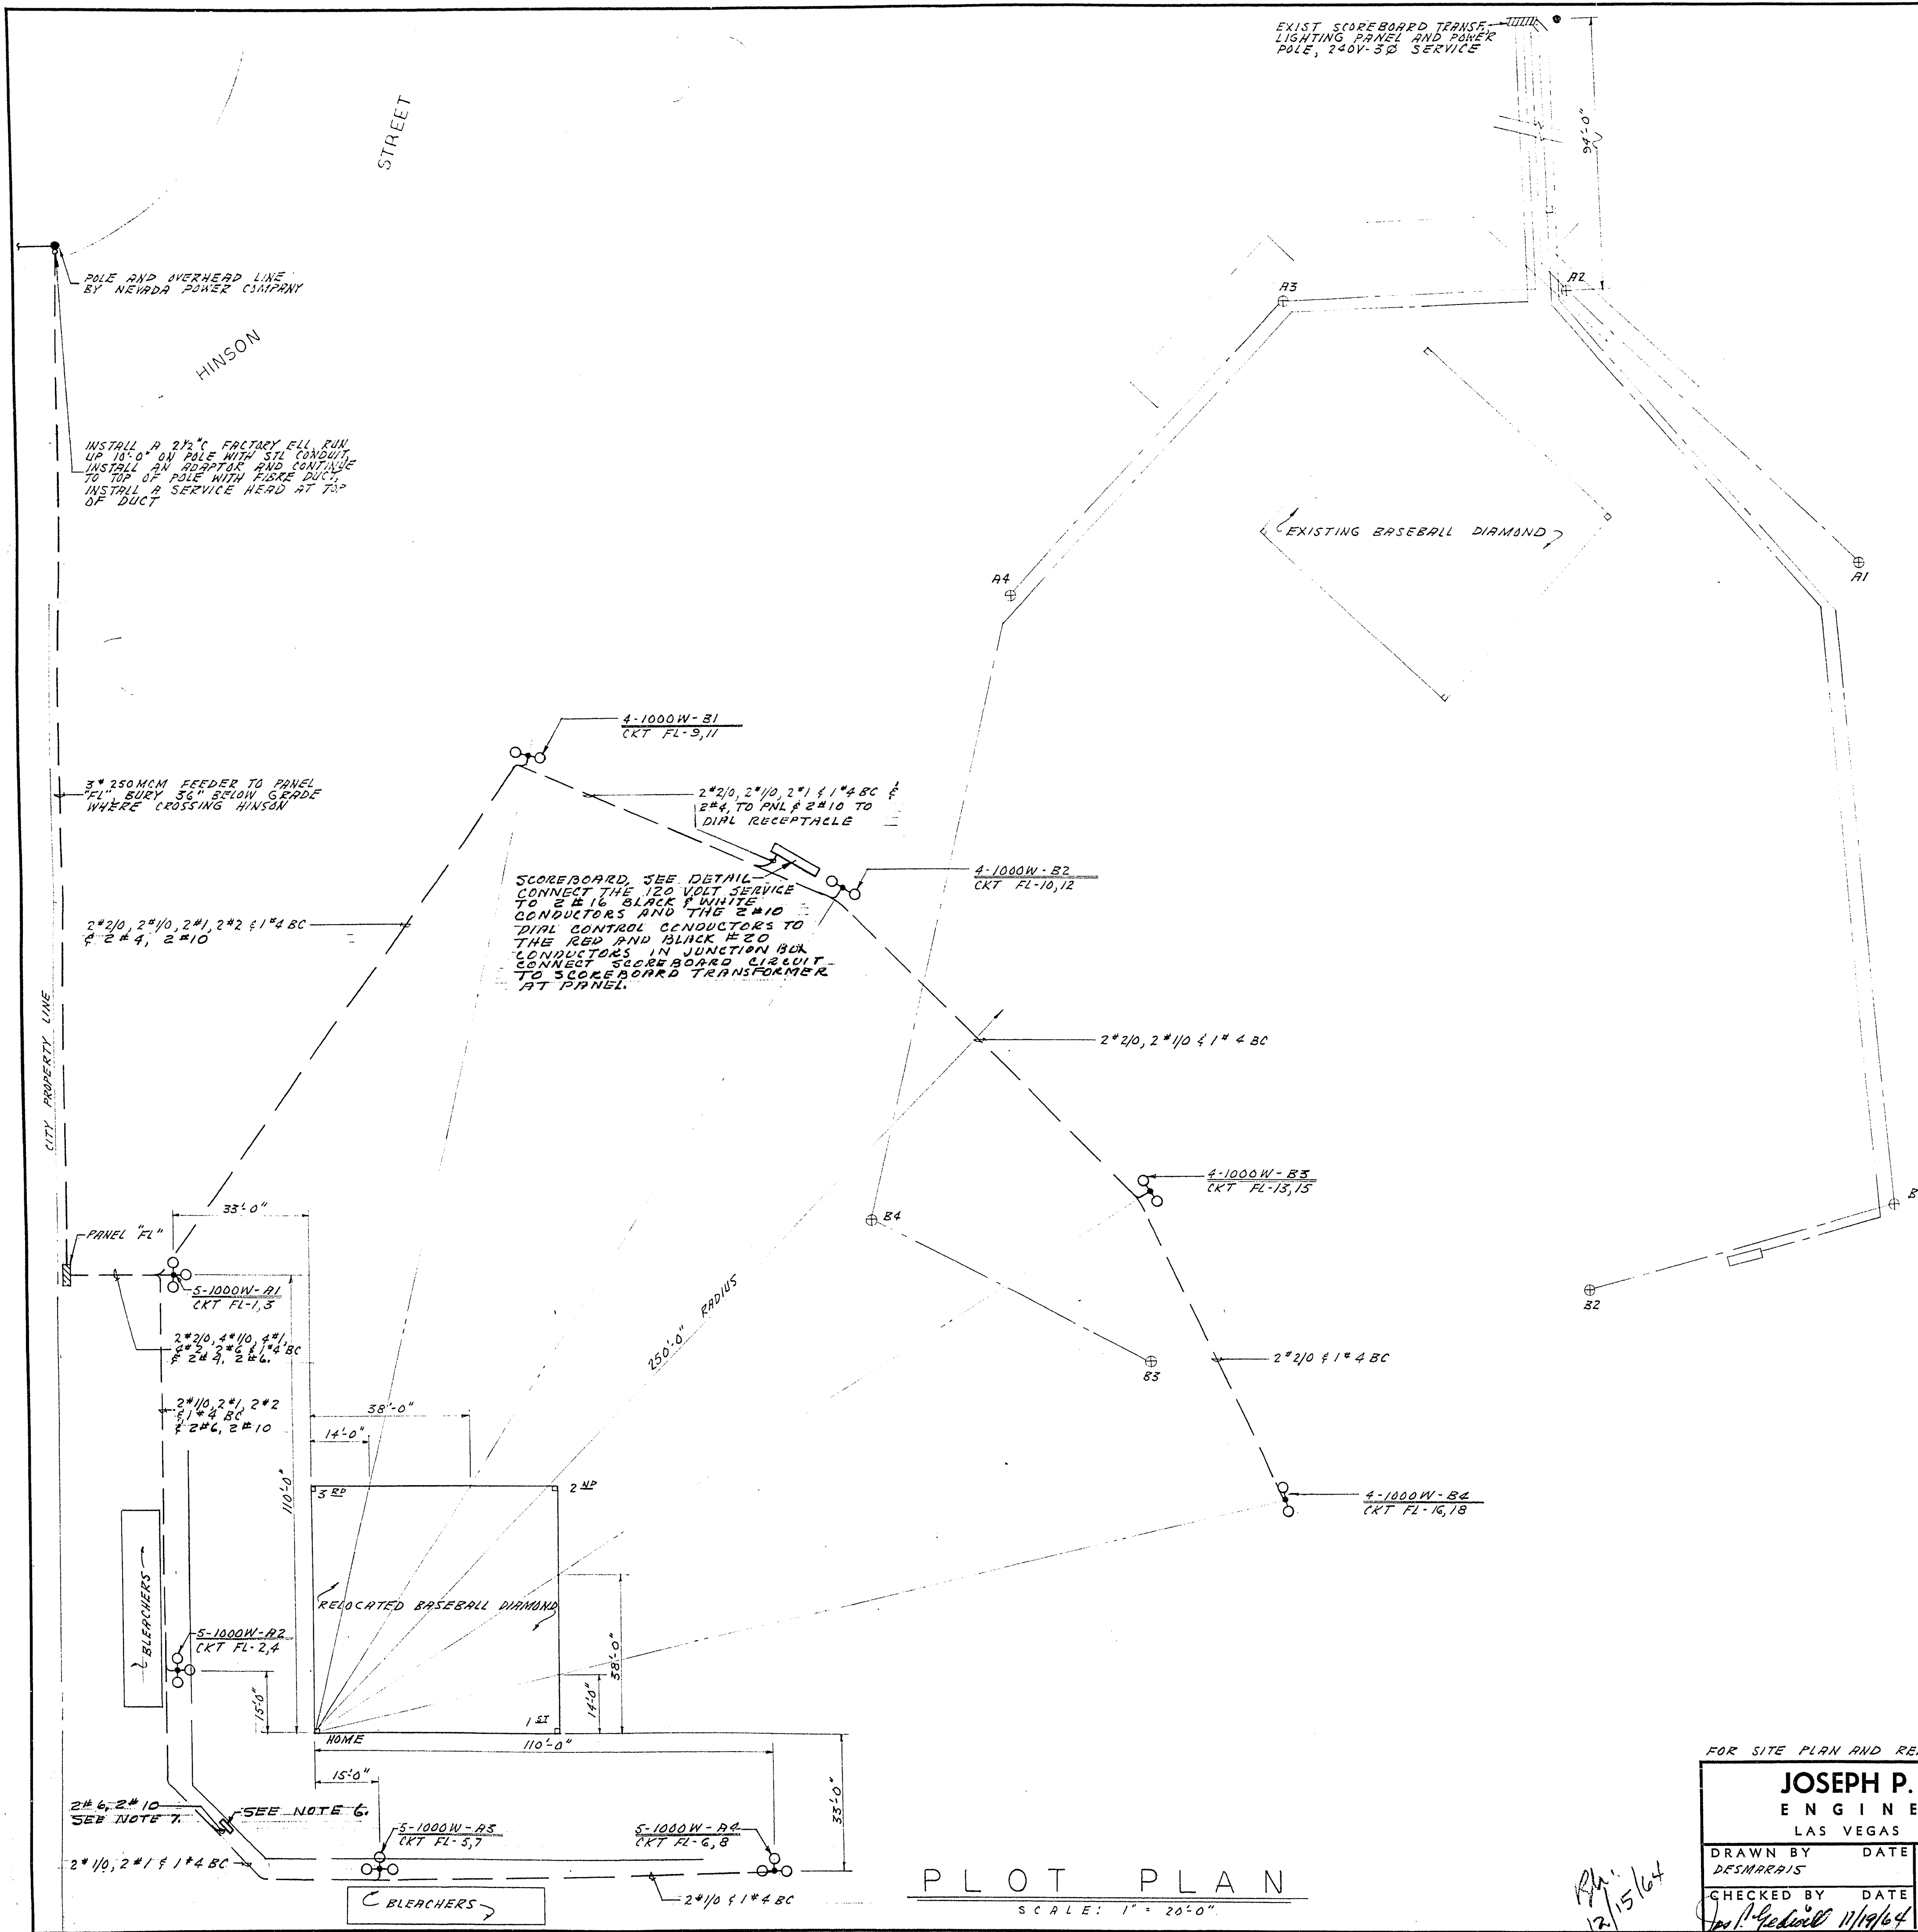

NOTES

- FOR DETAILS ON THIS DRAWING SEE DRAWING E-3
- CABLE SHOWN ON THIS DRAWING SHALL BE SINGLE CONDUCTOR DIRECT BURIAL TYPE RR AND SHALL BE INSTALLED A MINIMUM OF 24" BELOW GRADE
- ABOVE AND BELOW GRADE GROUND CONNECTIONS SHALL BE MADE WITH BURNDY CO., OR EQUAL, BOLTED CONNECTORS.
- EXISTING CONCRETE FOUNDATIONS SHALL BE REMOVED TO 18" BELOW GRADE, CONTRACTOR TO BACKFILL AND TAMP TO FIN. GRADE, TURF REPLACEMENT BY OTHERS.
- CONTRACTOR SHALL VISIT SITE PREVIOUS TO BID AND VERIFY CONDITIONS AND DETAILS SHOWN ON THESE DRAWINGS.
- RELOCATE 2 DUPLEX RECEPTACLES AND DIAL RECEPTACLE BOX (SCOREBOARD CONTROL) COMPLETE WITH WEATHER-TIGHT HOUSING TO LOCATION AS SHOWN. CONNECT BOTH RECEPTACLES TO SAME CIRCUIT.
- CARRY THE 2*10 BETWEEN DIAL RECEPTACLE AND THE SCORE BOARD JUNCTION BOX.

APPROVED: *L. L. Bennett* 12-11-64
CITY ELECTRICIAN DATE

APPROVED: *Ruth A. Macdonald* 12-23-64
SUPT. RECREATION DATE

FOR SITE PLAN AND REFERENCE DRAWING LIST SEE DRAWING E-1

JOSEPH P. GEDWILL ENGINEERING LAS VEGAS NEVADA		SEAL	FOR THE CITY OF LAS VEGAS NEVADA	CONTRACT No.
DRAWN BY DESIGNER	DATE	APPROVED FOR CITY OF LAS VEGAS	TITLE CRAGIN PARK SOFTBALL FIELD RELOCATION ELECTRICAL PLOT PLAN	E-2
CHECKED BY <i>J. P. Gedwill</i>	DATE 11/19/64	BY <i>R. A. Macdonald</i>	DATE 12-15-64	

650.4-26