


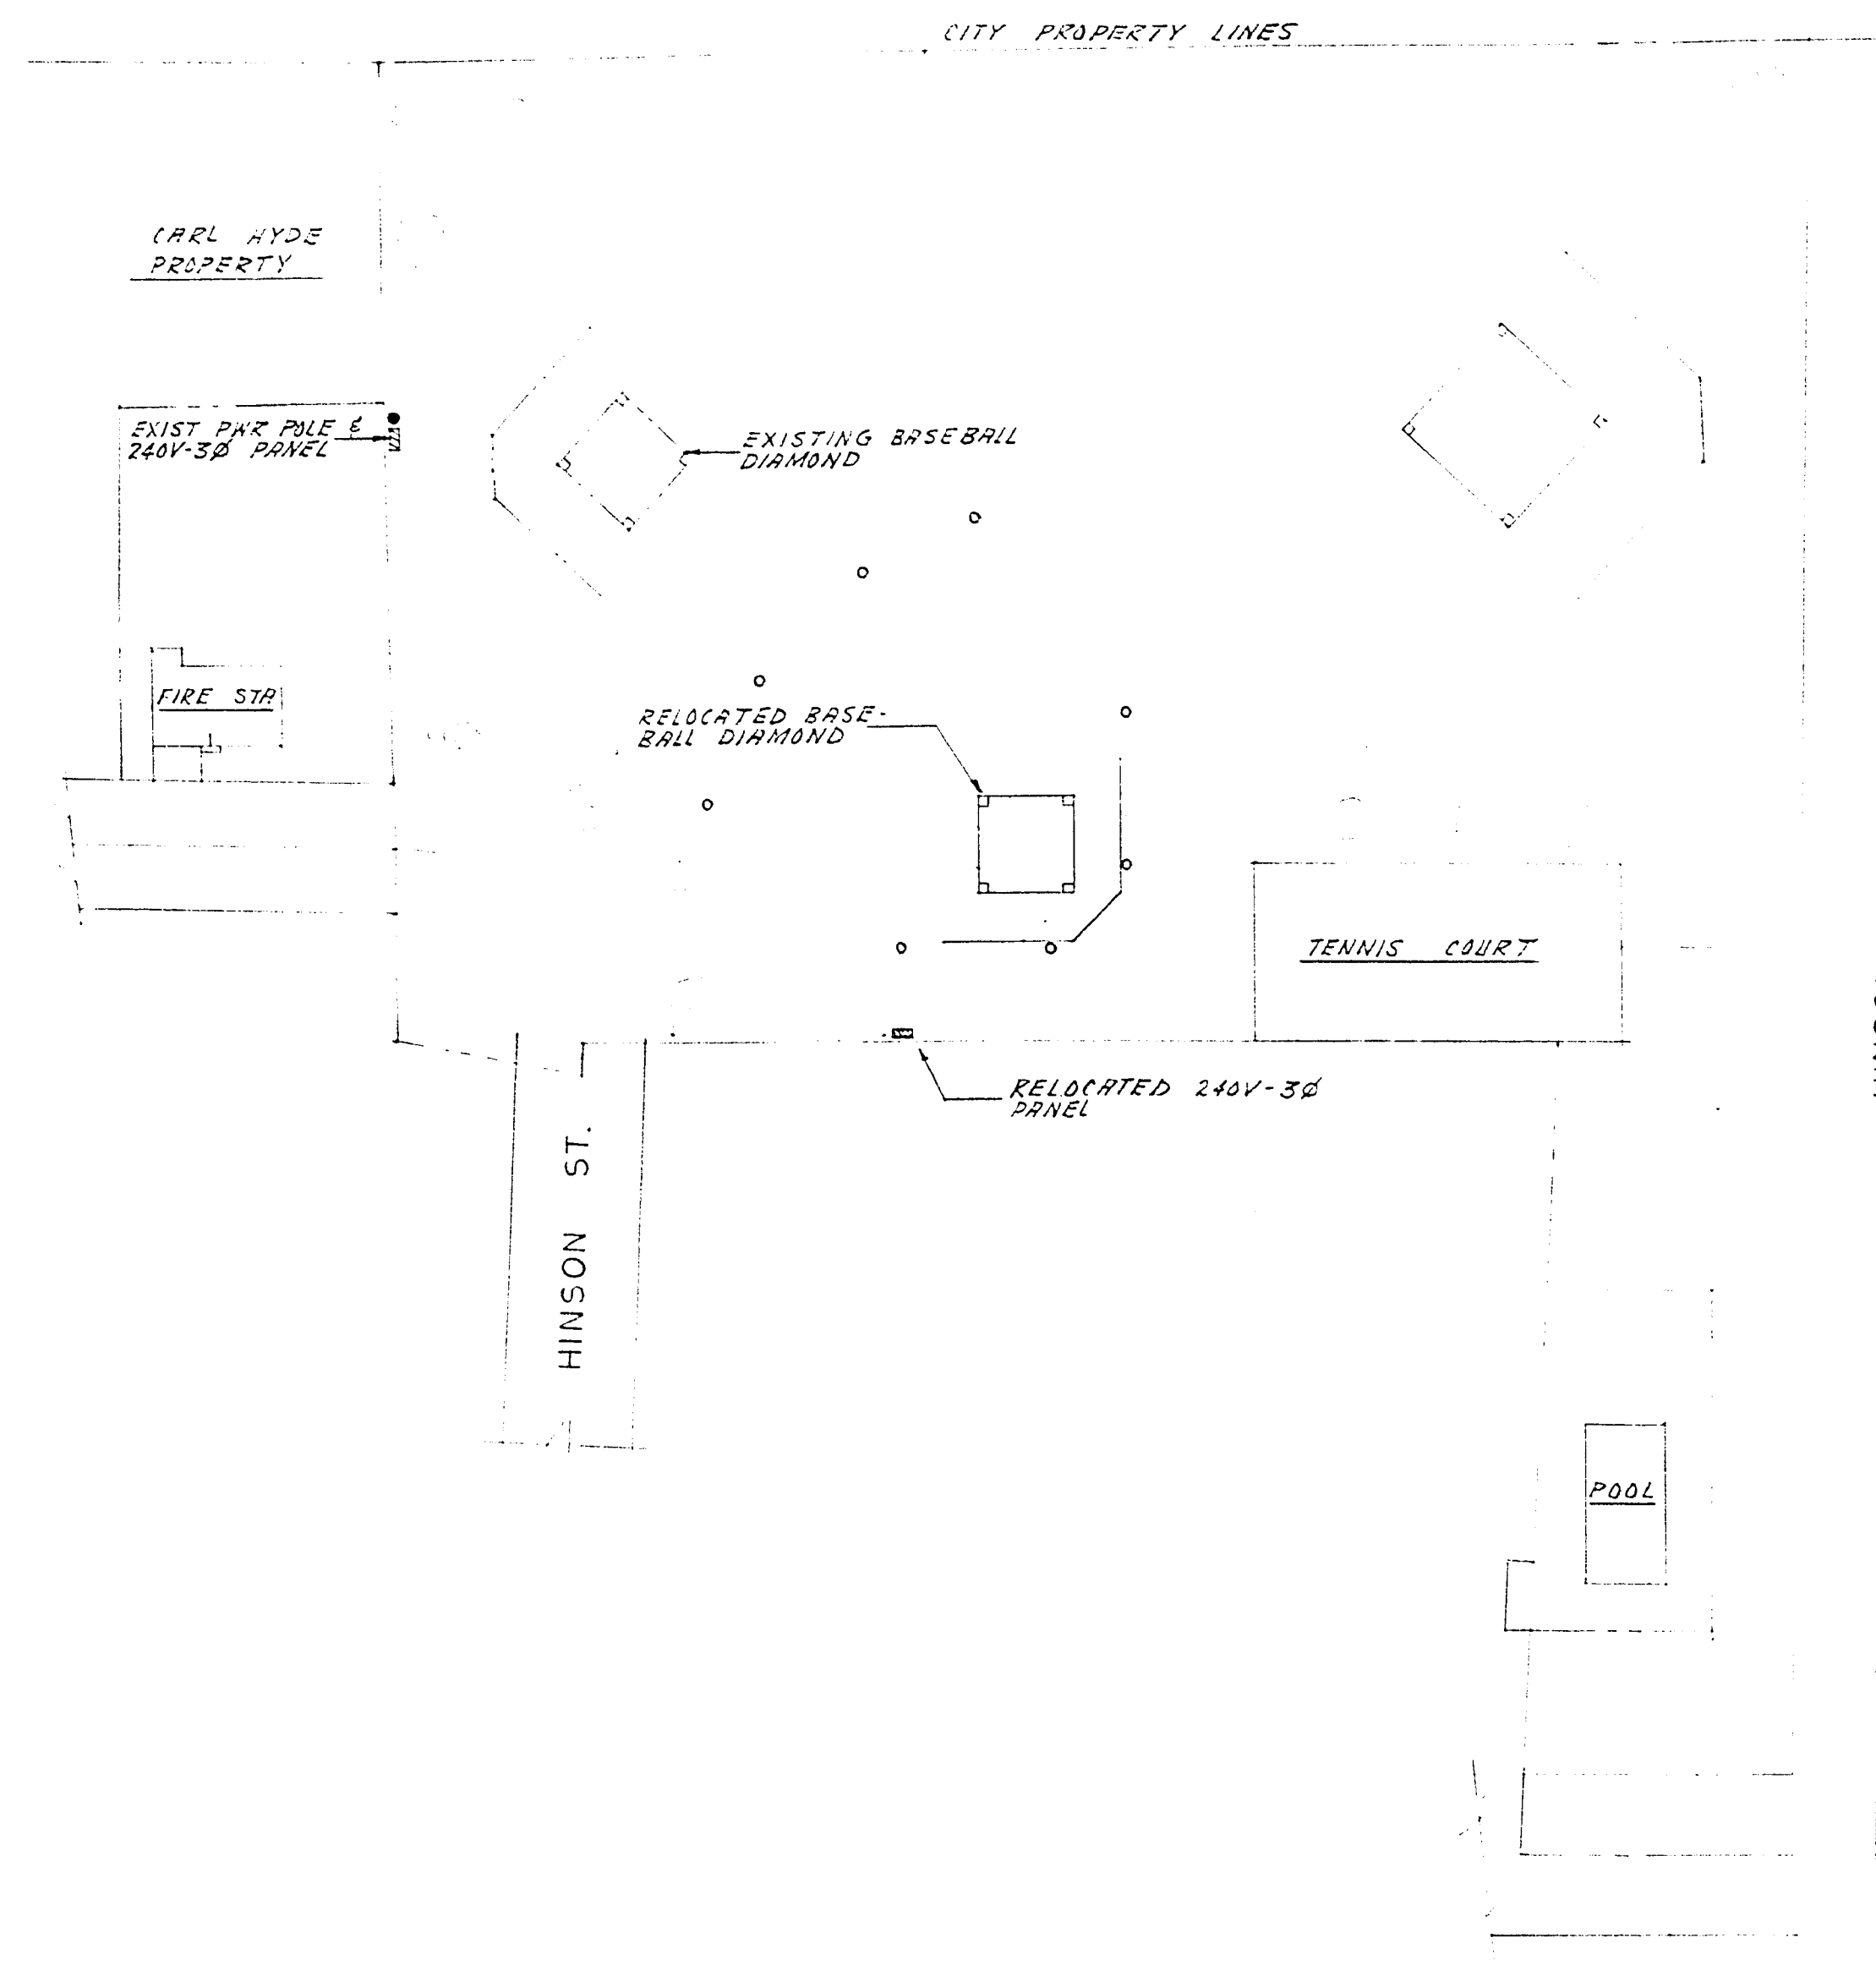

SITE PLAN
SCALE: 1" = 100'-0"

LEGEND

- ⊗ EXISTING FLOODLIGHT STANDARD, TO BE RELOCATED
- +○ RELOCATED FLOODLIGHT STANDARD WITH (4) LUMINAIRES
- +○+○ RELOCATED FLOODLIGHT STANDARD WITH (5) LUMINAIRES
- POWER POLE (BY NEVADA POWER COMPANY)
- ▭ MAIN SERVICE EQUIPMENT (EXISTING OR RELOCATED)
- CABLE OR CONDUIT INSTALLED BELOW GRADE (NEW)
- CABLE OR CONDUIT INSTALLED ABOVE GRADE (NEW)
- - - - - EXISTING CABLE OR CONDUIT INSTALLED BELOW GRADE

CITY OF LAS VEGAS NEVADA

RECREATION DEPARTMENT

CRAGIN PARK SOFTBALL FIELD RELOCATION

REFERENCE DRAWINGS

- E-2 _____ ELECTRICAL PLOT PLAN
- E-3 _____ ELECTRICAL DETAILS

JOSEPH P. GEDWILL ENGINEERING LAS VEGAS NEVADA		SEAL	FOR THE CITY OF LAS VEGAS NEVADA	CONTRACT No.
DRAWN BY DESIGNER/IS	DATE	APPROVED FOR CITY OF LAS VEGAS	TITLE CRAGIN PARK SOFTBALL FIELD RELOCATION TITLE SHEET AND SITE PLAN	E-1
CHECKED BY J.P. Gedwill	DATE 11/14/64	BY R.P. Haeck	DATE 2-15-65	

6-27

650-4-26