

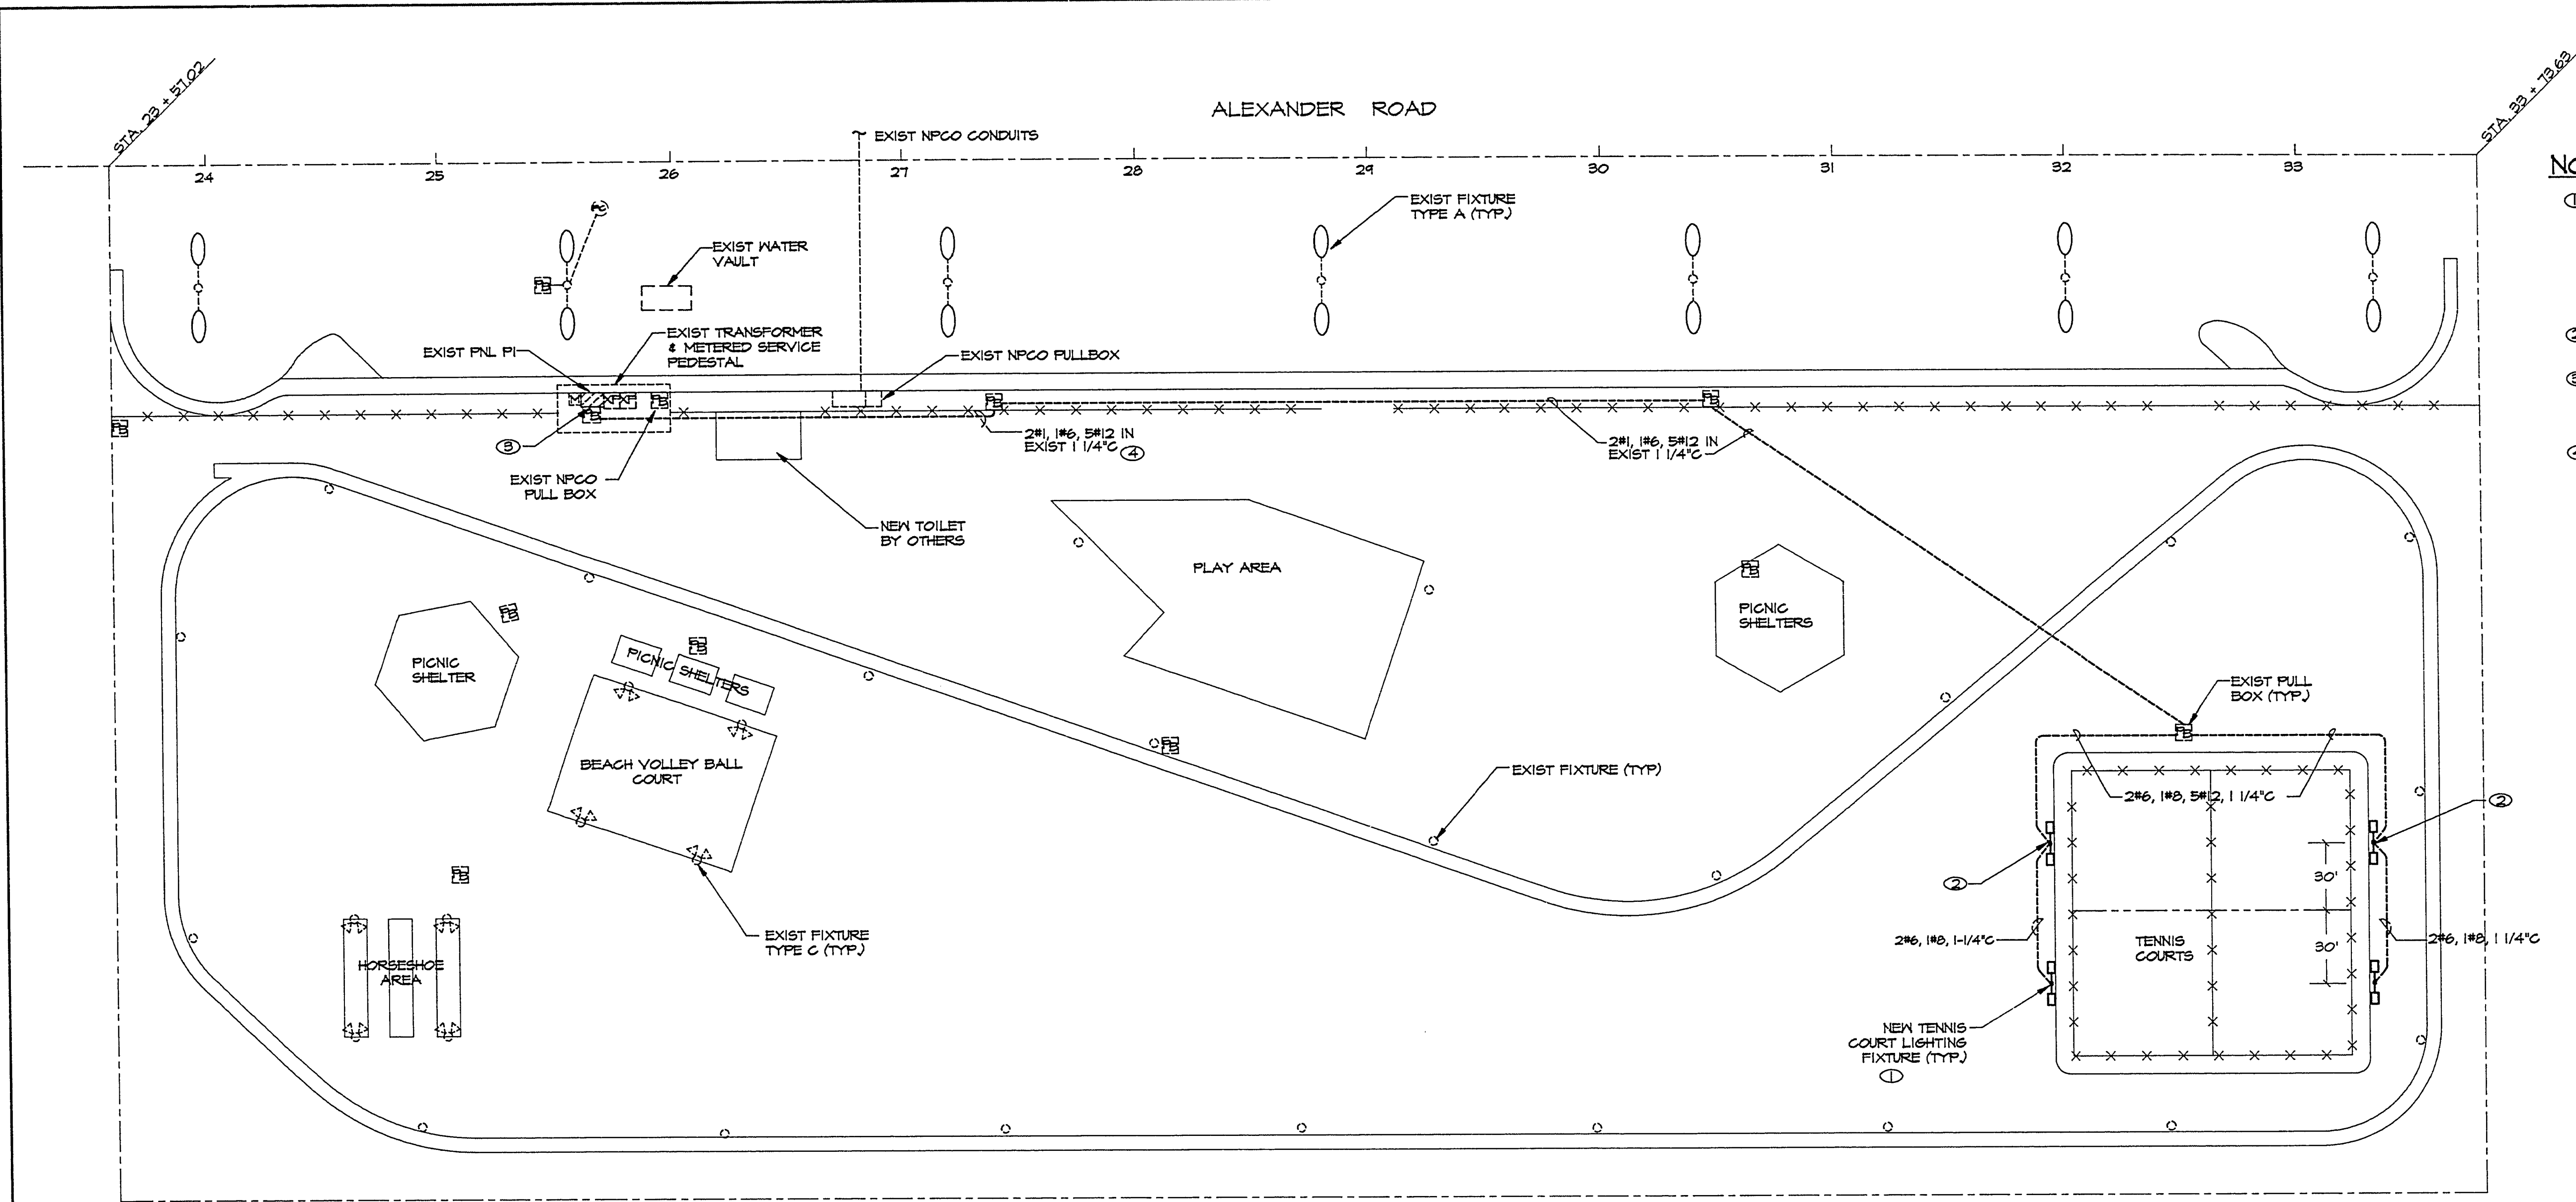
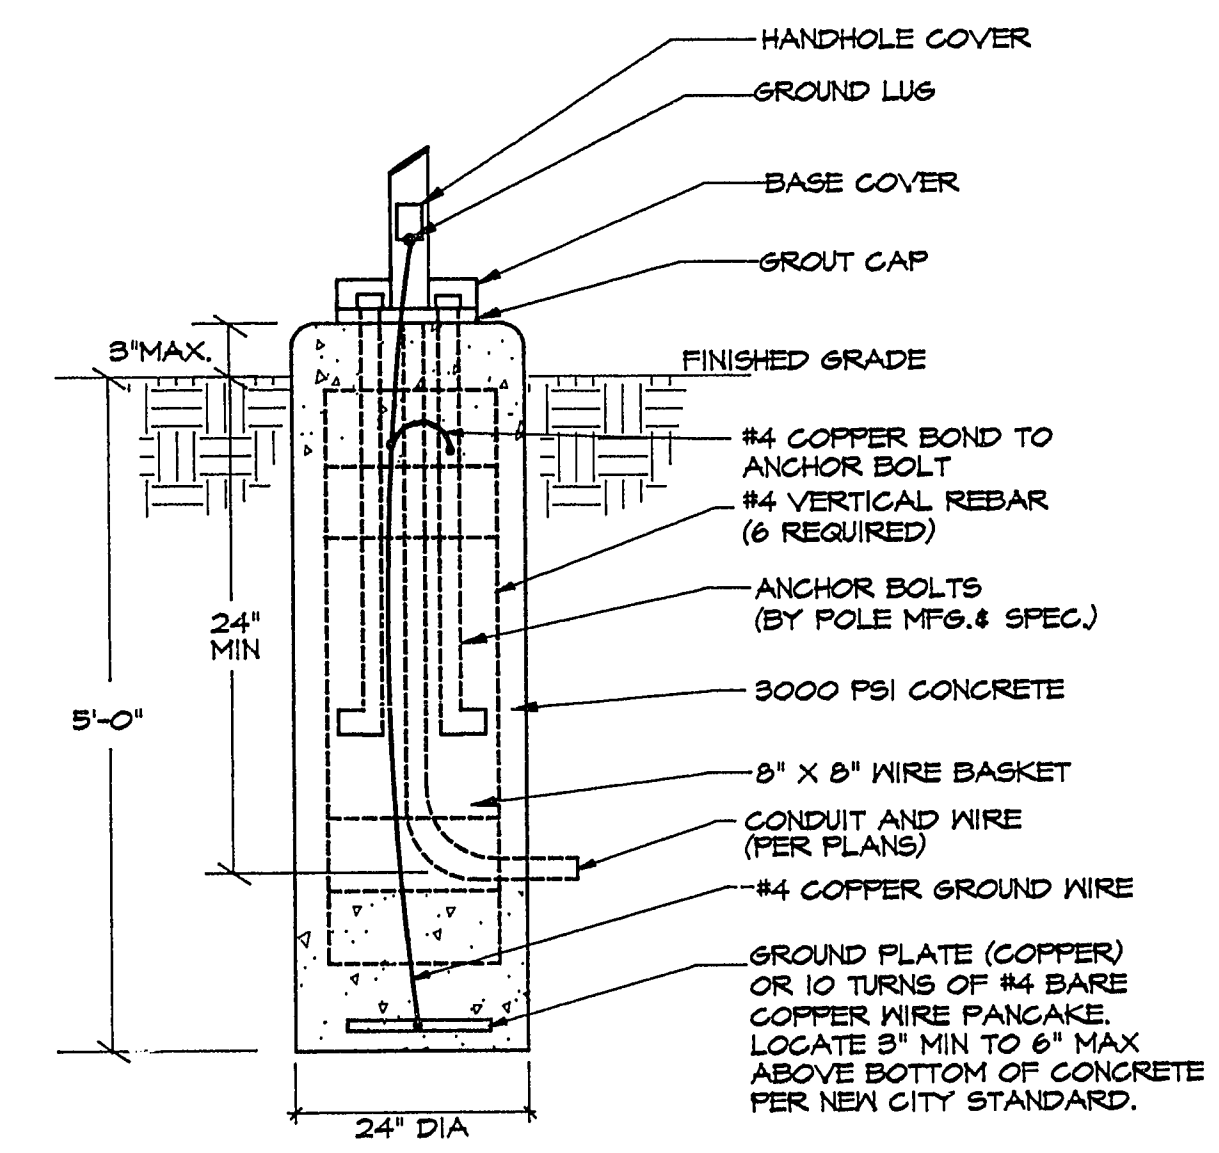


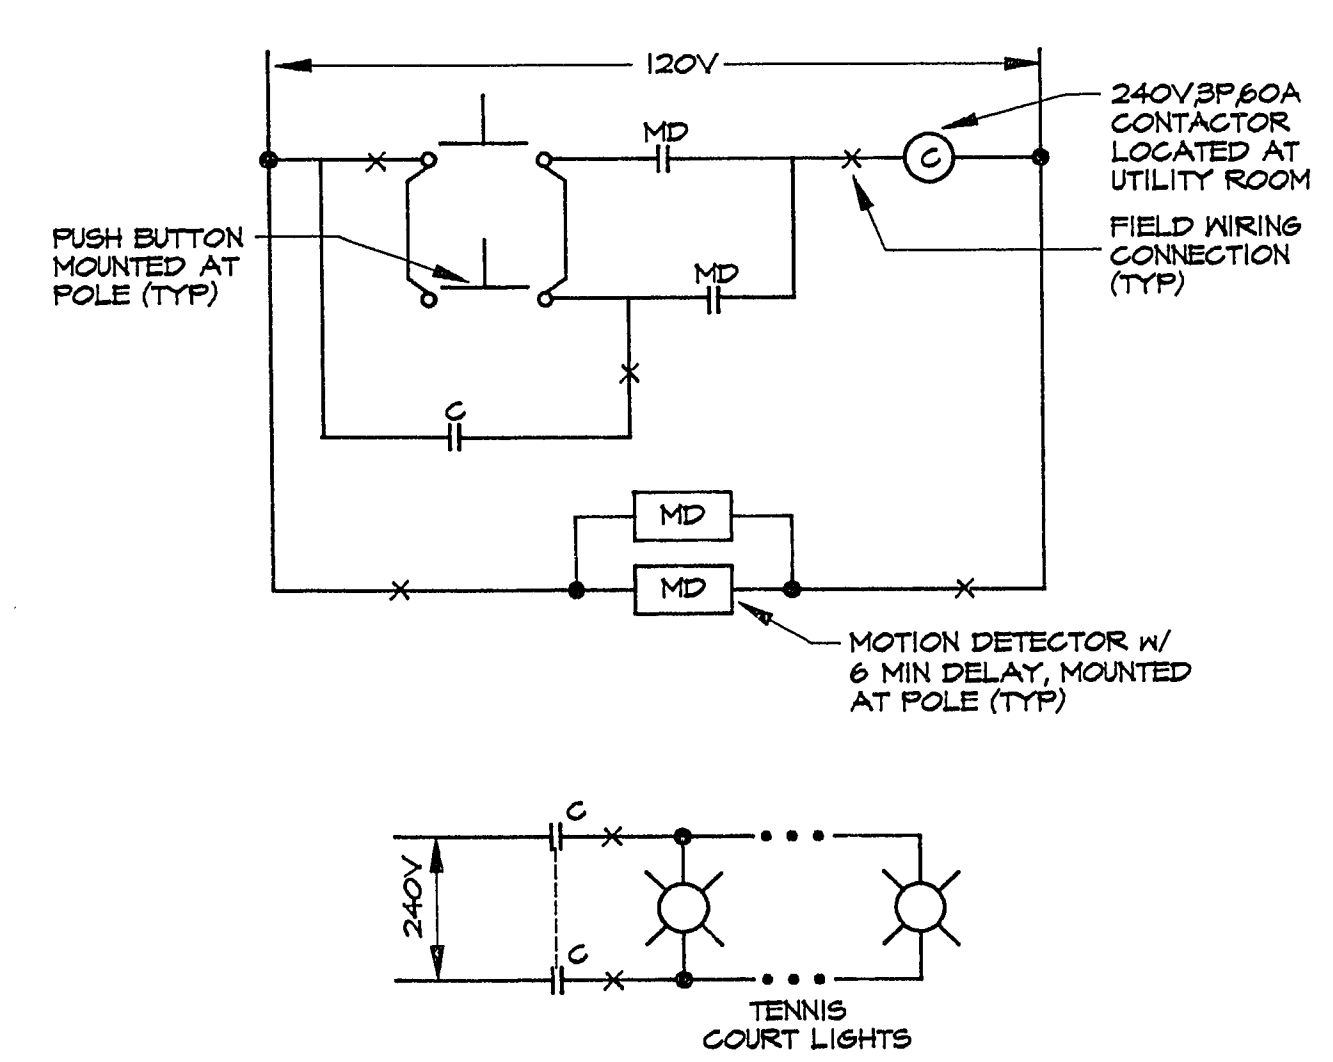

- NOTES:**
- ① INSTALL NEW TENNIS COURT LIGHTING FIXTURE. NEW LIGHTING FIXTURE SHALL BE EQUAL TO GARDCO H262FH-240-1000M-BRA-LF WITH MATCHING 35TAPERED ROUND STEEL POLE CATALOG NUMBER TR35SD2. MOUNT POLE OF PERIMETER CURB. SEE DETAIL ON THIS SHEET FOR POLE FOUNDATION INSTALLATION.
 - ② INSTALL LIGHT CONTROL STATION ON THIS POLE. SEE DETAIL THIS SHEET FOR WIRING & INSTALLATION.
 - ③ INSTALL A 240V 9P, 60A CONTACTOR IN NEMA 3R ENCLOSURE ABOVE EXISTING LTS CONTACTOR ON SWITCHBOARD FOR TENNIS COURT LTS CONTROL.
 - ④ TO P1-1, THRU CONTACTOR. SEE PANEL SCHEDULE & WIRING DIAGRAM THIS SHEET FOR DETAILS.

ELECTRICAL SITE PLAN
SCALE: 1"=40'-0"

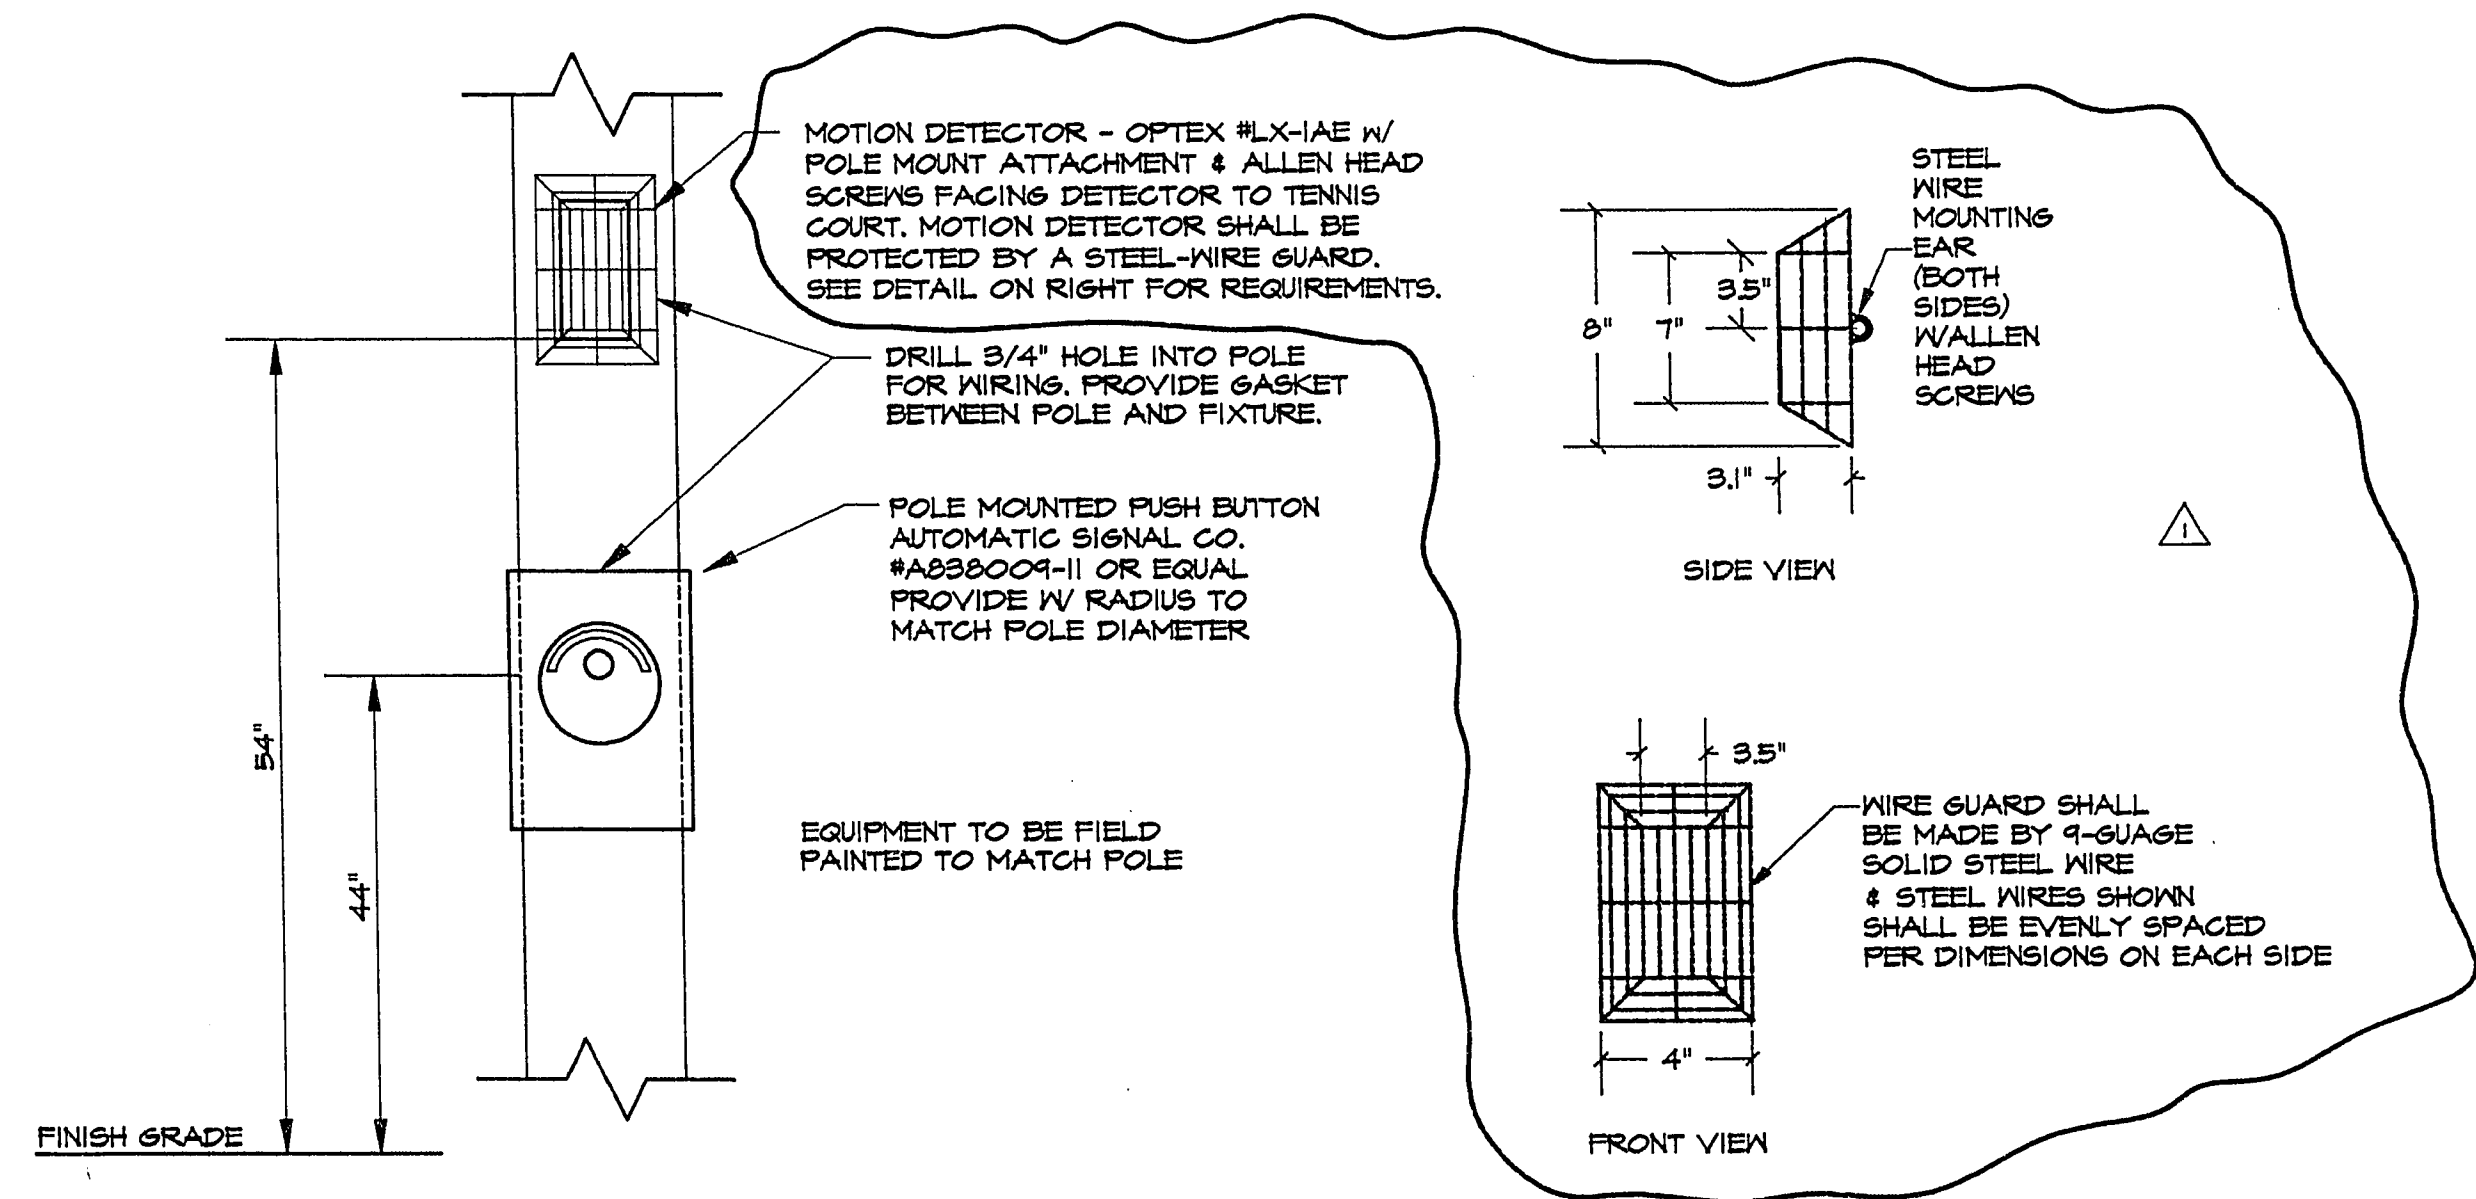

REV	DATE	DESCRIPTION
1	9/15/92	ADD MOTION DETECTOR WIRE GUARD DETAIL

TJ KROB CONSULTING ENGINEERS, INC. 1819 S. JONES BLVD., SUITE B LAS VEGAS, NEVADA 89102 (702) 871-3521	ELECTRICAL ENGINEERING
--	-------------------------------

SHEET TITLE: ELECTRICAL SITE PLAN	PROJECT: BUNKER PARK-TENNIS COURT LIGHTING
--	---

JOB NUMBER: 258
DATE: 7-30-92
DRAWN BY: JJ
CHECKED BY: TOM KROB
RECOMMENDED: by R. J. Goodman 9/15/92
DATE:
SHEET: E-1
2 OF: 3

FOR INFORMATION AND RECORD ONLY - SEE SET FOR ALL NOTES