
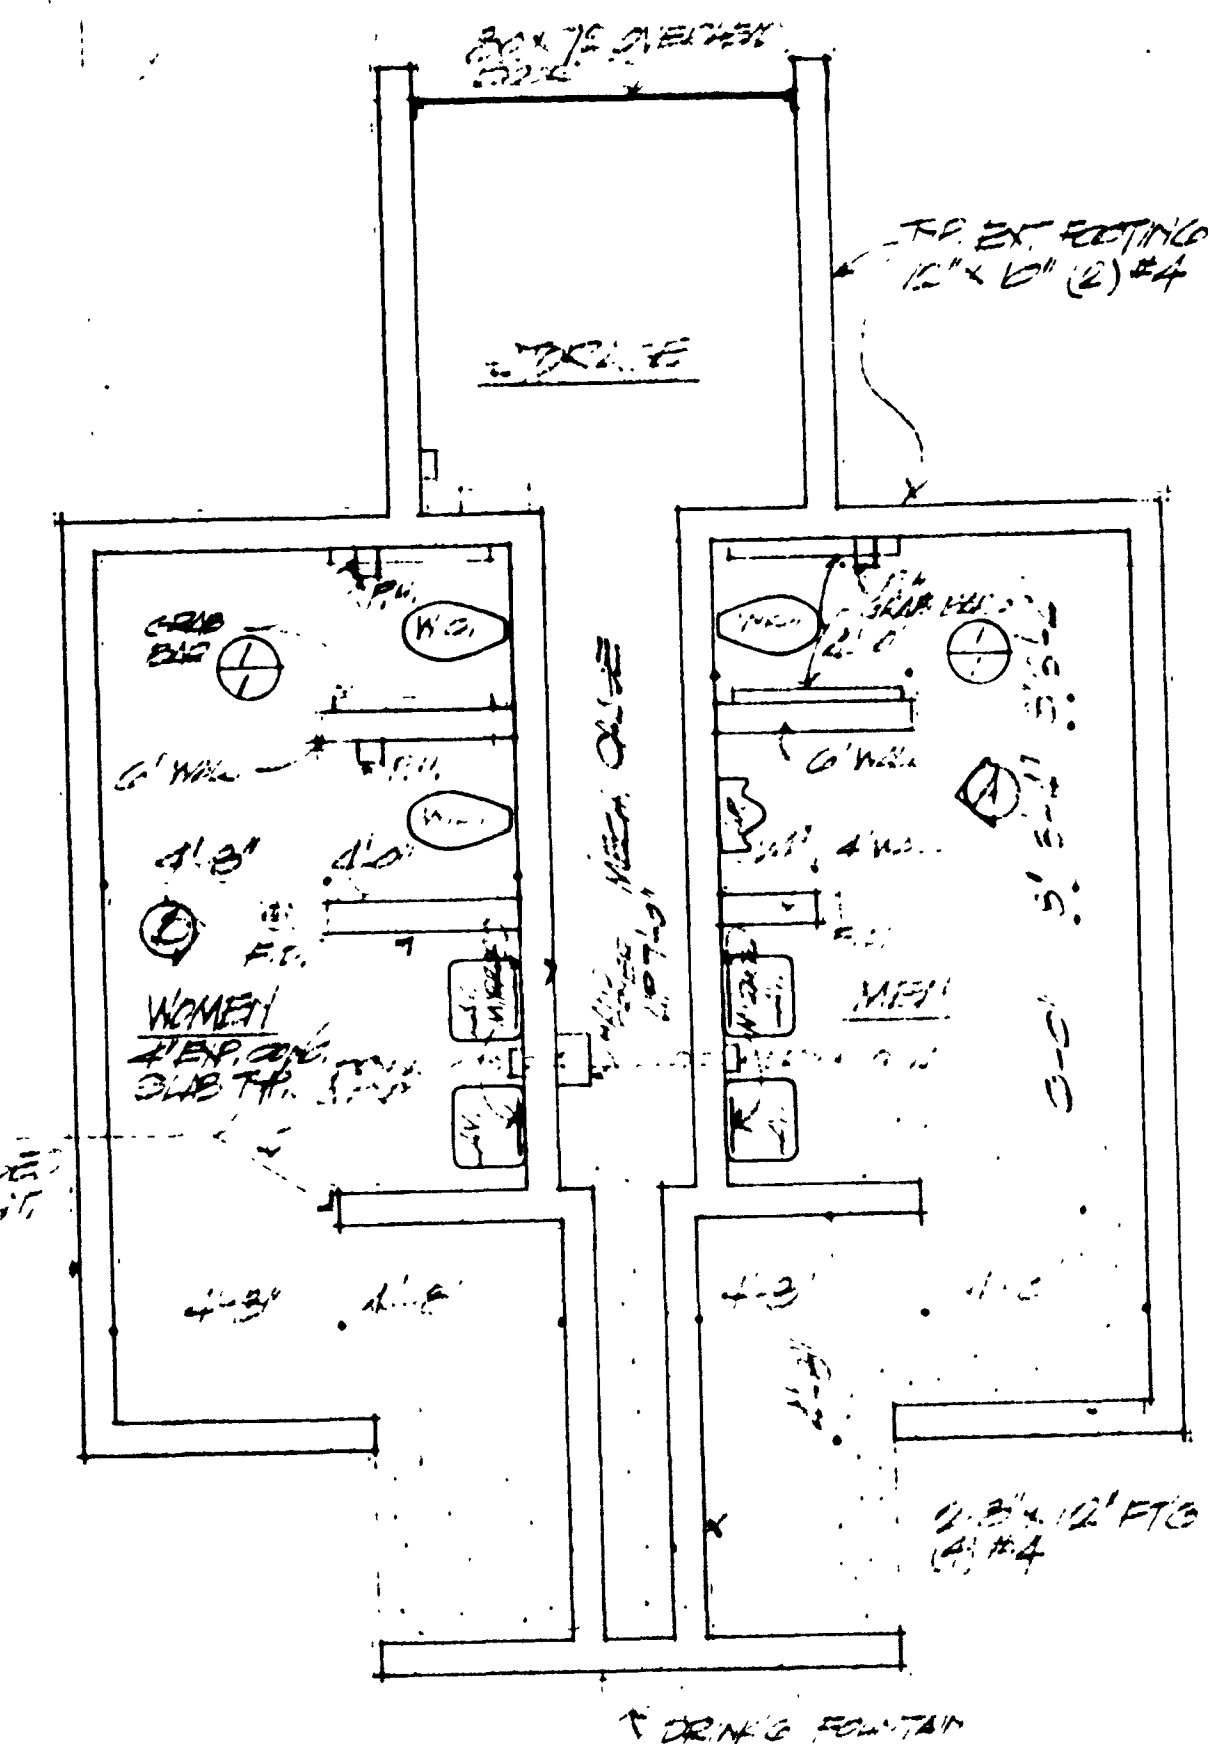
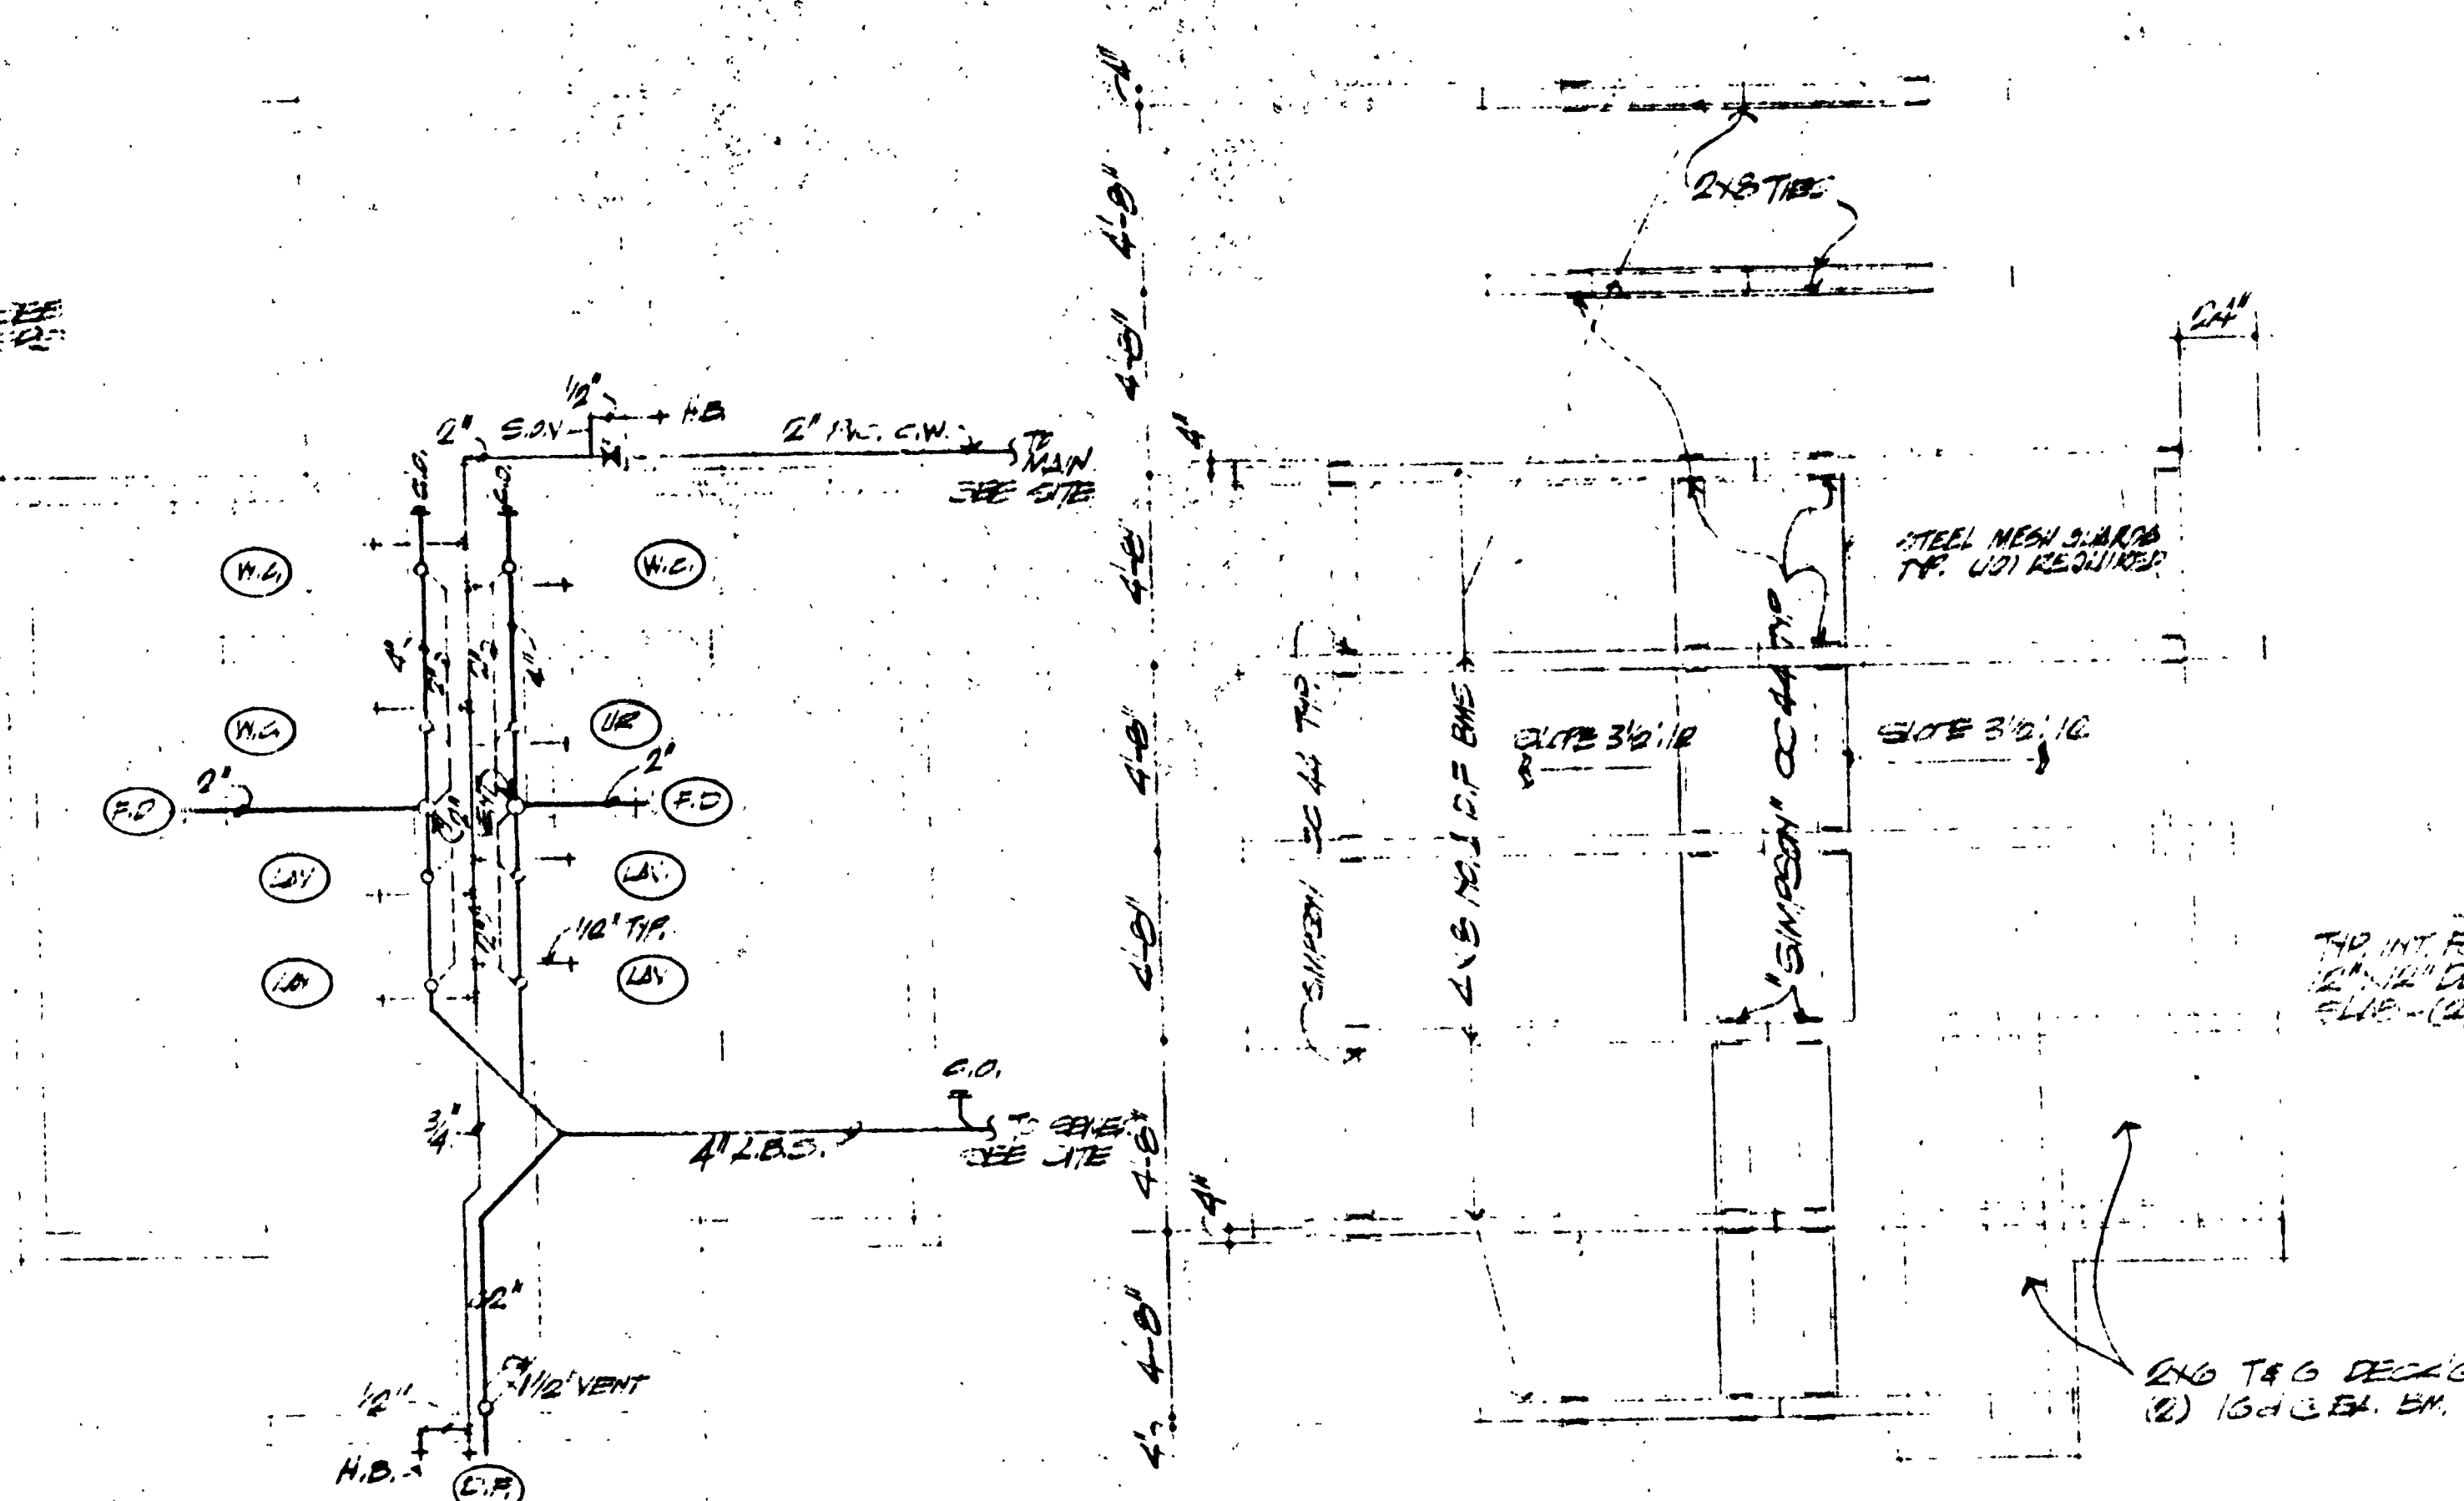


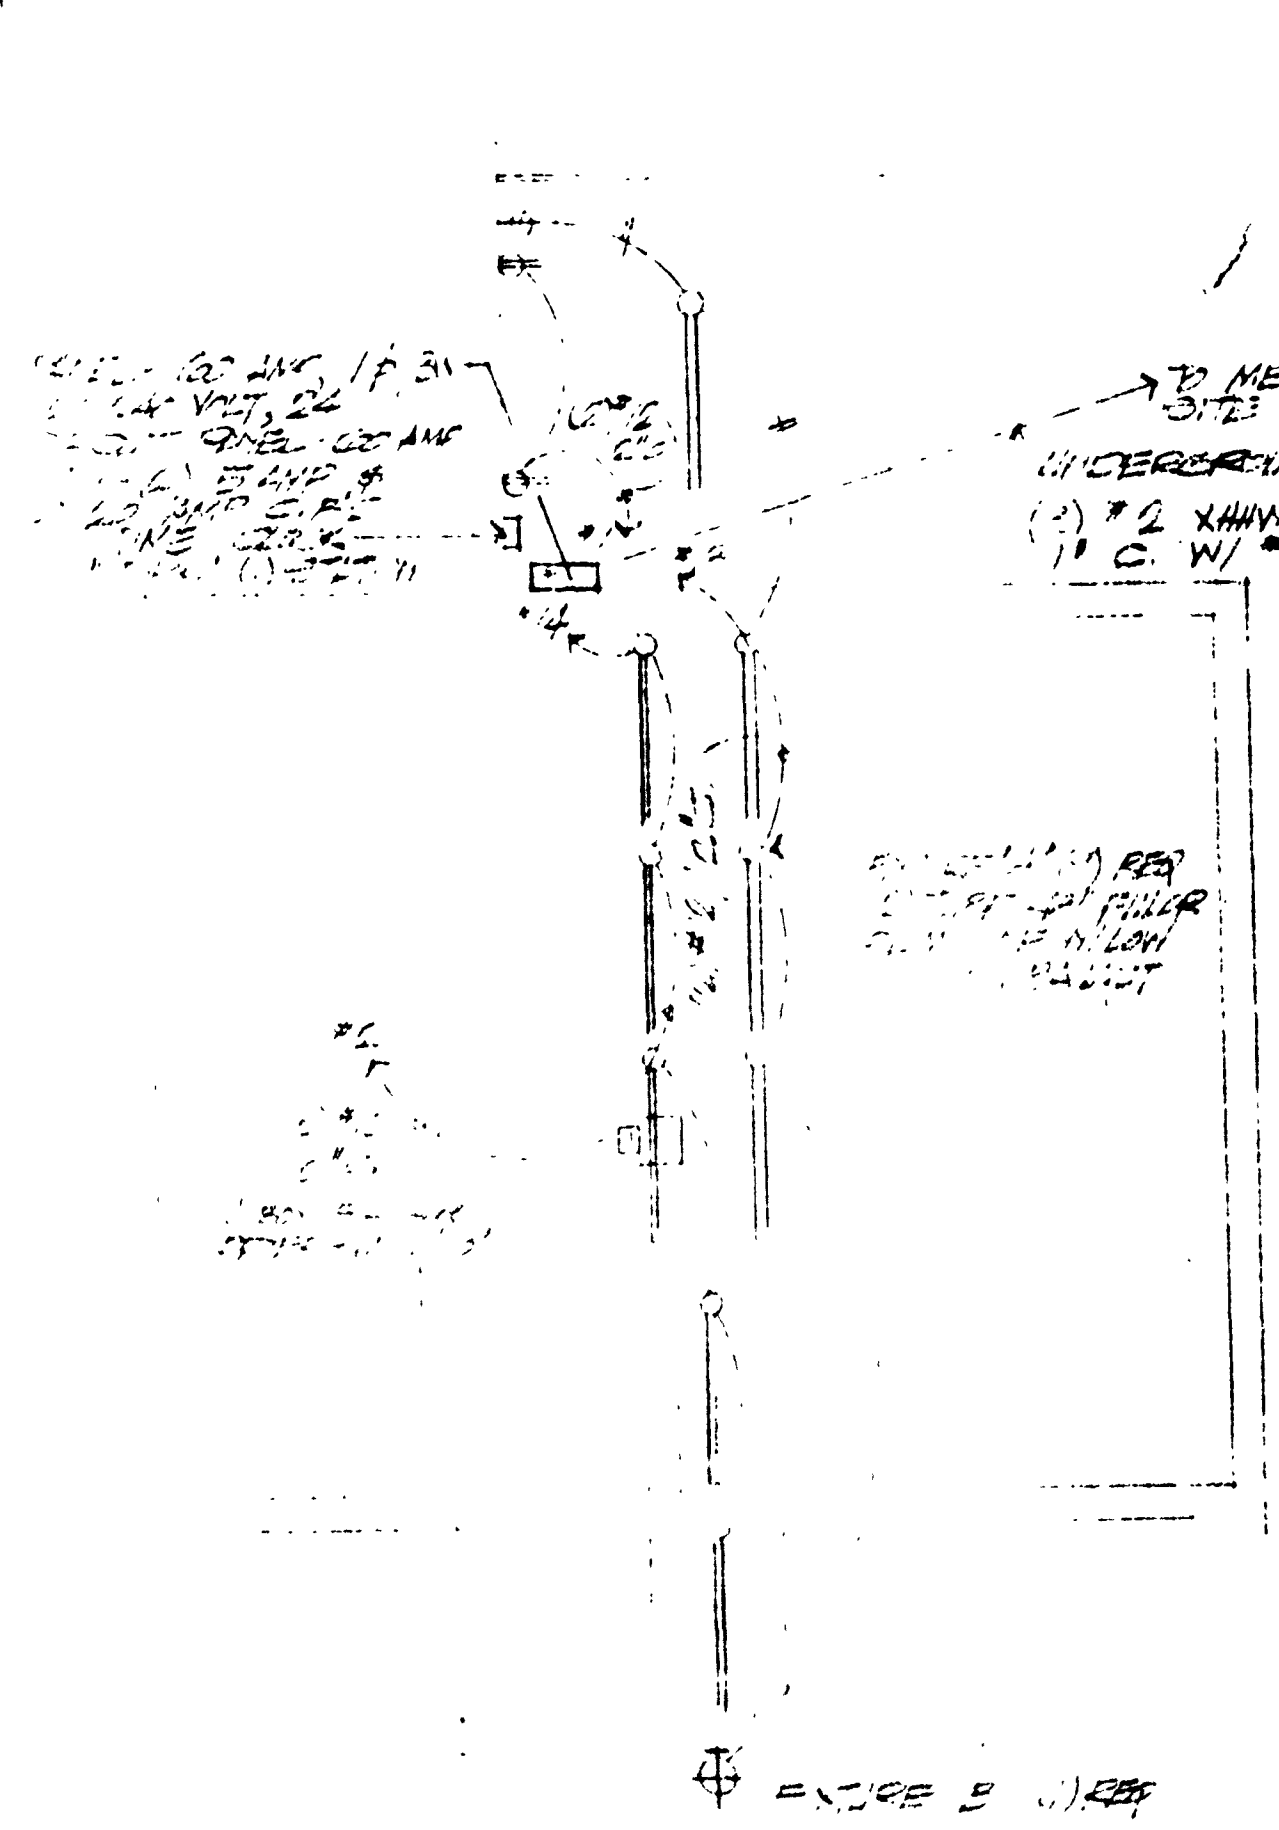

ELEC. NOTES

1. ALL WIRE TO BE 12 AWG.
2. PANEL SHALL BE 120V.
3. WIRE SHALL BE 12 AWG.
4. ALL WIRE TO BE 12 AWG.

ELEC. PLAN


FIGURE SCHEDULE

- W.C. SUPER SECURE CS 300 W/ PUSH BUTTON GLASS FLUSH VALVE
- U.R. SUPER SECURE CS 300 W/ PUSH BUTTON GLASS FLUSH VALVE
- LAV. SUPER SECURE CS 755 W/ COLD WATER PUSH BUTTON VALVE
- D.F. HANGS 1011 (BRONZE CS NO. 10 B) FLUSH W/ PUSH BUTTON VALVE - MT. CS 35" FROM MT.
- F.O. J.R. SMITH 4010-2-1" NICKEL BRASS 1/2" 5" ROUND VERTICAL PRIZE
- H.B. J.R. SMITH (RECESSED) * 5710 COMPLETE W/ BOX

NOTES:

1. ALL WATER & WASTE IN CHASE SHALL BE WALL MT.
2. WATER VALVES FOR W.C. & U.R. SHALL BE INSTALLED IN PIPE CHASE
3. WATER LINES TO BUILDING SHALL BE COPPER - 1" COLD & 1/2" HOT - 1" ABOVE GRADE
4. 1/2" P.C. PIPE FROM MAIN TO BUILDING


PLUMBING PLAN

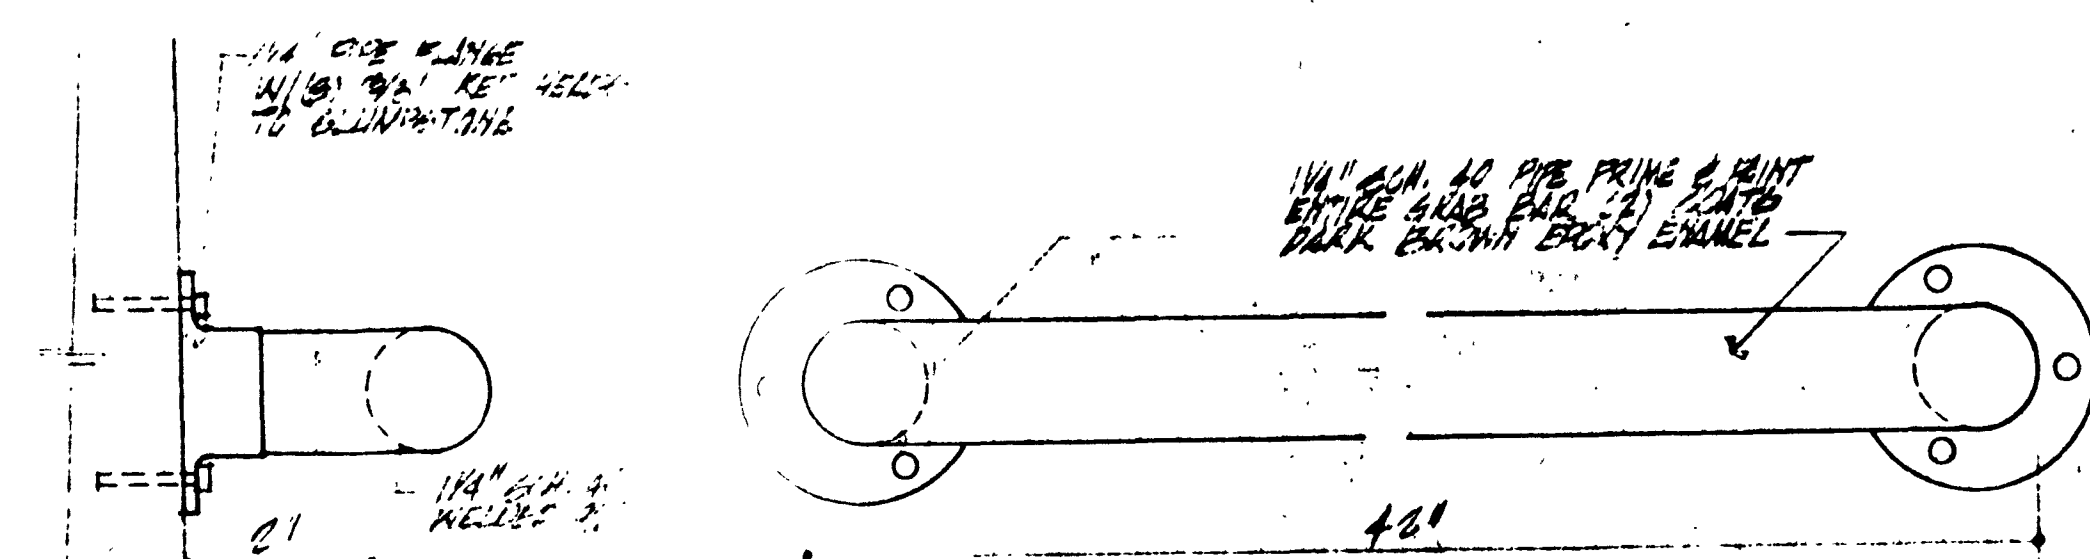

SIDE ELEV.

FRONT ELEV.

PIPE & BAR DETAIL (1)


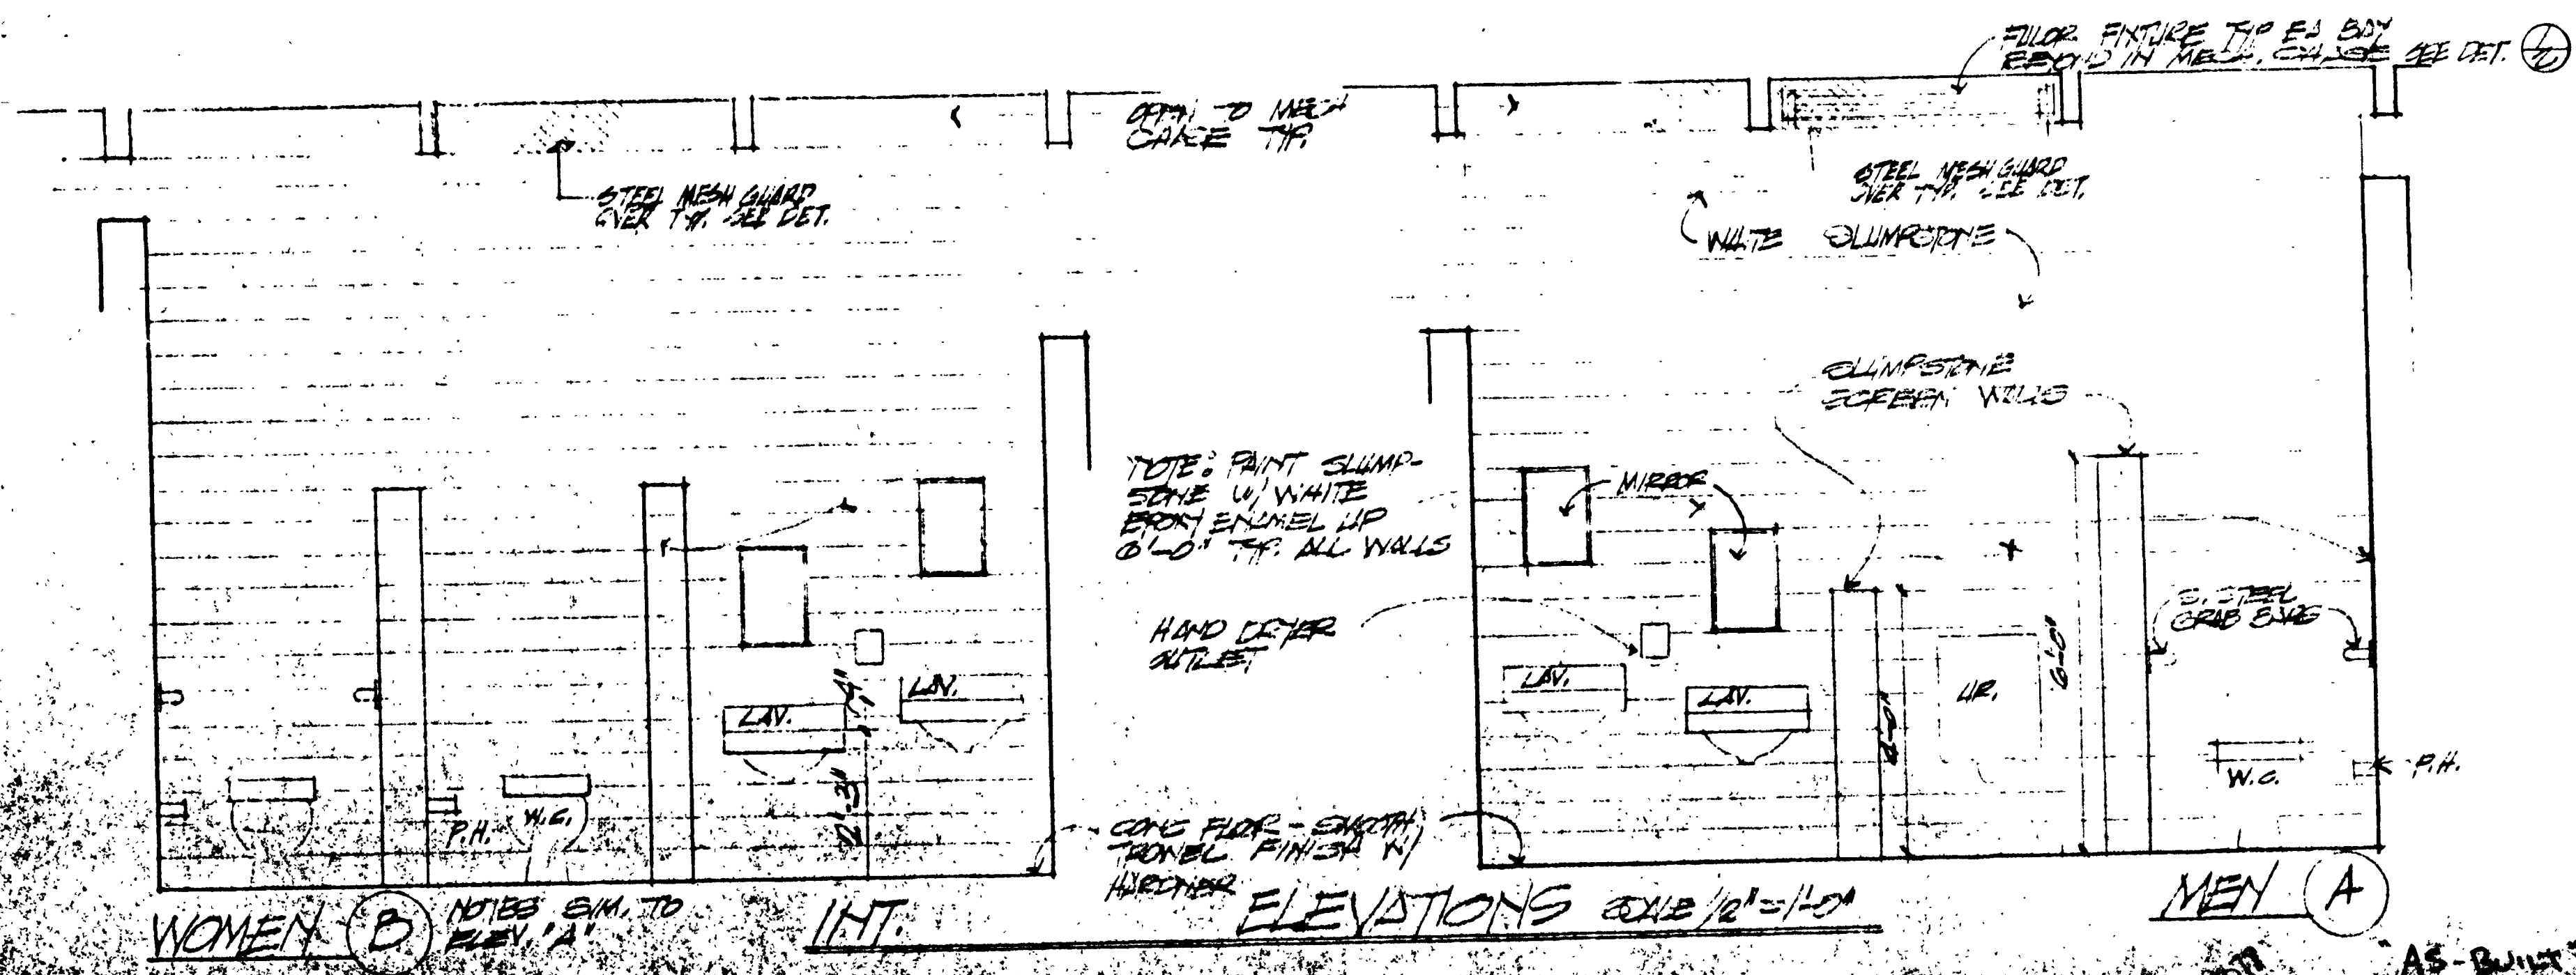


WOMEN (B) NOTES SAME TO ELEV. 'A'

INT.

ELEVATIONS SCALE 1/2" = 1'-0"

MEN (A)

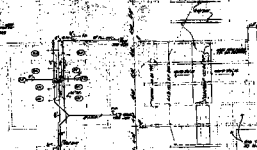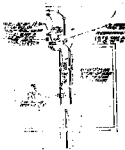

PLAN VIEW

1. L. L. LINE
2. L. L. LINE
3. L. L. LINE
4. L. L. LINE
5. L. L. LINE
6. L. L. LINE
7. L. L. LINE
8. L. L. LINE
9. L. L. LINE
10. L. L. LINE

PLAN VIEW

PLAN VIEW

1. L. L. LINE
2. L. L. LINE
3. L. L. LINE
4. L. L. LINE
5. L. L. LINE
6. L. L. LINE
7. L. L. LINE
8. L. L. LINE
9. L. L. LINE
10. L. L. LINE

PLAN VIEW

 
1. L. L. LINE
2. L. L. LINE
3. L. L. LINE
4. L. L. LINE
5. L. L. LINE
6. L. L. LINE
7. L. L. LINE
8. L. L. LINE
9. L. L. LINE
10. L. L. LINE

PLAN VIEW

PLAN VIEW

PLAN VIEW

1. L. L. LINE
2. L. L. LINE
3. L. L. LINE
4. L. L. LINE
5. L. L. LINE
6. L. L. LINE
7. L. L. LINE
8. L. L. LINE
9. L. L. LINE
10. L. L. LINE



SEE ALL PROJECTS FOR
ANALYSIS OF THE BUILDING

RECTOR ROOM FACILITY
FOR CHAIRMAN RECTOR ROOM
RECTOR ROOM FACILITY

SEE ALL PROJECTS FOR
ANALYSIS OF THE BUILDING