


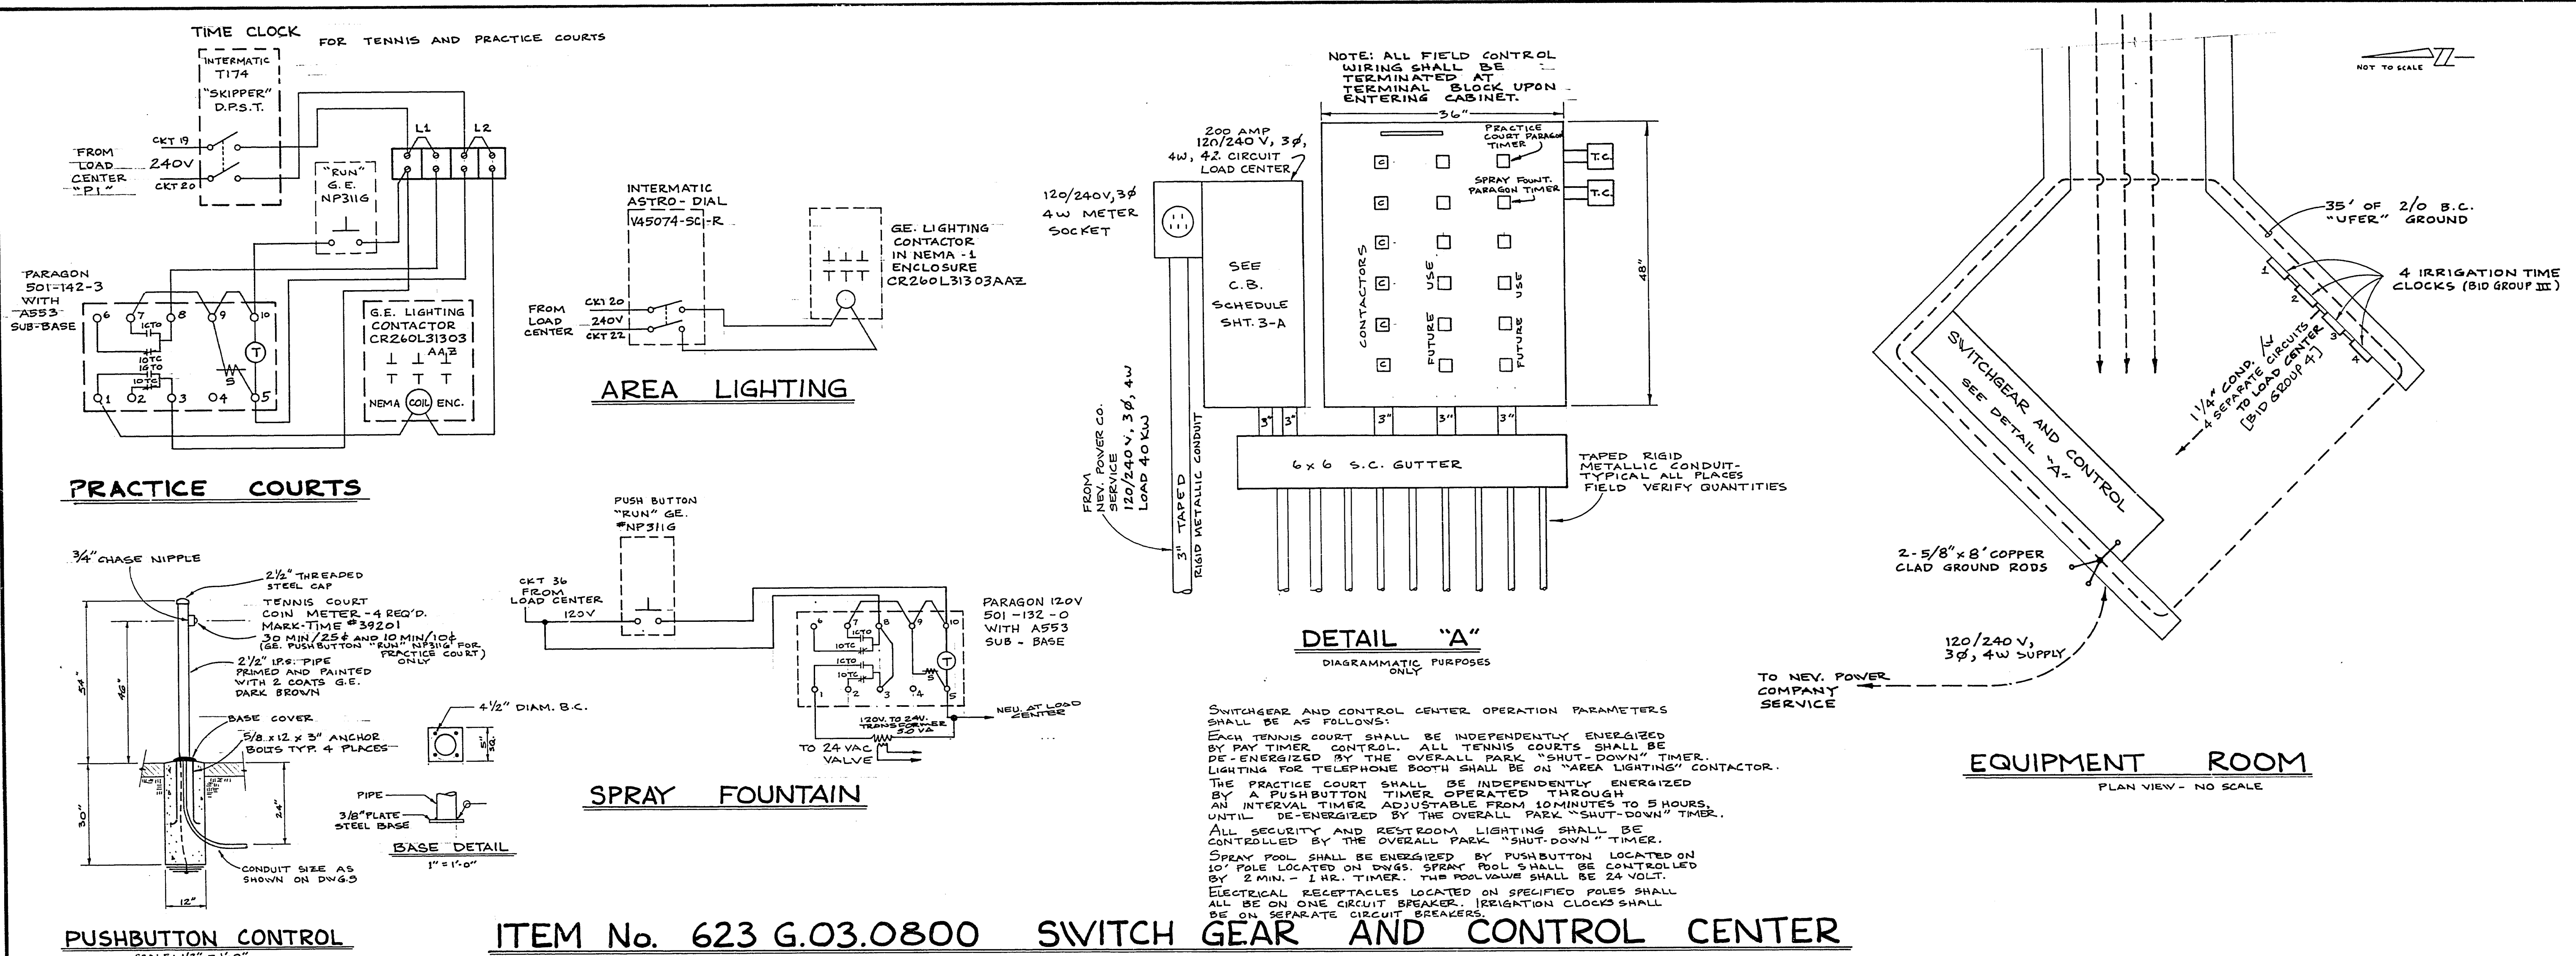

POLE & FOUNDATION DETAIL
NO SCALE

NOTE: SEE SITE PLAN FOR AREA LIGHT POLE AND SPRAY POOL SWITCH POLE.

POLE No.	POLE HT.	LUMINAIRES	FOUNDATION: WIDTH X DEPTH	EQUIPMENT
1	35'	250 W / 400 W / 1000 W	24 X 60	2-IN-A-ROW BRACKET WITH SIDE BRACKET FOR SEC. LGT.
2	35'	400 W / 1000 W	24 X 60	2-IN-A-ROW BRACKET, ELEC. FESTOON @ 8 FT.
3	35'	2-400 W / 2-1000 W	24 X 72	4-IN-A-ROW BRACKET
4	35'	2-400 W / 2-1000 W	24 X 72	4-IN-A-ROW BRACKET
5	35'	400 W / 1000 W	24 X 60	2-IN-A-ROW BRACKET
6	35'	400 W / 1000 W	24 X 60	2-IN-A-ROW BRACKET
7	35'	400 W / 1000 W	24 X 60	2-IN-A-ROW BRACKET
8	35'	400 W / 1000 W	24 X 60	2-IN-A-ROW BRACKET
9	35'	2-400 W / 2-1000 W	24 X 72	4-IN-A-ROW BRACKET
10	35'	2-400 W / 2-1000 W	24 X 72	4-IN-A-ROW BRACKET
11	35'	400 W / 1000 W	24 X 60	2-IN-A-ROW BRACKET
12	35'	250 W / 400 W / 1000 W	24 X 60	2-IN-A-ROW BRACKET WITH SIDE BRACKET FOR SEC. LGT.
13	14'	150 W	24 X 48	POST-TOP MOUNTING
14	35'	1000 W	24 X 60	KNUCKLE-TYPE SLIPFITTER
15	35'	1000 W	24 X 60	KNUCKLE-TYPE SLIPFITTER
16	35'	1000 W	24 X 60	KNUCKLE-TYPE SLIPFITTER
17	35'	250 W / 1000 W	24 X 60	KNUCKLE-TYPE SLIPFITTER, SIDE BRACKET, FESTOON @ 8 FT.

TRENCH AND BACKFILL
NO SCALE

FOUNDATION DETAIL
NO SCALE

W.O. no. 3477

Scale (v)

Scale (h)

File. bk. no. 79-3X

Design by S. MORSE

Approved by the Director of Public Services

Date JAN. 1979

Drawn by

Date

Revisions

Date

Department of Public Services

Engineering Design Division

ELECTRICAL

DETAILS

BOB BASKIN

PARK

Drawing no. 650.27-1

E/3