


8410

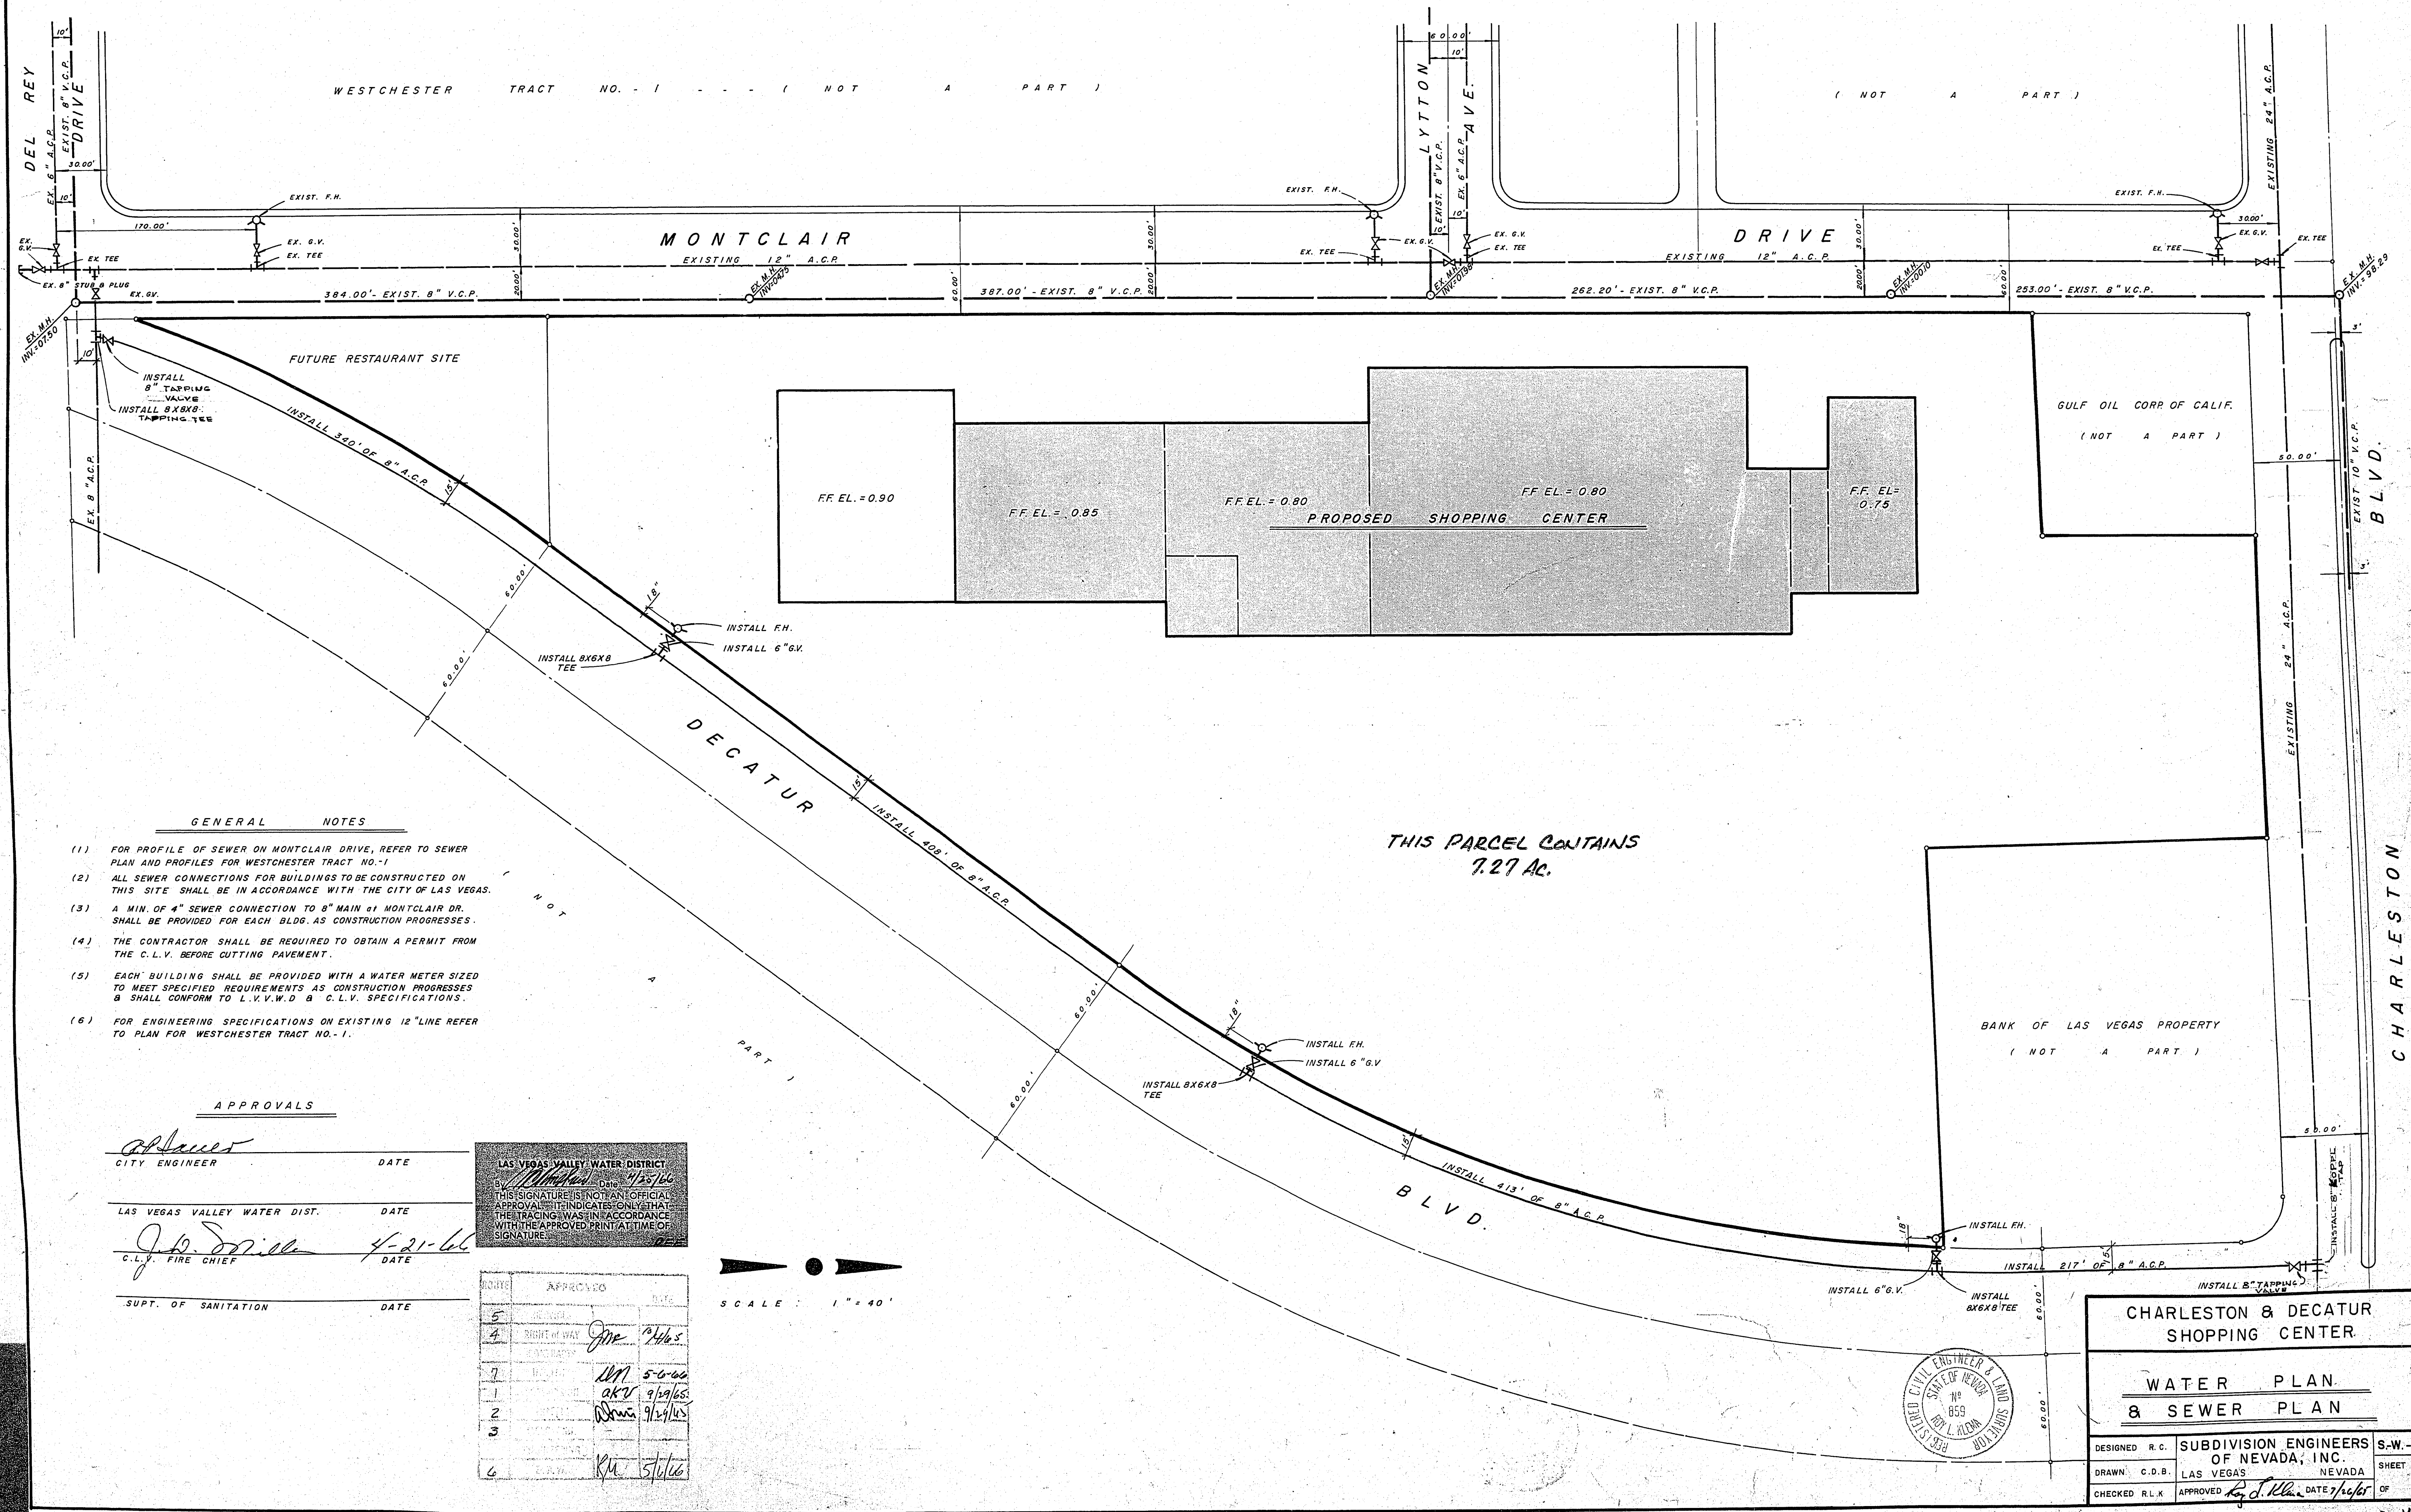

GENERAL NOTES

- (1) FOR PROFILE OF SEWER ON MONTCLAIR DRIVE, REFER TO SEWER PLAN AND PROFILES FOR WESTCHESTER TRACT NO. 1.
- (2) ALL SEWER CONNECTIONS FOR BUILDINGS TO BE CONSTRUCTED ON THIS SITE SHALL BE IN ACCORDANCE WITH THE CITY OF LAS VEGAS.
- (3) A MIN. OF 4" SEWER CONNECTION TO 8" MAIN AT MONTCLAIR DR. SHALL BE PROVIDED FOR EACH BLDG. AS CONSTRUCTION PROGRESSES.
- (4) THE CONTRACTOR SHALL BE REQUIRED TO OBTAIN A PERMIT FROM THE C.L.V. BEFORE CUTTING PAVEMENT.
- (5) EACH BUILDING SHALL BE PROVIDED WITH A WATER METER SIZED TO MEET SPECIFIED REQUIREMENTS AS CONSTRUCTION PROGRESSES & SHALL CONFORM TO L.V.V.W.D. & C.L.V. SPECIFICATIONS.
- (6) FOR ENGINEERING SPECIFICATIONS ON EXISTING 12" LINE REFER TO PLAN FOR WESTCHESTER TRACT NO. 1.

APPROVALS

[Signature]
CITY ENGINEER
DATE

LAS VEGAS VALLEY WATER DIST.
DATE


[Signature]
C.L.V. FIRE CHIEF
DATE

S.U.P.T. OF SANITATION
DATE

LAS VEGAS VALLEY WATER DISTRICT
APPROVED
DATE 4/25/66
THIS SIGNATURE IS NOT AN OFFICIAL APPROVAL. IT INDICATES ONLY THAT THE TRACING WAS IN ACCORDANCE WITH THE APPROVED PRINT AT TIME OF SIGNATURE.

NO.	APPROVED	DATE
5		
4	RIGHT OF WAY	4/25/66
7		
1		5-6-66
2		9/29/66
3		9/29/66
6		5/1/66

SCALE : 1" = 40'

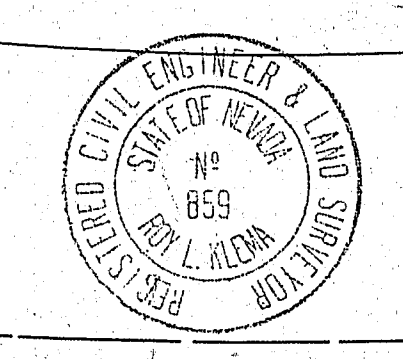

CHARLESTON & DECATUR SHOPPING CENTER

WATER PLAN
& SEWER PLAN

DESIGNED R.C.	SUBDIVISION ENGINEERS OF NEVADA, INC.	S.W. - 1
DRAWN C.D.B.	LAS VEGAS	NEVADA
CHECKED R.L.K.	APPROVED <i>[Signature]</i>	DATE 7/1/66

SHEET 7 OF 8