



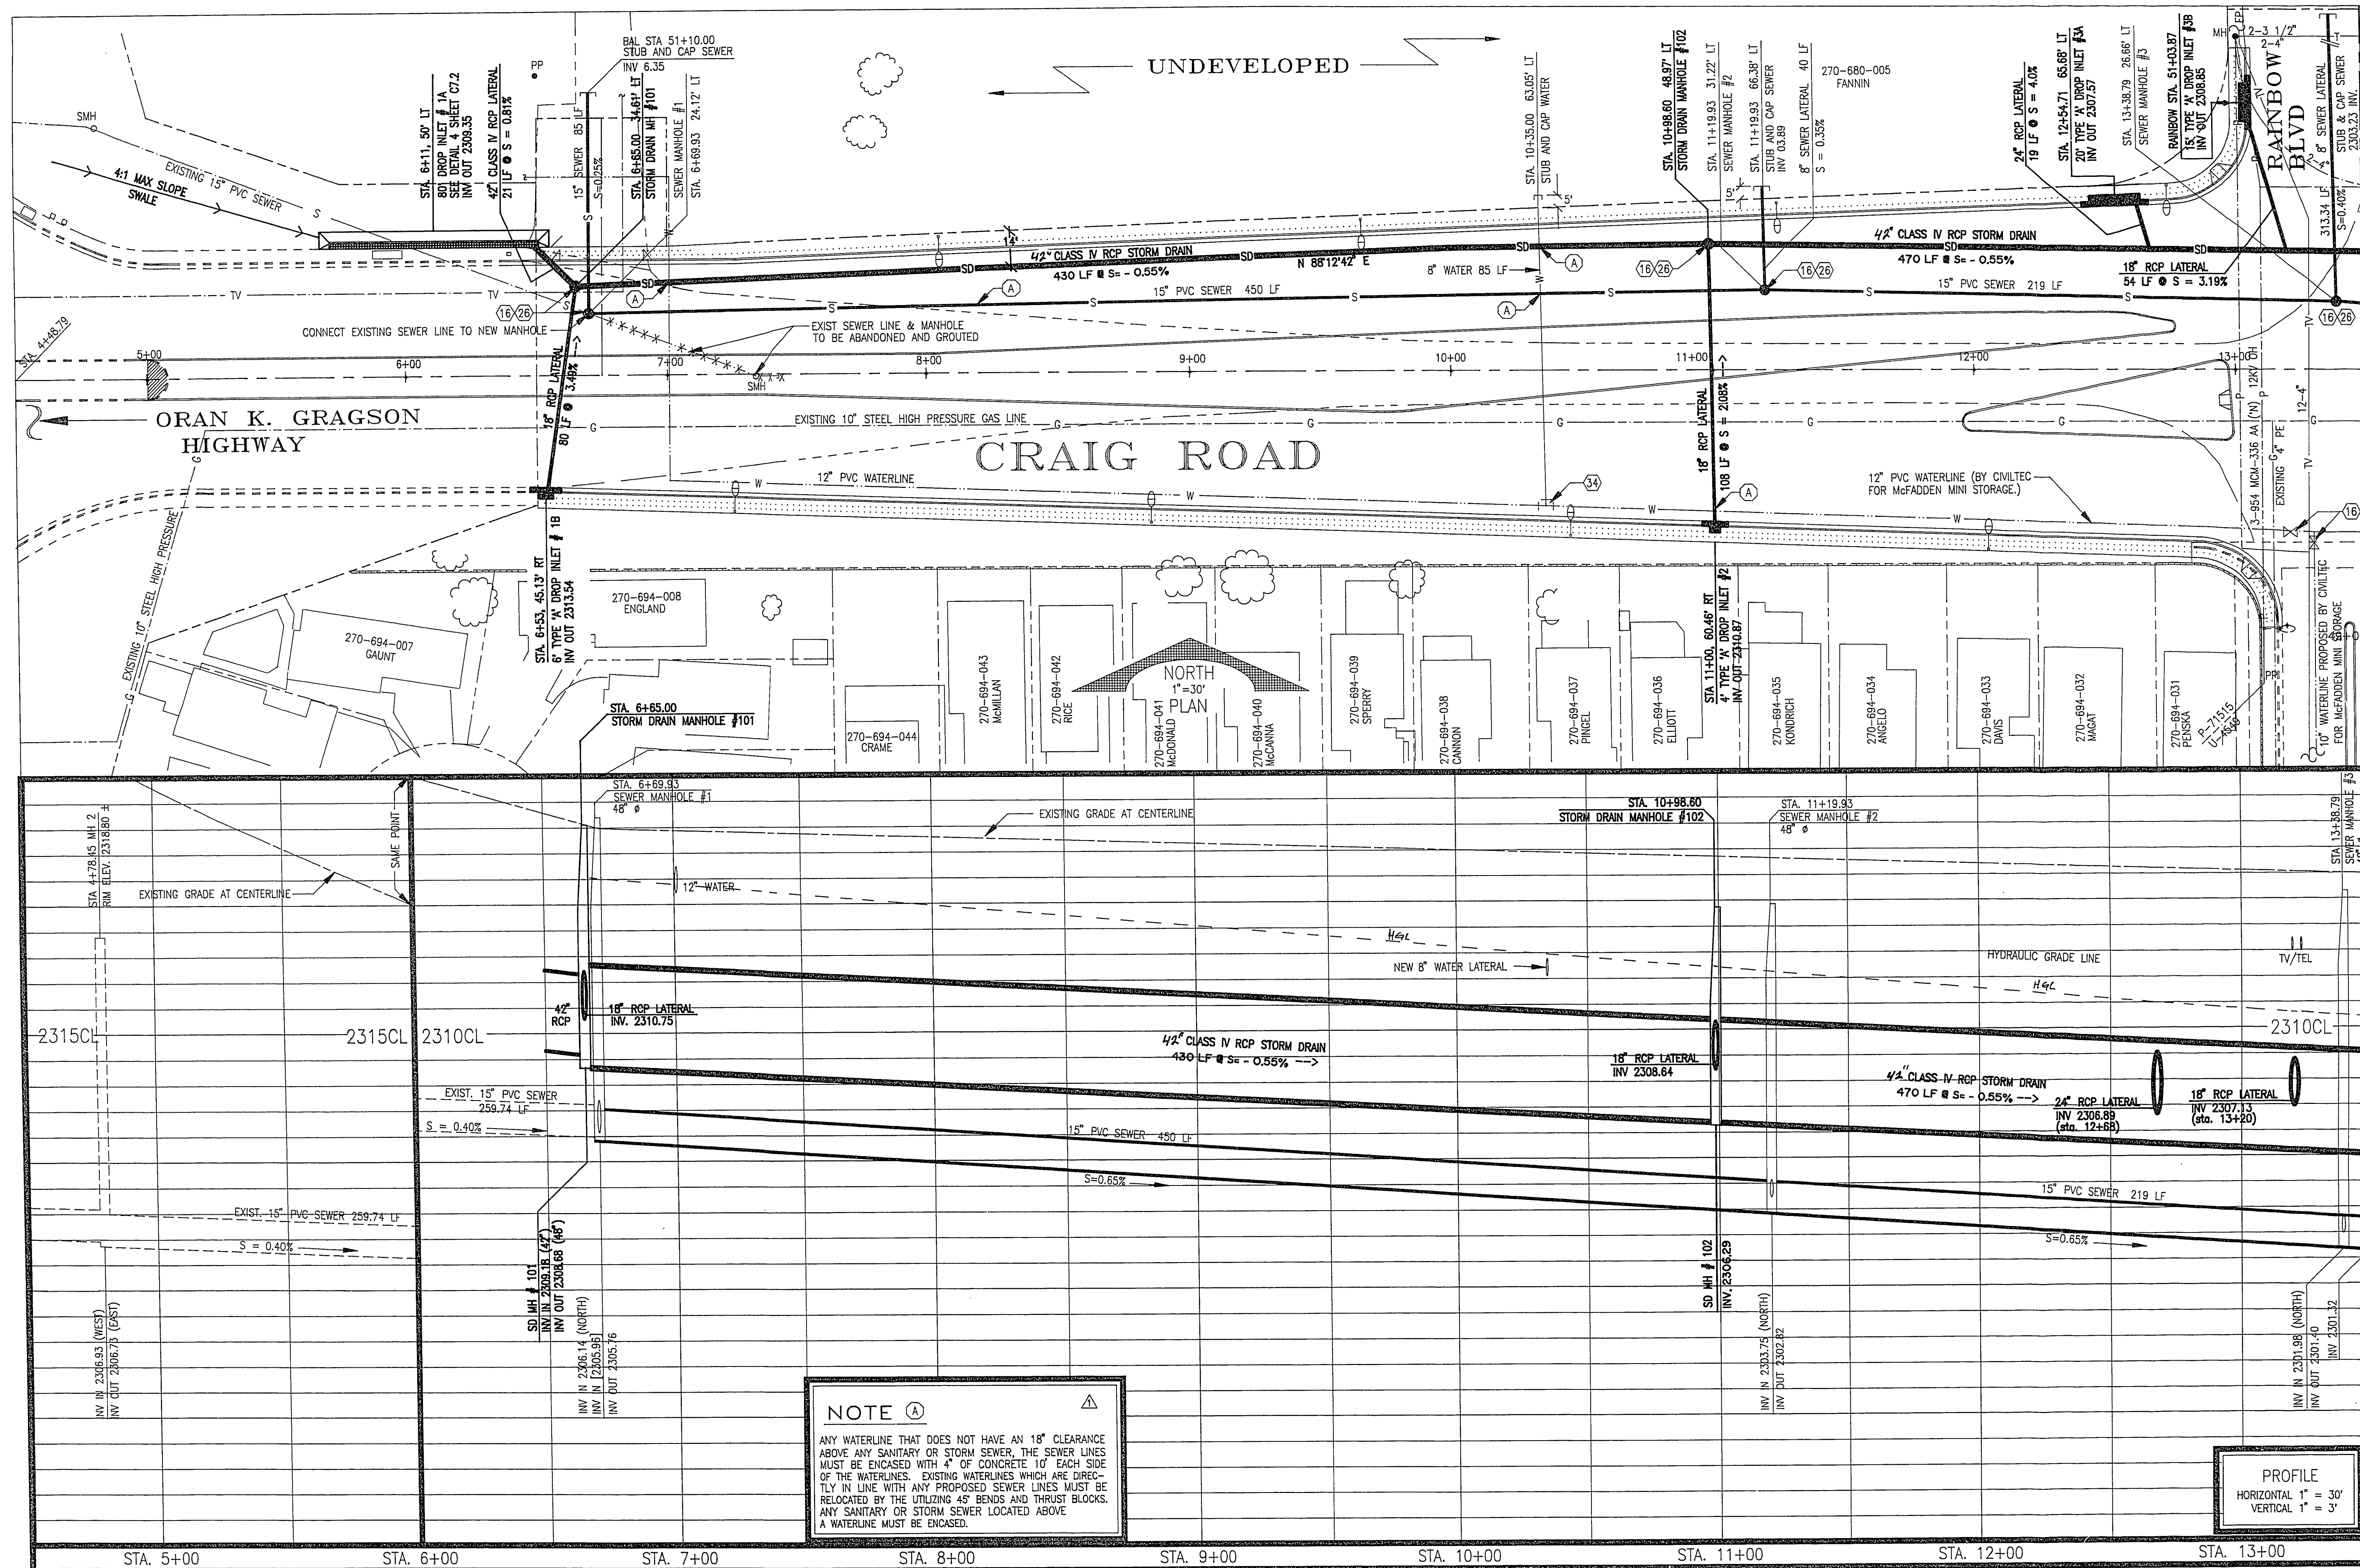

MATCHLINE AT STATION 13+48.79 - SEE SHEET C1.2

| REVISION | DATE  | BY | DESCRIPTION                                                      |
|----------|-------|----|------------------------------------------------------------------|
| 1        | 9/92  |    | CITY OF LAS VEGAS ENGINEERING DESIGN                             |
| 2        |       |    | DRAINAGE DESIGN REVISED ALONG WITH VARIOUS OTHER MINOR REVISIONS |
| 3        |       |    | ** SEE TOP REVISION BAR **                                       |
| TO SHEET | 10/92 |    | ENCASUREMENT NOTE                                                |

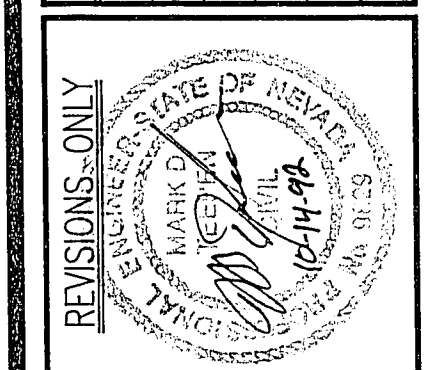

**HEFNER ENGINEERING**  
CIVIL ENGINEERING DESIGN  
LAND PLANNING & DEVELOPMENT  
4441 South Pacific Avenue, Las Vegas, Nevada 89103  
Phone: (702) 798-1900

**CRAIG ROAD**  
**UTILITY PLAN AND PROFILE**  
**STATION 4+48.79 TO STATION 13+48.79**

**SHEET NO.**  
**C5.1.1**  
107-V1804  
11/25/91

REVISIONS PERFORMED TO EXISTING DRAWINGS BY THE CITY OF LAS VEGAS ENGINEERING DIVISION  
ORIGINAL HEFNER ENGINEERING DESIGN DRAWINGS ON FILE AT THE CITY OF LAS VEGAS