
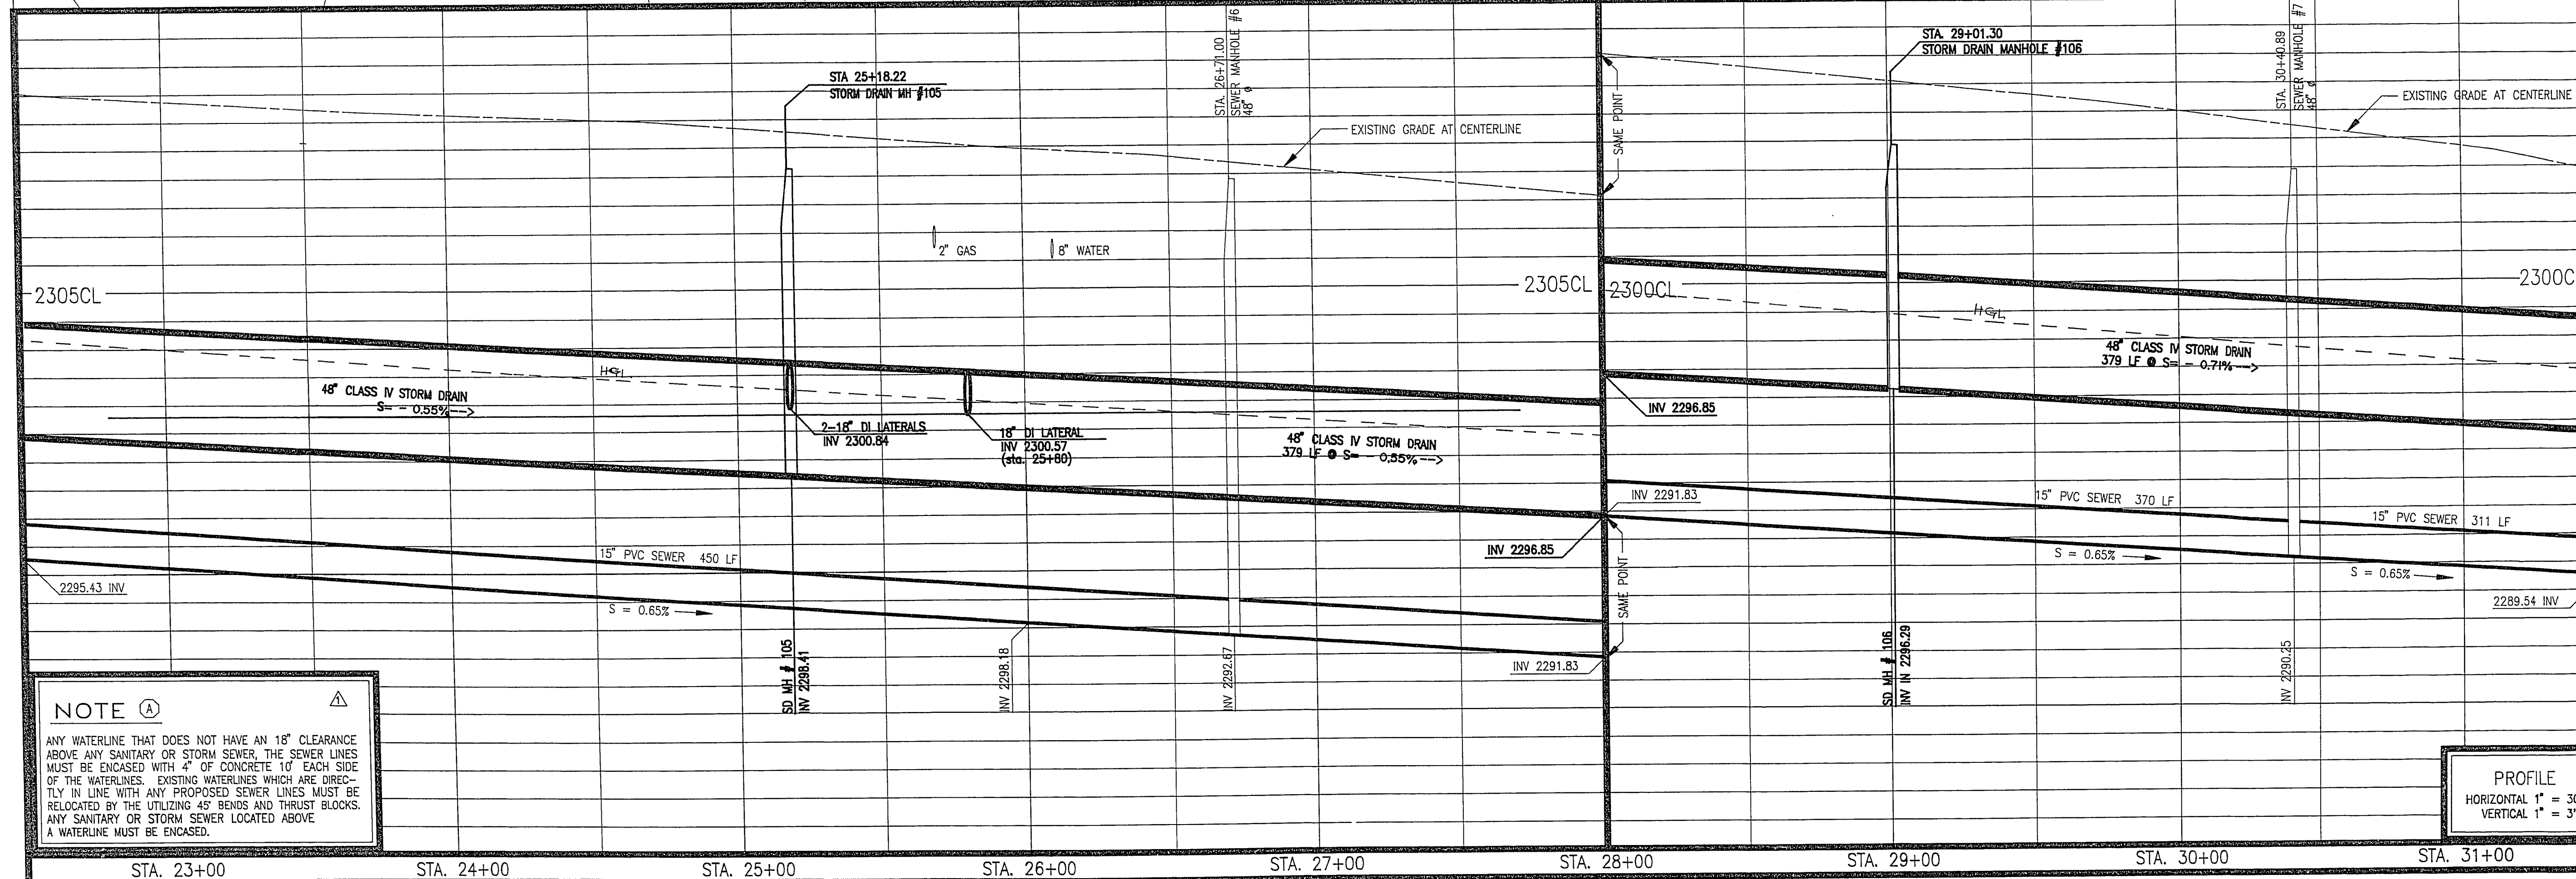


MATCHLINE AT STA. 22+48.79 SEE SHEET C5.2

MATCHLINE AT STA. 31+48.79 SEE SHEET C5.4

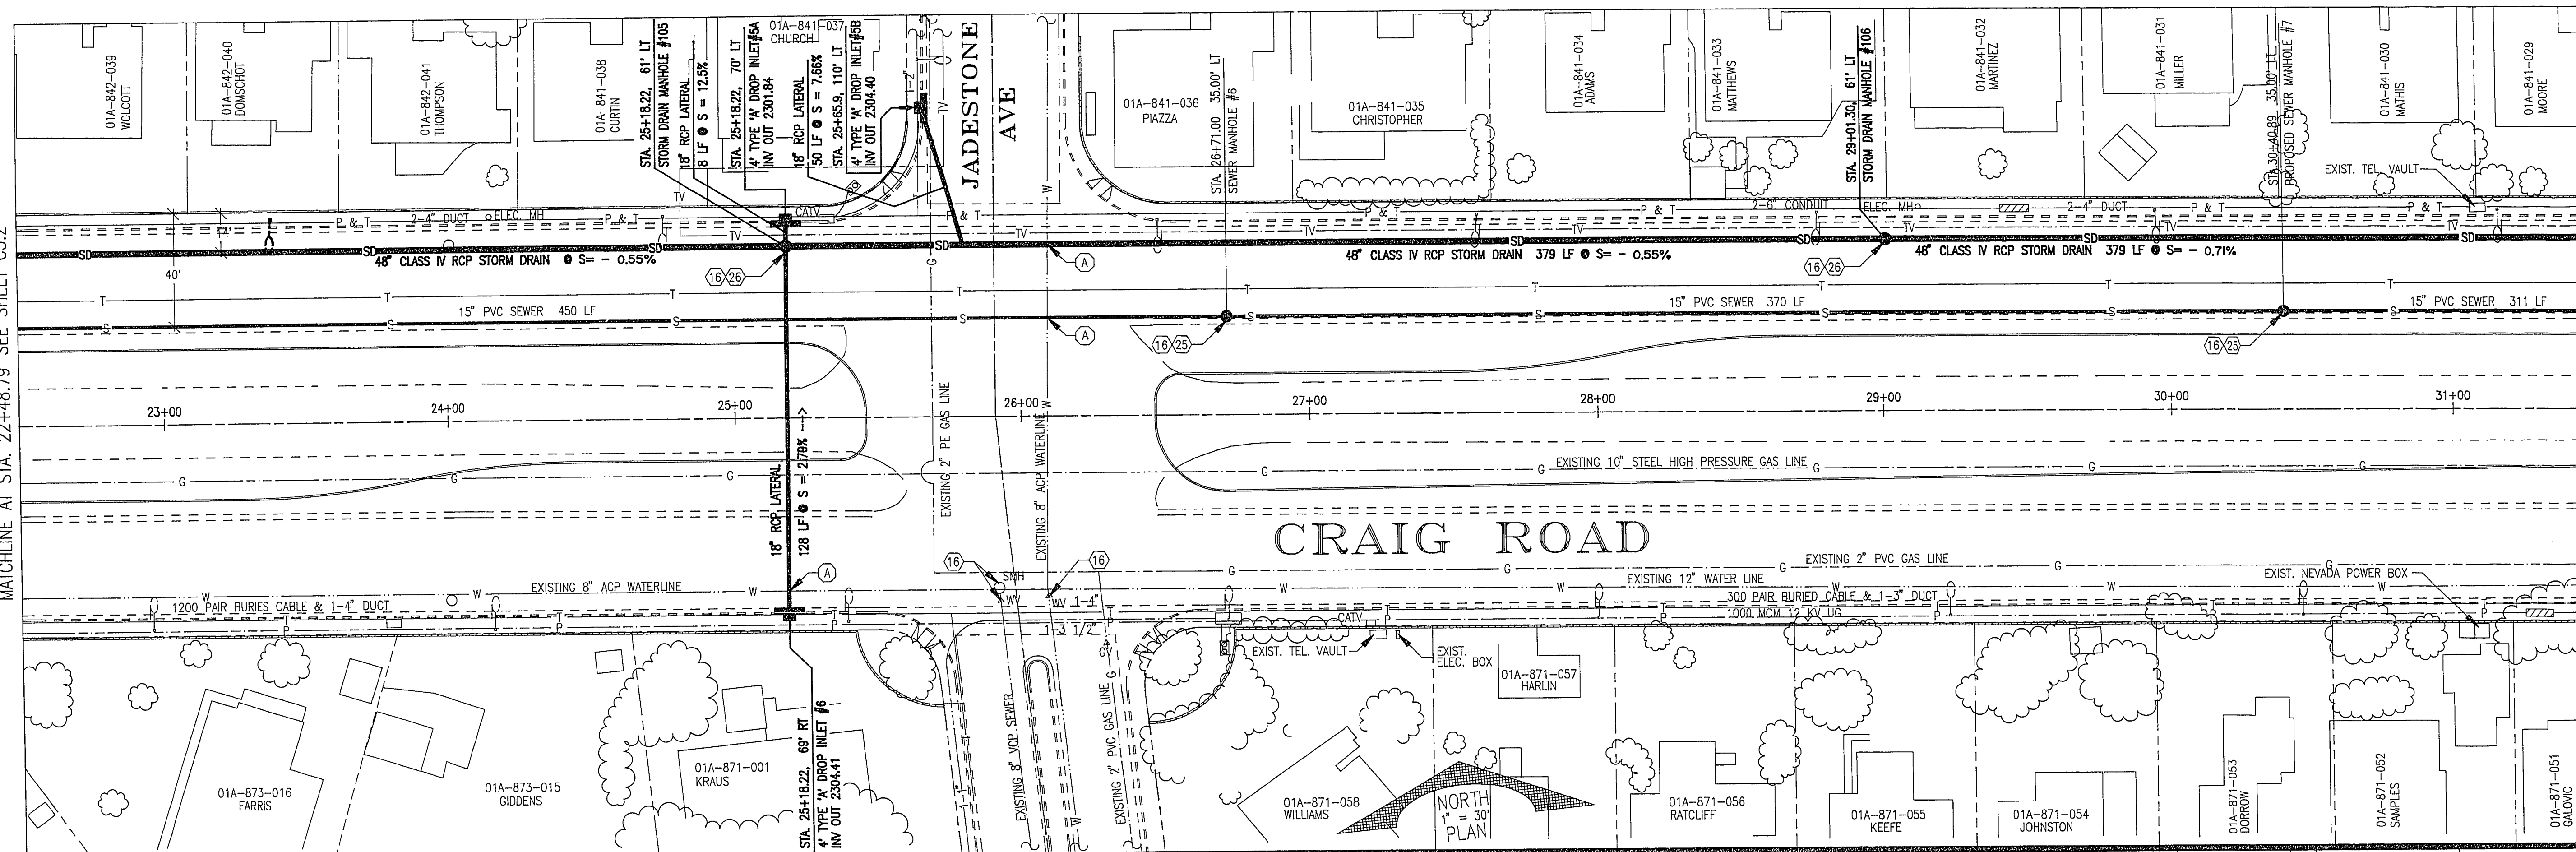


NOTE (A)

ANY WATERLINE THAT DOES NOT HAVE AN 18\"/>

PROFILE
HORIZONTAL 1\"/>

REVISIONS PERFORMED TO EXISTING DRAWINGS BY THE CITY OF LAS VEGAS ENGINEERING DIVISION
ORIGINAL HEFNER ENGINEERING DESIGN DRAWINGS ON FILE AT THE CITY OF LAS VEGAS

DATE	REVISION
9/92	1. CITY OF LAS VEGAS ENGINEERING DESIGN. 2. DRAINAGE DESIGN REVISED ALONG WITH VARIOUS OTHER MINOR REVISIONS
10 JUNE 1992	ENCLOSURE NOTE

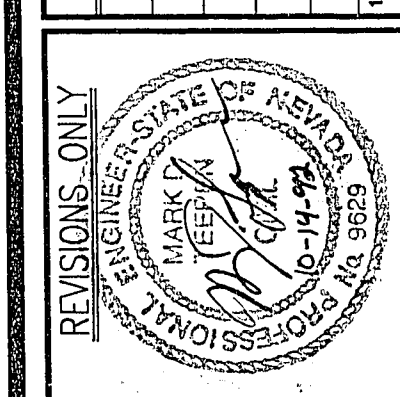

HEFNER ENGINEERING
CIVIL ENGINEERING DESIGN
LAND PLANNING & DEVELOPMENT
4441 South Pahrump Road, Nevada 89103
Phone: (702) 798-1900

CRAIG ROAD
UTILITY PLAN AND PROFILE
STATION 22+48.79 TO STATION 31+48.79

SHEET NO.

C5.3.1

107-V1804
C89042PC DATE: 11/25/91