
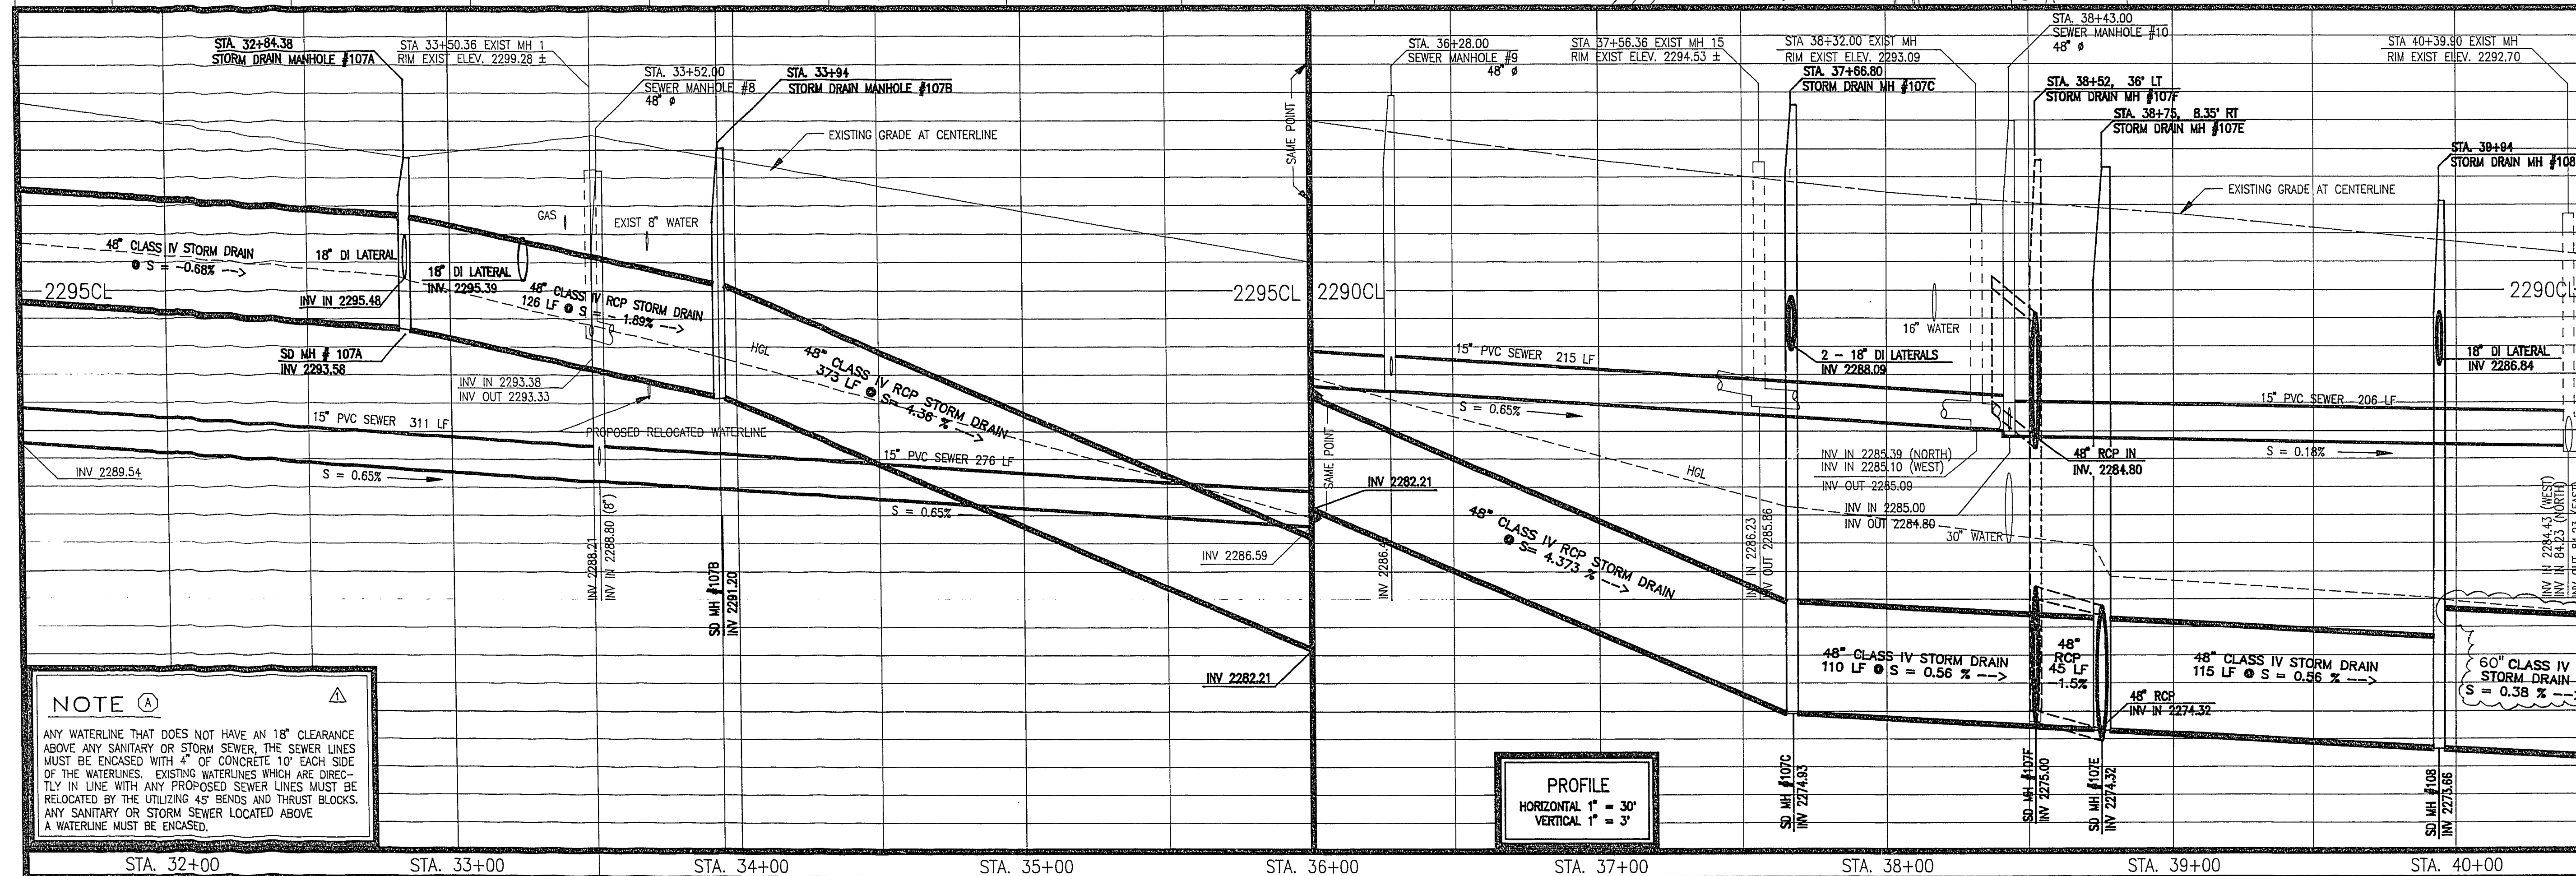


MATCHLINE AT STA. 31+48.79 SEE SHEET C5.3

MATCHLINE AT STA. 40+48.79 SEE SHEET C5.5

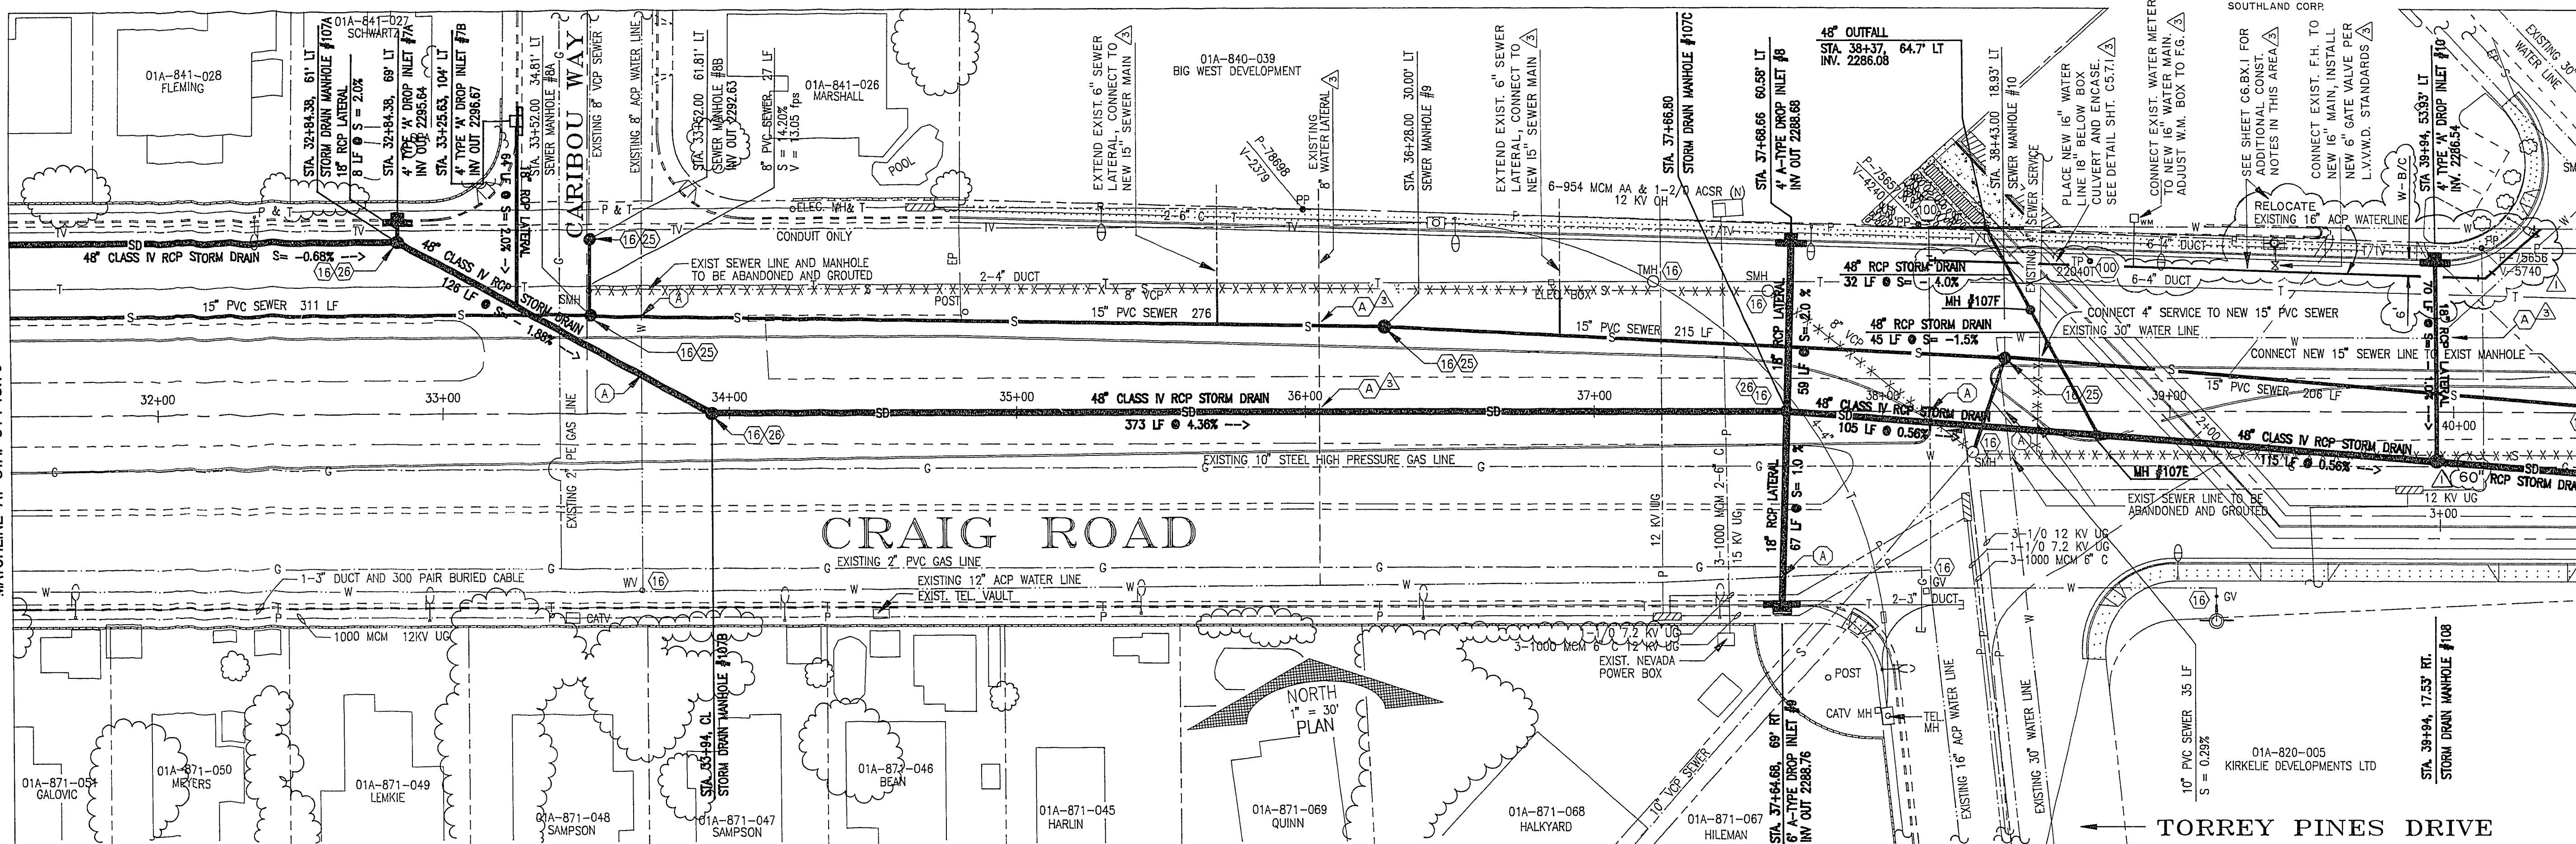

NOTE (A)

ANY WATERLINE THAT DOES NOT HAVE AN 18" CLEARANCE ABOVE ANY SANITARY OR STORM SEWER, THE SEWER LINES MUST BE ENCASED WITH 4" OF CONCRETE 10' EACH SIDE OF THE WATERLINES. EXISTING WATERLINES WHICH ARE DIRECTLY IN LINE WITH ANY PROPOSED SEWER LINES MUST BE RELOCATED BY THE UTILIZING 45° BENDS AND THRUST BLOCKS. ANY SANITARY OR STORM SEWER LOCATED ABOVE A WATERLINE MUST BE ENCASED.

PROFILE

HORIZONTAL 1" = 30'
VERTICAL 1" = 3'

DATE	REVISION
9/92	Δ CITY OF LAS VEGAS ENGINEERING DESIGN
5/93	Δ DRAINAGE DESIGN REVISED ALONG WITH VARIOUS OTHER MINOR REVISIONS
	Δ ADD WATER LINE CONST. NOTES
	Δ RELOCATE WATER LINE ABOVE ARROW ENCLOSURE NOTE



HEFNER ENGINEERING

CIVIL ENGINEERING DESIGN
LAND PLANNING & DEVELOPMENT
4411 South Pahr Avenue, Las Vegas, Nevada 89103
Phone: (702) 788-1000

CRAIG ROAD

UTILITY PLAN AND PROFILE

STATION 31+48.79 TO STATION 40+48.79

SHEET NO.

C5.4.2

107-V1804
088042P01 DATE: 11/25/91

REVISIONS PERFORMED TO EXISTING DRAWINGS BY THE CITY OF LAS VEGAS ENGINEERING DIVISION
ORIGINAL HEFNER ENGINEERING DESIGN DRAWINGS ON FILE AT THE CITY OF LAS VEGAS

23-3-144

SHT. 43/66