
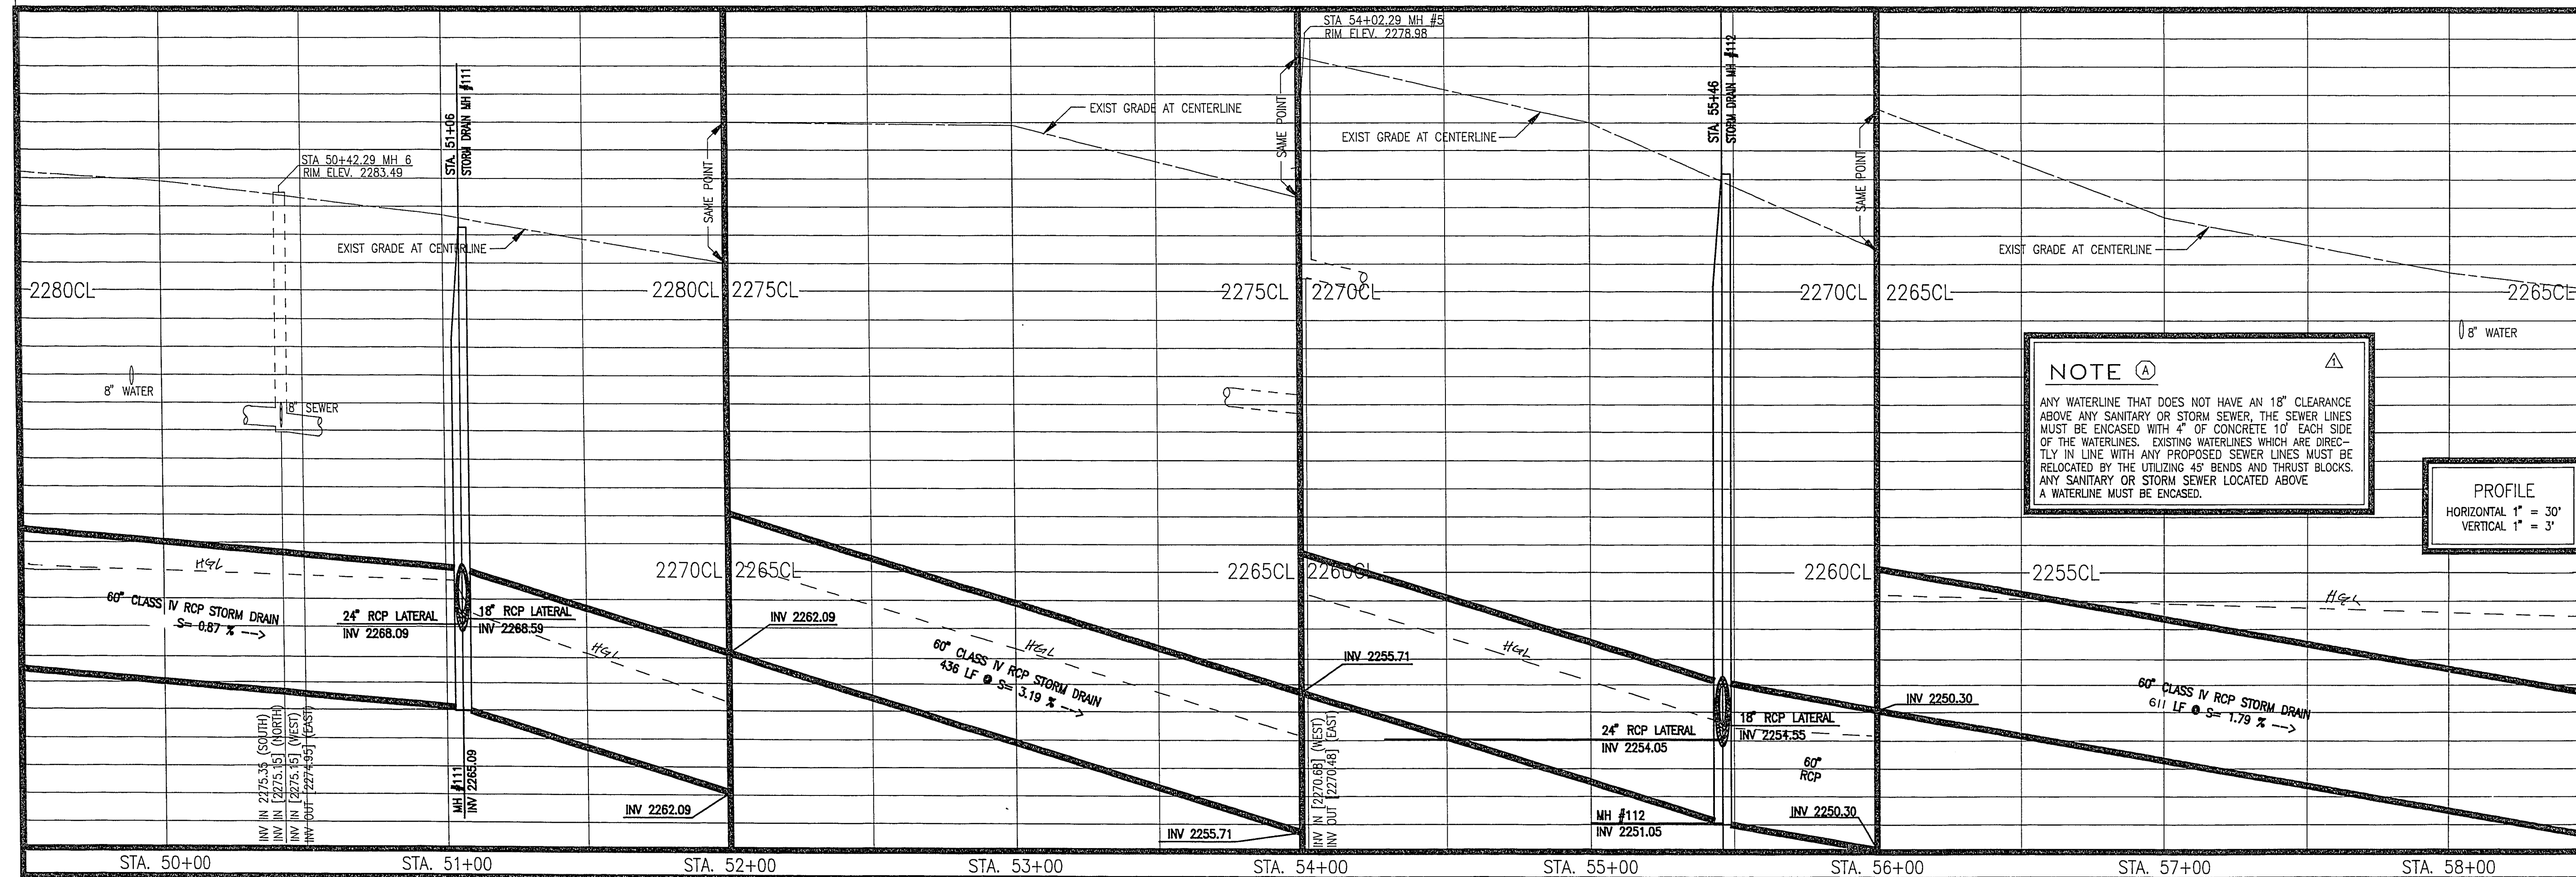


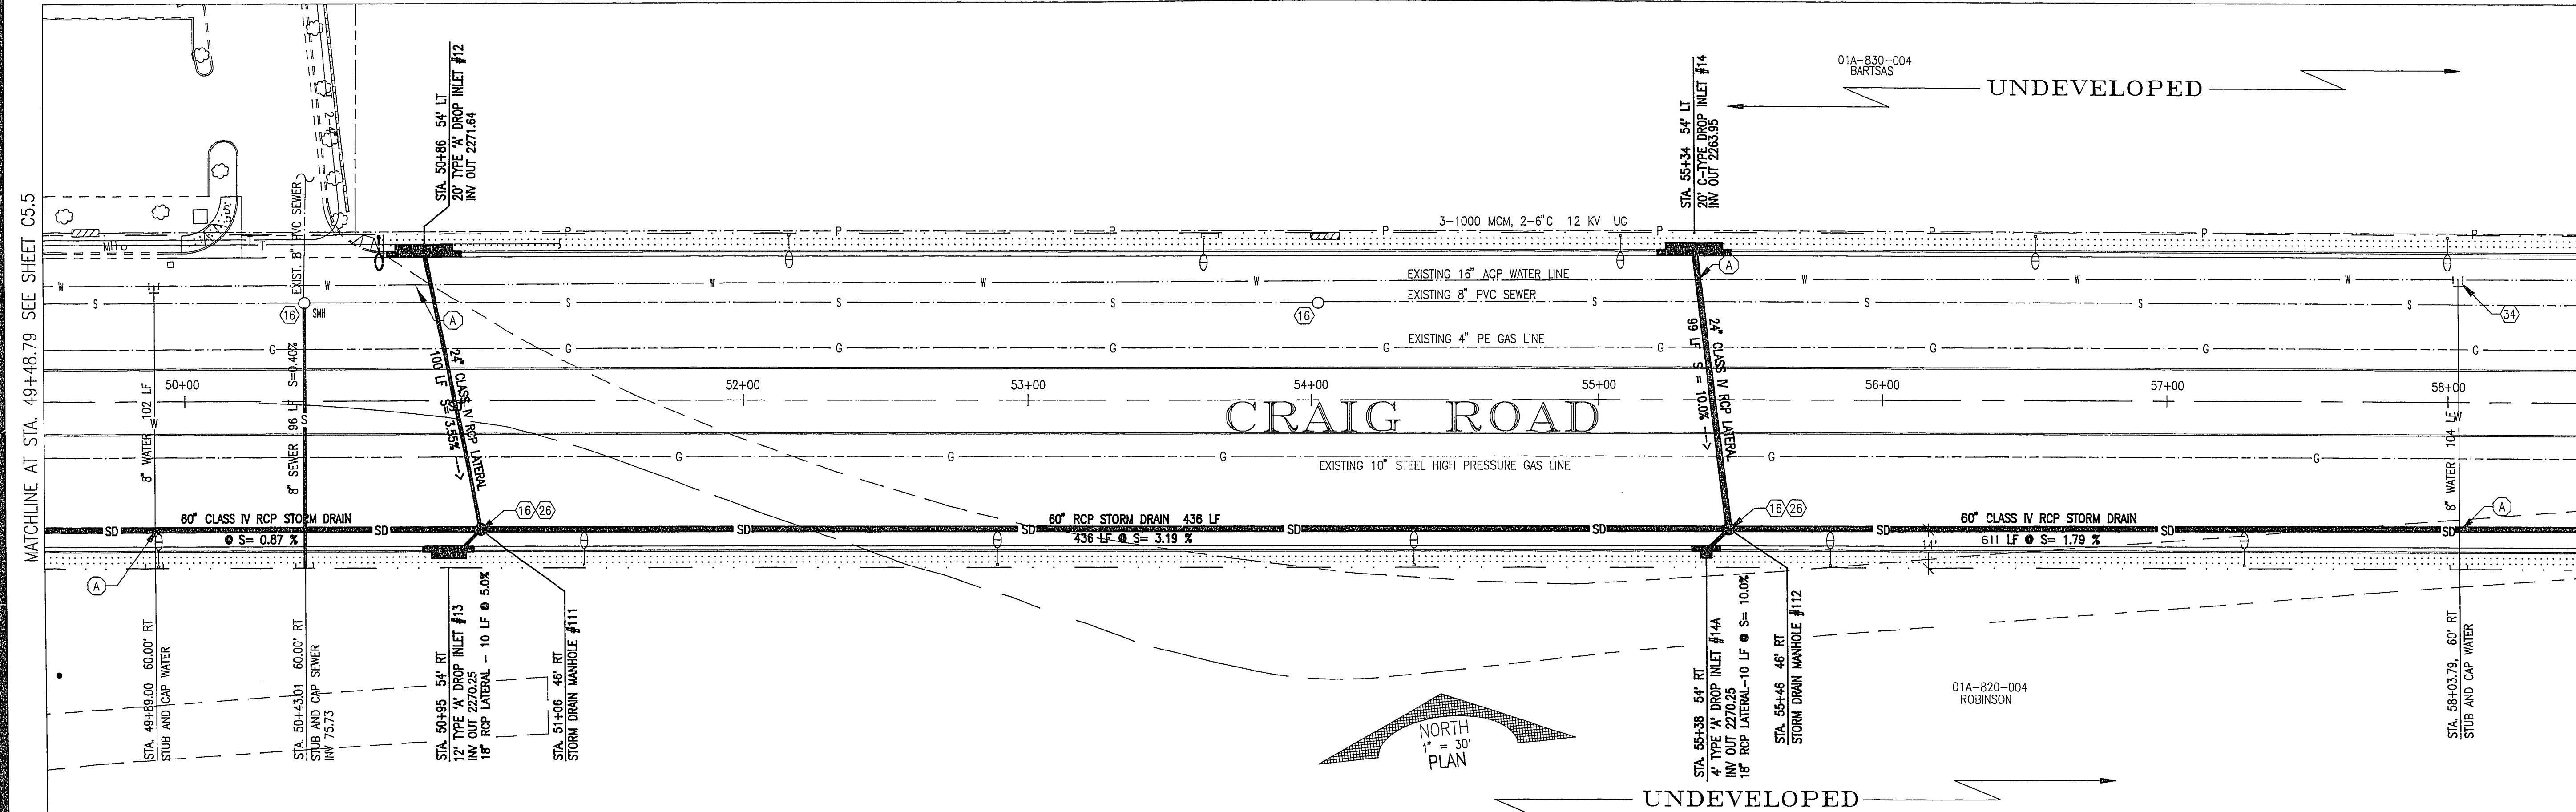

NOTE (A)

ANY WATERLINE THAT DOES NOT HAVE AN 18" CLEARANCE ABOVE ANY SANITARY OR STORM SEWER, THE SEWER LINES MUST BE ENCASED WITH 4" OF CONCRETE 10' EACH SIDE OF THE WATERLINES. EXISTING WATERLINES WHICH ARE DIRECTLY IN LINE WITH ANY PROPOSED SEWER LINES MUST BE RELOCATED BY THE UTILIZING 45° BENDS AND THRUST BLOCKS. ANY SANITARY OR STORM SEWER LOCATED ABOVE A WATERLINE MUST BE ENCASED.

PROFILE

HORIZONTAL 1" = 30'

VERTICAL 1" = 3'

REVISIONS PERFORMED TO EXISTING DRAWINGS BY THE CITY OF LAS VEGAS ENGINEERING DIVISION
ORIGINAL HEFNER ENGINEERING DESIGN DRAWINGS ON FILE AT THE CITY OF LAS VEGAS

REVISIONS ONLY DATE 9/92 REVISION 1 CITY OF LAS VEGAS ENGINEERING DESIGN DRAINAGE DESIGN REVISED ALONG WITH VARIOUS OTHER MINOR REVISIONS 10 JUNE 1992 RELOCATE WATER LINE, MOVE ARROW, ENCASEMENT NOTE		 HEFNER ENGINEERING CIVIL ENGINEERING DESIGN LAND PLANNING & DEVELOPMENT 4441 South Paines Avenue, Las Vegas, Nevada 89103 Phone: (702) 798-1800	CRAIG ROAD UTILITY PLAN AND PROFILE STATION 49+48.79 TO STATION 58+48.79
SHEET NO. C5.6.1 107-V1804 F88042PF DATE: 11/25/91			