
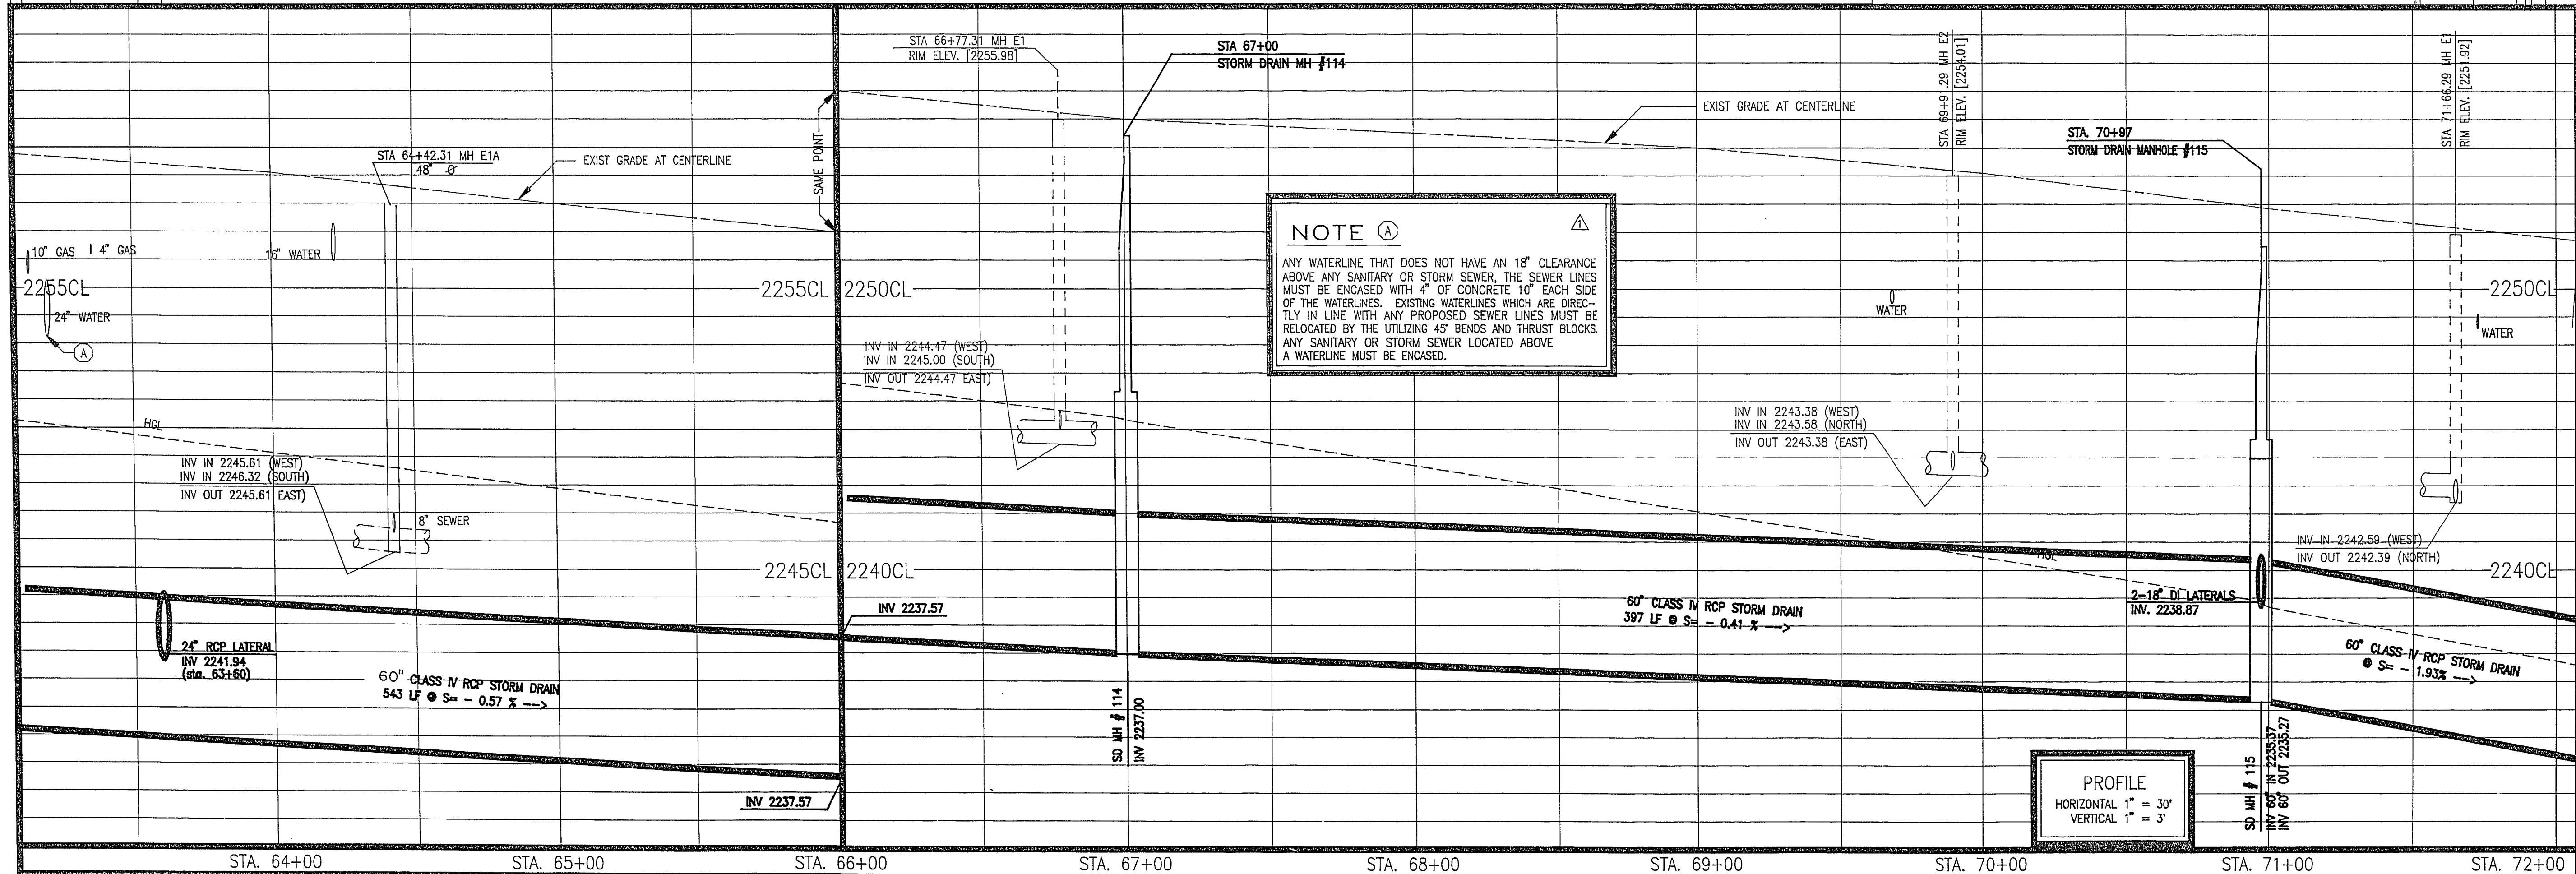


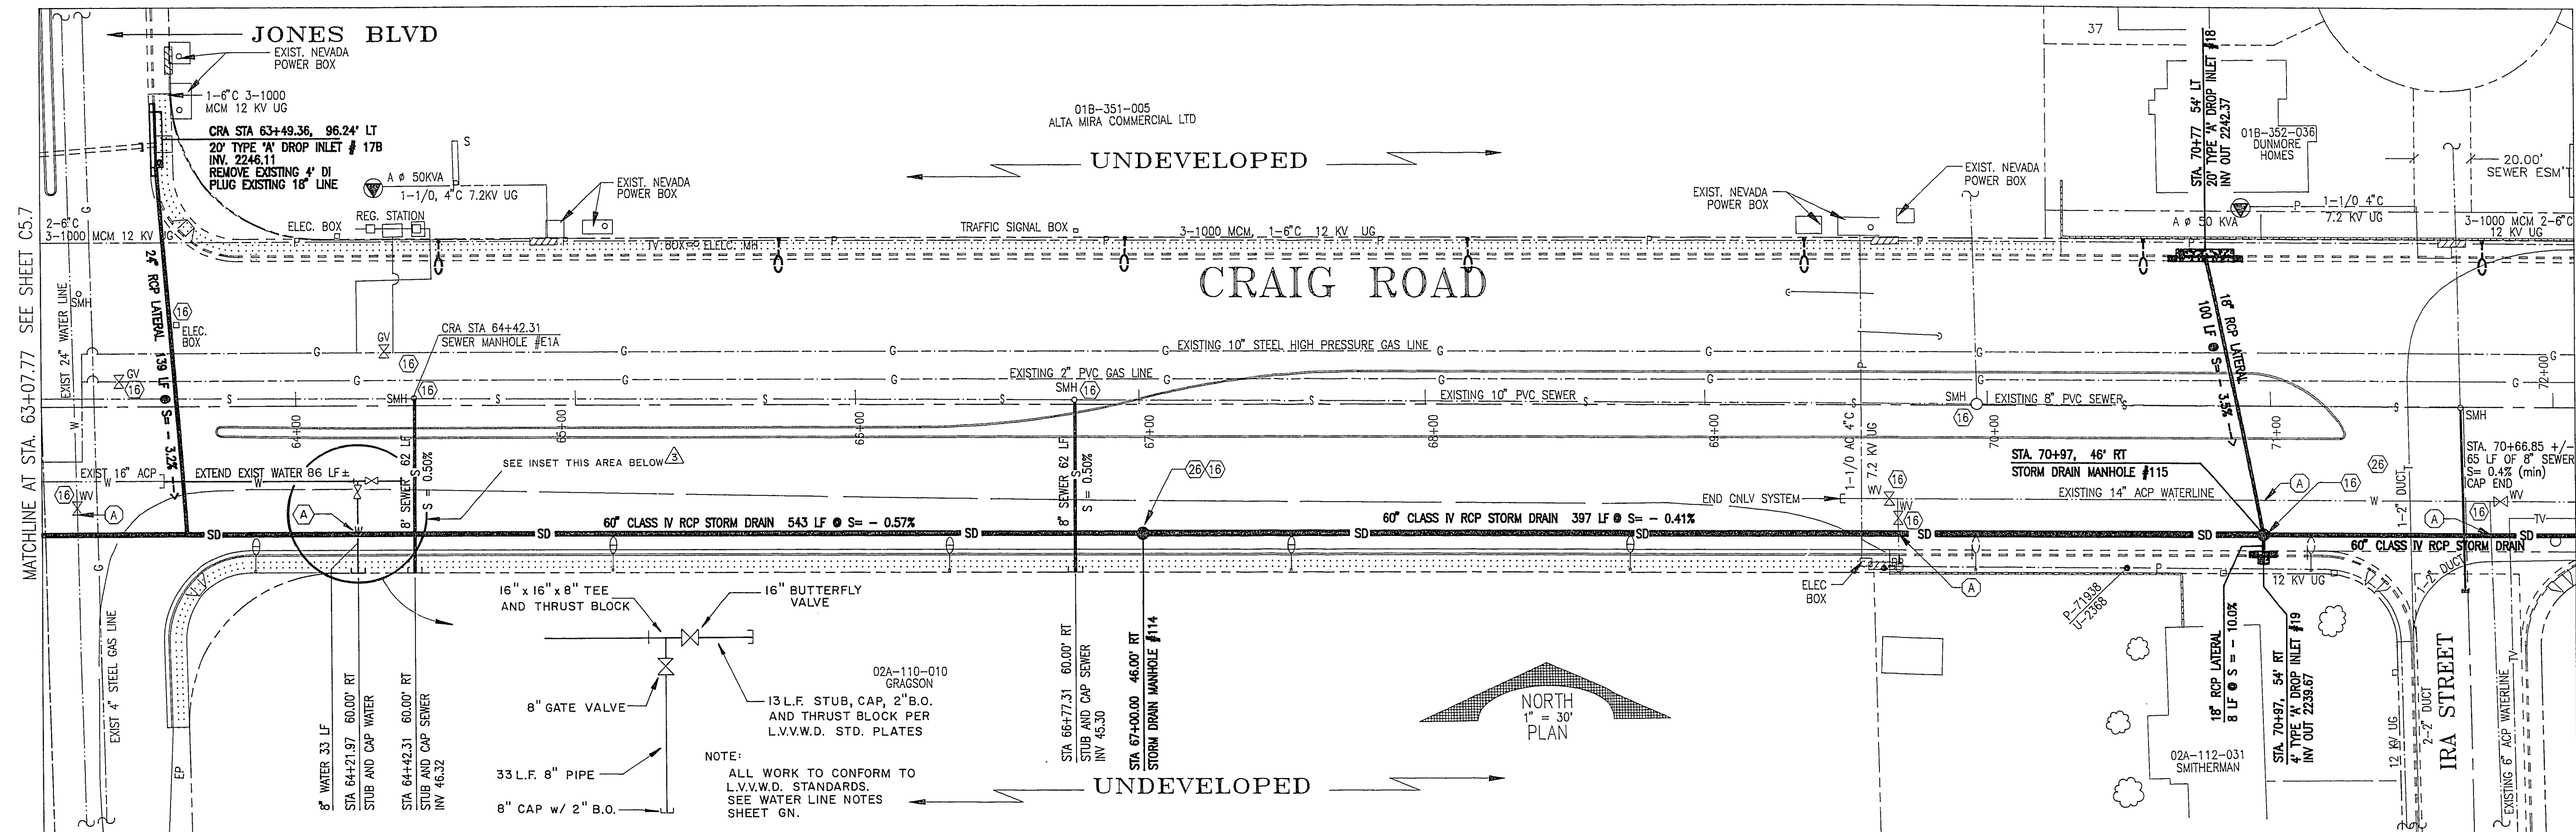

NOTE A

ANY WATERLINE THAT DOES NOT HAVE AN 18" CLEARANCE ABOVE ANY SANITARY OR STORM SEWER, THE SEWER LINES MUST BE ENCASED WITH 4" OF CONCRETE 10" EACH SIDE OF THE WATERLINES. EXISTING WATERLINES WHICH ARE DIRECTLY IN LINE WITH ANY PROPOSED SEWER LINES MUST BE RELOCATED BY THE UTILIZING 45° BENDS AND THRUST BLOCKS. ANY SANITARY OR STORM SEWER LOCATED ABOVE A WATERLINE MUST BE ENCASED.

PROFILE
 HORIZONTAL 1" = 30'
 VERTICAL 1" = 3'

REVISIONS ONLY DATE REVISION 9/92 CITY OF LAS VEGAS ENGINEERING DESIGN 5/93 DRAINAGE DESIGN REVISED ALONG WITH VARIOUS OTHER MINOR REVISIONS 1/92 ADD WATER LINE INSET DRAWING 1/92 ASSESS SEWER STATUS ENCLOSURE NOTE	
HEFNER ENGINEERING CIVIL ENGINEERING DESIGN LAND PLANNING & DEVELOPMENT 4441 South Palms Avenue, Las Vegas, Nevada 89103 Phone: (702) 788-1900	
CRAIG ROAD UTILITY PLAN AND PROFILE STATION 65+07.77 TO STATION 78+07.77	
SHEET NO. C5.8.1	
107-V1804 H88042PH DATE: 11/25/91	

REVISIONS PERFORMED TO EXISTING DRAWINGS BY THE CITY OF LAS VEGAS ENGINEERING DIVISION
 ORIGINAL HEFNER ENGINEERING DESIGN DRAWINGS ON FILE AT THE CITY OF LAS VEGAS

23-3141 SHT. 47/66