
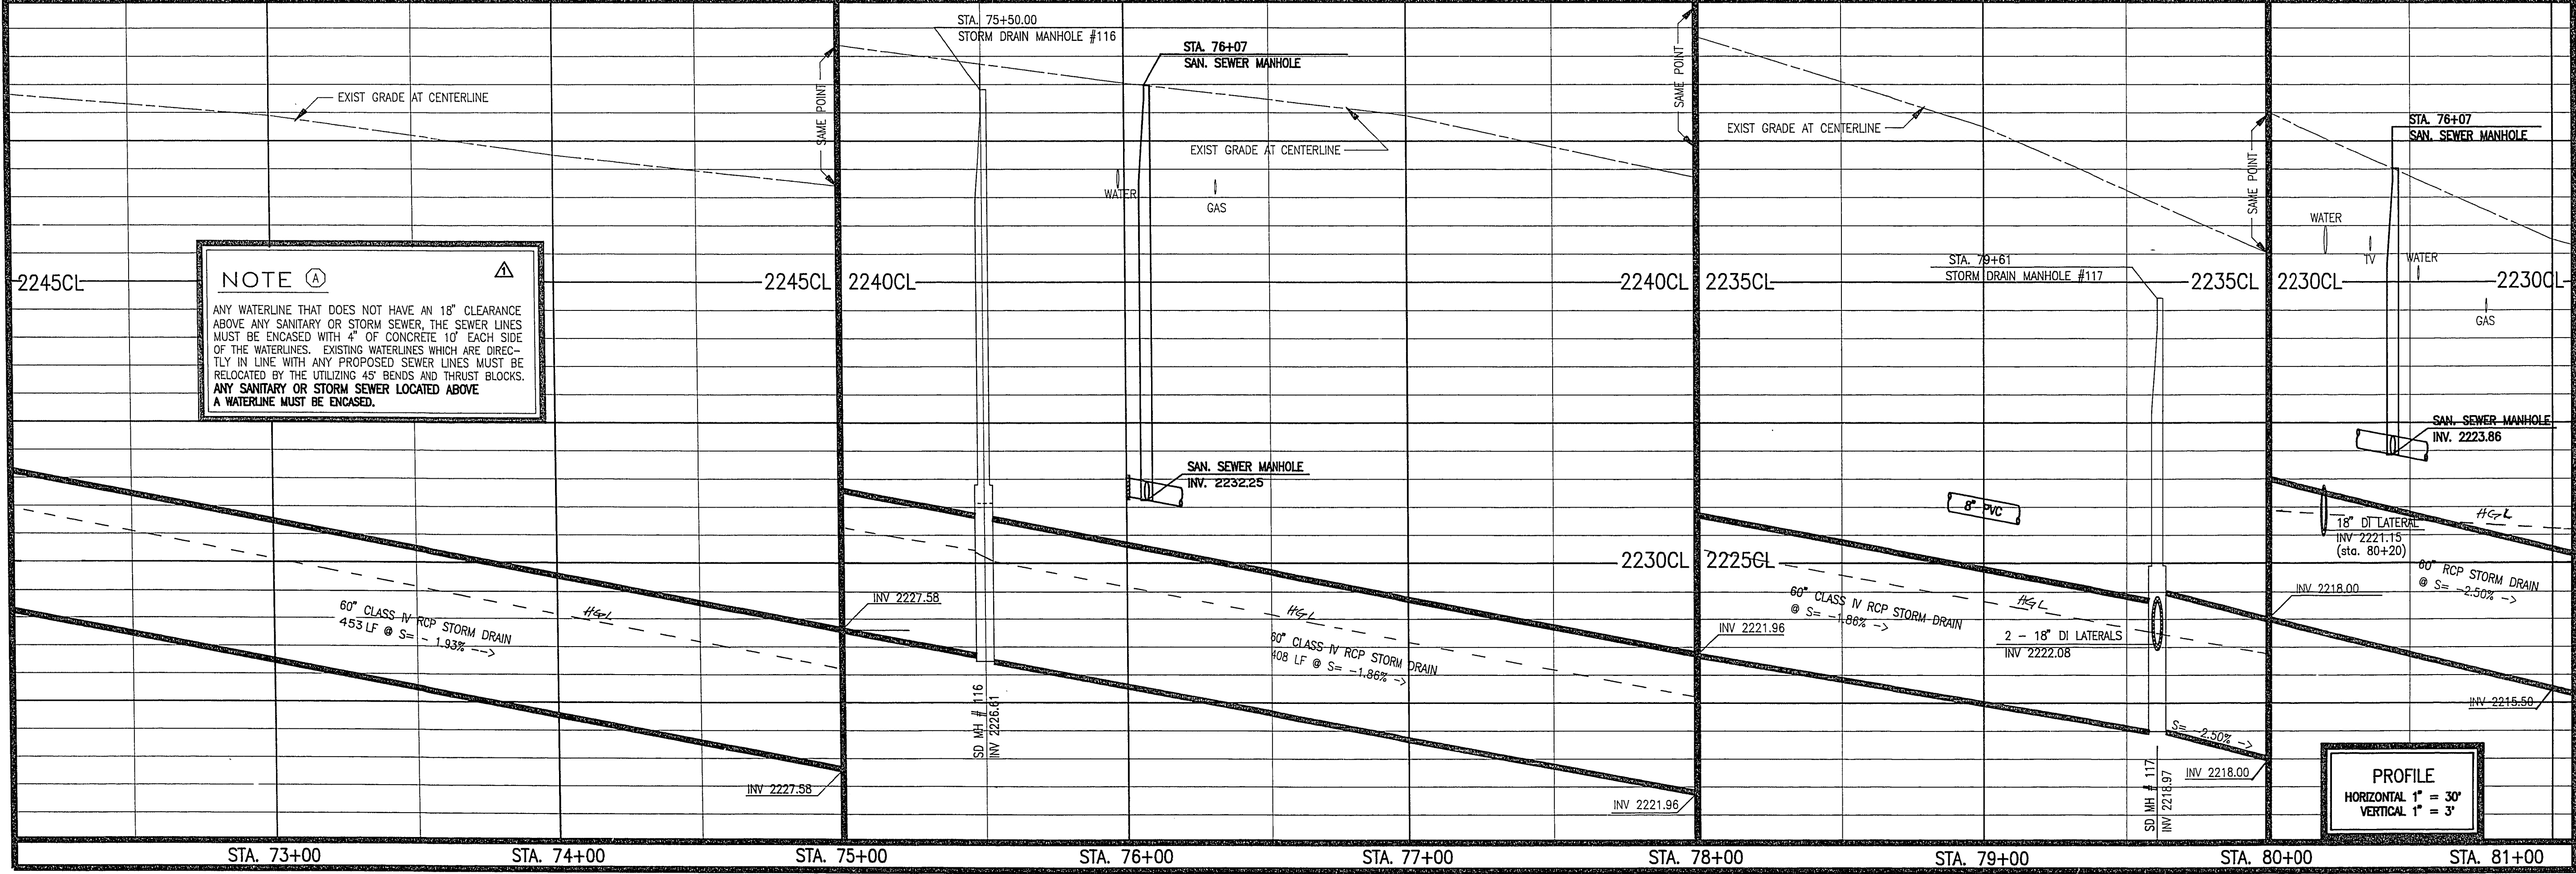


MATCHLINE AT STATION 72+07.77 SEE SHEET C5.8

MATCHLINE AT STATION 81+07.77 SEE SHEET C5.10

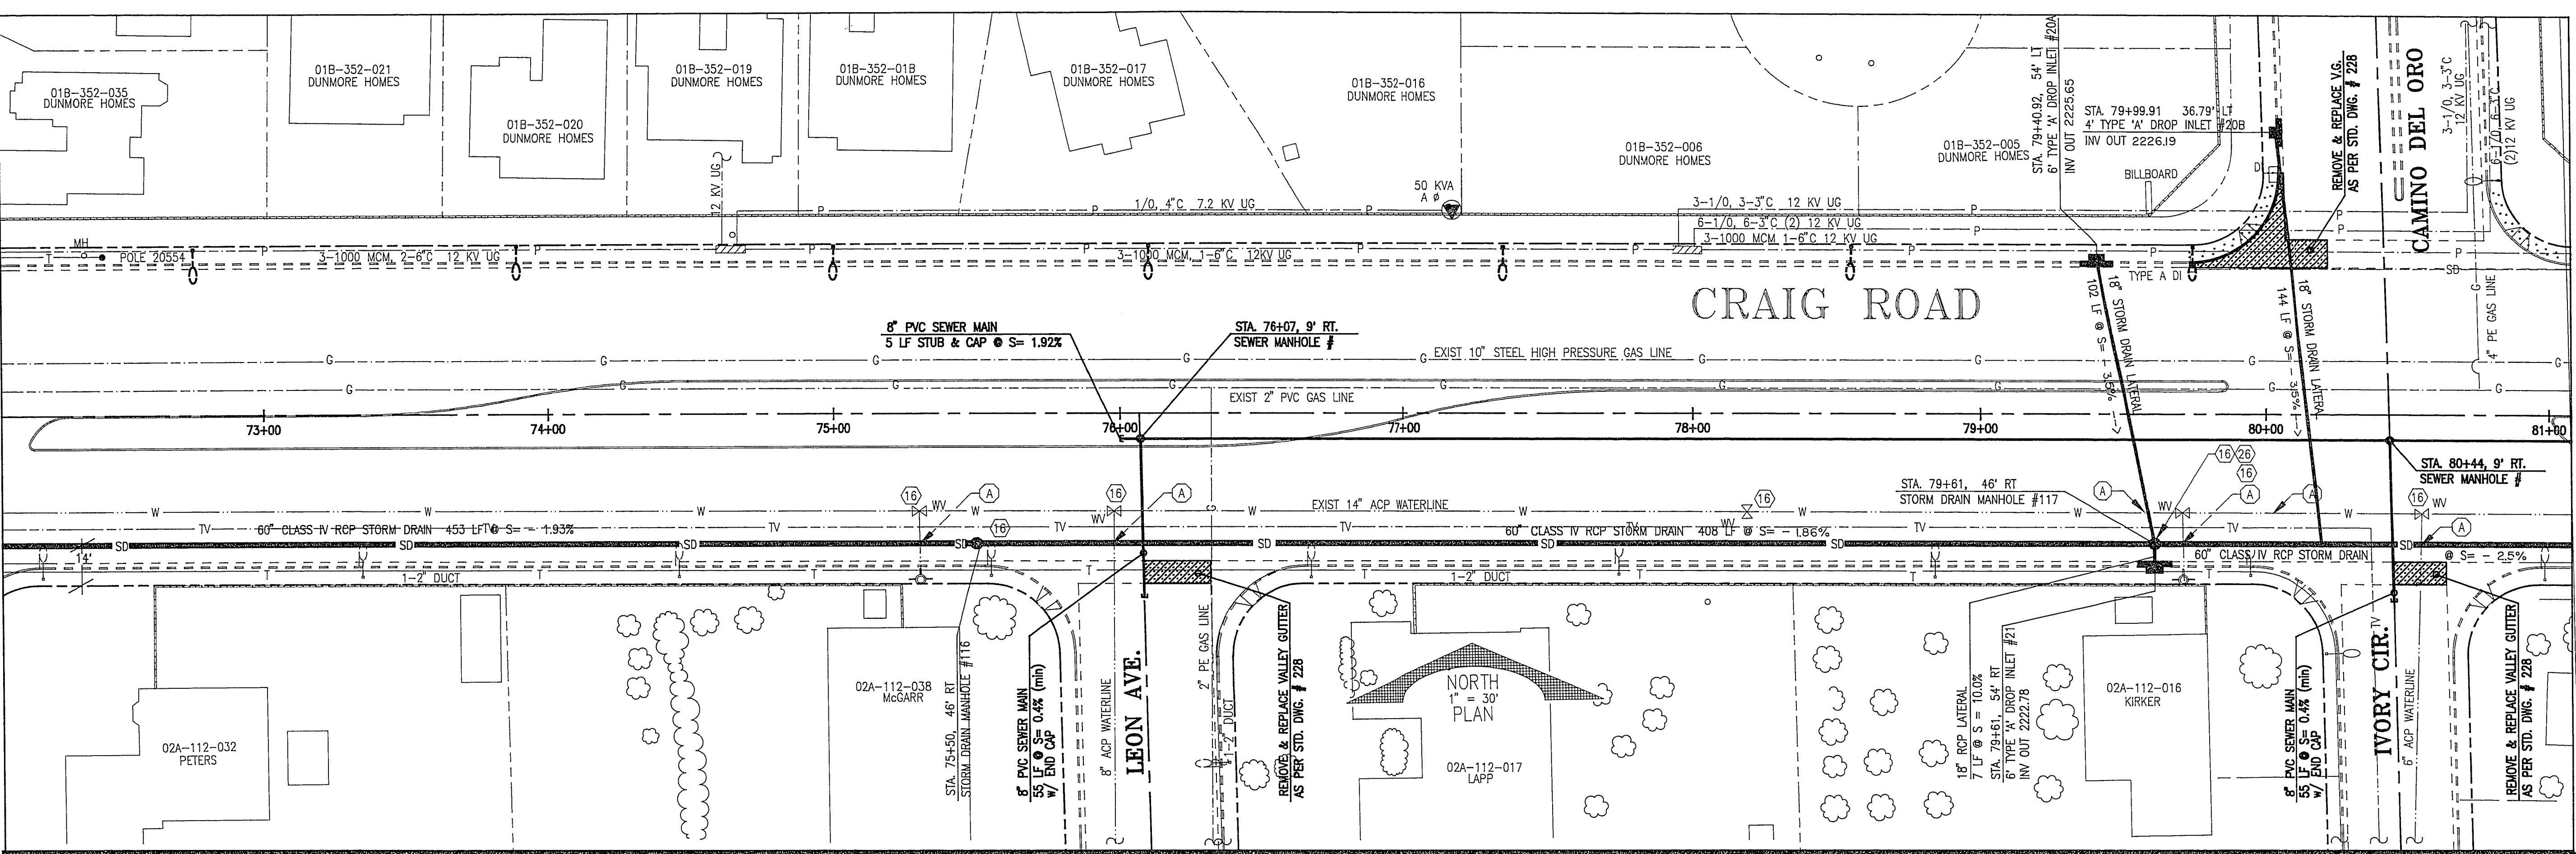

NOTE (A)

ANY WATERLINE THAT DOES NOT HAVE AN 18" CLEARANCE ABOVE ANY SANITARY OR STORM SEWER, THE SEWER LINES MUST BE ENCASED WITH 4" OF CONCRETE 10' EACH SIDE OF THE WATERLINE. EXISTING WATERLINES WHICH ARE DIRECTLY IN LINE WITH ANY PROPOSED SEWER LINES MUST BE RELOCATED BY THE UTILIZING 45° BENDS AND THRUST BLOCKS. ANY SANITARY OR STORM SEWER LOCATED ABOVE A WATERLINE MUST BE ENCASED.

PROFILE
HORIZONTAL 1" = 30'
VERTICAL 1" = 3'

REVISIONS PERFORMED TO EXISTING DRAWINGS BY THE CITY OF LAS VEGAS ENGINEERING DIVISION
ORIGINAL HEFNER ENGINEERING DESIGN DRAWINGS ON FILE AT THE CITY OF LAS VEGAS

REVISIONS ONLY	
DATE	REVISION
9/92	CITY OF LAS VEGAS ENGINEERING DESIGN DRAINAGE DESIGN REVISED ALONG WITH VARIOUS OTHER MINOR REVISIONS
10/92	CONC. MARIAN HOUSE, ADD 8" SEWER LINE ENCLOSURE NOTE

HEFNER ENGINEERING
CIVIL ENGINEERING DESIGN
LAND PLANNING & DEVELOPMENT
4441 South Pahrump Avenue, Las Vegas, Nevada 89103
Phone: (702) 780-1000

CRAIG ROAD
UTILITY PLAN AND PROFILE
STATION 72+07.77 TO STATION 81+07.77

SHEET NO.
C5.9.1
107-V1804
89042P | DATE: 11/26/81