
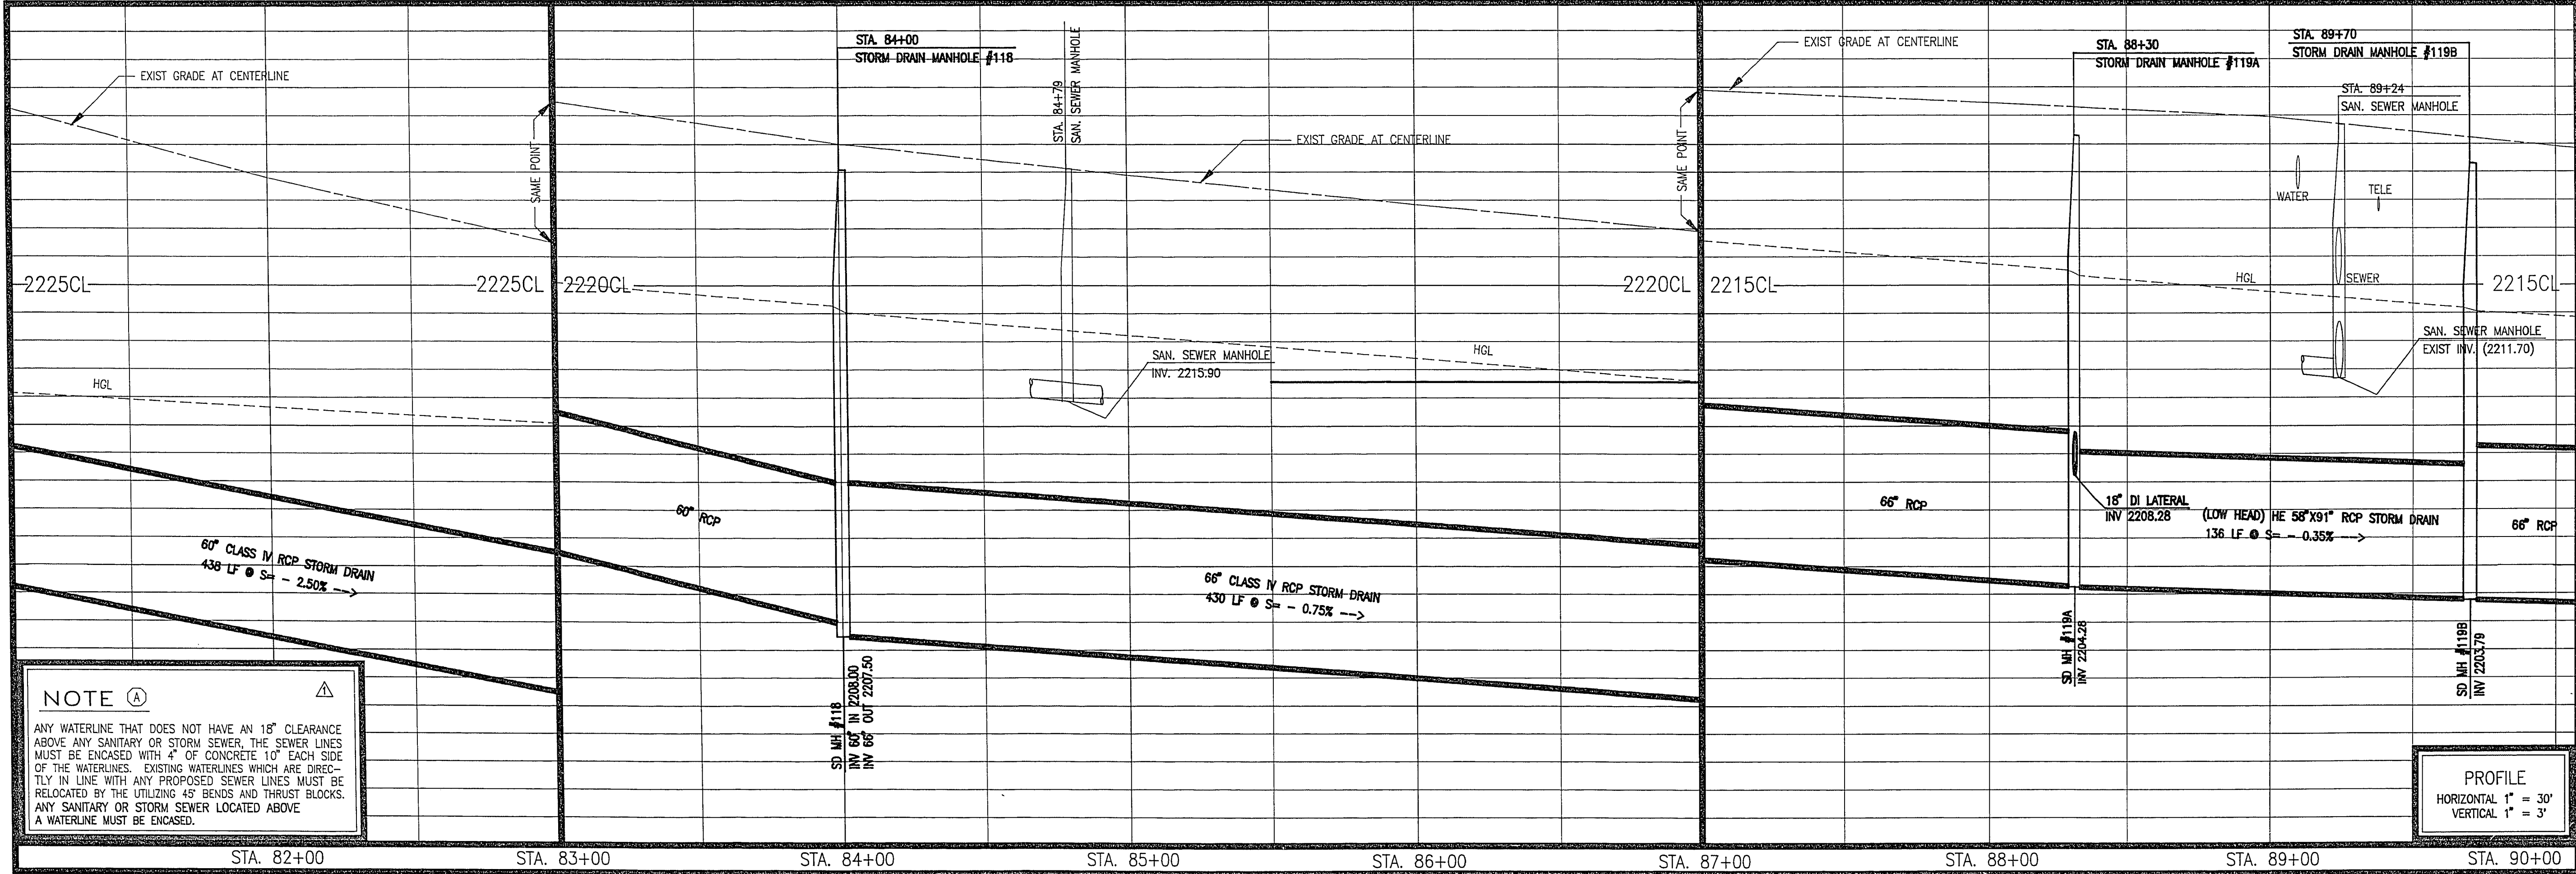



MATCHLINE AT STATION 81+07.77 SEE SHEET C5.9

MATCHLINE AT STATION 90+07.77 SEE SHEET C5.11

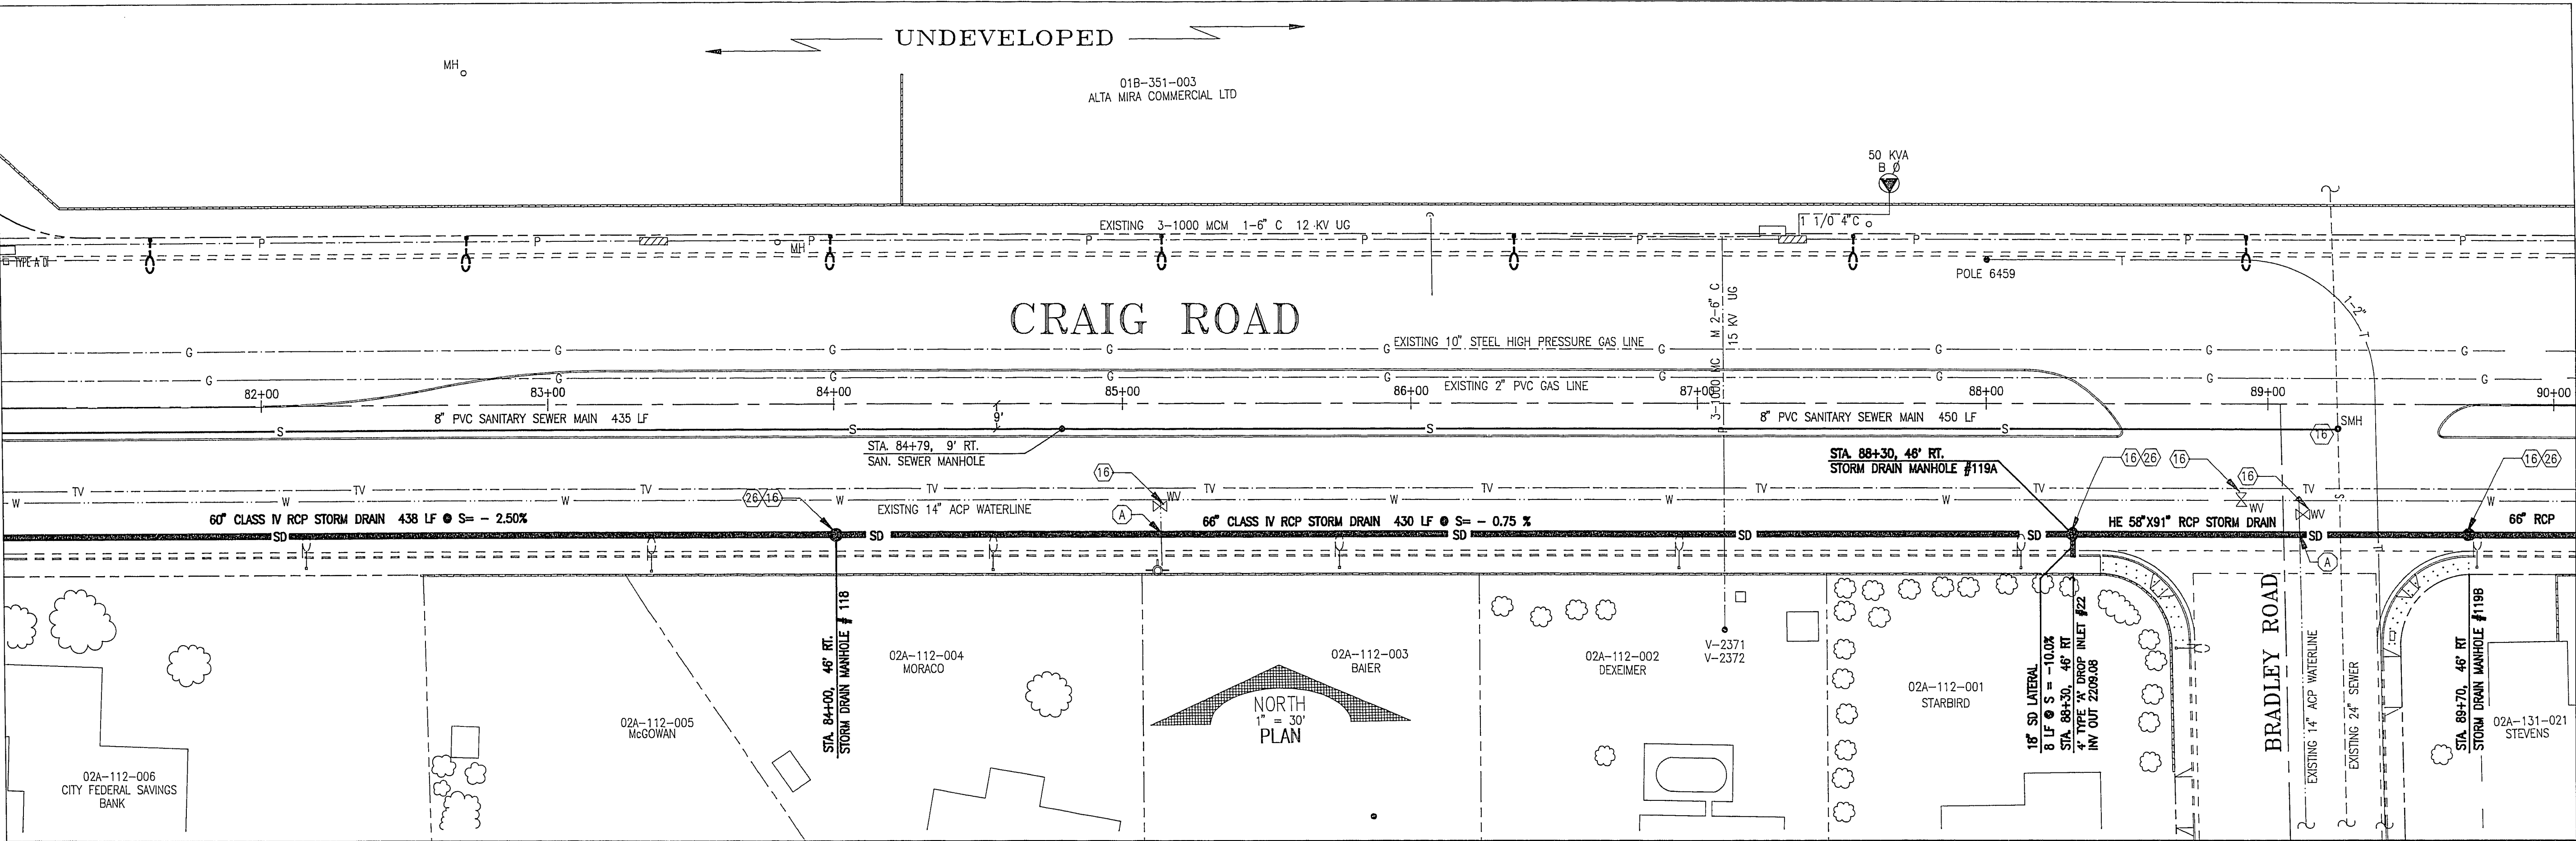

REVISIONS PERFORMED TO EXISTING DRAWINGS BY THE CITY OF LAS VEGAS ENGINEERING DIVISION
ORIGINAL HEFNER ENGINEERING DESIGN DRAWINGS ON FILE AT THE CITY OF LAS VEGAS

REVISION	DATE	BY	DESCRIPTION
1	9/92	AS	CITY OF LAS VEGAS ENGINEERING DESIGN
2		AS	DRAINAGE DESIGN REVISED ALONG WITH VARIOUS OTHER MINOR REVISIONS
3	10 JUNE 1992	AS	ADD 8" PVC SEWER LINE, USE LOW HEAD PIPE, ADD 18" DI LATERAL

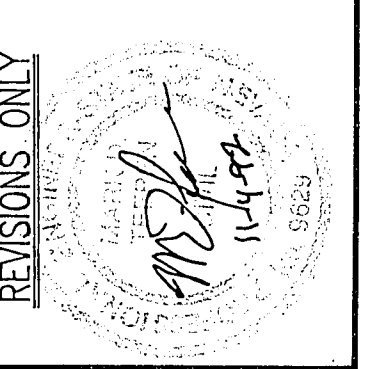

HEFNER ENGINEERING
CIVIL ENGINEERING DESIGN
LAND PLANNING & DEVELOPMENT
4441 South Polaris Avenue, Las Vegas, Nevada 89103
Phone: (702) 798-1900

CRAIG ROAD
UTILITY PLAN AND PROFILE
STATION 81+07.77 TO STATION 90+07.77

SHEET NO.
C5.10.1
107-V1804
J89042P1 DATE: 11/25/91